





# HORIZONTAL ACOUSTICAL PANELS

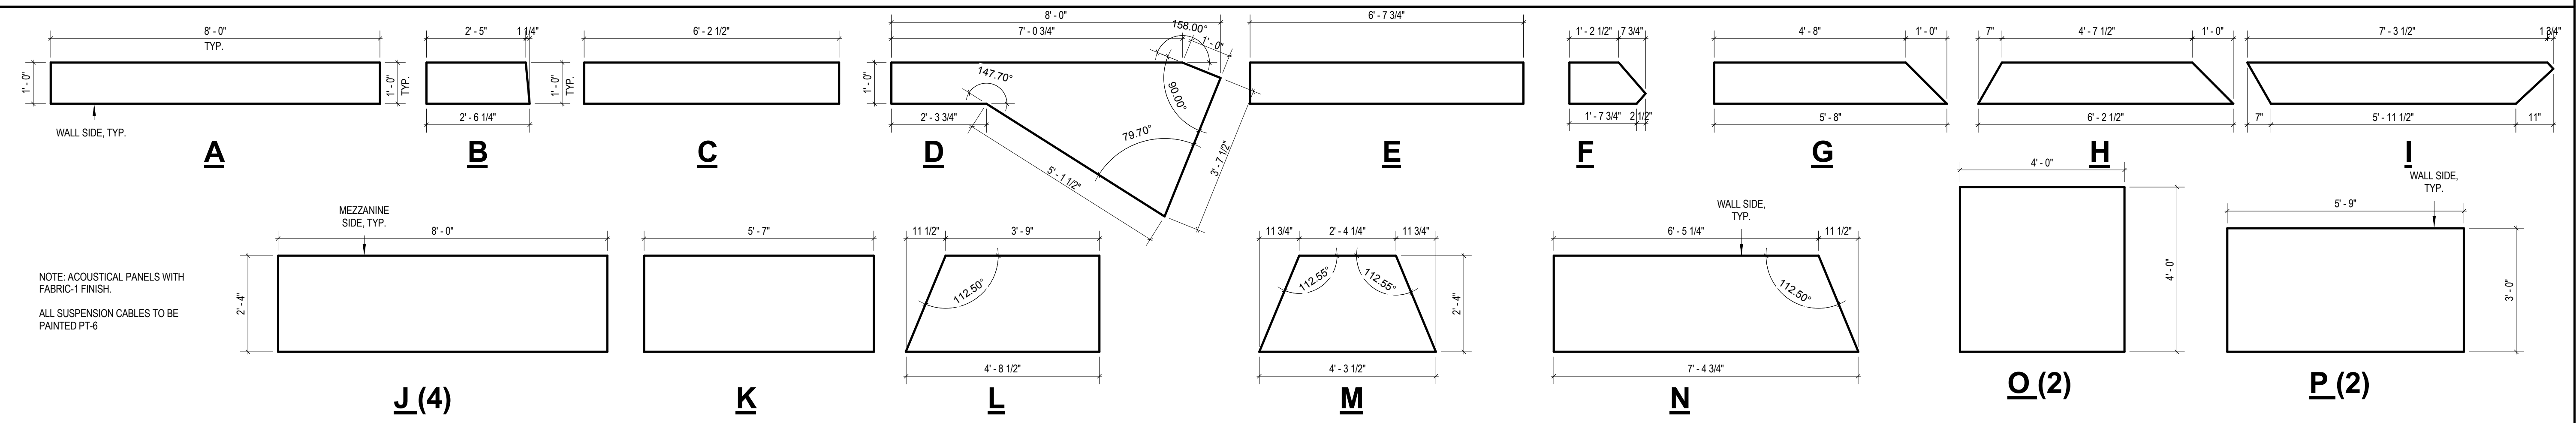

# SLOPED ACOUSTICAL PANELS

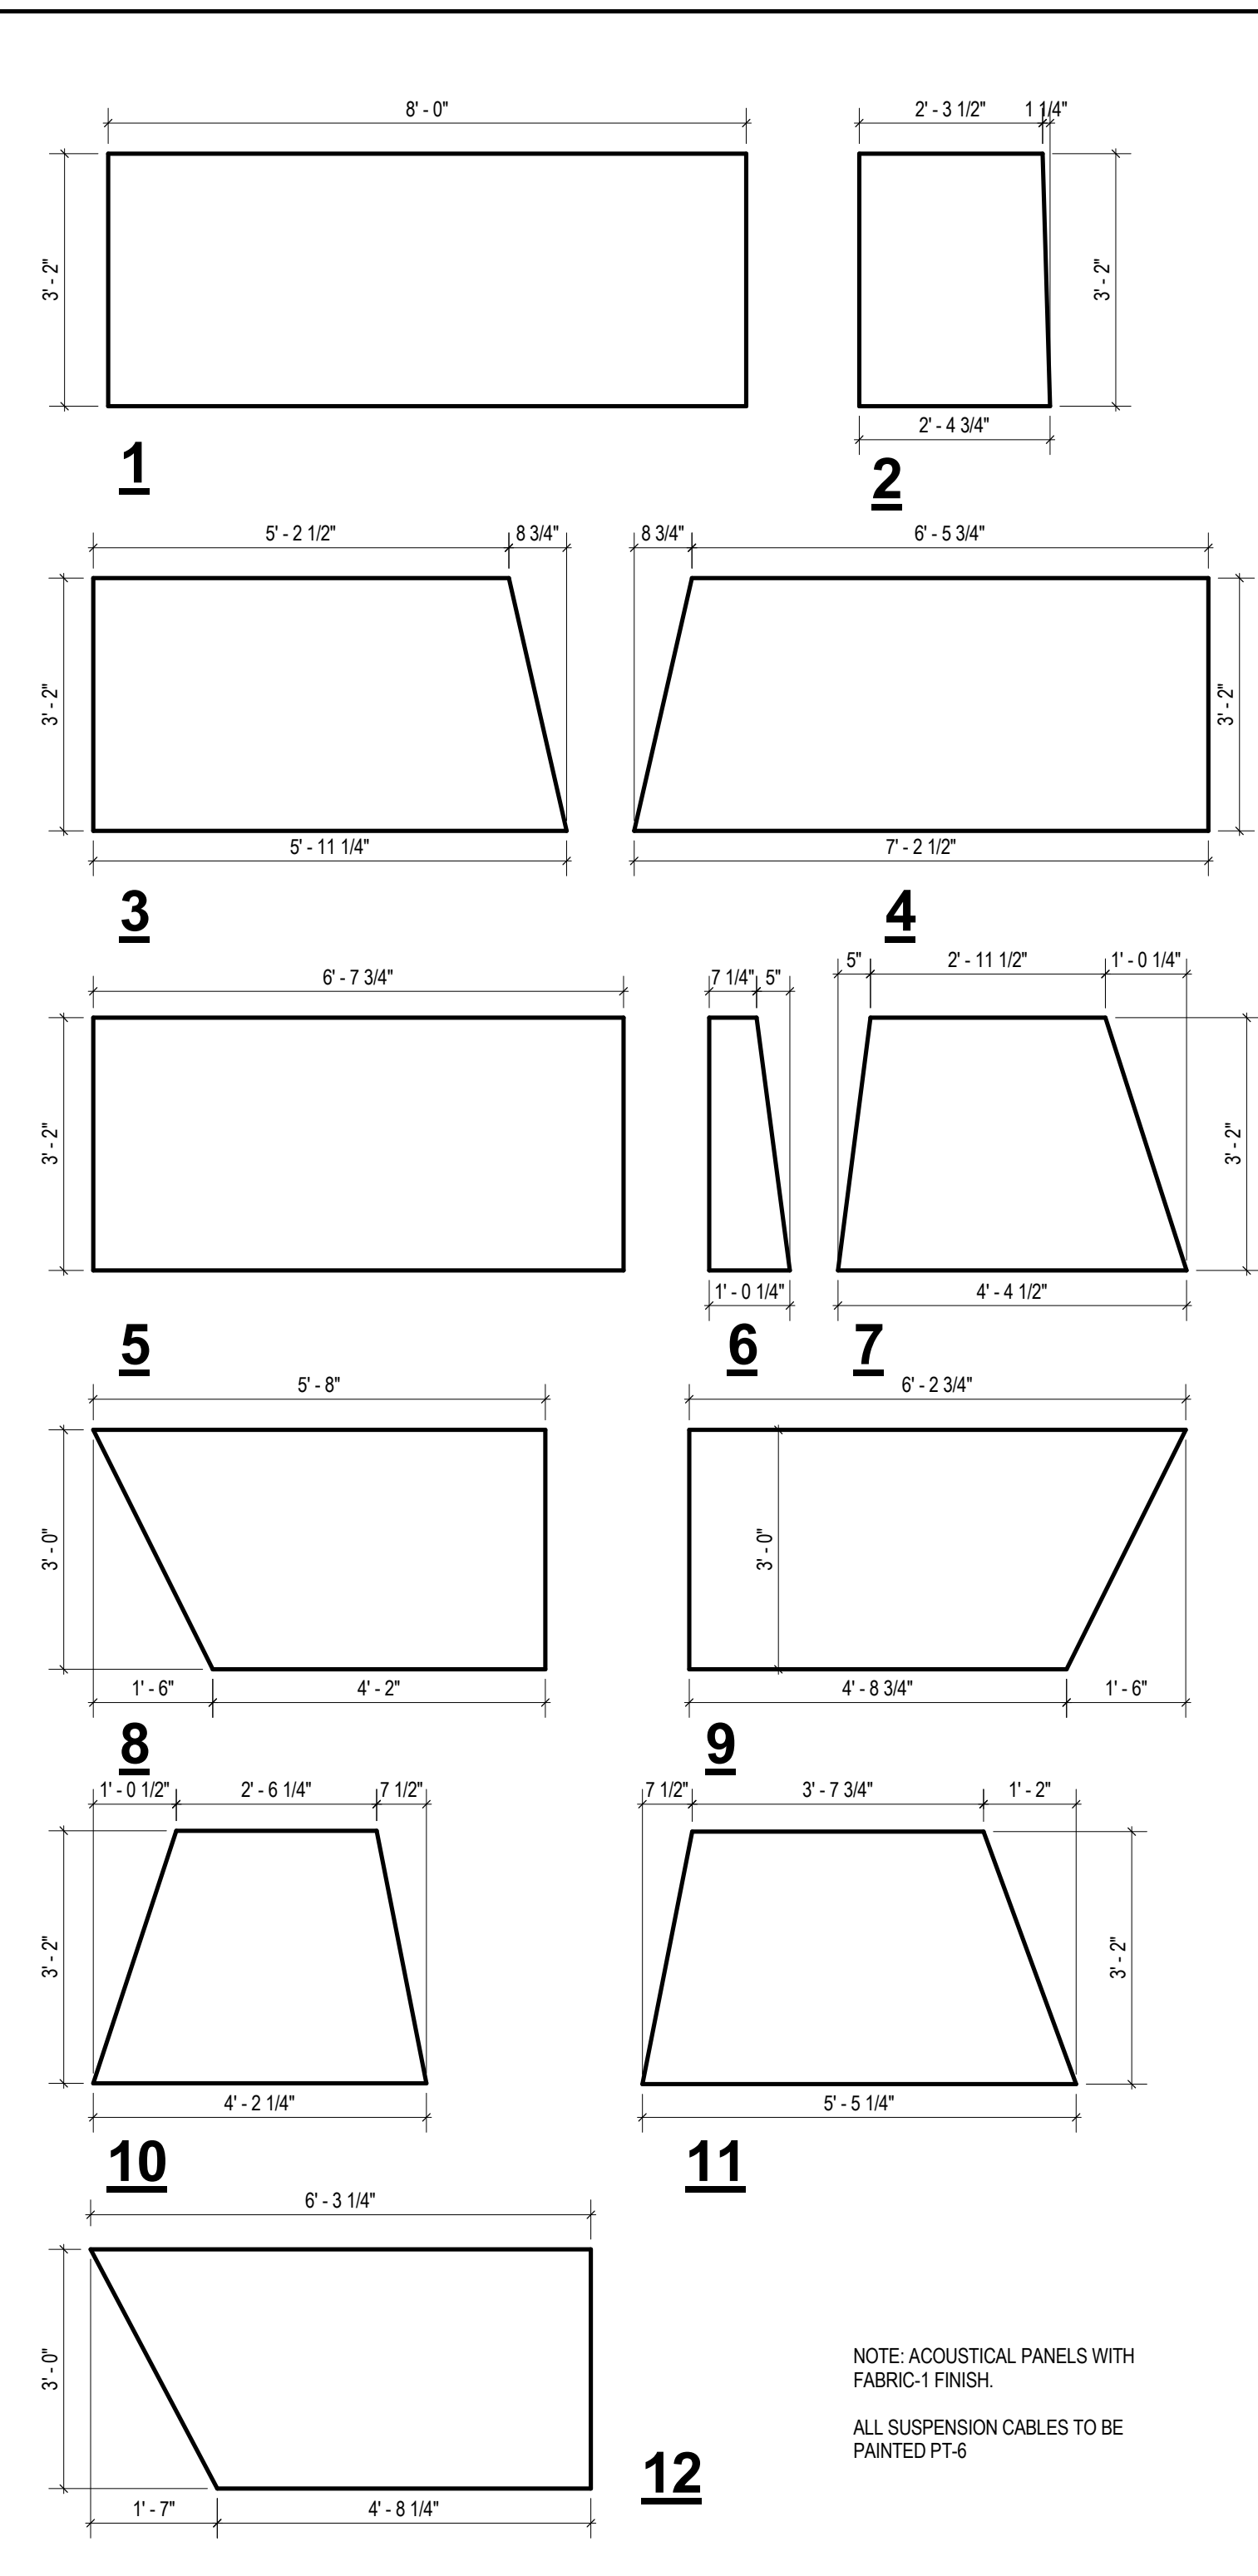

# MEZZANINE HORIZONTAL ACOUSTICAL PANELS

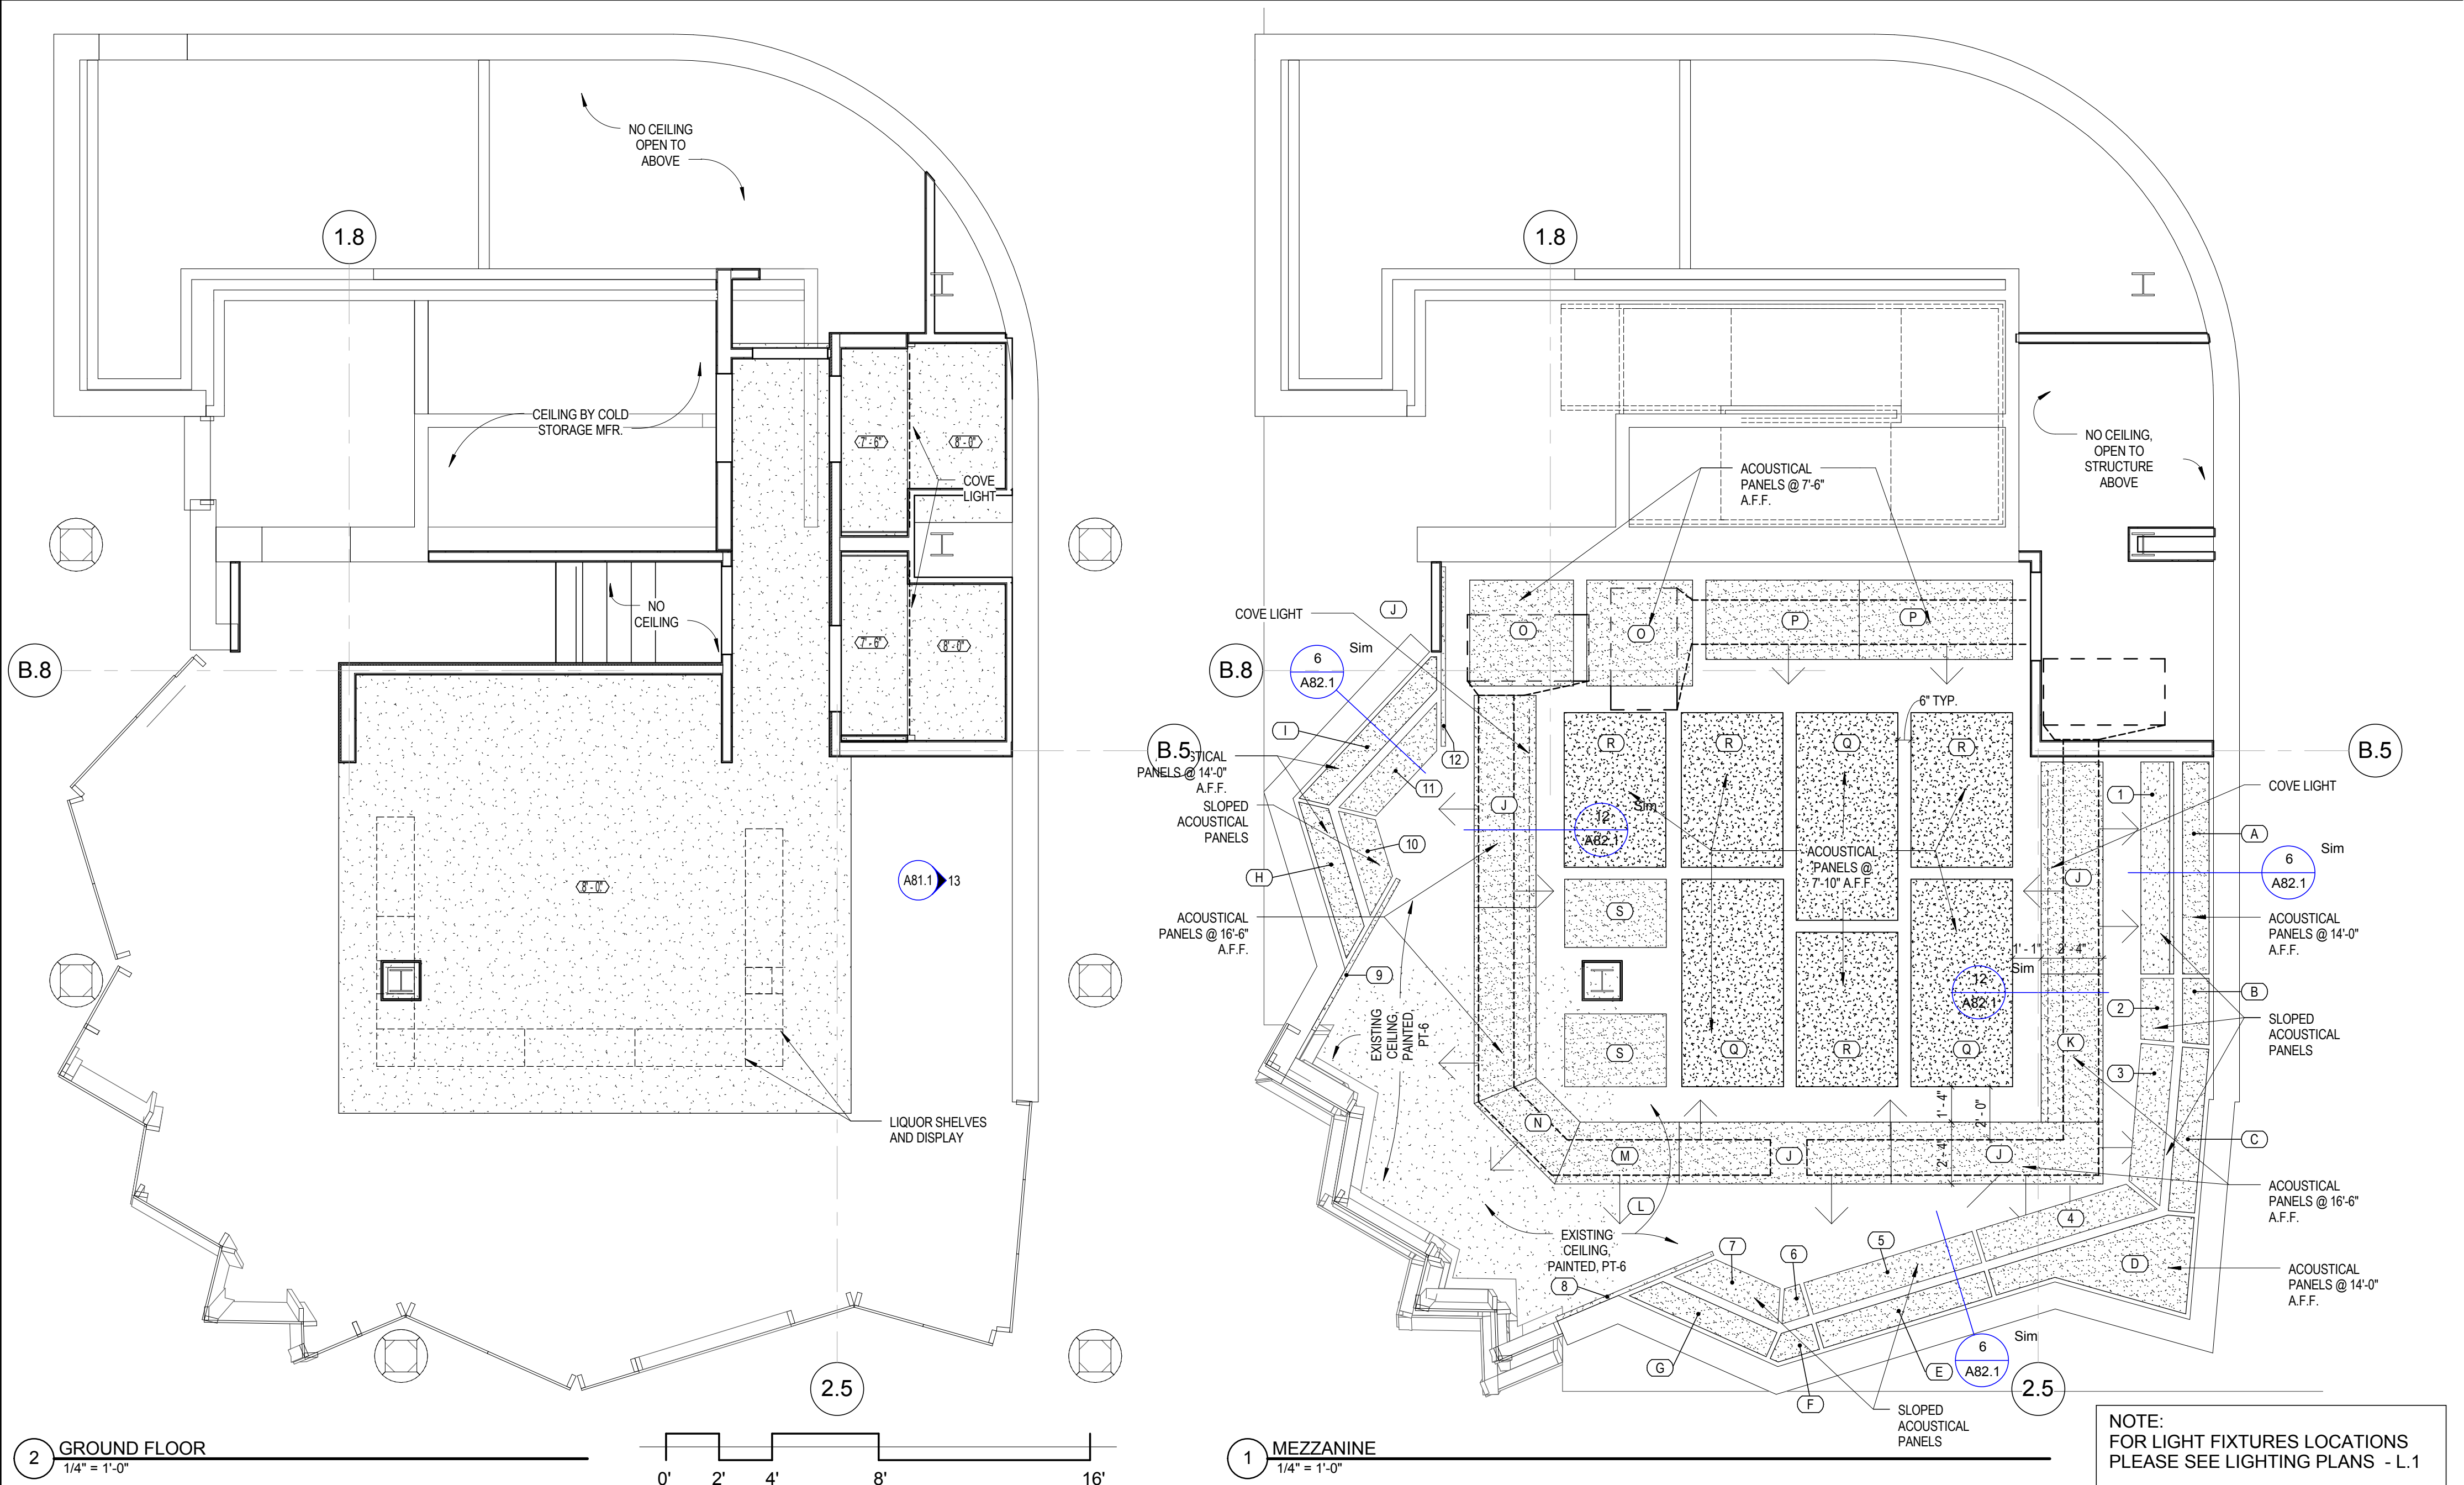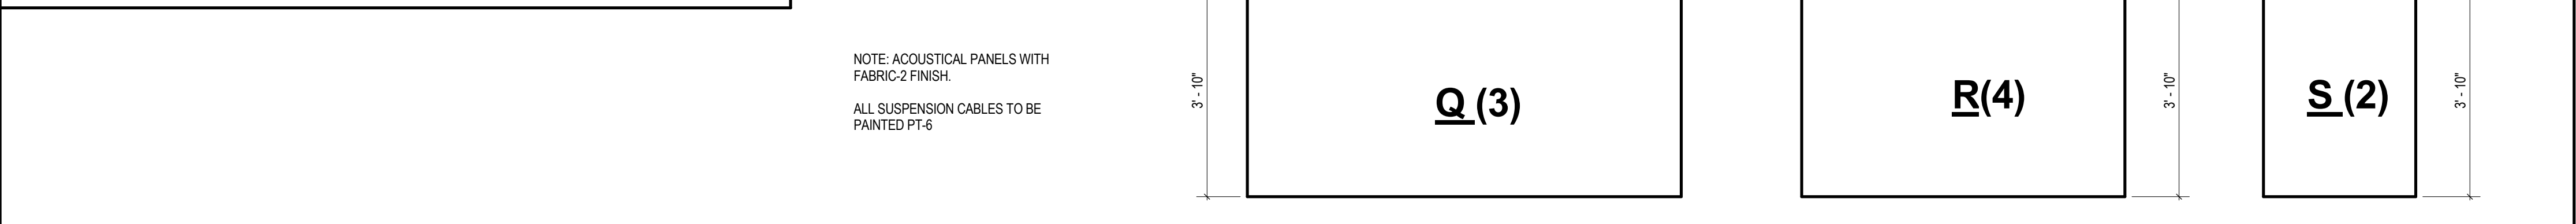

GENERAL NOTES:  
SEE DRAWING L.1 FOR LIGHTING PLANS

THIS DRAWING IS THE PROPERTY OF CANAL 5 STUDIO AND IS NOT TO BE COPIED OR REPRODUCED IN PART OR WHOLE. 2014 © CANAL 5 STUDIO

| Mark | Date | Description |
|------|------|-------------|
|      |      |             |
|      |      |             |
|      |      |             |
|      |      |             |

ISSUED FOR PERMIT  
DECEMBER 05, 2014

Drawing Title  
**Reflected Ceiling Plans**

Scale: As indicated

Drawing Number  
**A70.1**