



FIXTURE SCHEDULE

A	Track mounted, 120V, 10° GU10 2700K LED MR16 Track fixture; 1/4 cc warning lense and linear lens; silver finish	Soraa MR16-50-B03-120-927-10	Jesco Lighting H-HV240-SC	10
B	Surface mounted, 120V 2700K LED, cove and liquor shelf adhesive tape light; mounting clips; wet location.	Included with Fixture	Jesco Lighting DL-A-C-FLEX-27	4
C	Surface mounted, 120V 3' Fluorescent, cove light	TBD	TBD	0
D1	Recessed, 120V, 10° GU10 2700K LED MR16 Track fixture; 1/4 CCT warning lense and linear lens; white finish	Soraa MR16-50-B03-120-927-10	Jesco Lighting RS3000B + TM302-WHWH	10
T	Pendant mounted with threaded rod, 120V 2' Track; silver.	N/A	Jesco Lighting HTR2-S	20amp
T1	Pendant mounted with threaded rod, 120V 4' Track; silver.	N/A	Jesco Lighting HTR4-S	20amp
T2	Pendant mounted with threaded rod, 120V 6' Track; silver.	N/A	Jesco Lighting HTR6-S	20amp
T3	Pendant mounted with threaded rod, 120V 8' Track; silver.	N/A	Jesco Lighting HTR8-S	20amp


FOR PRICING ONLY

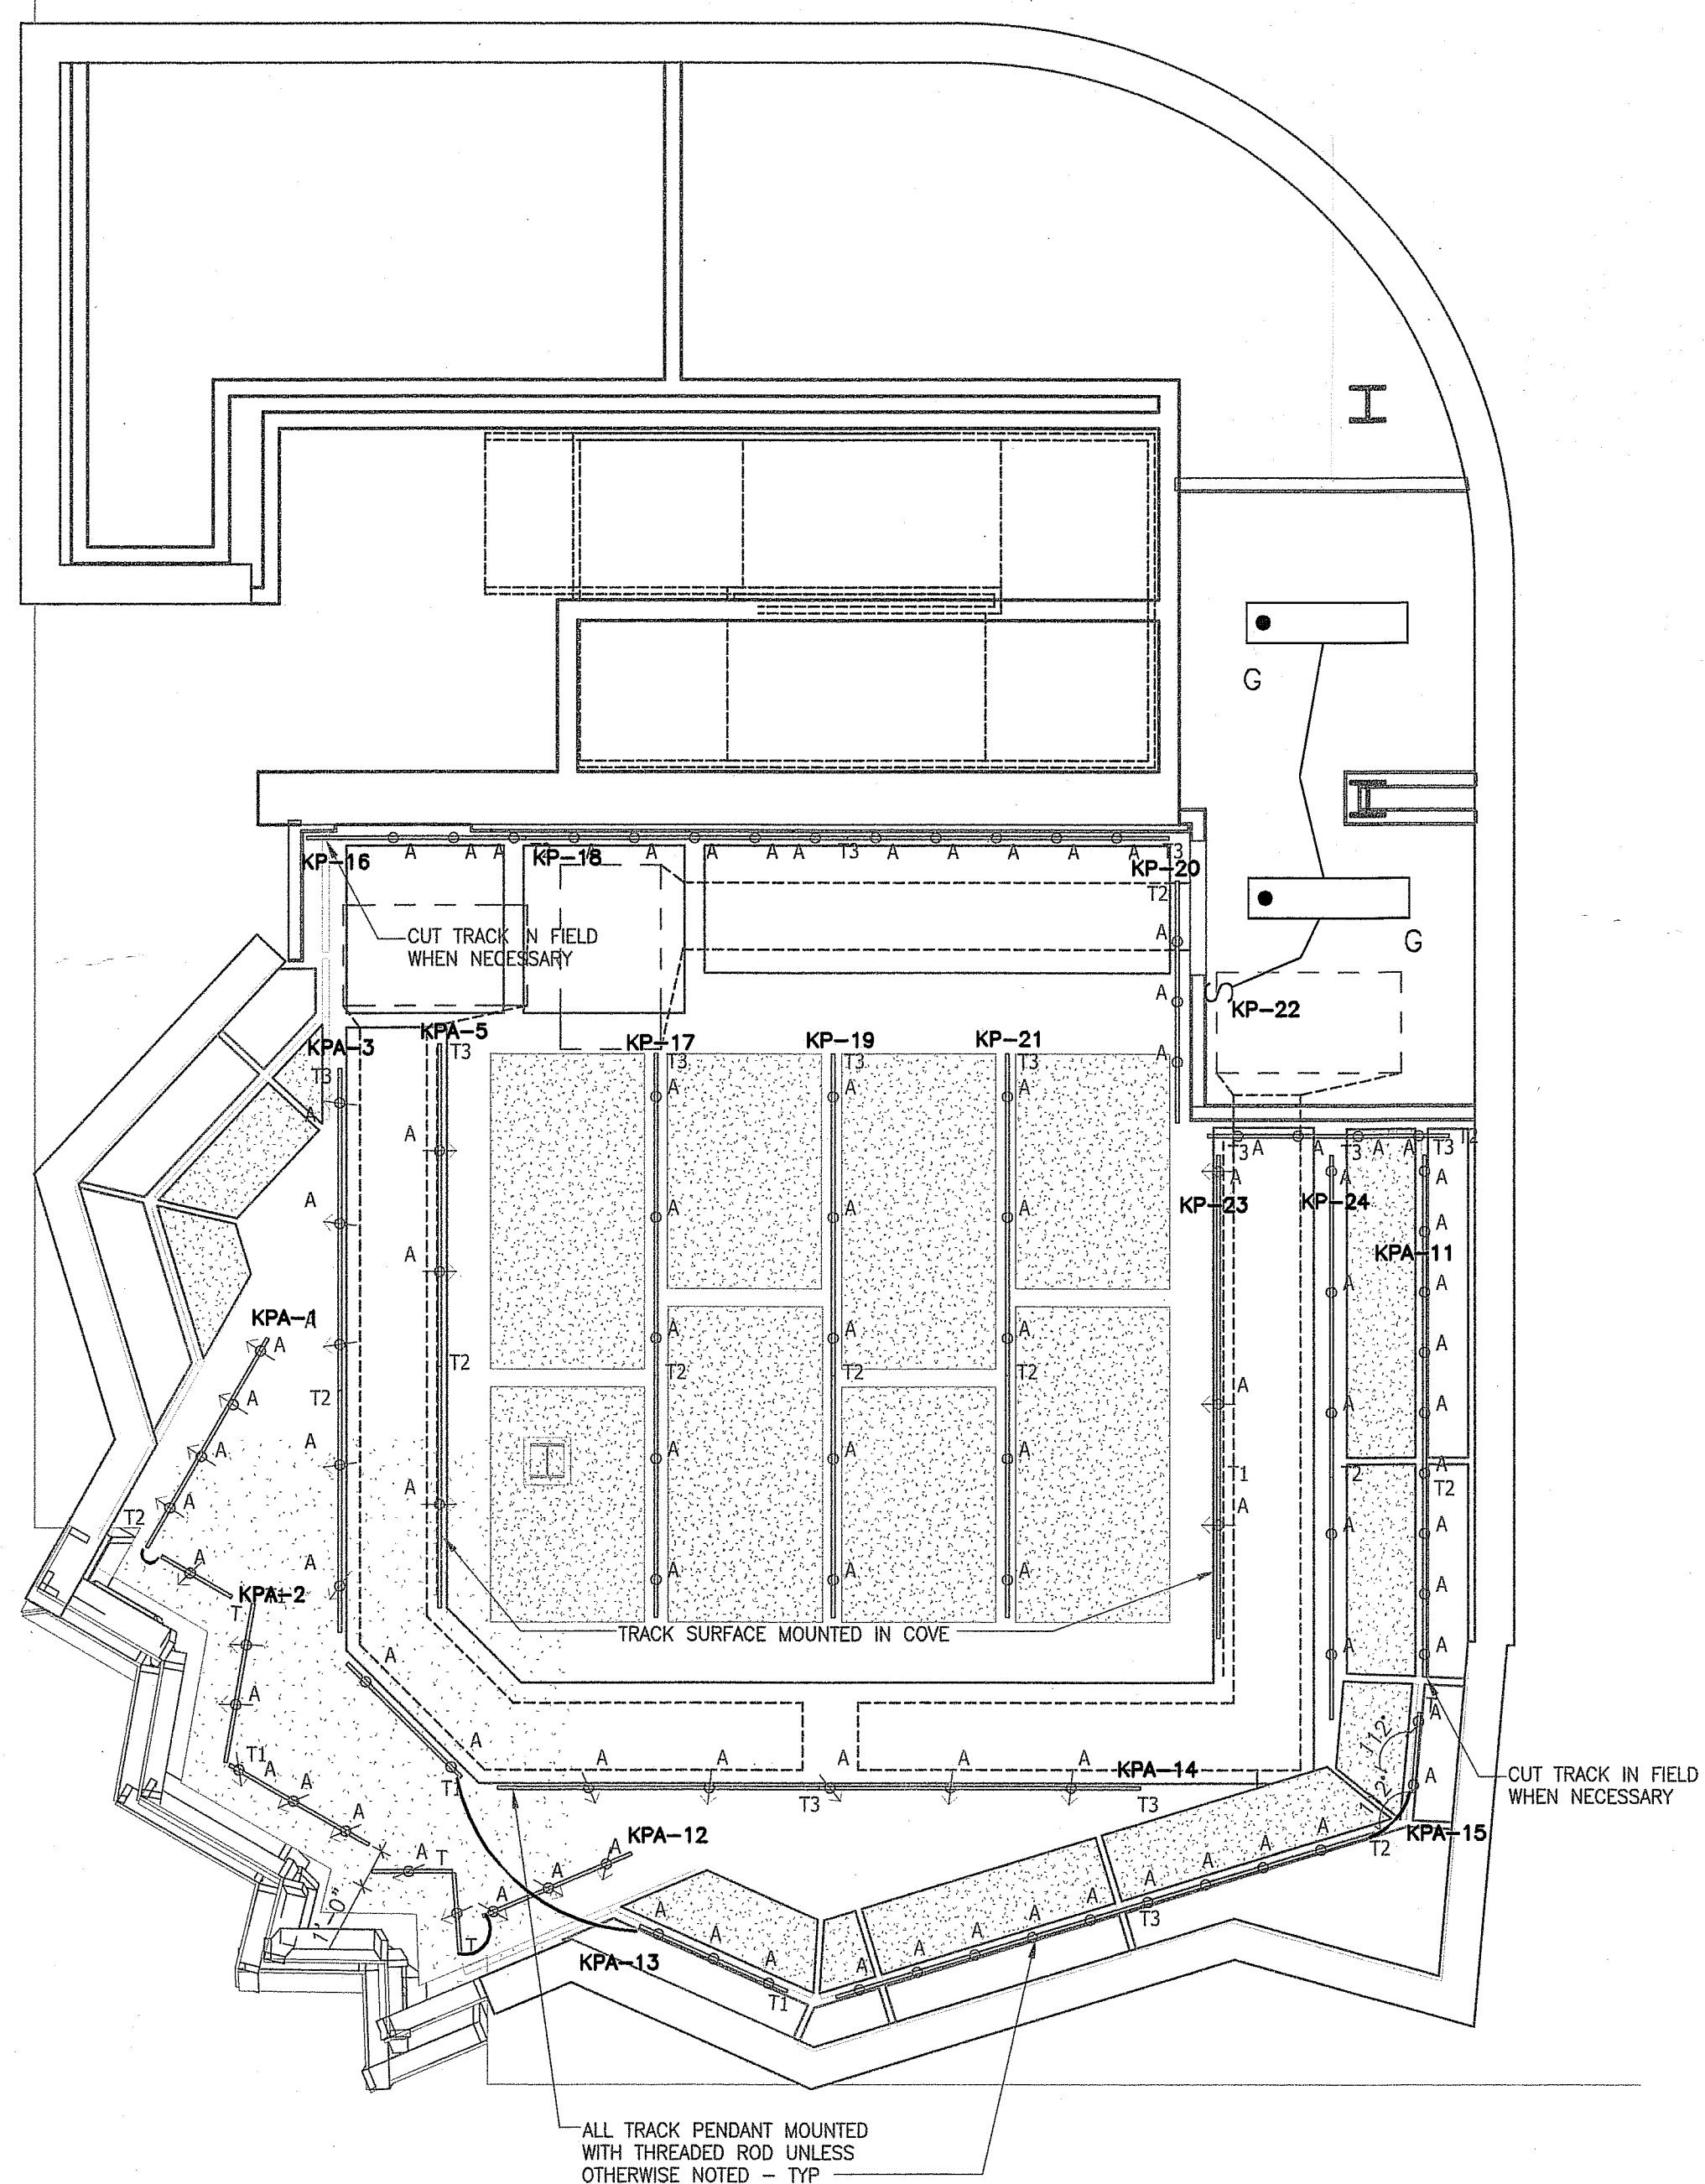

2 MEZZANINE LIGHTING PLAN
Scale: 1/4"=1'0"

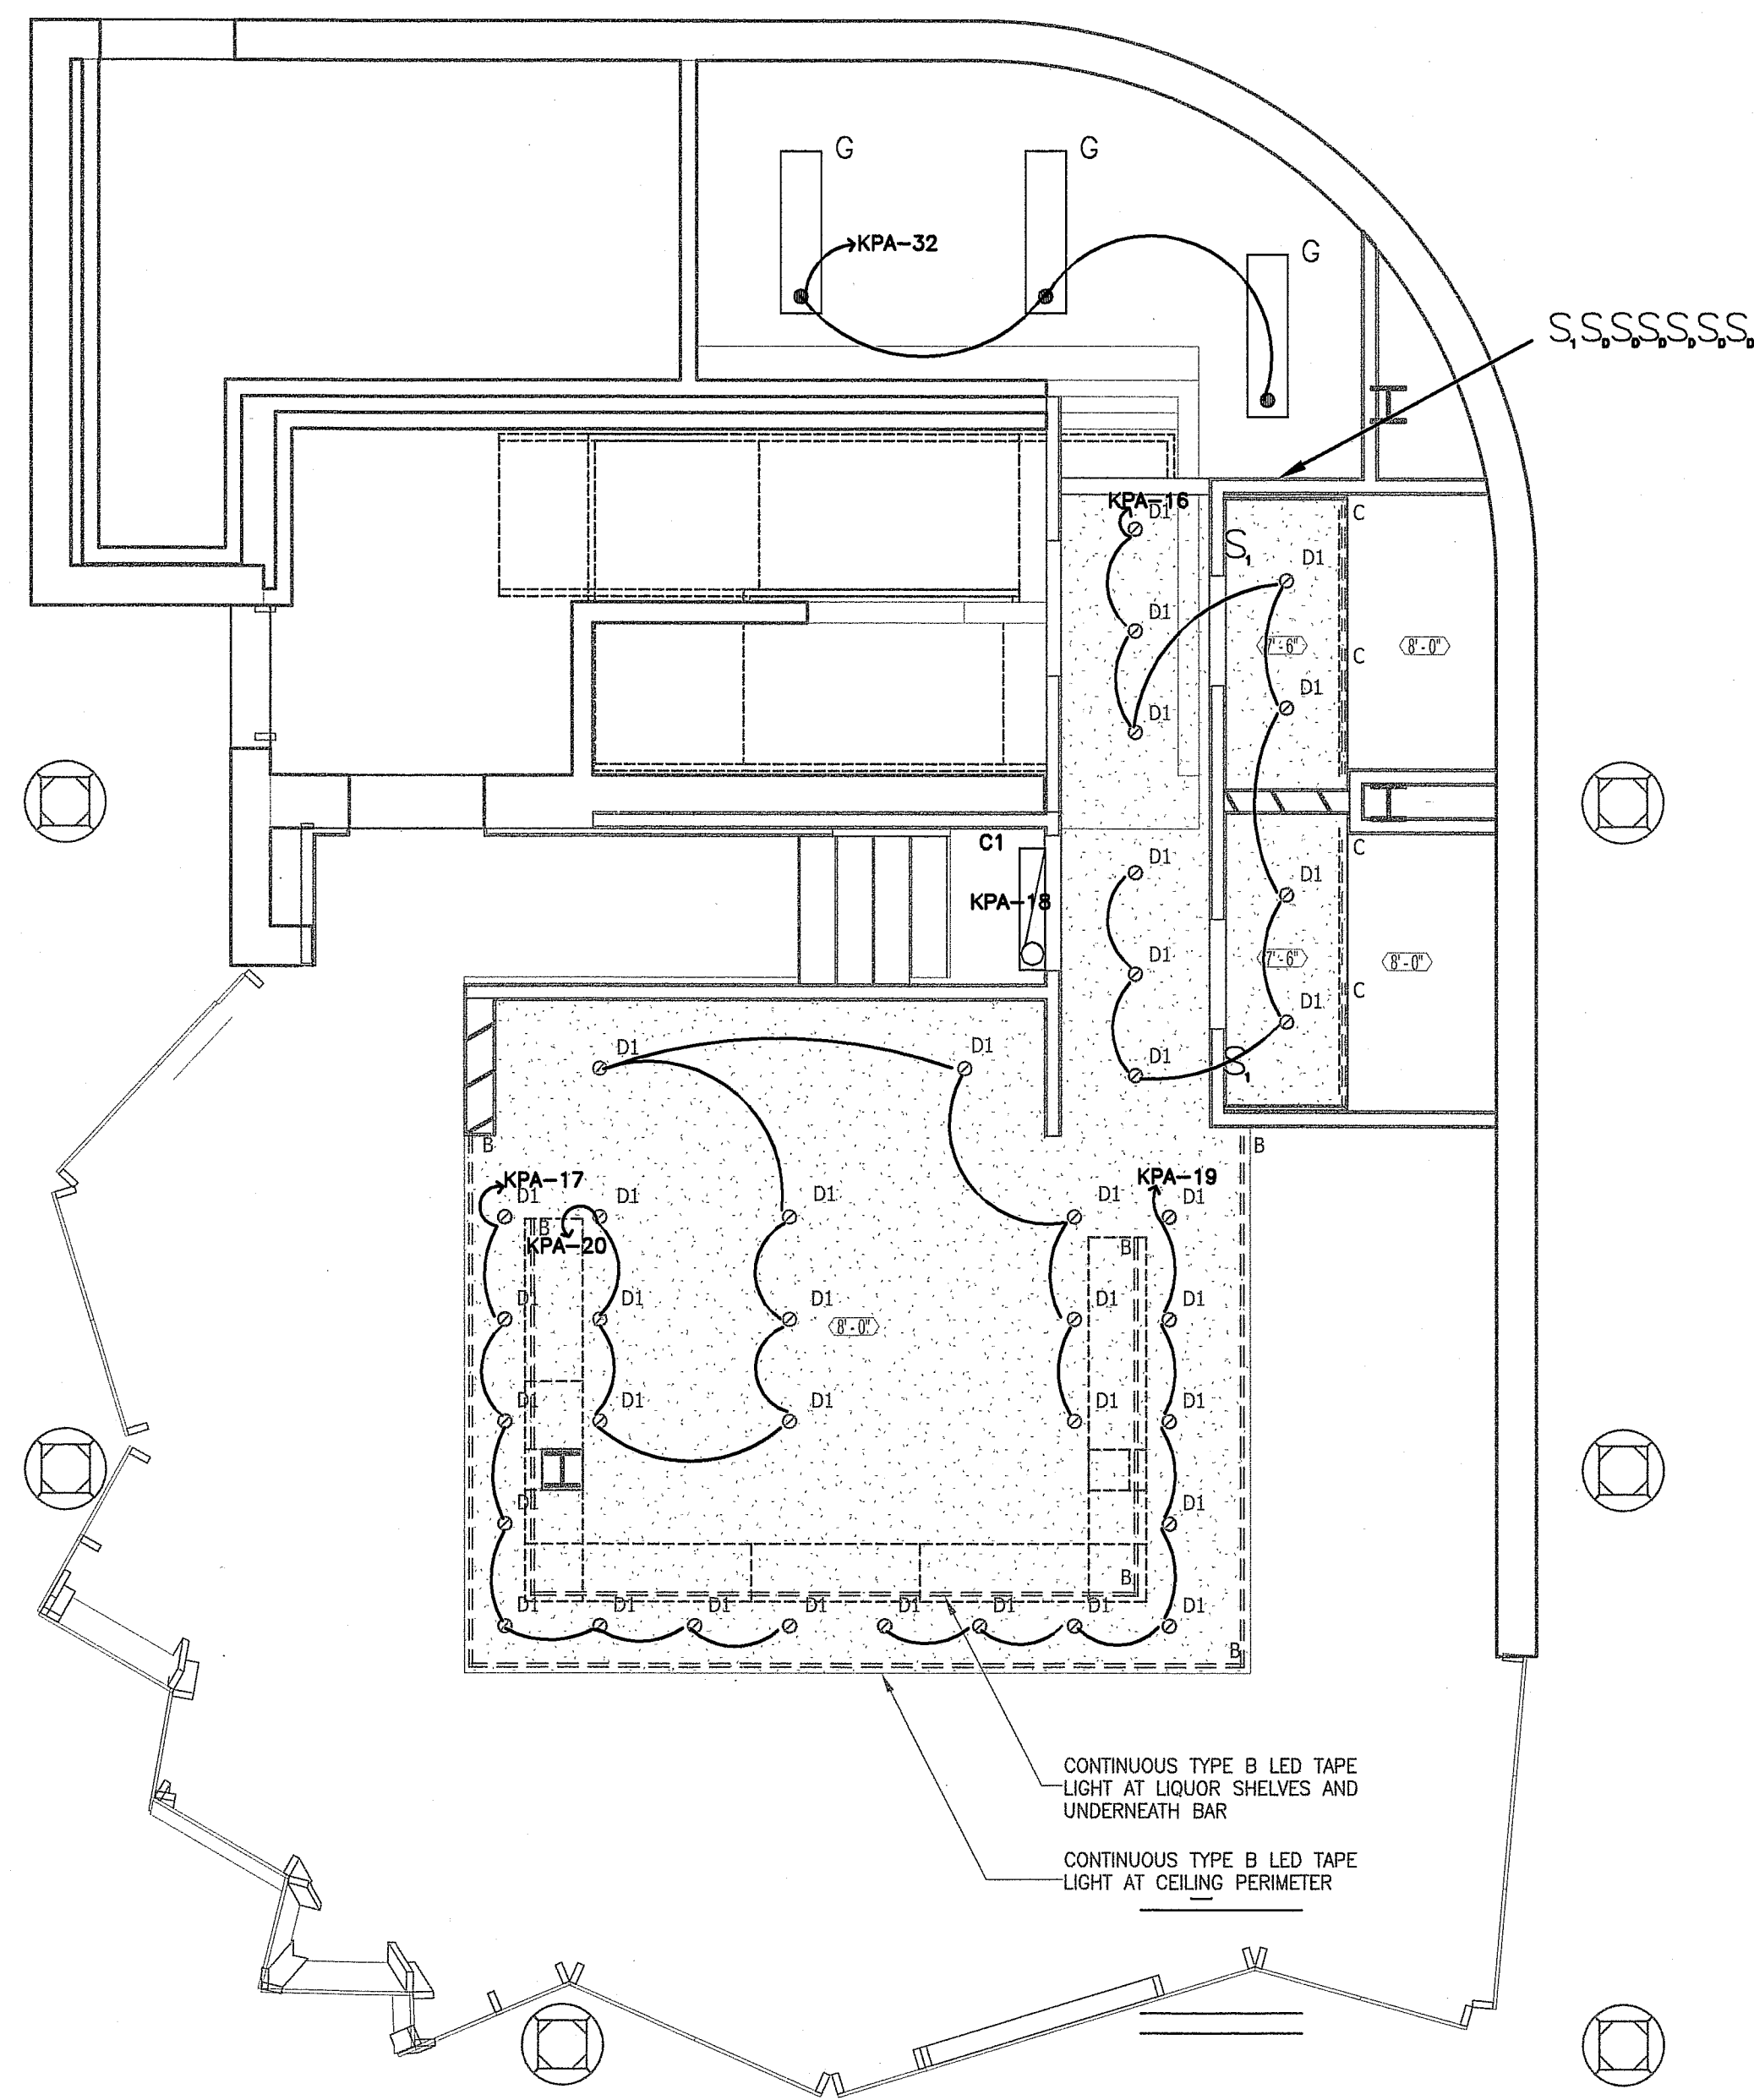

1 BASEMENT LIGHTING PLAN
Scale: 1/4"=1'0"

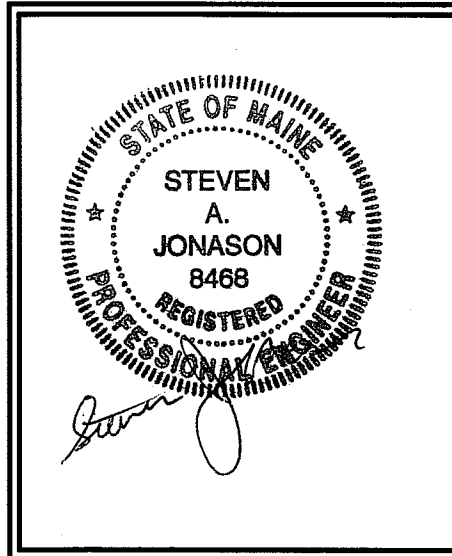

BH Milliken
ELECTRICAL CONTRACTORS
175 ANDERSON STREET
PORTLAND, MAINE 04101
PHONE 879-1877
FAX: 774-1492

443 Fore St,
443 FORE ST.
PORTLAND, ME.

TITLE
LIGHTING
REVISION 1 - 12-3-14
SCALE: 1/4"=1'
DATE: 11-20-14
SHEET

E300