

CONDENSER SCHEDULE											
TAG	UNIT SERVED	GENERAL					CONDENSER FAN(S)				REMARKS
		AMBIENT	NOM. TONS	SEER	MCA	ELECTRIC	QUAN	KW	R.L.A.	MCA	
CU-R1	SAC-R1	92	3	14.2	25	208/60/1	1	5.06	12.0	28A	EXISTING
CU-R2	SAC-R2	92	3	14.2	25	208/60/1	1	5.06	12.0	28A	EXISTING
CU-R3	SAC-R3	92	3	14.2	25	208/60/1	1	5.06	12.0	28A	EXISTING

VARIABLE REFRIGERANT FLOW UNIT SCHEDULE												
TAG	SERVES	V/PHHZ	F.L.A.	CFM	COOLING BTU/H	HEATING BTU/H	DIMENSIONS			CONFIGURATION	MODEL NO.	REMARKS
							WIDTH	HEIGHT	DEPTH			
SAC-R1	BAR AREA & MEZZANINE	208/60/1	2.0	1060	30,000	32,000	55 1/8"	9 7/8"	28 7/8"	HORIZONTAL DUCTED	PEAD-A36AA4	EXISTING
SAC-R2	KITCHEN, BATHROOMS & MEZZANINE	208/60/1	2.0	1060	30,000	32,000	55 1/8"	9 7/8"	28 7/8"	HORIZONTAL DUCTED	PEAD-A36AA4	EXISTING
SAC-R3	BAR AREA & MEZZANINE	208/60/1	2.0	1060	30,000	32,000	55 1/8"	9 7/8"	28 7/8"	HORIZONTAL DUCTED	PEAD-A36AA4	EXISTING

AIR CURTAIN SCHEDULE										
TAG	SERVES	TYPE	KW	V/PHHZ	WIDTH	HEIGHT	DEPTH	MANUFACTURER	MOD. NO.	REMARKS
AIR-R1	ENTRY DOOR	LO PRO 2	9.5/13	208/60/1	60"	8"	11-3/4"	MARS	LPV260-1E	OR EQUAL

DEHUMIDIFIER SCHEDULE										
TAG	SERVES	DIMENSIONS	EXTRACTION (PPD)	ELECTRIC	AMPS	TEMP. RANGE	FAN CFM	MODEL	REMARKS	
DH-R1	RESTAURANT	17'-1/2' x 27' x 26"	110	110V/60/1	9.2	33°F-95°F	491	EBAC PD120	R407C REFRIGERANT	

NOTES: NOT INCLUDED IN BASE BID.

GRILLES, REGISTERS, & DIFFUSER SCHEDULE						
TAG	NECK (INCHES)	FACE SIZE (INCHES)	CFM	SP (W.G.)	THROW (FEET)	REMARKS
SG-1	12x8	13-3/4"x9-3/4"	225	0.05	12'	LONG FRONT BLADES, 3/4" SPACING W/ DOUBLE DEFLECTION @ 45°
SG-2	10x6	11-3/4"x7-3/4"	150	0.05	17'	LONG FRONT BLADES, 3/4" SPACING W/ DOUBLE DEFLECTION @ 22.5°
SG-3	24x12	25-3/4"x13-3/4"	900	0.05	25'	LONG FRONT BLADES, 3/4" SPACING W/ DOUBLE DEFLECTION @ 45°


NOTES: ALL GRIDS MAX NC=20
ALL UNITS SHALL BE TITUS OR EQUAL

NOTES:


- DEHUMIDIFIER NOT INCLUDED IN BASE BID PRICE. ALTERNATE PRICING TO BE PROVIDED UPON APPROVAL.

KEYED NOTES:

- EXISTING PATCHED OPENING IN WALL TO BE LOCATED BY OTHERS FOR MECHANICAL USE.
- EXHAUST FAN DUCTWORK TO TERMINATE IN CEILING SPACE ABOVE PORTE COCHERE.

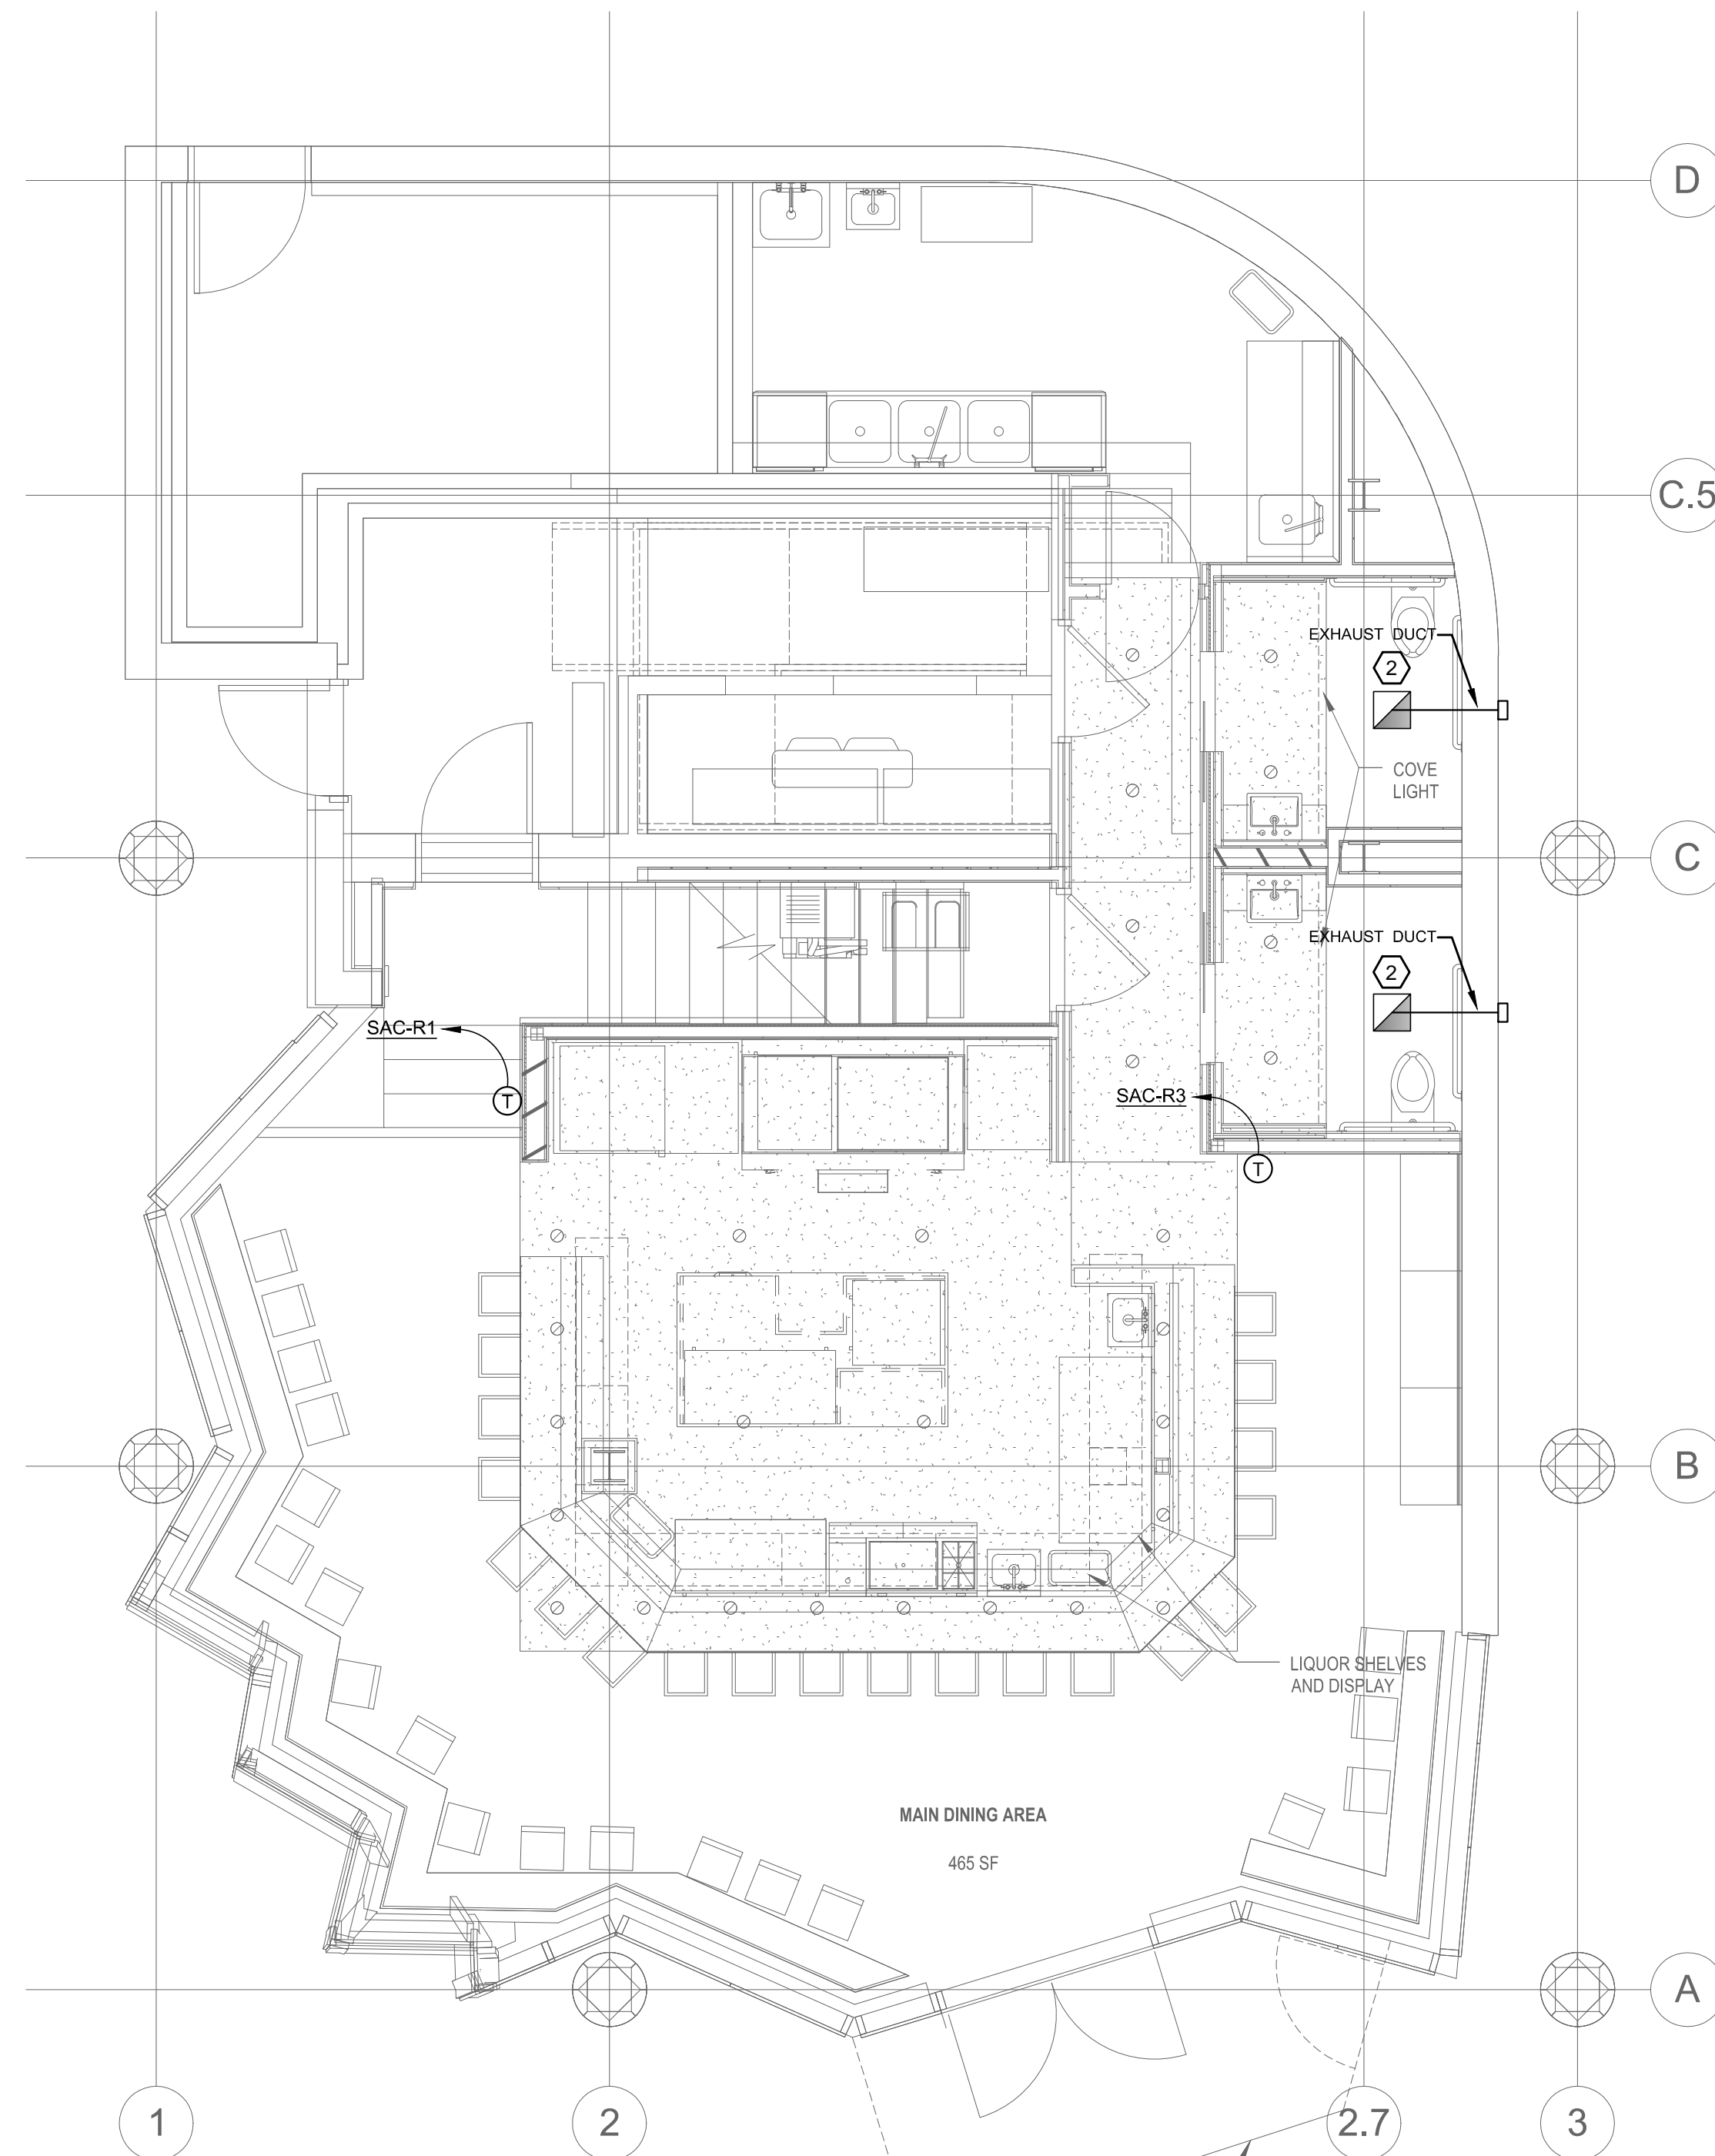

1 LOWER LEVEL - HVAC EQUIPMENT & DUCTWORK LAYOUT
SCALE: 1/4" = 1'-0"

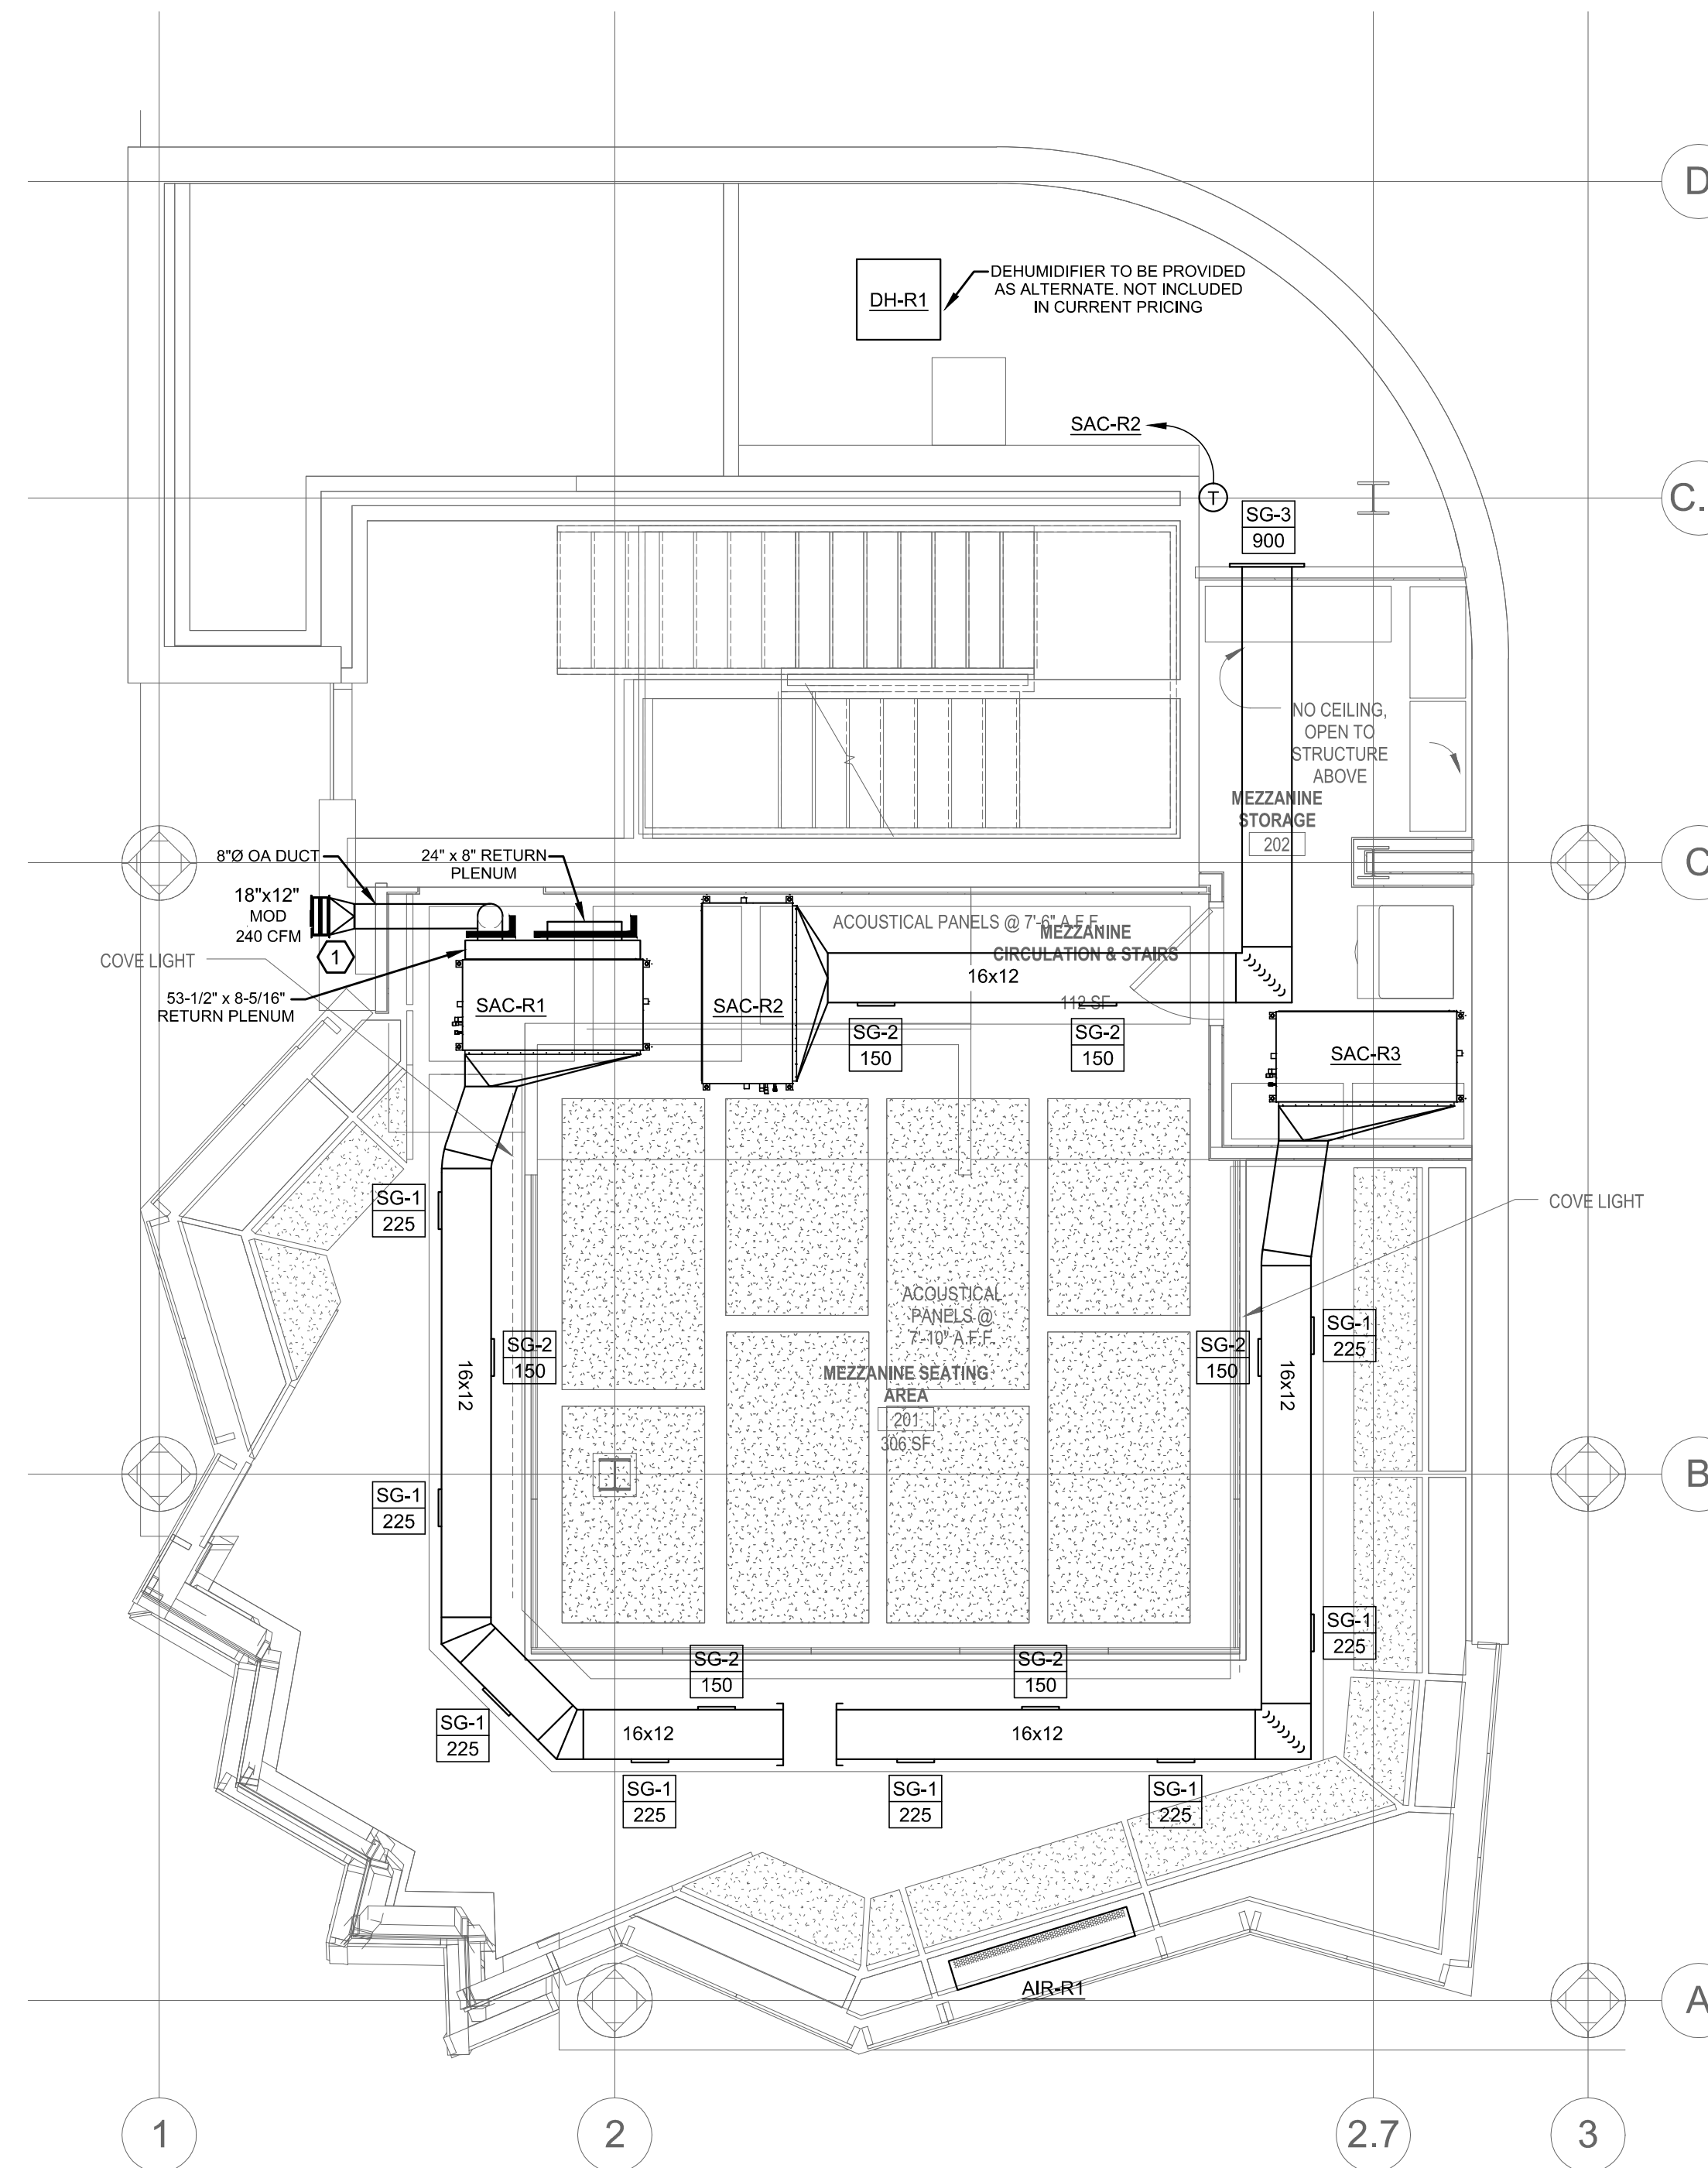


1 MEZZANINE - HVAC EQUIPMENT & DUCTWORK LAYOUT
SCALE: 1/4" = 1'-0"

This document is owned by, and the information contained in it is proprietary to Titan Mechanical, Inc. By receipt hereof the bidder agrees not to use the information disclosed to any third party, nor reproduce this document without the prior written consent of Titan Mechanical, Inc. and agrees to return this document forthwith upon request.

DATE	REVISIONS

Titan Mechanical, Inc.
Design Build Engineering - Mechanical Contracting
232 Riverside Industrial Parkway
Portland, Maine 04103
Ph. (207) 878-5223 Fax. (207) 878-5235

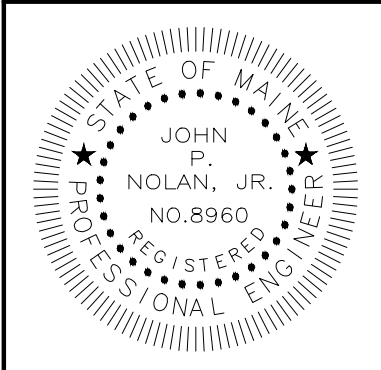

CANAL 5 STUDIO
CLIENT
443 FORE STREET RESTAURANT
PROJECT
HVAC EQUIPMENT & DUCTWORK PLAN
DRAWING TITLE

DATE: 11.11.2014
SCALE: AS NOTED
DRAWN BY: KLM
CHECKED BY: JPN
ISSUED FOR:
CONSTRUCTION
12.05.2014

SHEET NUMBER
M1.0
SHEET 3 OF 3