


1 LOWER LEVEL - PLUMBING DRAINAGE LAYOUT
SCALE: 1/4" = 1'-0"

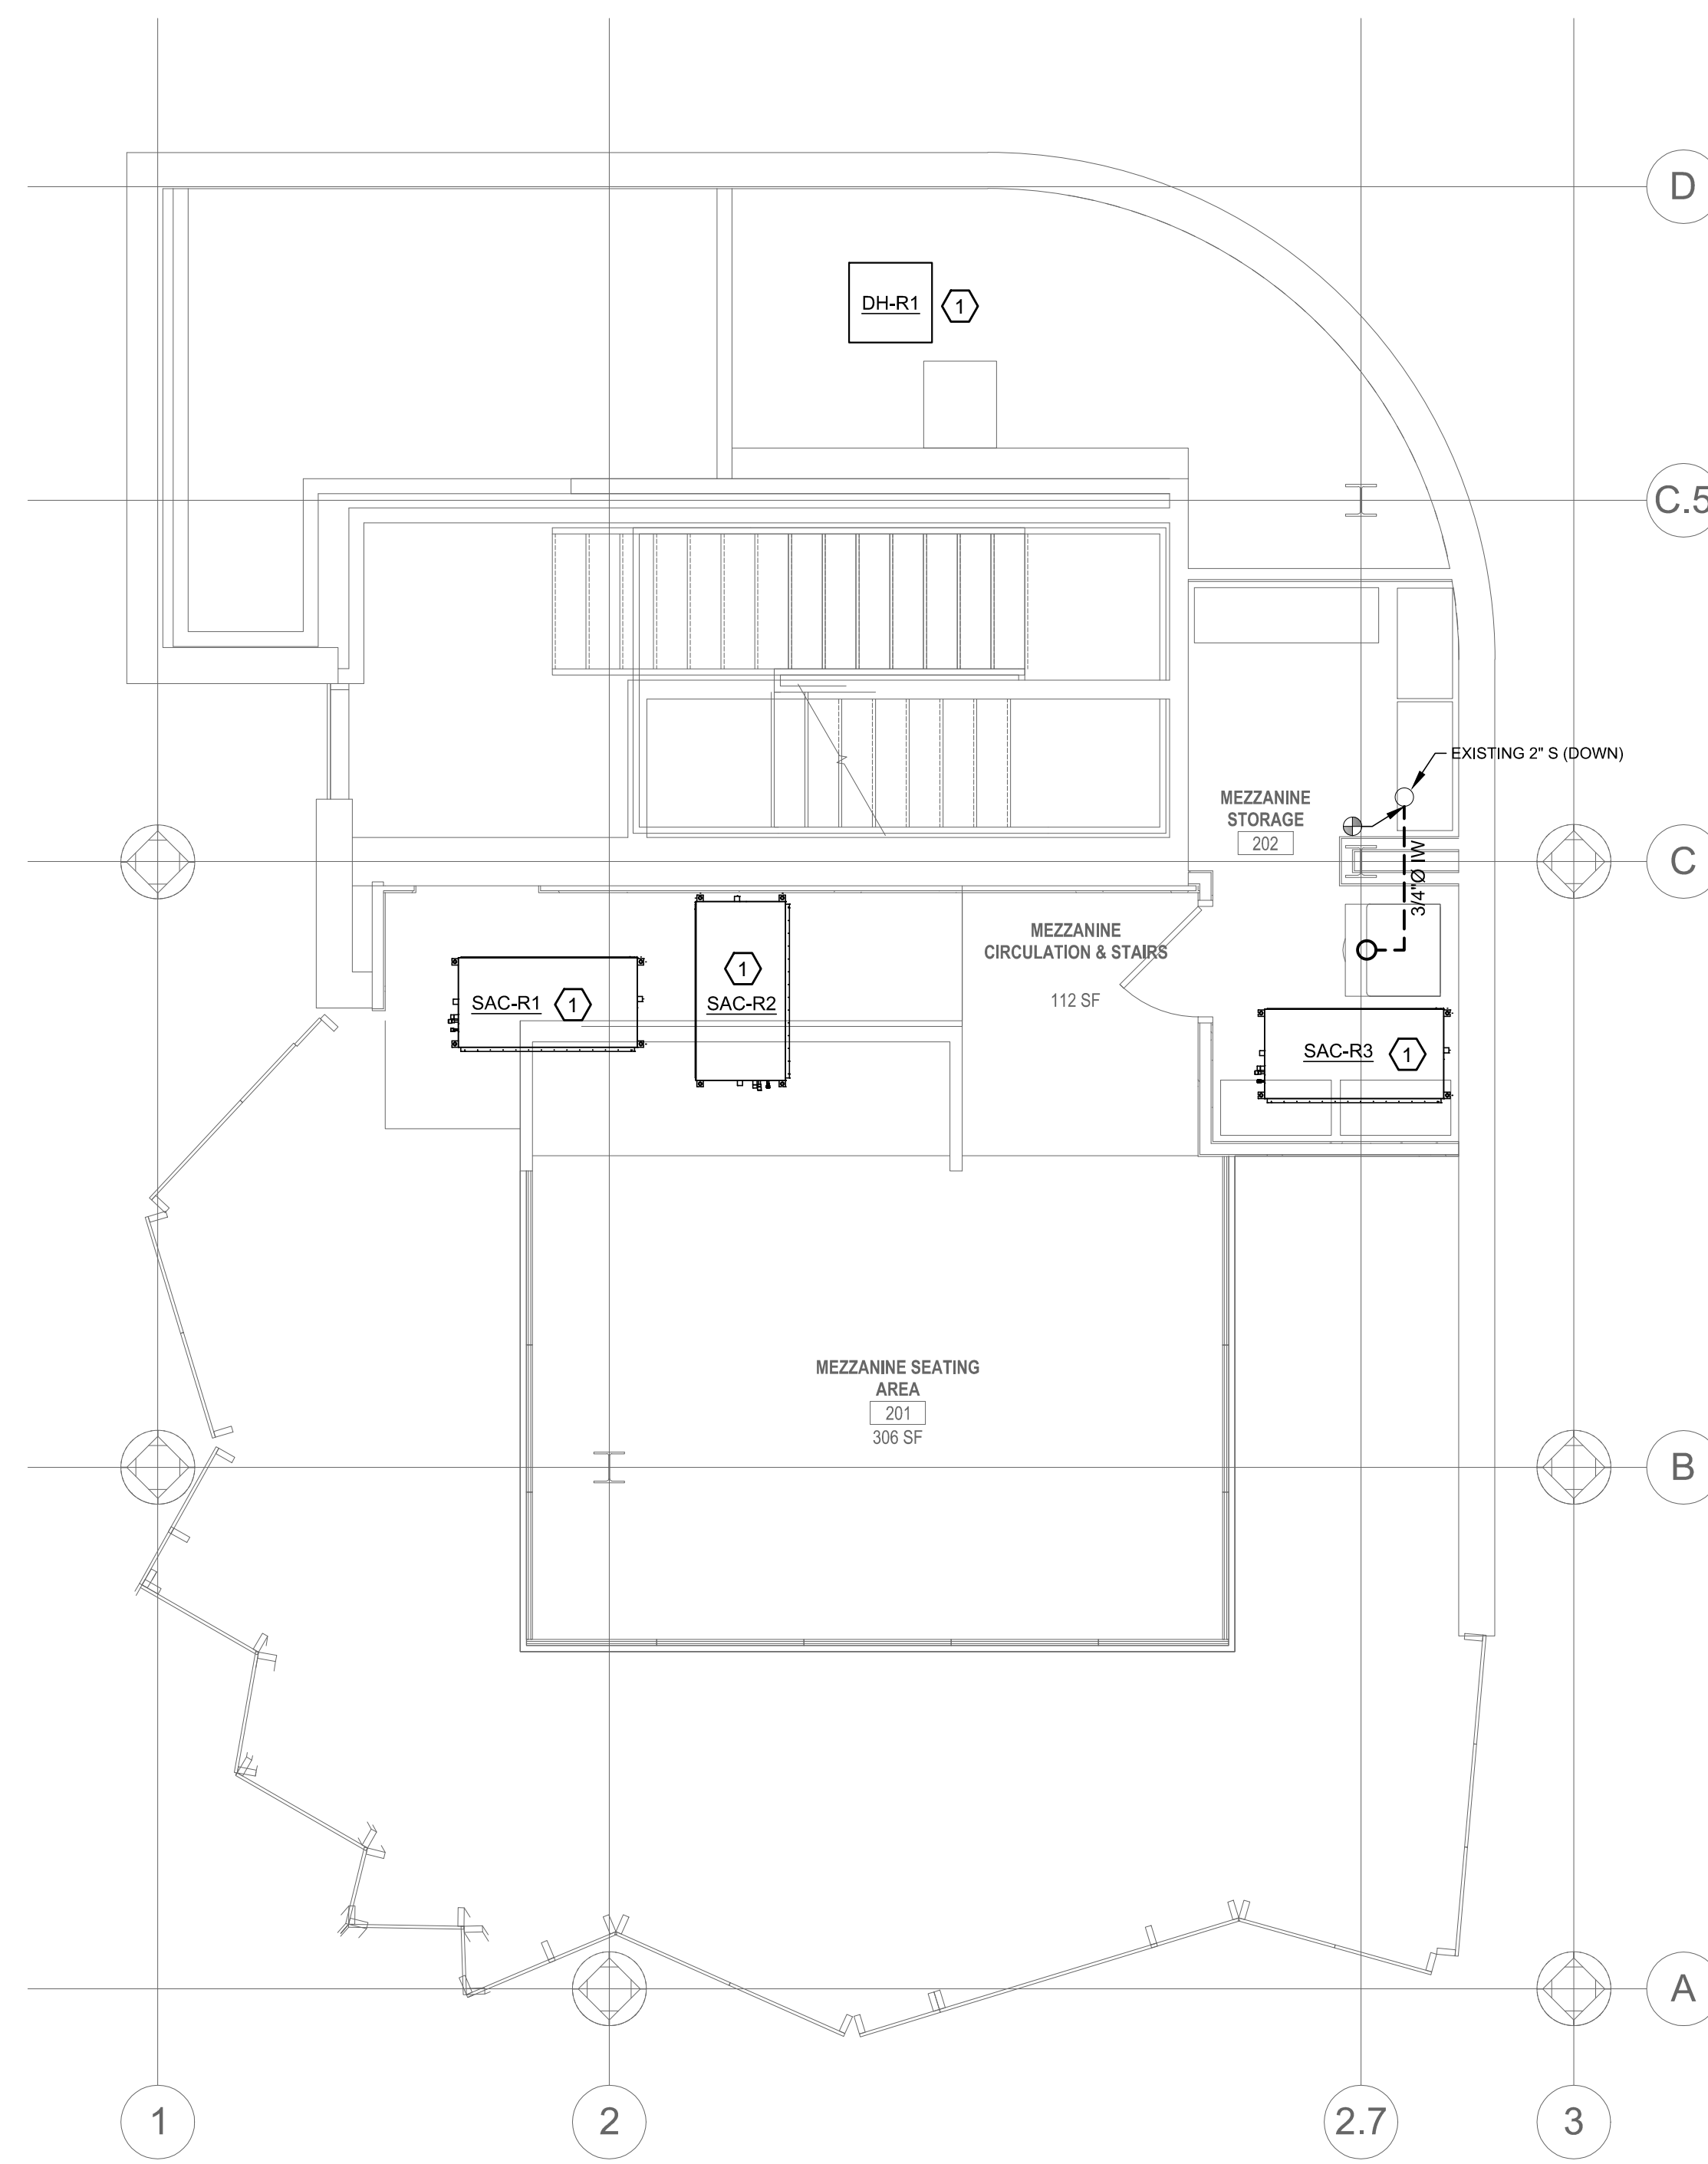

2 MEZZANINE - PLUMBING DRAINAGE LAYOUT
SCALE: 1/4" = 1'-0"


KEYED NOTES:

- ① COORDINATE CONDENSATE DRAINS IN FIELD.

This document is owned by, and the information contained in it is proprietary to Titan Mechanical Inc. By receipt hereof the holder agrees not to use the information, disclose it to any third party, nor reproduce this document without the prior written consent of Titan Mechanical Inc. and agrees to return this document forthwith upon request.

REVISIONS	DATE

Titan Mechanical, Inc.
Design Build Engineering - Mechanical Contracting
232 Riverside Industrial Parkway
Portland, Maine 04103
Ph. (207) 878-5223 Fax. (207) 878-5235

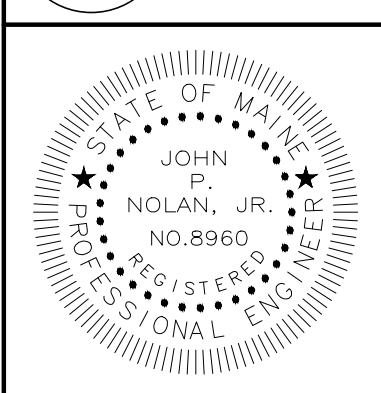

CANAL 5 STUDIO
CLIENT
443 FORE STREET RESTAURANT
PROJECT
HVAC EQUIPMENT & DUCTWORK PLAN
DRAWING TITLE

DATE: 11.11.2014
SCALE: AS NOTED
DRAWN BY: KLM
CHECKED BY: JPN
ISSUED FOR:
CONSTRUCTION
12.05.2014

SHEET NUMBER
P1.0
SHEET 1 OF 3