



PLUMBING FIXTURE SCHEDULE						
TAG	FIXTURE	CW	HW	WASTE	VENT	MODEL, REMARKS
P-1	ADA WATER CLOSET, WALL MOUNTED	1"	-	4"	2"	AMERICAN STANDARD LUCERNE W/ MONTERREY FAUCET COMMERCIAL SYSTEM NO: 0355.614.020
P-2	ADA LAVATORY, WALL HUNG	1/2"	1/2"	1-1/2"	1-1/2"	AMERICAN STANDARD MADERA ADA BOWL W/ SELECTRONIC FAUCET COMMERCIAL SYSTEM NO: 3461.716.020

COMMERCIAL WATER HEATER SCHEDULE								
TAG	SERVES	STORAGE (GAL)	DIA (IN)	HEIGHT (IN)	WEIGHT (LBS)	FLOW (GPH)	ELECTRICAL	REMARKS
WH-1	DOM. HOT WATER	85	28-1/4"	57-11/16"	350	138	208/360 84 FLA	-

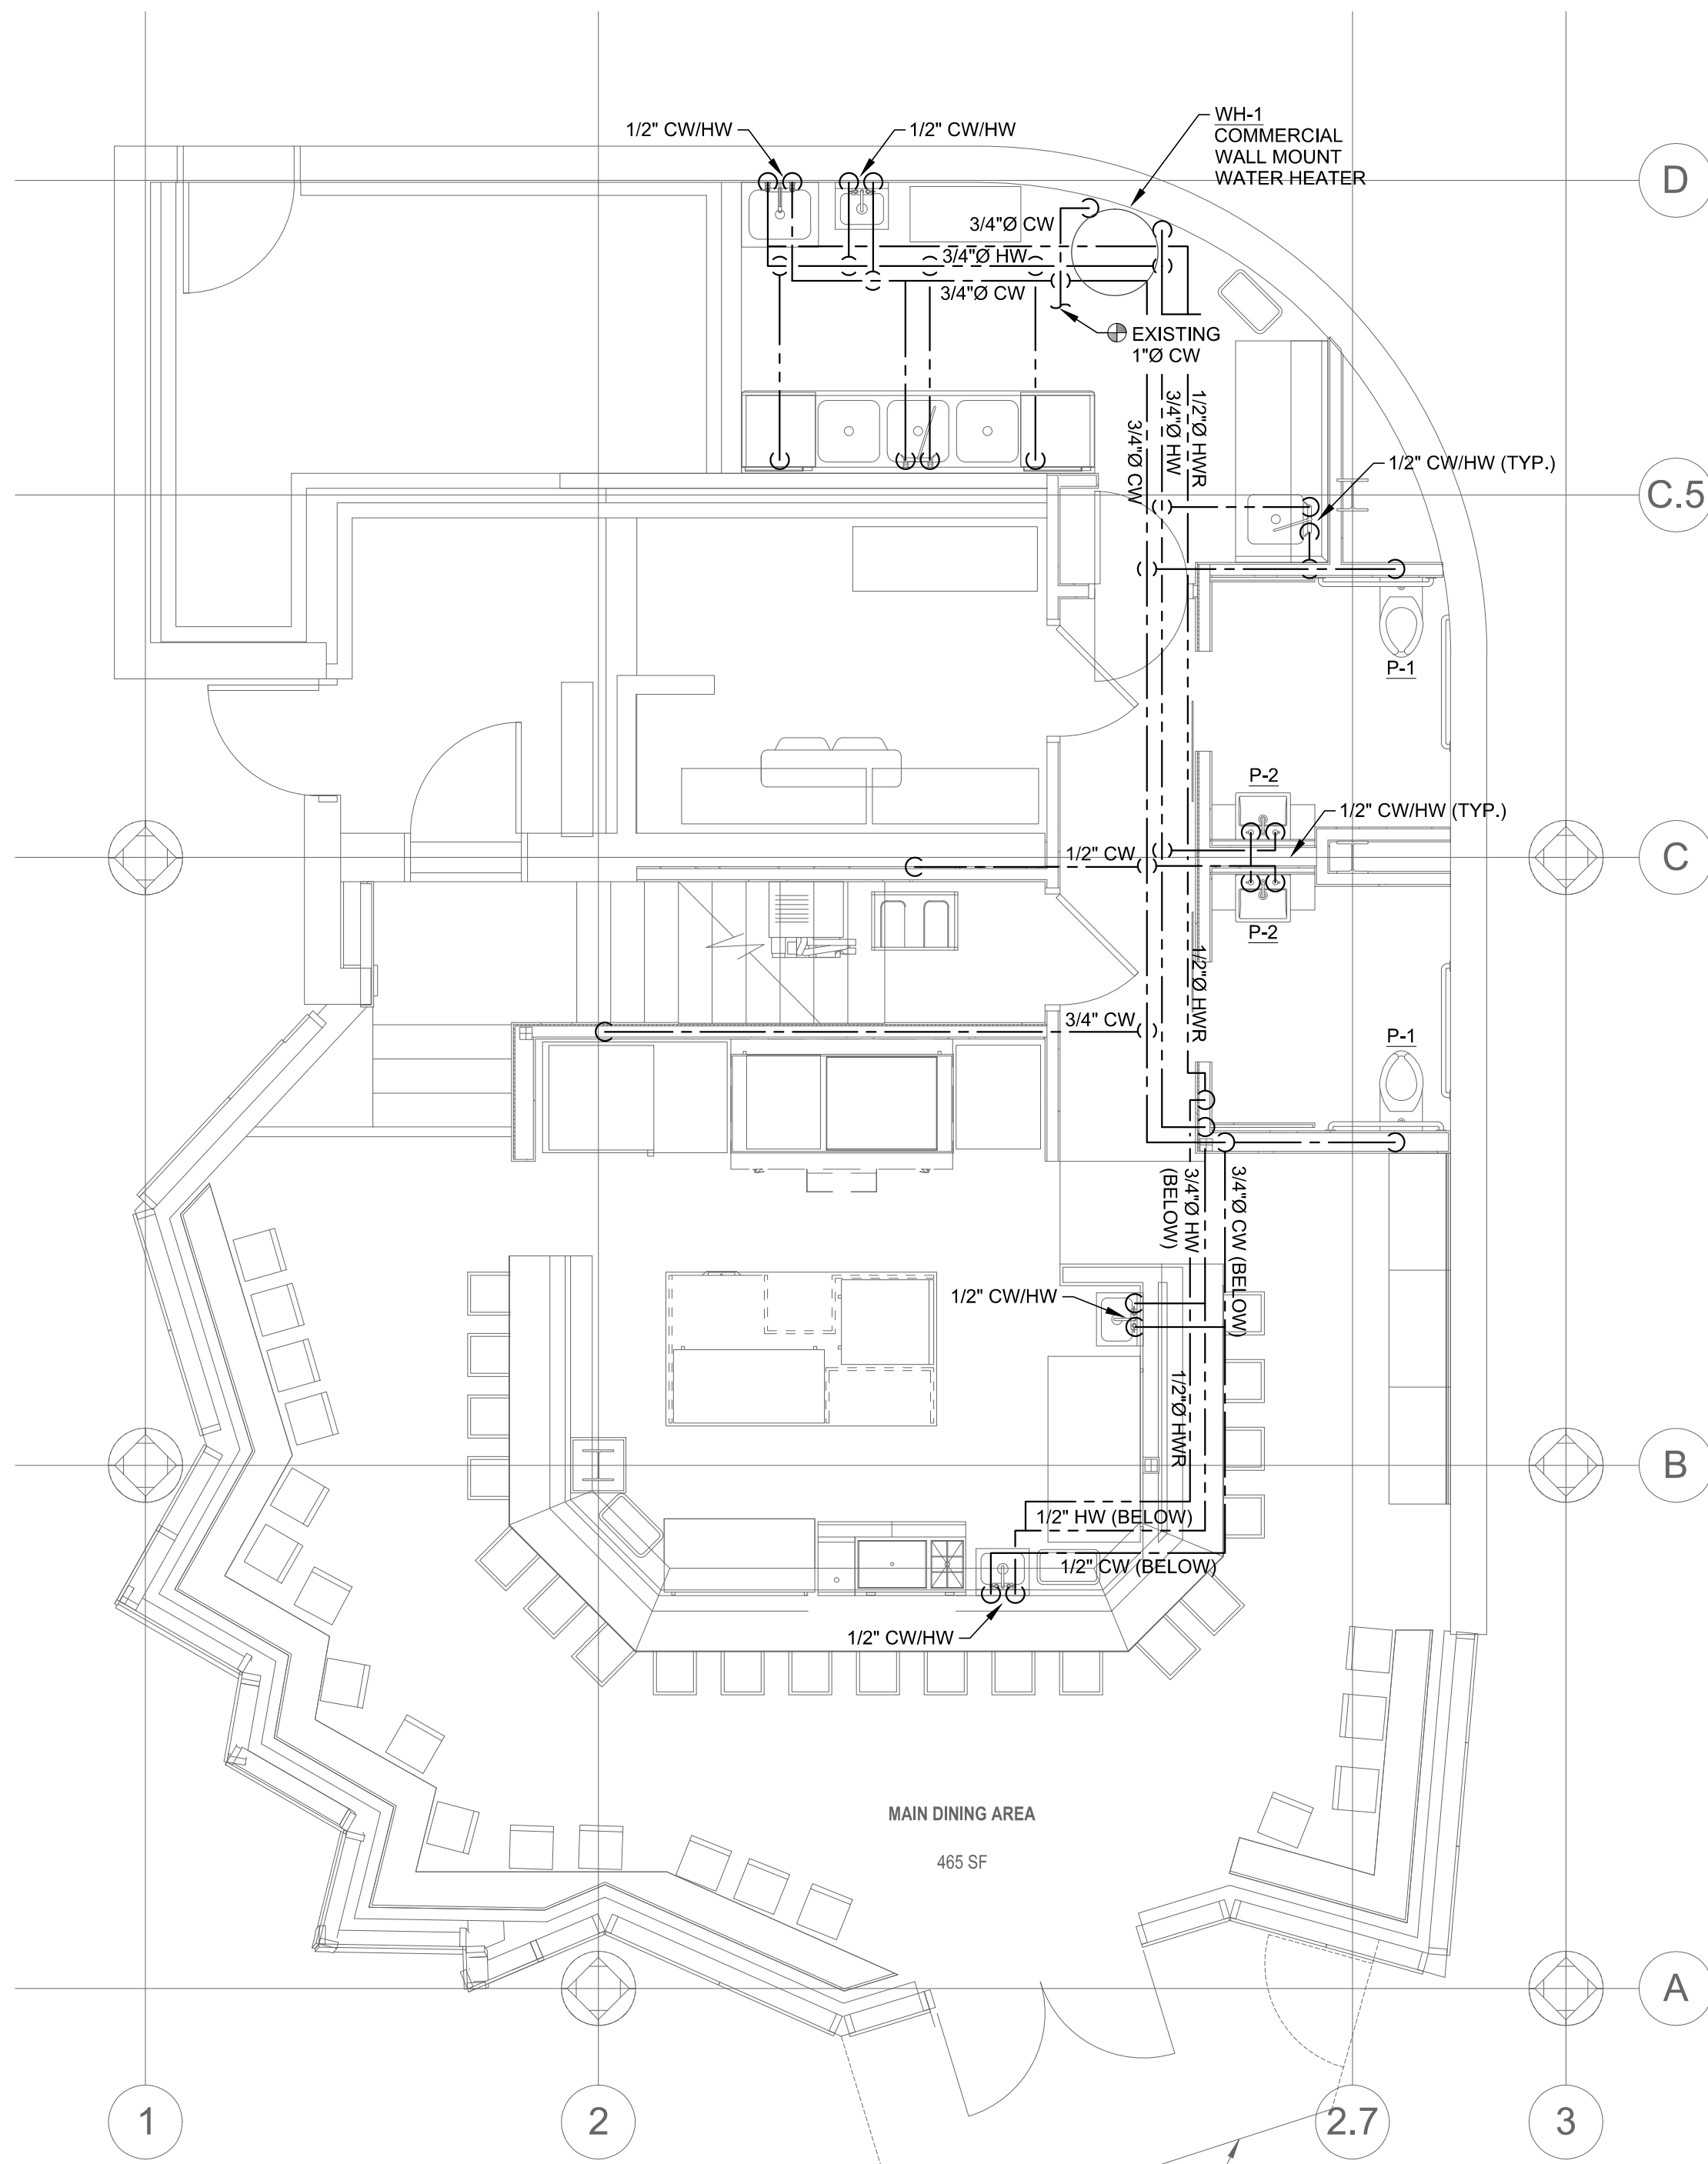

1 LOWER LEVEL - DOMESTIC PLUMBING LAYOUT
SCALE: 1/4" = 1'-0"

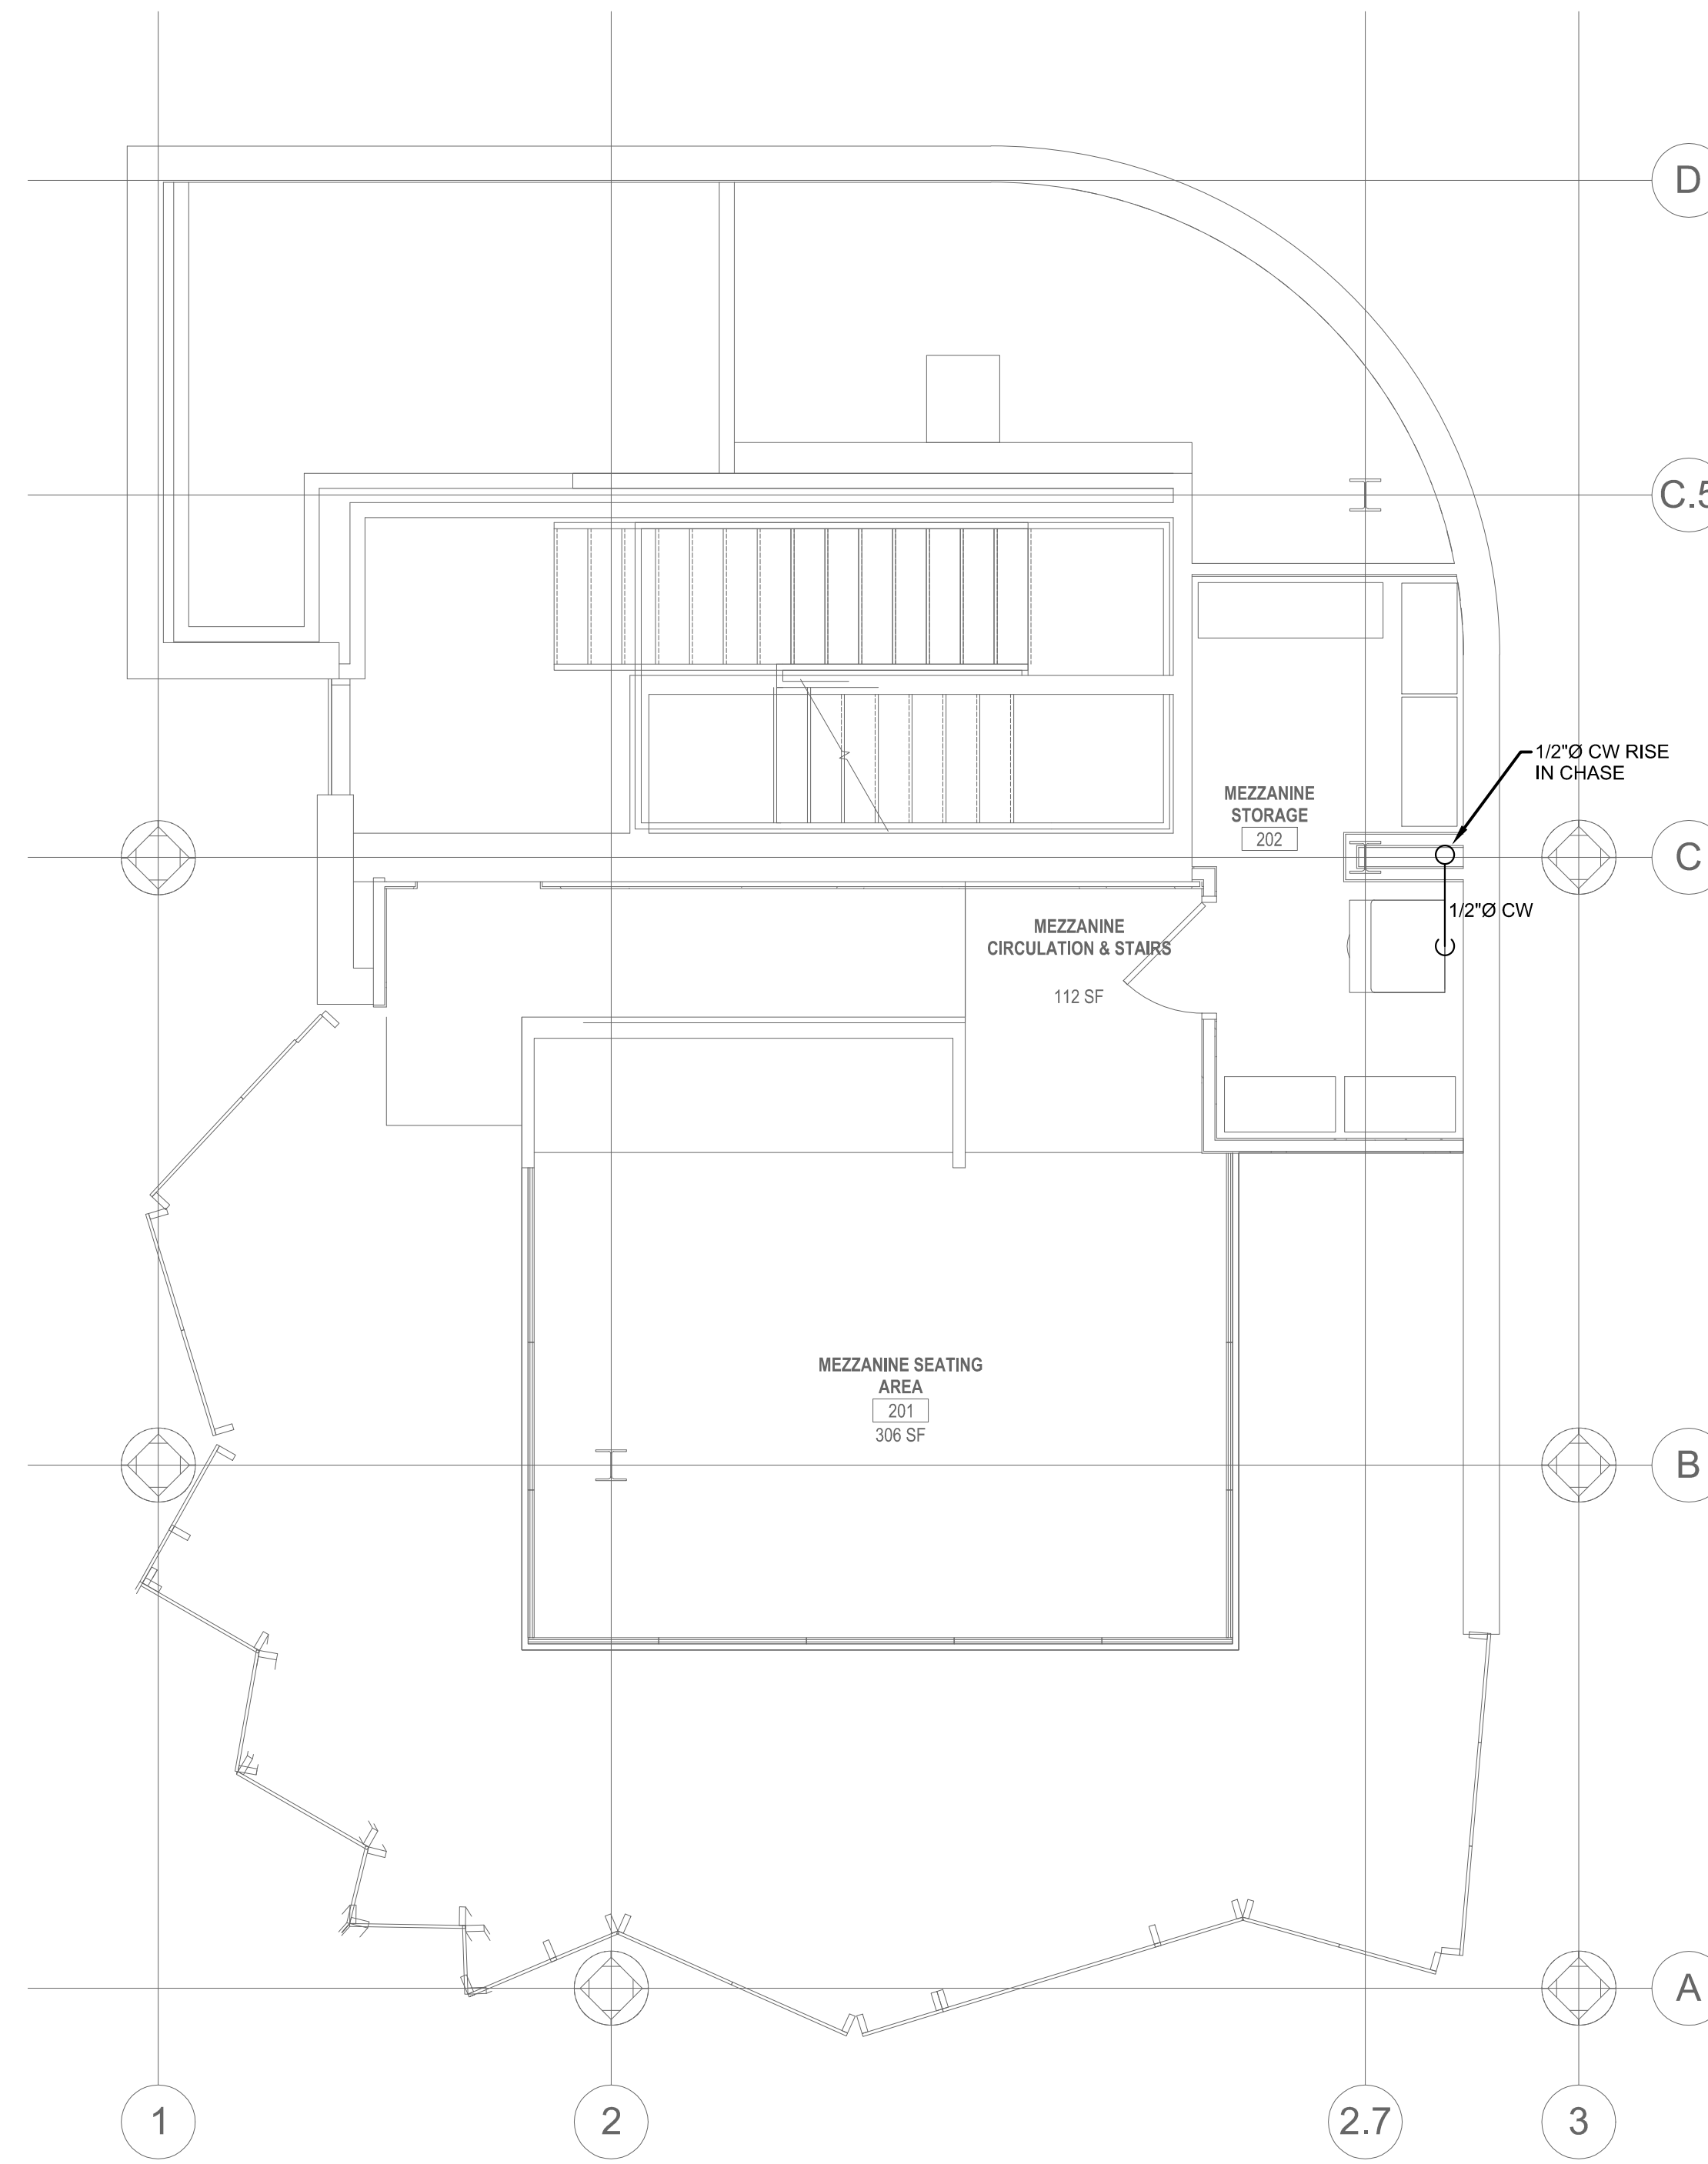


2 MEZZANINE - DOMESTIC PLUMBING LAYOUT
SCALE: 1/4" = 1'-0"

This document is owned by, and the information contained in it is proprietary to Titan Mechanical Inc. By receipt hereof the holder agrees not to use the information, disclose it to any third party, nor reproduce this document without the prior written consent of Titan Mechanical Inc. and agrees to return this document forthwith upon request.

REVISIONS	DATE

Titan Mechanical, Inc.
Design Build Engineering - Mechanical Contracting
232 Riverside Industrial Parkway
Portland, Maine 04103
Ph. (207) 878-5223 Fax. (207) 878-5235

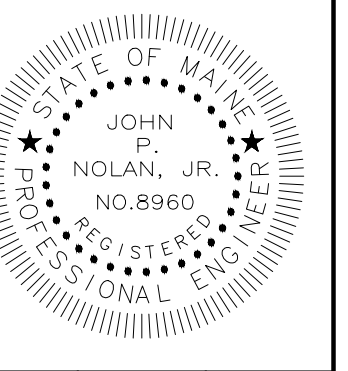

CANAL 5 STUDIO
CLIENT
443 FORE STREET RESTAURANT
PROJECT
HVAC EQUIPMENT & DUCTWORK PLAN
DRAWING TITLE

DATE: 11.11.2014
SCALE: AS NOTED
DRAWN BY: KLM
CHECKED BY: JPN
ISSUED FOR:
CONSTRUCTION
12.05.2014

SHEET NUMBER
P2.0