


FOODSERVICE EQUIPMENT SCHEDULE																			
MK.	QTY	DESCRIPTION	ELECTRICAL						WATER		WASTE		GAS		STEAM			REMARKS	
			FLAMPS	KW	HP	VOLTS	PHASE	DIRECT	PLUG	COLD	HOT	DIRECT	INDIRECT	SIZE	MBTUH	LBS/HR	PSIG		INLET
1	1	REFRIGERATOR, 1-SECTION	6.0		1/3	120	1	X											
2	1	VENTLESS HOOD SYSTEM	8.0			208/240	1	X											
3	1	REFRIGERATED EQUIPMENT STAND	9.9		1/3	115	1	X											
4	1	INDUCTION PLANCHA	39.0	14.0		208	3	X											
5	1	INDUCTION COOKTOP, 4-HOB	24.0			208	1	X											
		— SPARE NUMBER —	24.0			208	1	X											
6	—	— SPARE NUMBER —																	
7	1	WORK TABLE																	
8	1	COMBI-OVEN	44.0	15.4		208	3	X	3/4"			1-1/2"							
		— SPARE NUMBER —		0.8		208	1	X											
9	—	— SPARE NUMBER —																	
10	1	FIRE SUPPRESSION SYSTEM																	
11	1	DRAWER WARMER	3.8	0.45		120	1	X											
12	1	REFRIGERATOR, UNDERCOUNTER	4.8		1/3	115	1	X											
13	1	REFRIGERATED SANDWICH UNIT	7.8		1/3	115	1	X											
14	2	BACK BAR COOLER	7.6		1/3	115	1	X											
15	—	— SPARE NUMBER —																	
16	1	UNDERBAR, DRAINBOARD										1"							
17	—	— SPARE NUMBER —																	
18	1	UNDERBAR, ICE BIN										1/2", 1"							
19	1	UNDERBAR, SPEED RAIL																	
20	—	— SPARE NUMBER —																	
21	—	— SPARE NUMBER —																	
22	—	— SPARE NUMBER —																	
23	3	TRASH CONTAINER — SLIM JIM																	
24	—	— SPARE NUMBER —																	
25	1	BEER LINE CHILLER	13.0		1/3	120	1	X											
26	1	WALK-IN COOLER	15.0			115	1	X											
27	1	EVAPORATOR COIL, COOLER	1.8			115	1	X				3/4"							
28	1	COMPRESSOR, COOLER	5.8		1	208	3	X											
29	3	SHELVING UNIT																	
30	—	— SPARE NUMBER —																	
31	1	WORK TABLE WITH SINK							1/2"	1/2"		2"							
32	1	WALL SHELF																	
33	1	SHELVING UNIT																	
34	1	MOP SINK							1/2"	1/2"	2"								
35	2	DISHWASHER, UNDERCOUNTER	38.8			208	1	X	1/2"	1/2"	1-3/8"								
36	3	HAND SINK							1/2"	1/2"	1-1/2"								
37	1	SINK, 3-COMPARTMENT							1/2"	1/2"	3 @ 2"								
38	1	ICE MACHINE WITH BIN	19.0			115	1	X	3/8"			2 @ 3/4"							
39	1	BAG-N-BOX RACK	15.0			115	1	X	1/2"										
40	5	SHELVING UNIT																	

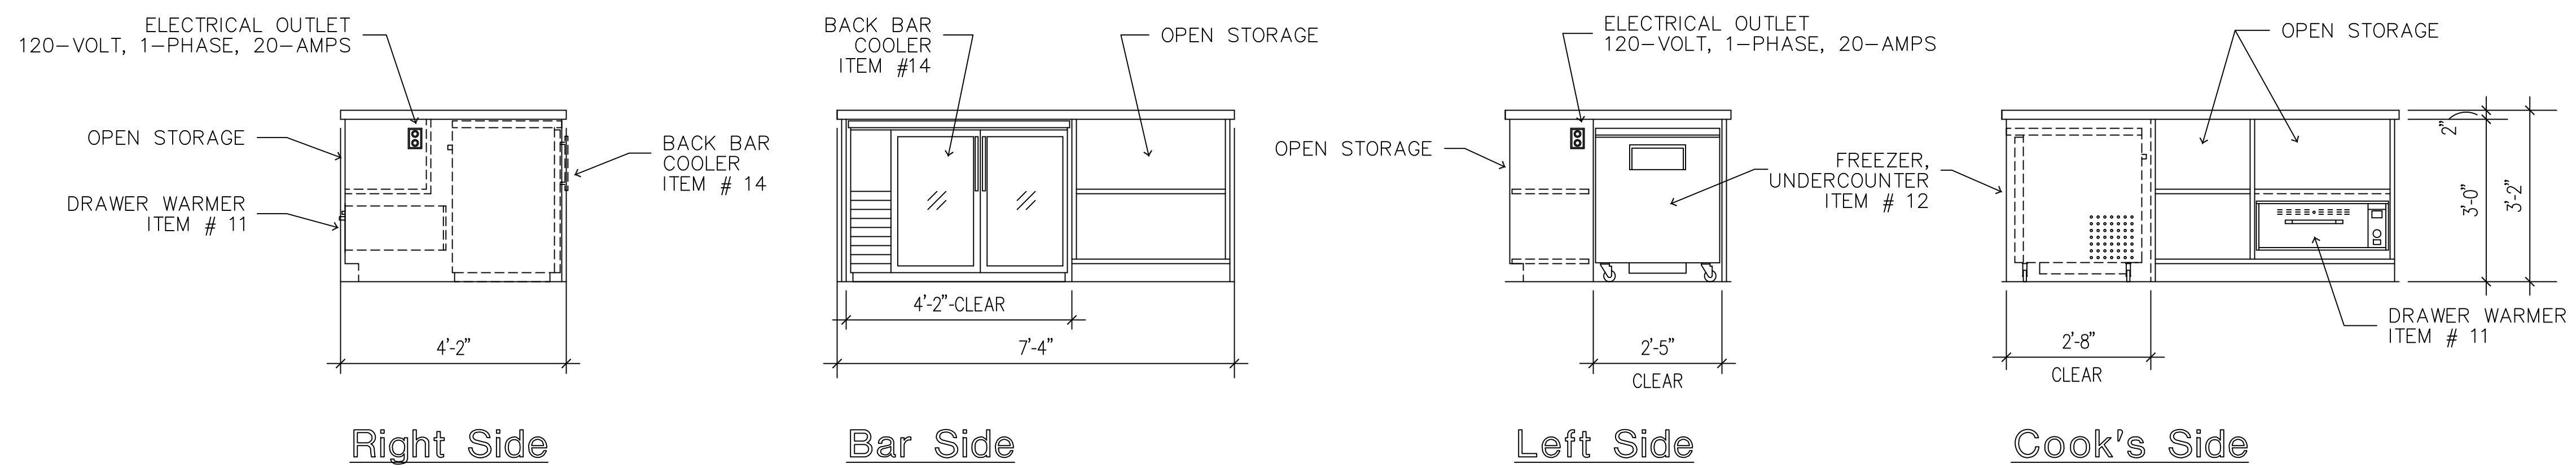

**Chef's Island Work Counter Elevations**  
 SCALE - 1/2" = 1' - 0"

Project Title  
**443 Fore Street Restaurant**  
 443 Fore Street, Portland, ME 04101  
 C55 Project No. 14011

THIS DRAWING IS THE PROPERTY OF CANAL 5 STUDIO AND IS NOT TO BE COPIED OR REPRODUCED IN PART OR WHOLE. 2014 © CANAL 5 STUDIO

Mark Date Description  
 Project Status  
**Construction Document Phase**  
 December 3, 2014

Drawing Title  
**Foodservice Equipment Mechanical Schedule**

Scale: 1/4" = 1'-0"  
 Drawing Number

**FS-02**