






**HORIZONTAL ACOUSTICAL PANELS**

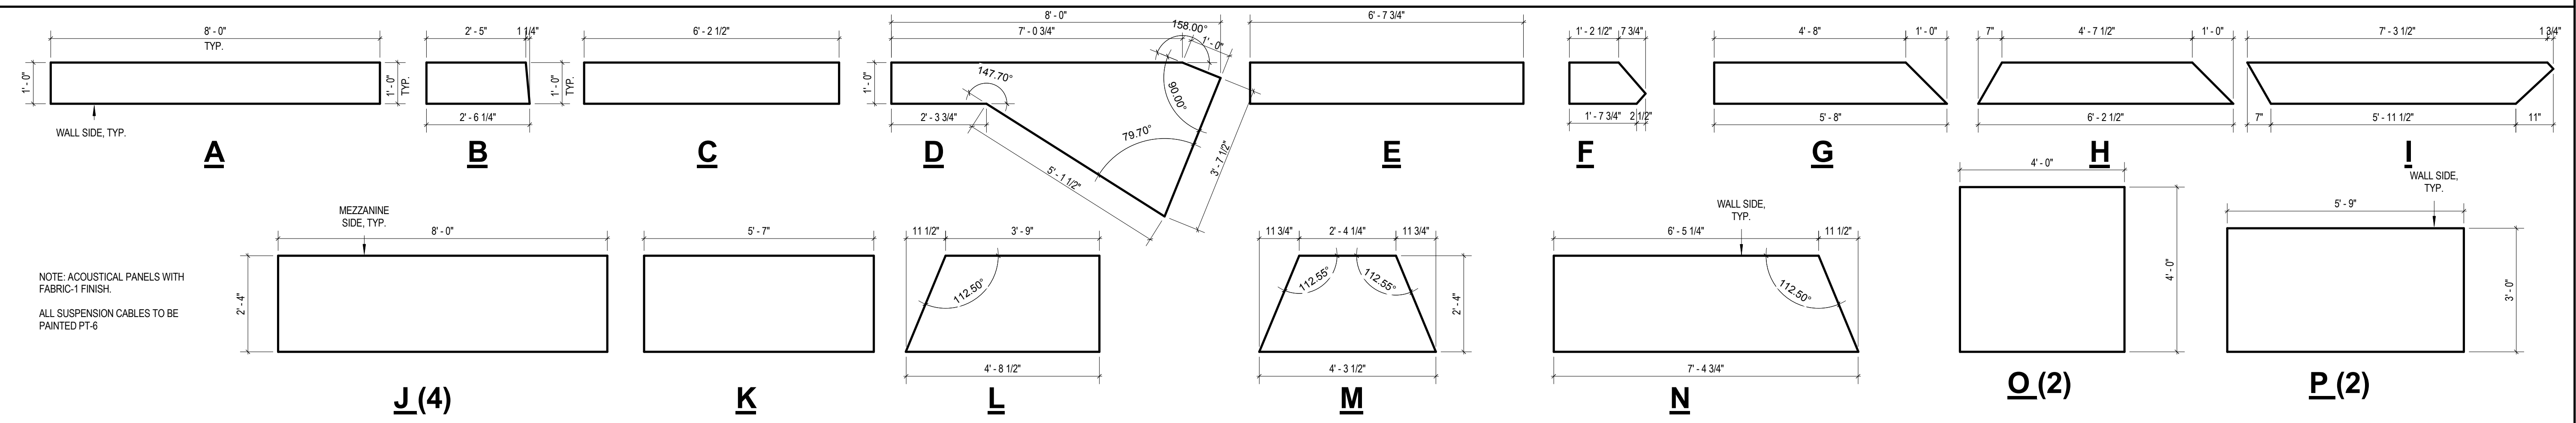


**SLOPED ACOUSTICAL PANELS**

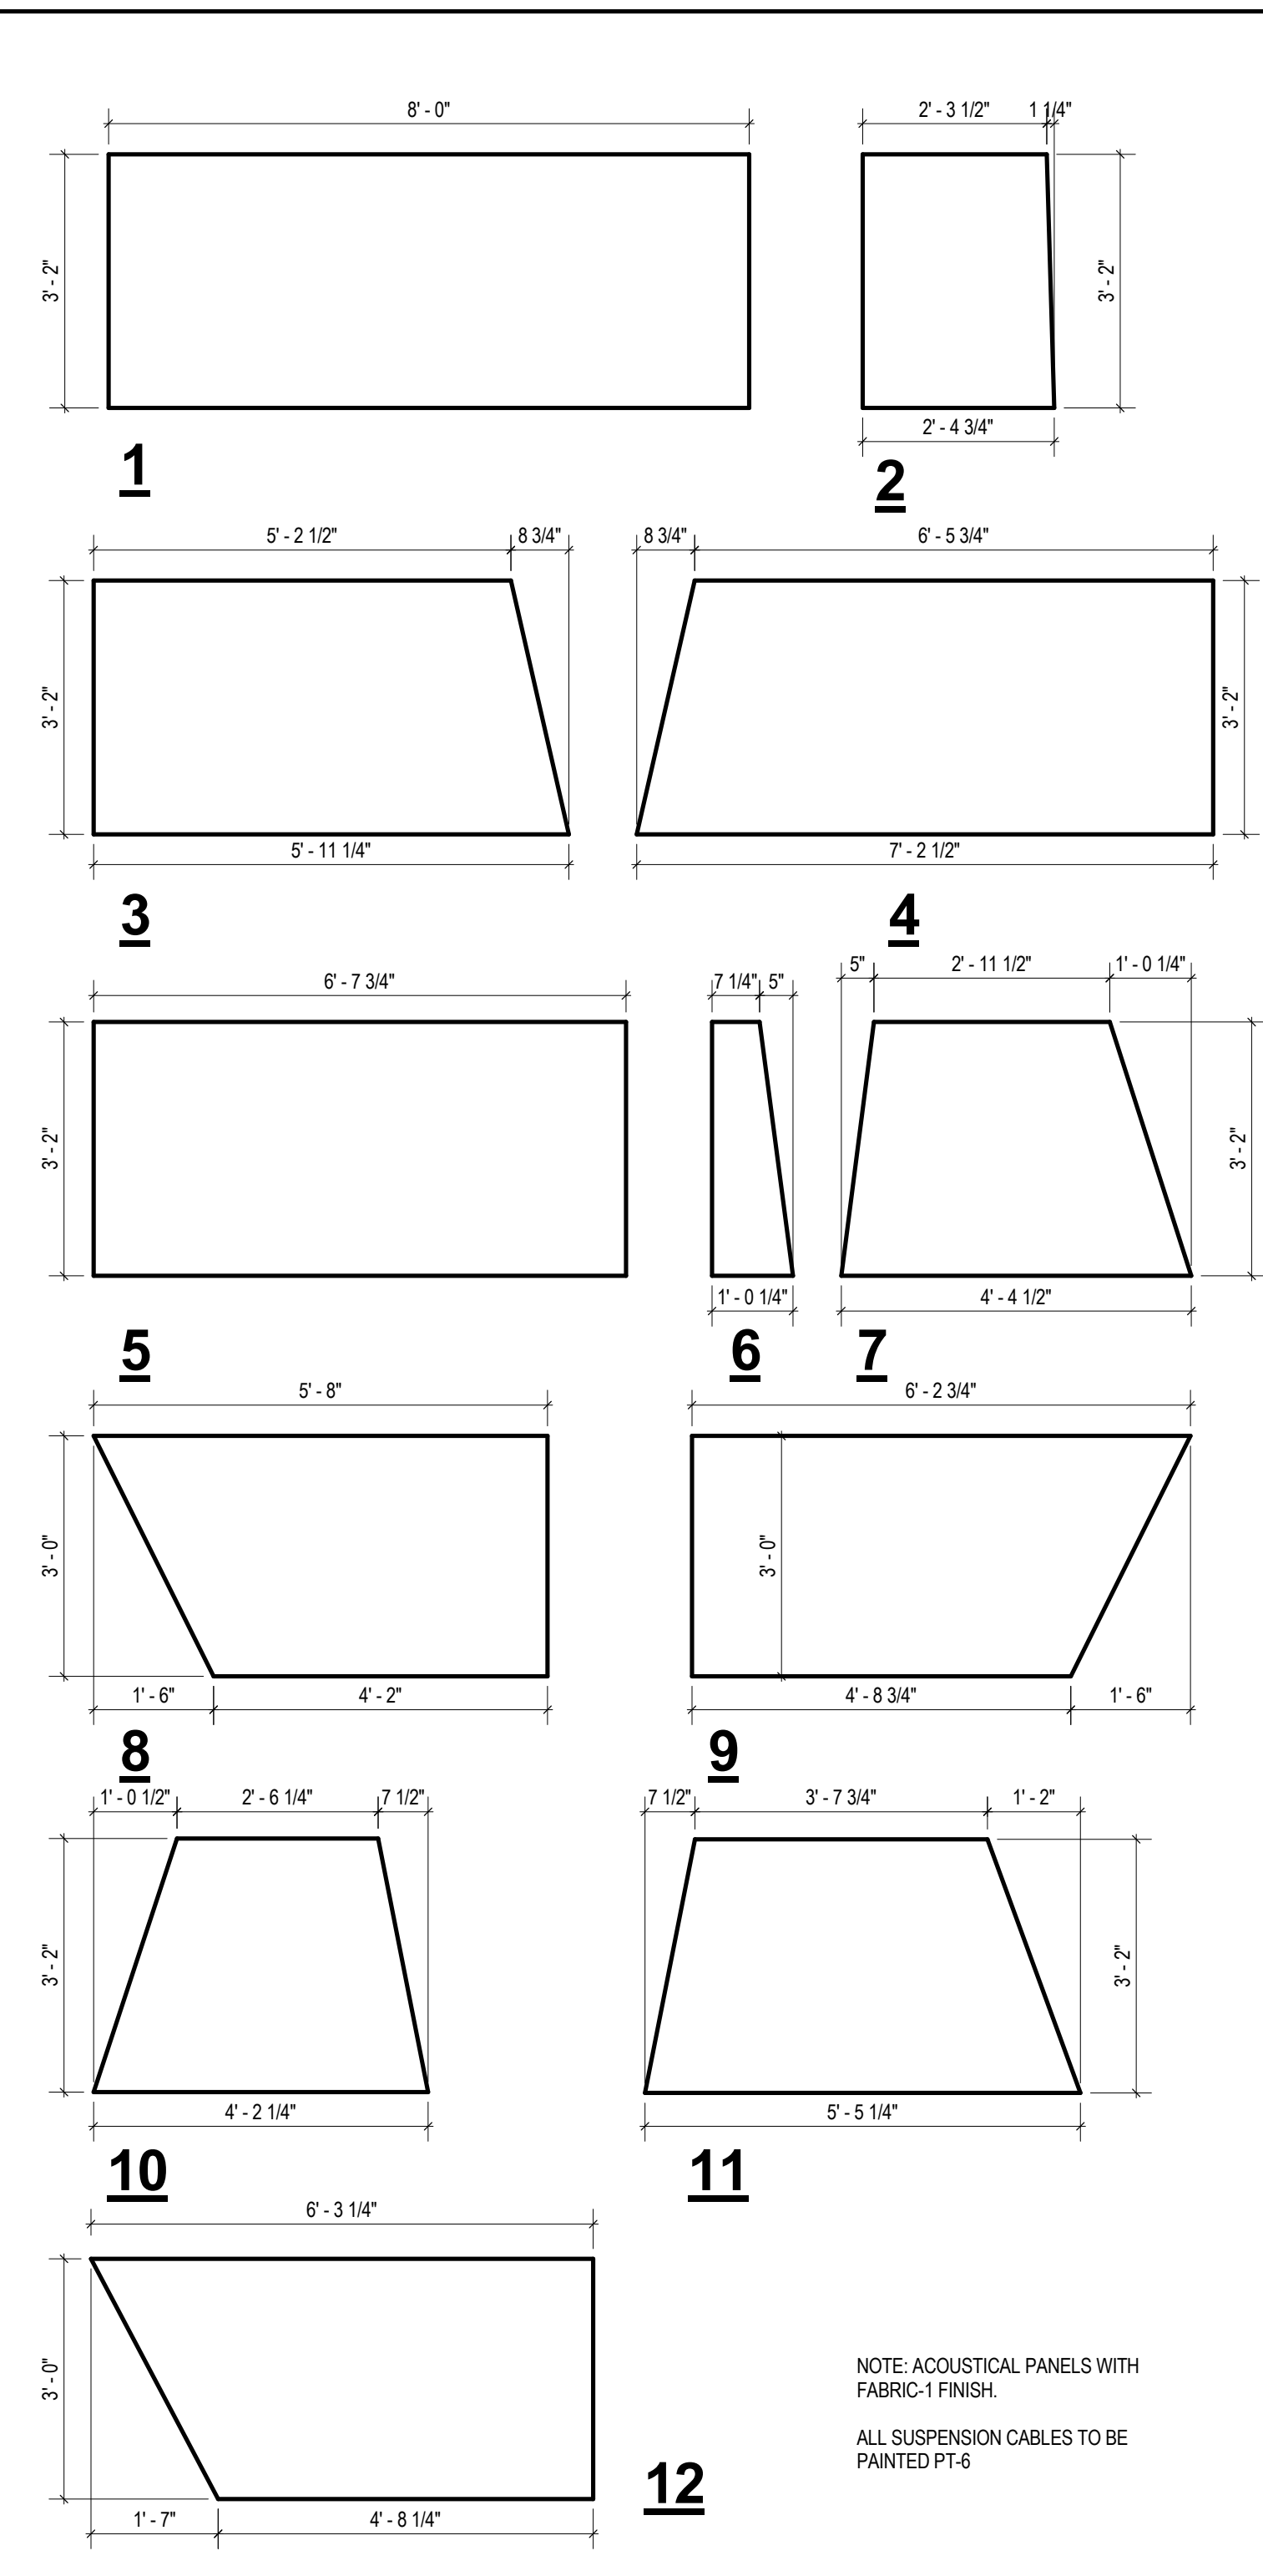

**MEZZANINE HORIZONTAL ACOUSTICAL PANELS**

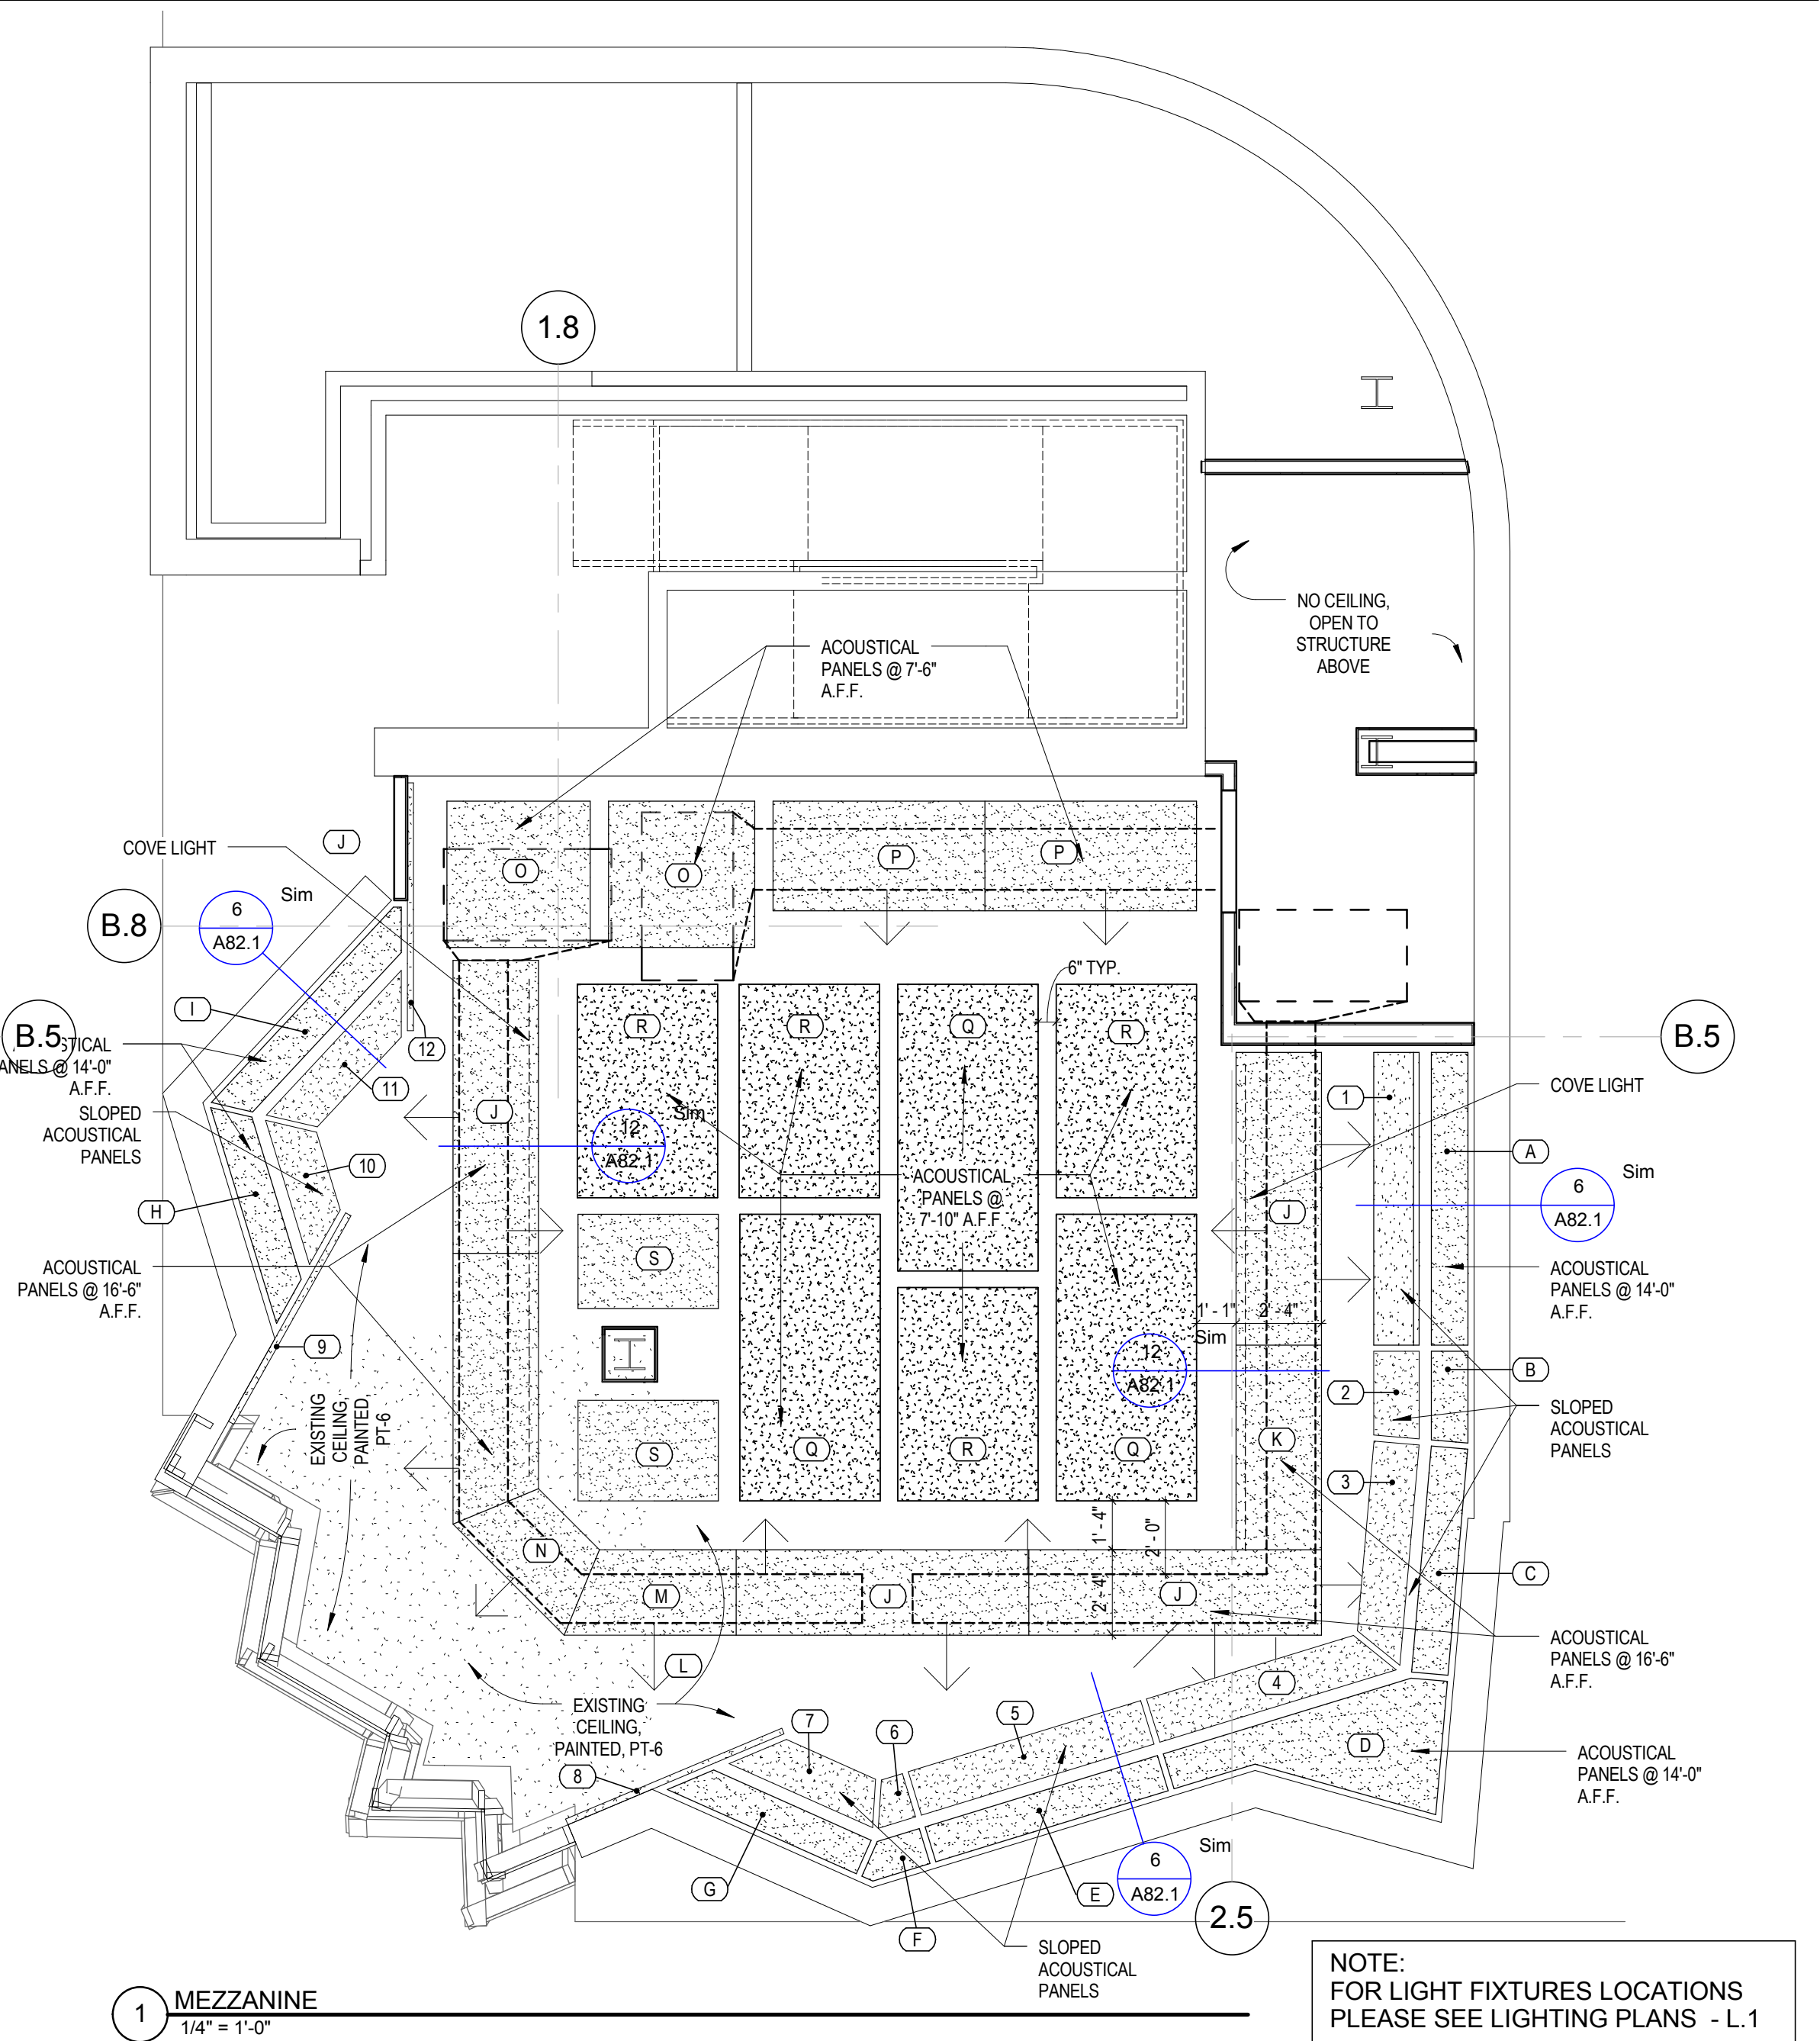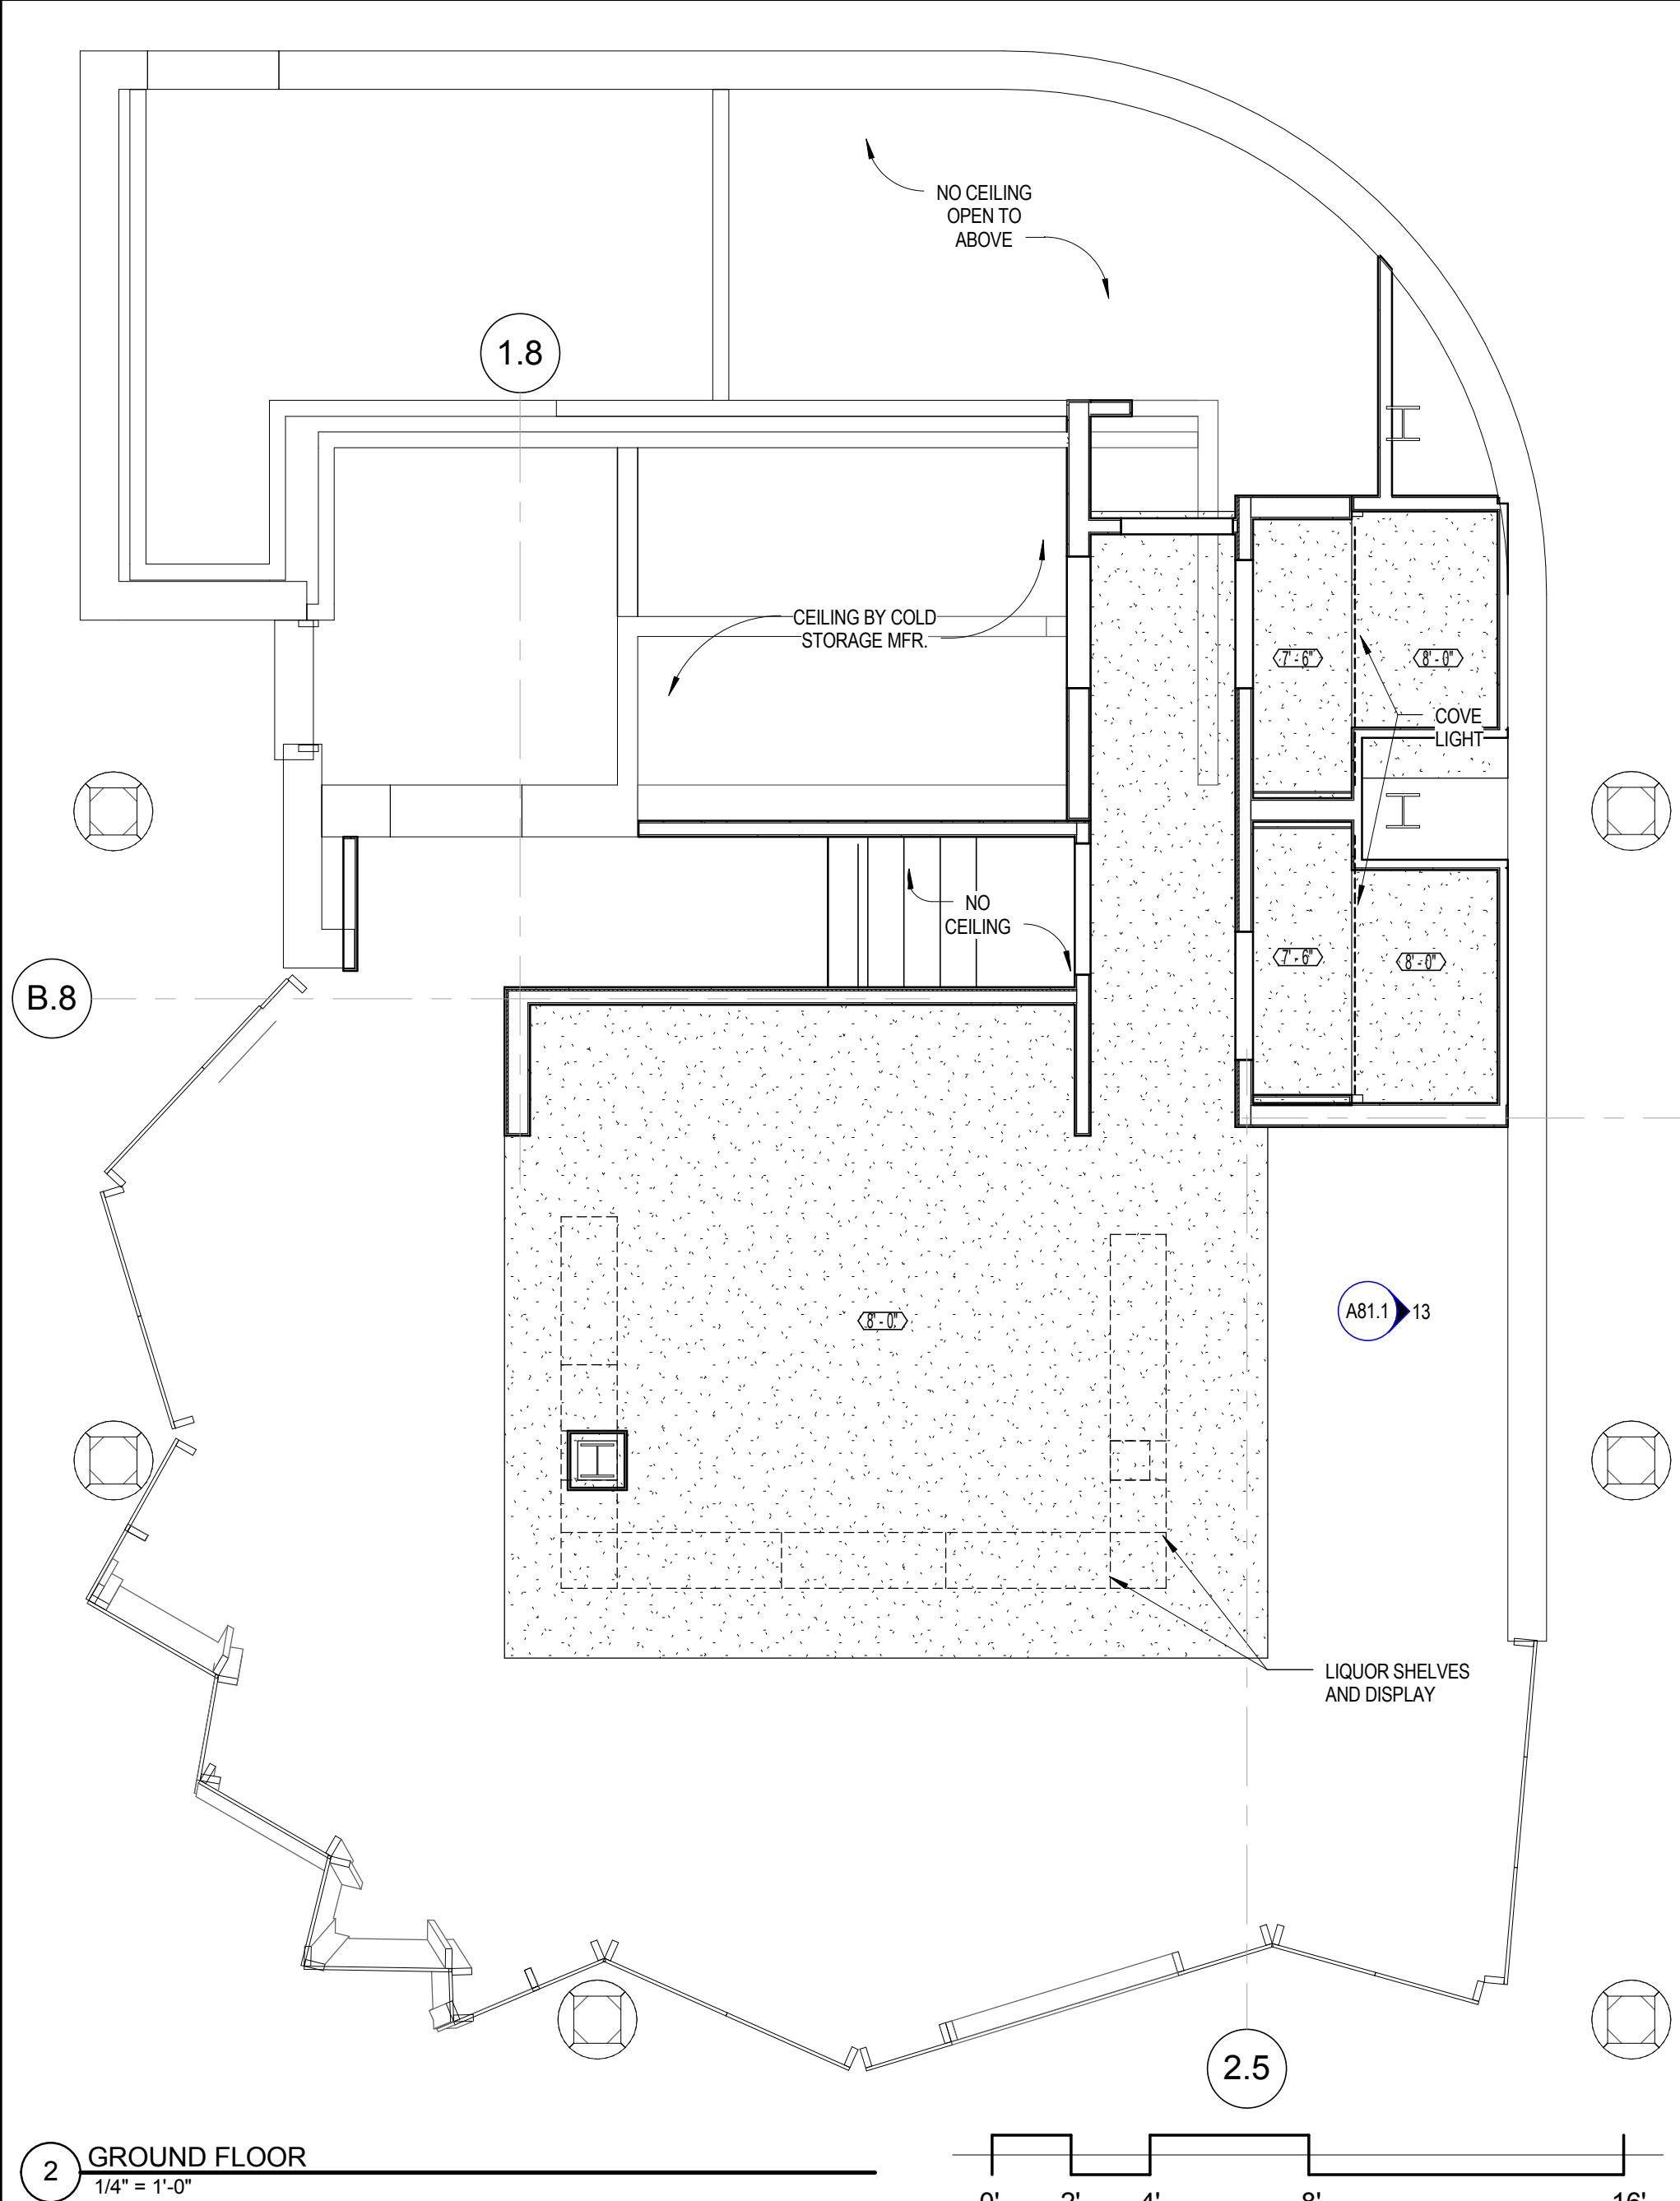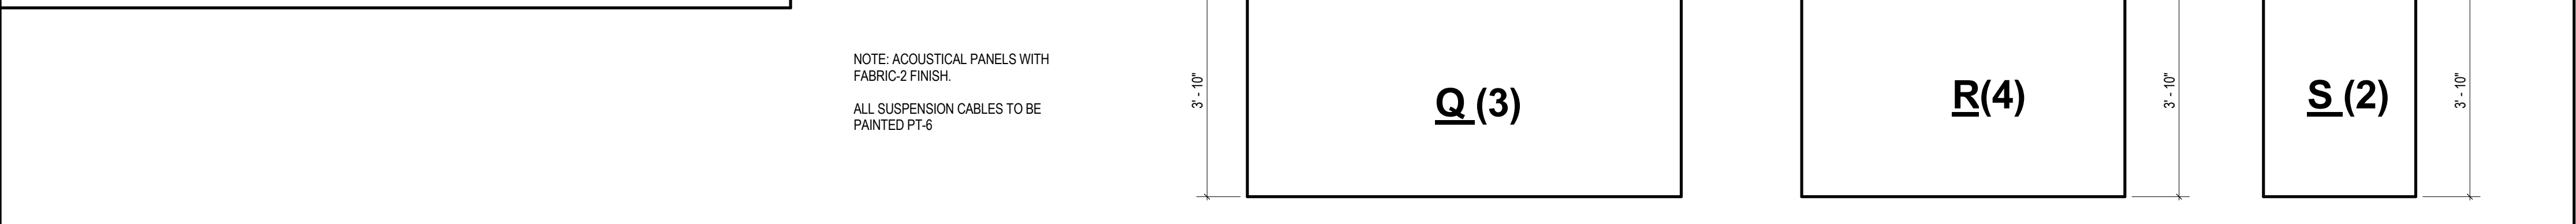

GENERAL NOTES:  
 SEE DRAWING L.1 FOR LIGHTING PLANS

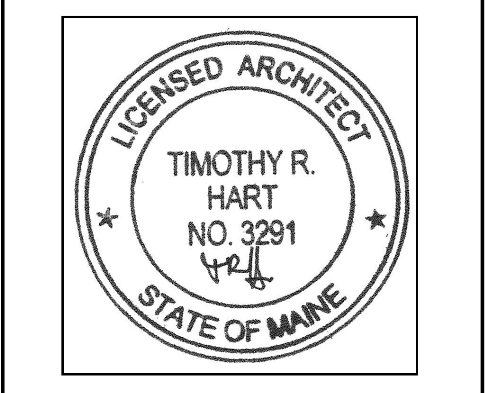

THIS DRAWING IS THE PROPERTY OF CANAL 5 STUDIO AND IS NOT TO BE COPIED OR REPRODUCED IN PART OR WHOLE. 2014 © CANAL 5 STUDIO

Mark	Date	Description

**ISSUED FOR PERMIT**  
 DECEMBER 05, 2014

Drawing Title  
**Reflected Ceiling Plans**

Scale: As indicated  
 Drawing Number

**A70.1**

NOTE:  
 FOR LIGHT FIXTURES LOCATIONS  
 PLEASE SEE LIGHTING PLANS - L.1