


FILE PATH: P:\2013\147\Hyatt Place\REV 3\CAD\FA-102.dwg

LAST PRINTED: 2/10/2014 8:54:23 AM LAST SAVED BY: SKALAFARSKI

24" x 36"

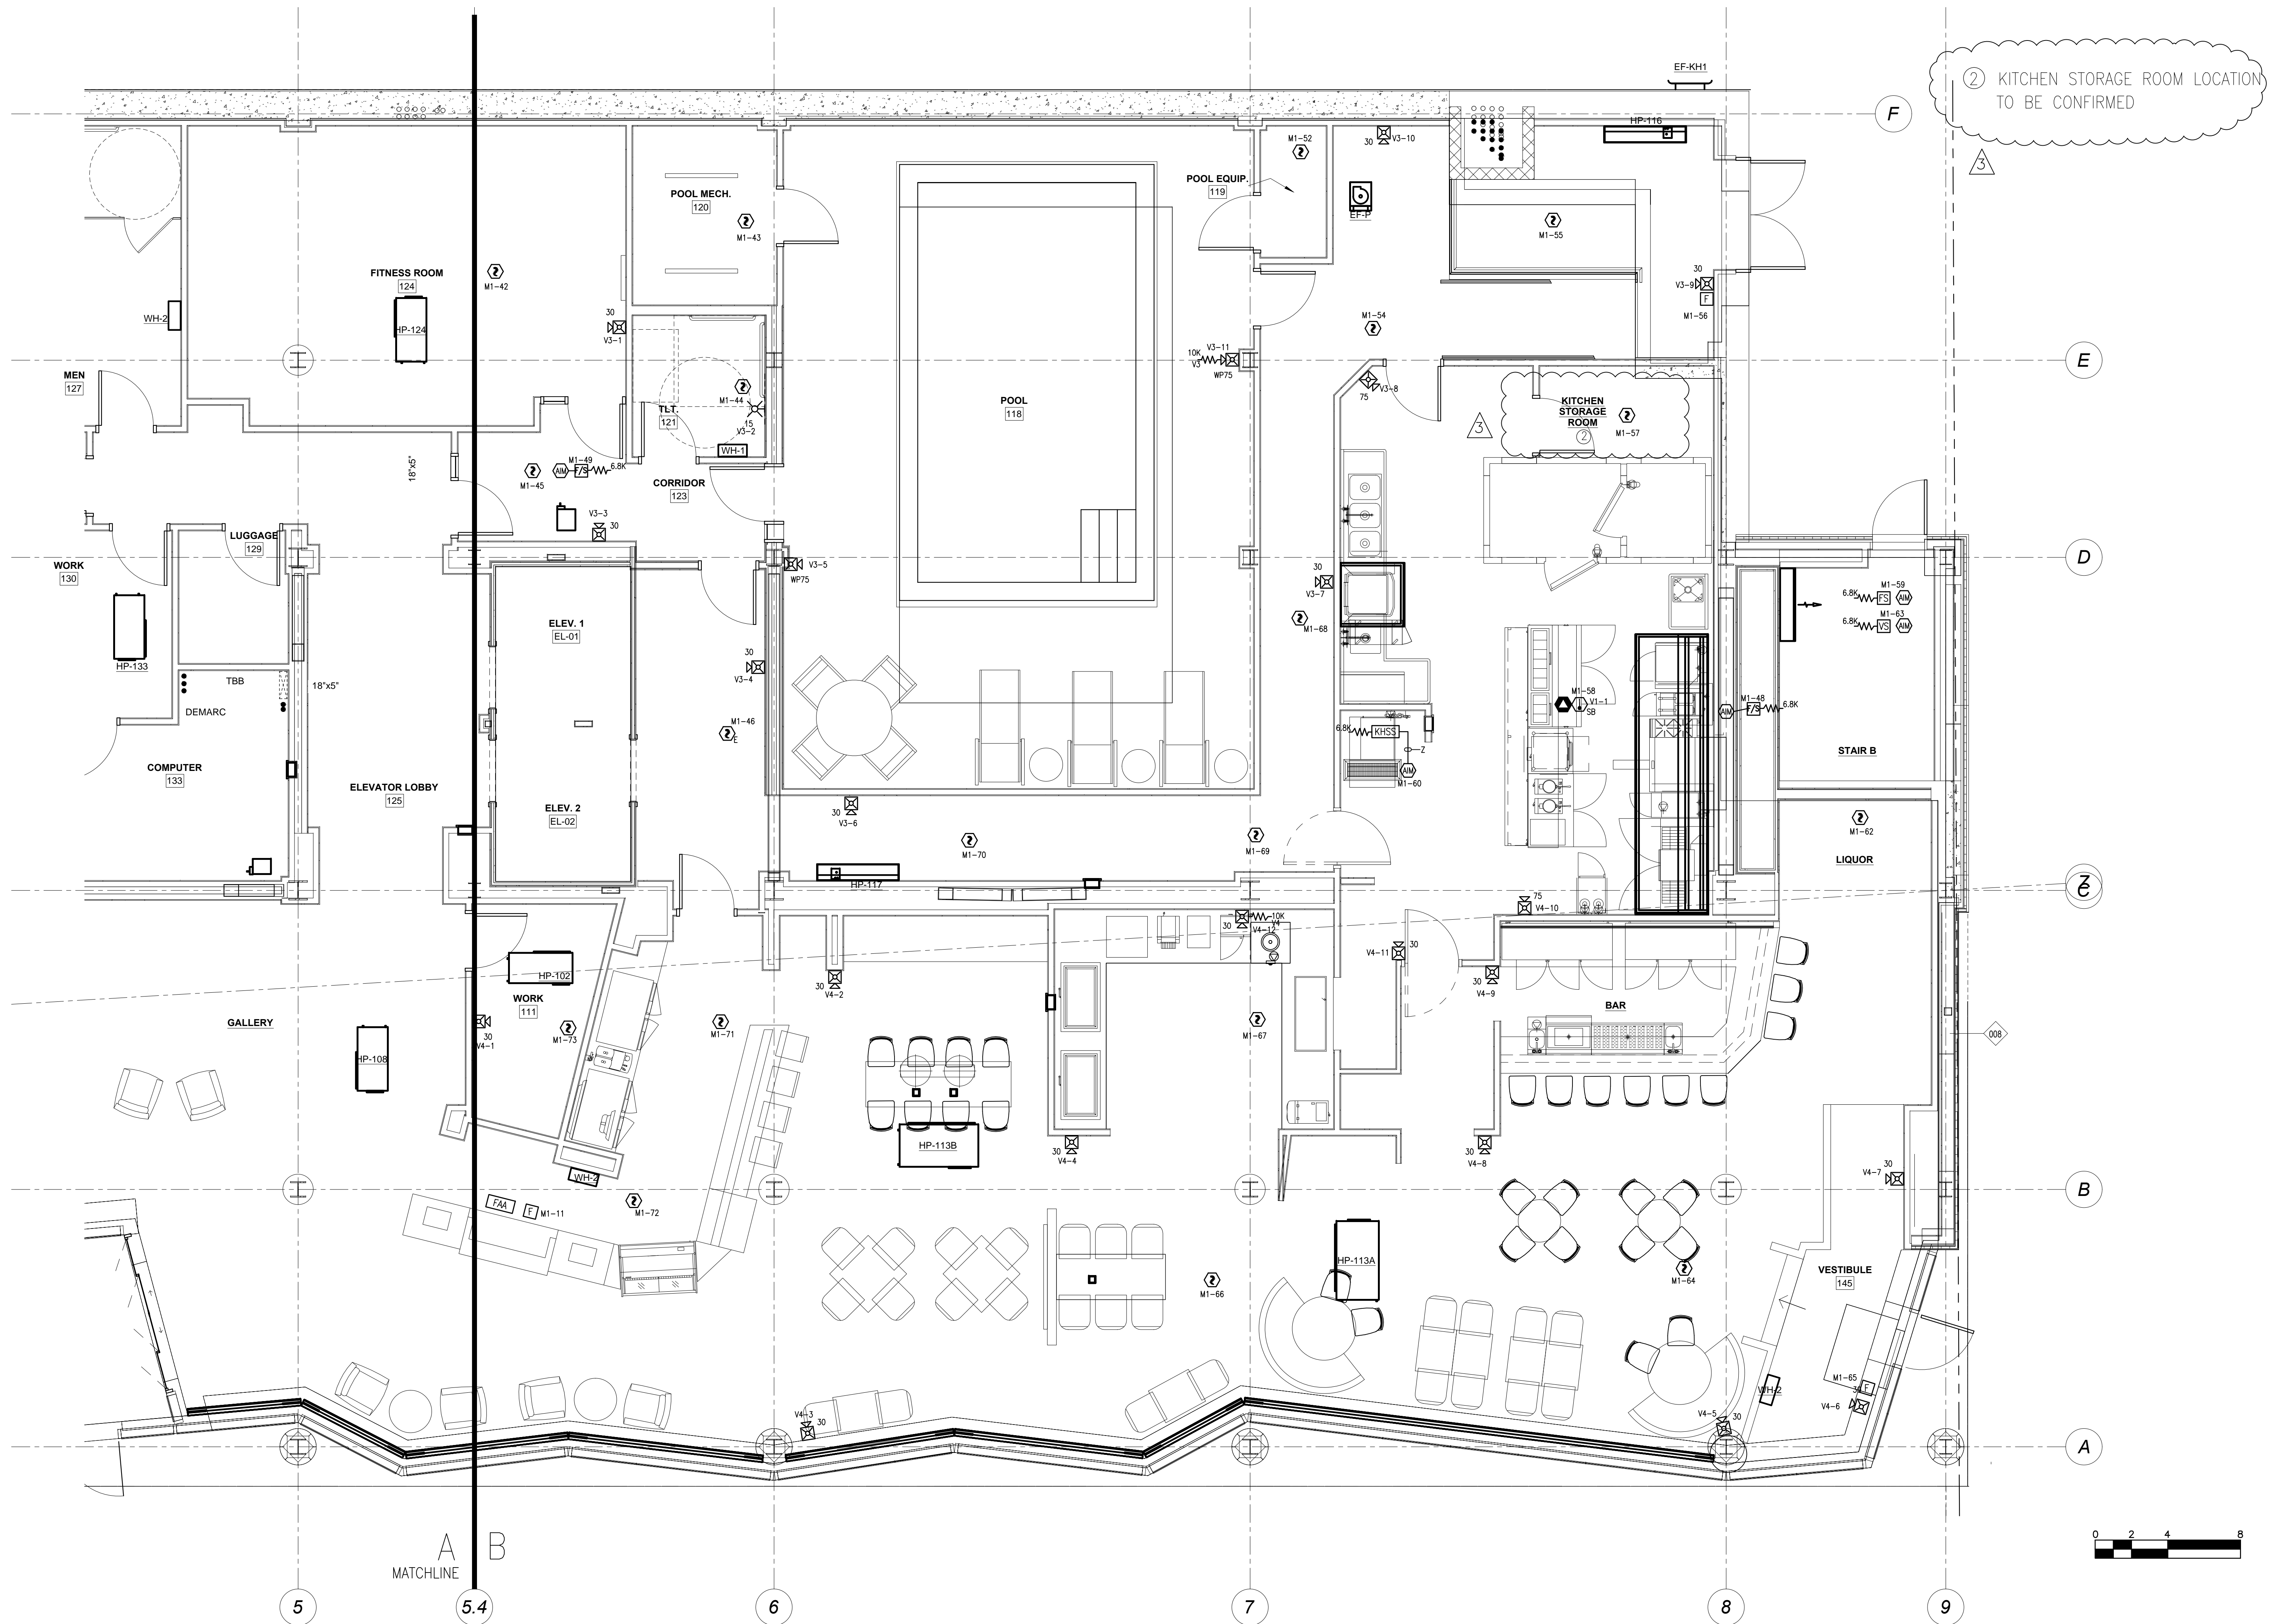

2 KITCHEN STORAGE ROOM LOCATION TO BE CONFIRMED

tyco SimplexGrinnell

20 THOMAS DRIVE
WESTBROOK, ME 04092
SALES: 207-842-6440
SERVICE: 207-842-6440
FAX: 207-842-6439

NO.	DATE	REVISION DESCRIPTION
1	8/14/13	REVISED PER ENGINEERS REVIEW COMMENTS DATED 7/19/13 & 8/5/13
2	9/10/13	REVISED PER SUBMITTAL REVIEW DATED 8/29/13
3	10/07/13	REVISED PER SUBMITTAL REVIEW DATED 10/1/13

CHG BY: JS
DATE: 8/14/13

CHG BY: SK
DATE: 9/10/13

CHG BY: SK
DATE: 10/07/13

PROJECT NUMBER: 971237001

SHEET TITLE: FIRE ALARM SYSTEM FIRST FLR PLAN PART B

SHEET NUMBER: FA-102

FA-101.dwg