


FILE PATH: P:\2013\147\Hyatt Place\REV 3\CAD\FA-103.dwg

LAST PRINTED: 2/10/2014 8:54:27 AM LAST SAVED BY: GLORION

24" x 36"

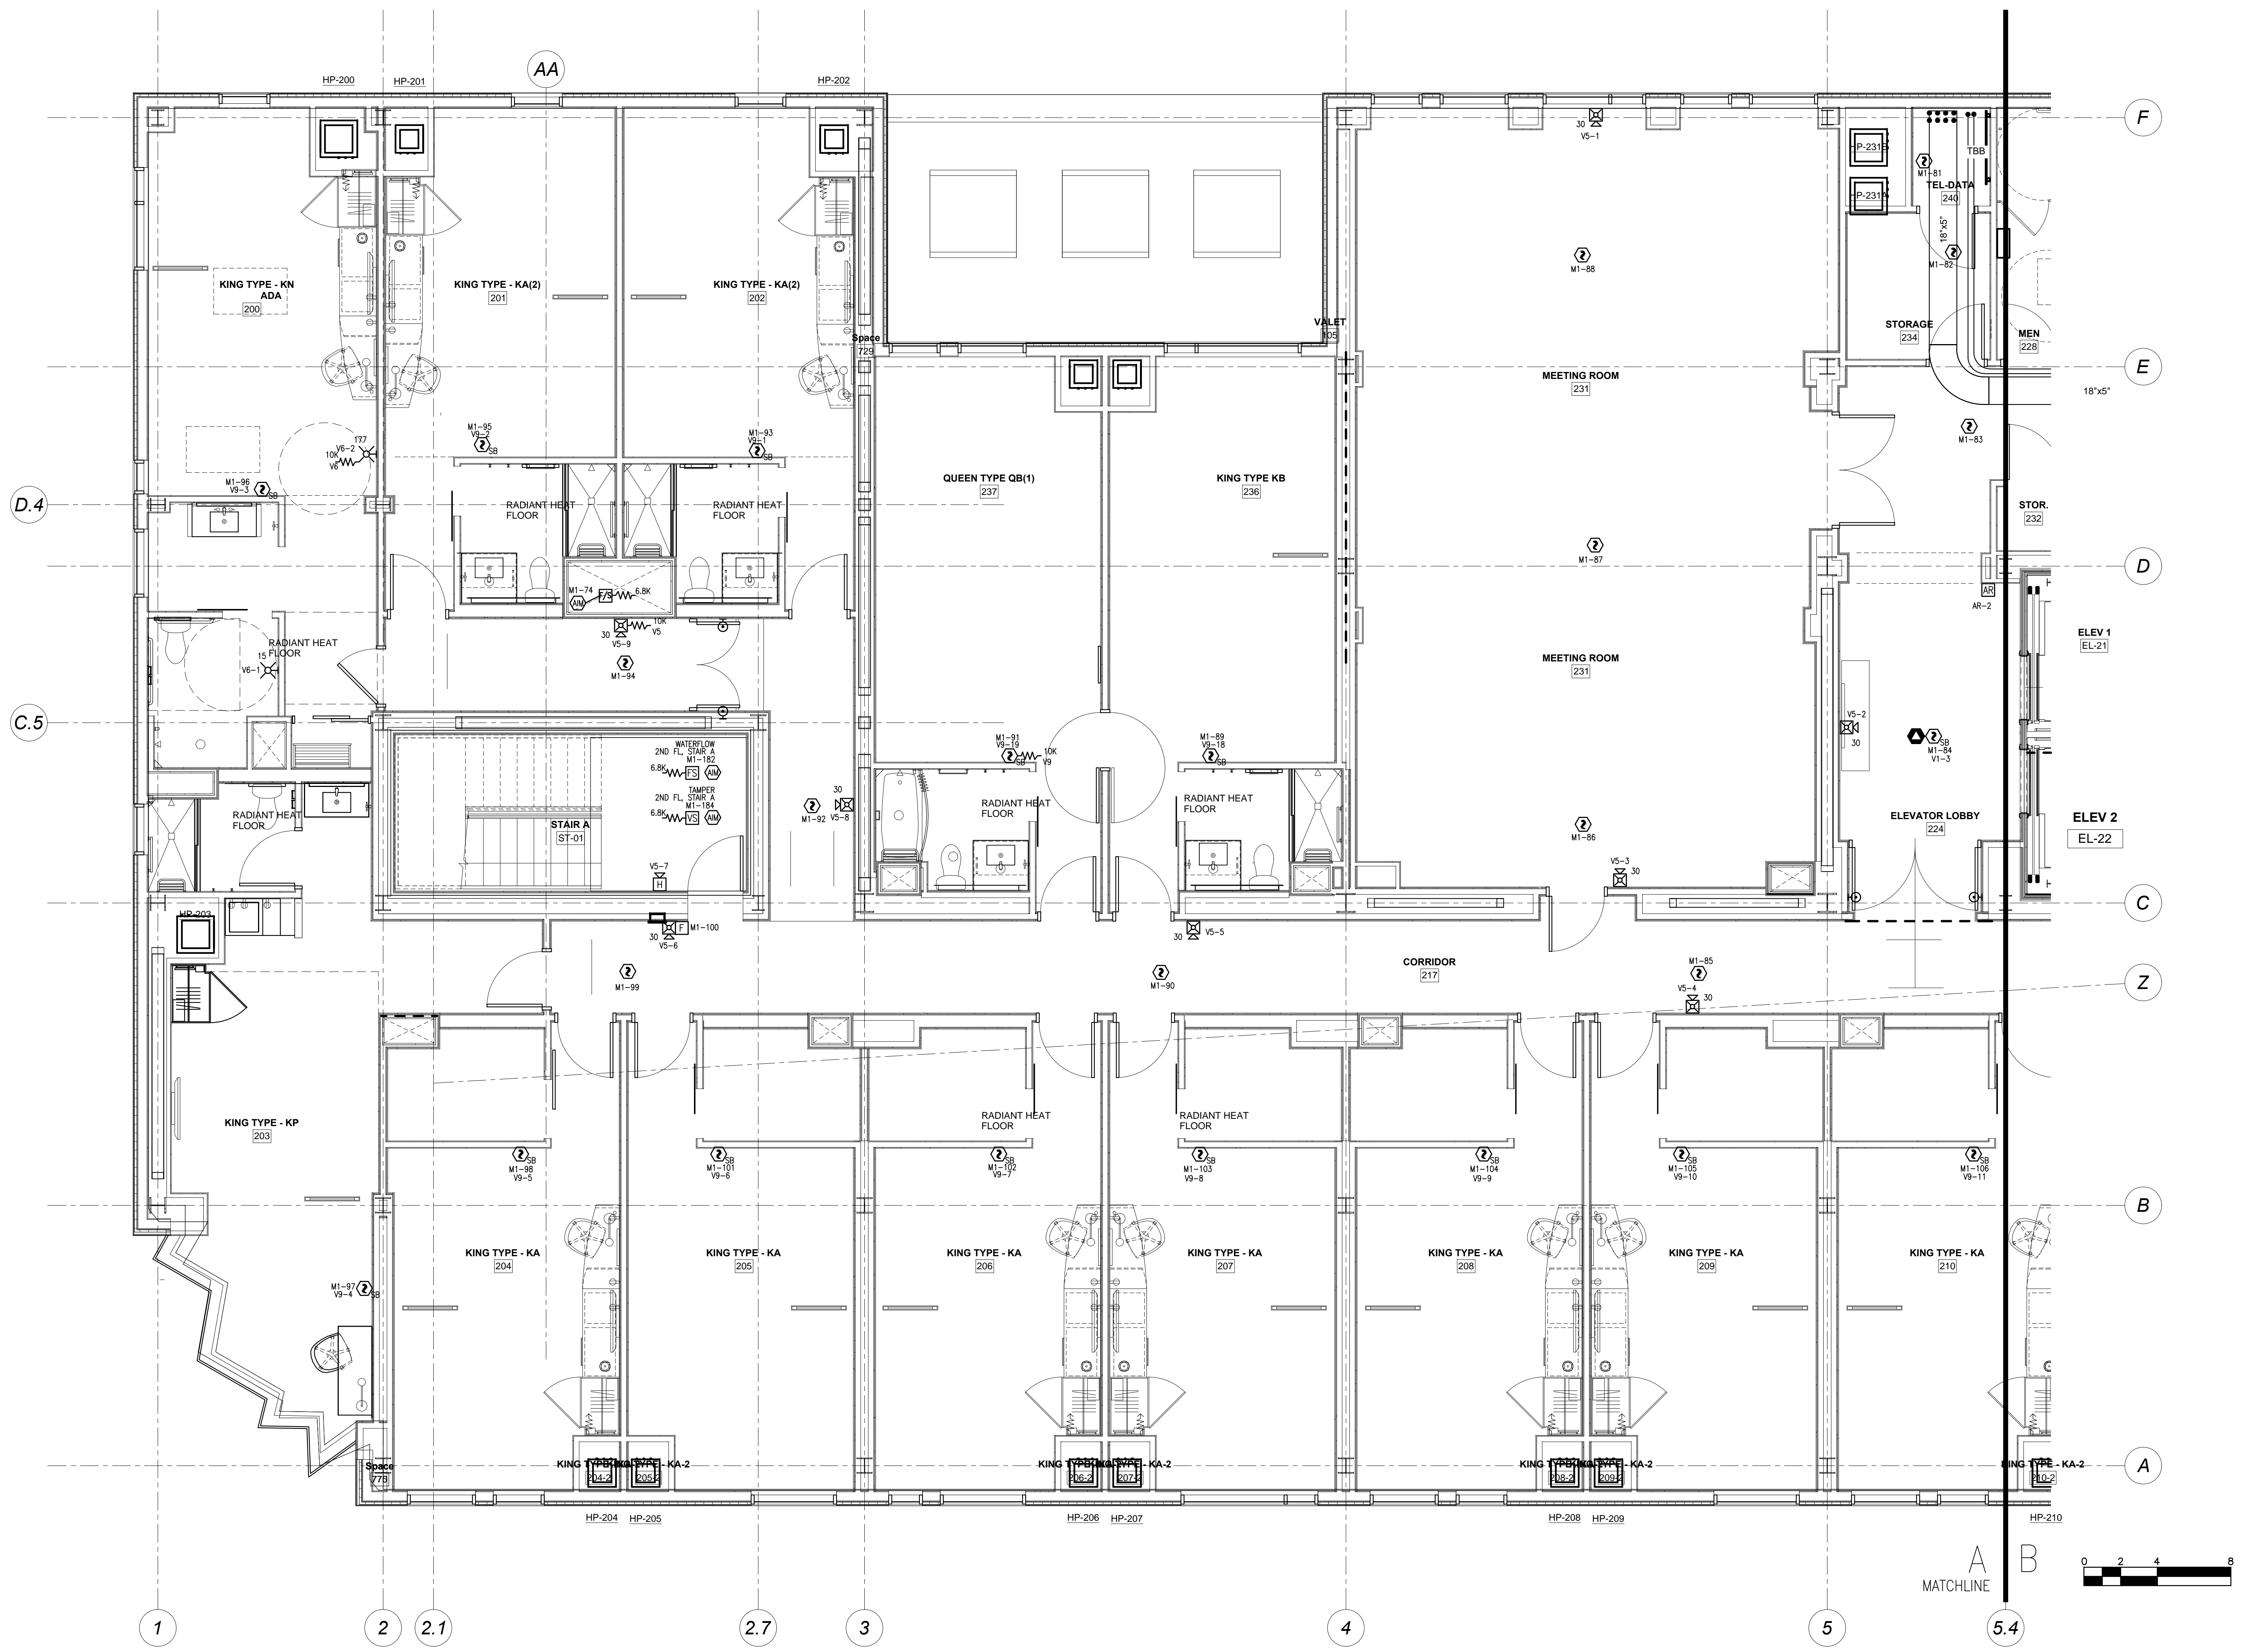

**tyco**  
SimplexGrinnell

20 THOMAS DRIVE  
WESTBROOK, ME 04092  
SALES: 207-842-6440  
SERVICE: 207-842-6440  
FAX: 207-842-6439

© 2013 SIMPLEXGRINNELL, LP  
ALL RIGHTS RESERVED

NO.	DATE	REVISION DESCRIPTION
1	8/14/13	REVISED PER ENGINEERS REVIEW COMMENTS DATED 7/19/13 & 8/5/13
2	9/10/13	REVISED PER SUBMITTAL REVIEW DATED 8/29/13
3	10/07/13	REVISED PER SUBMITTAL REVIEW DATED 10/1/13

FIRE ALARM & AREA OF REFUGE SYSTEMS  
SECOND FLOOR PLAN PART A  
HYATT PLACE PORTLAND-OLD PORT  
433 FORE STREET  
PORTLAND, ME

DRAWN BY: LORION DATE: 6/14/13

CHECKED BY: KALAFARSKI DATE: 7/12/13

PROJECT NUMBER: 971237001

SHEET TITLE: FIRE ALARM SYSTEM SECOND FLR PLAN PART A

SHEET NUMBER: FA-103