


FILE PATH: P:\2013\147\Hyatt Place\REV 3\CAD\FA-104.dwg

LAST PRINTED: 2/10/2014 8:54:37 AM LAST SAVED BY: GLORION

24" x 36"

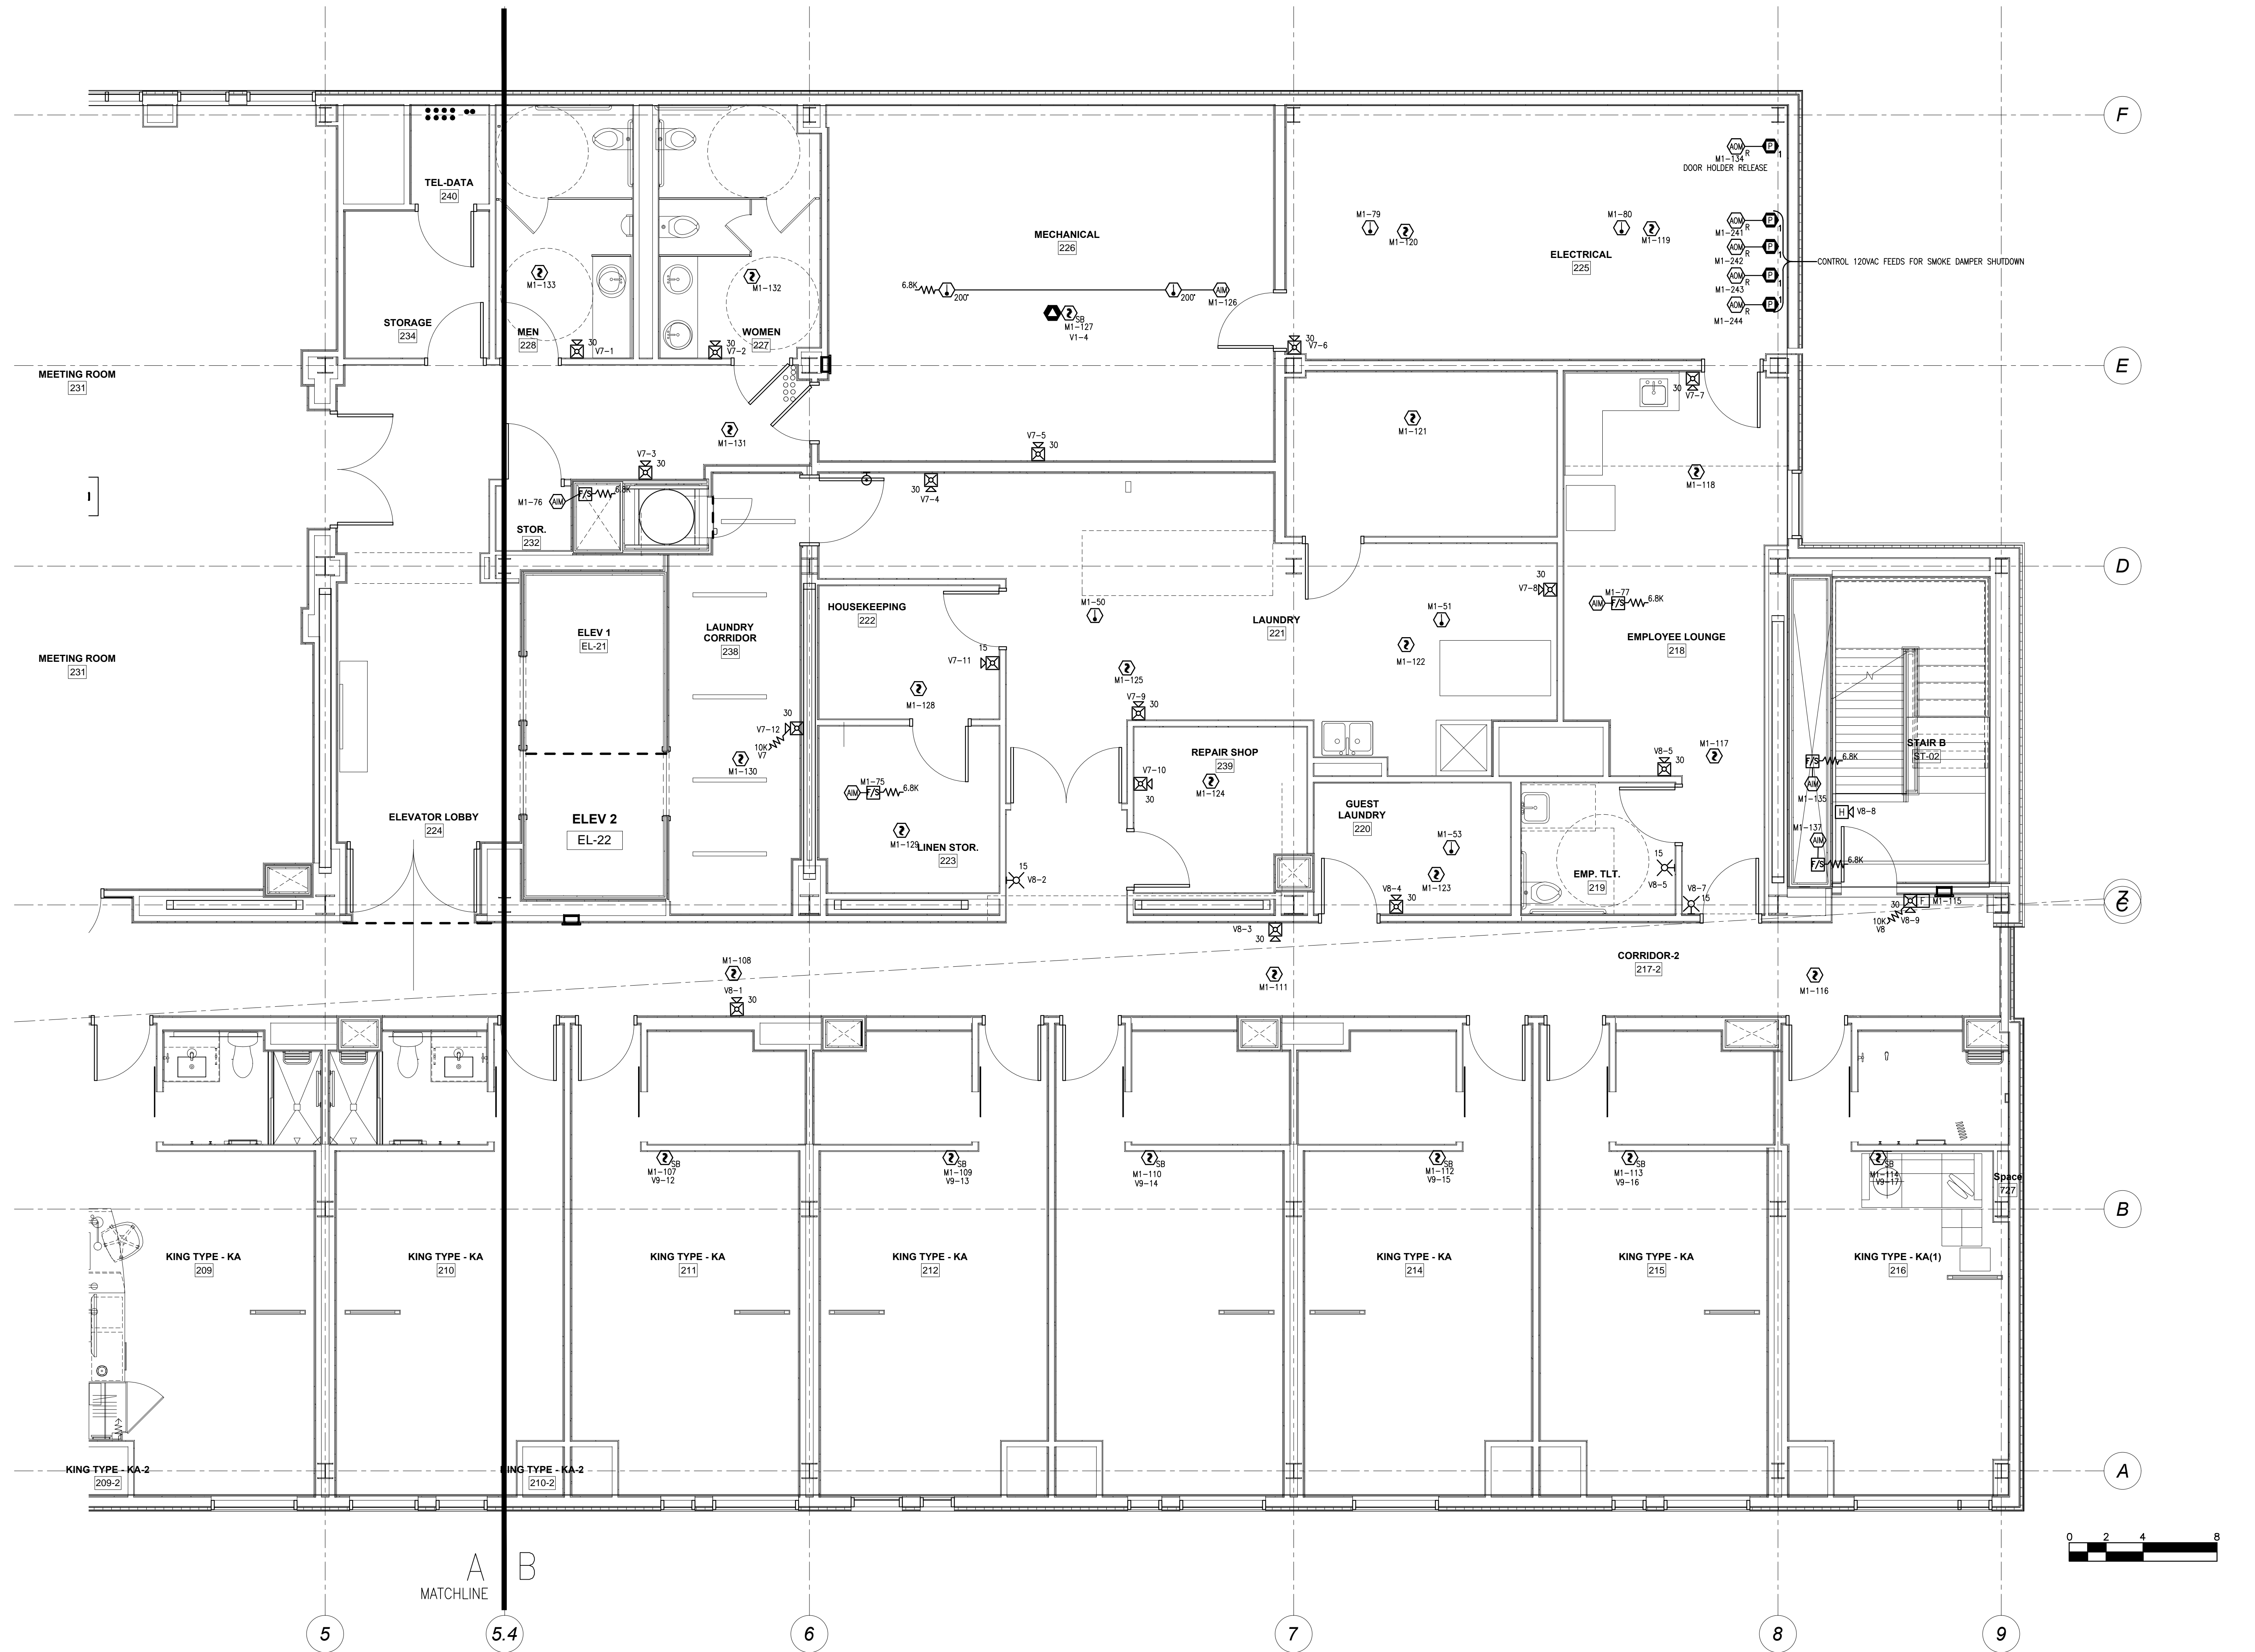

tyco
SimplexGrinnell

20 THOMAS DRIVE
WESTBROOK, ME 04092
SALES: 207-842-6440
SERVICE: 207-842-6440
FAX: 207-842-6439
© 2013 SIMPLEXGRINNELL, LP
ALL RIGHTS RESERVED

NO.	DATE	REVISION DESCRIPTION
1	8/14/13	REVISED PER ENGINEERS REVIEW COMMENTS DATED 7/19/13 & 8/5/13
2	9/10/13	REVISED PER SUBMITTAL REVIEW DATED 8/29/13
3	10/07/13	REVISED PER SUBMITTAL REVIEW DATED 10/1/13

FIRE ALARM & AREA OF REFUGE SYSTEMS
SECOND FLOOR PLAN PART B
HYATT PLACE PORTLAND-OLD PORT
433 FORE STREET
PORTLAND, ME

DRAWN BY: LORION	DATE: 6/14/13
CHECKED BY: KALAFARSKI	DATE: 7/12/13
PROJECT NUMBER: 971237001	
SHEET TITLE: FIRE ALARM SYSTEM SECOND FLR PLAN PART B	
SHEET NUMBER: FA-104	