


FILE PATH: P:\2013\147\Hyatt Place\REV 3\REV 3 CAD\FA-105.dwg

LAST PRINTED: 2/10/2014 8:54:41 AM LAST SAVED BY: GLORION

24" x 36"

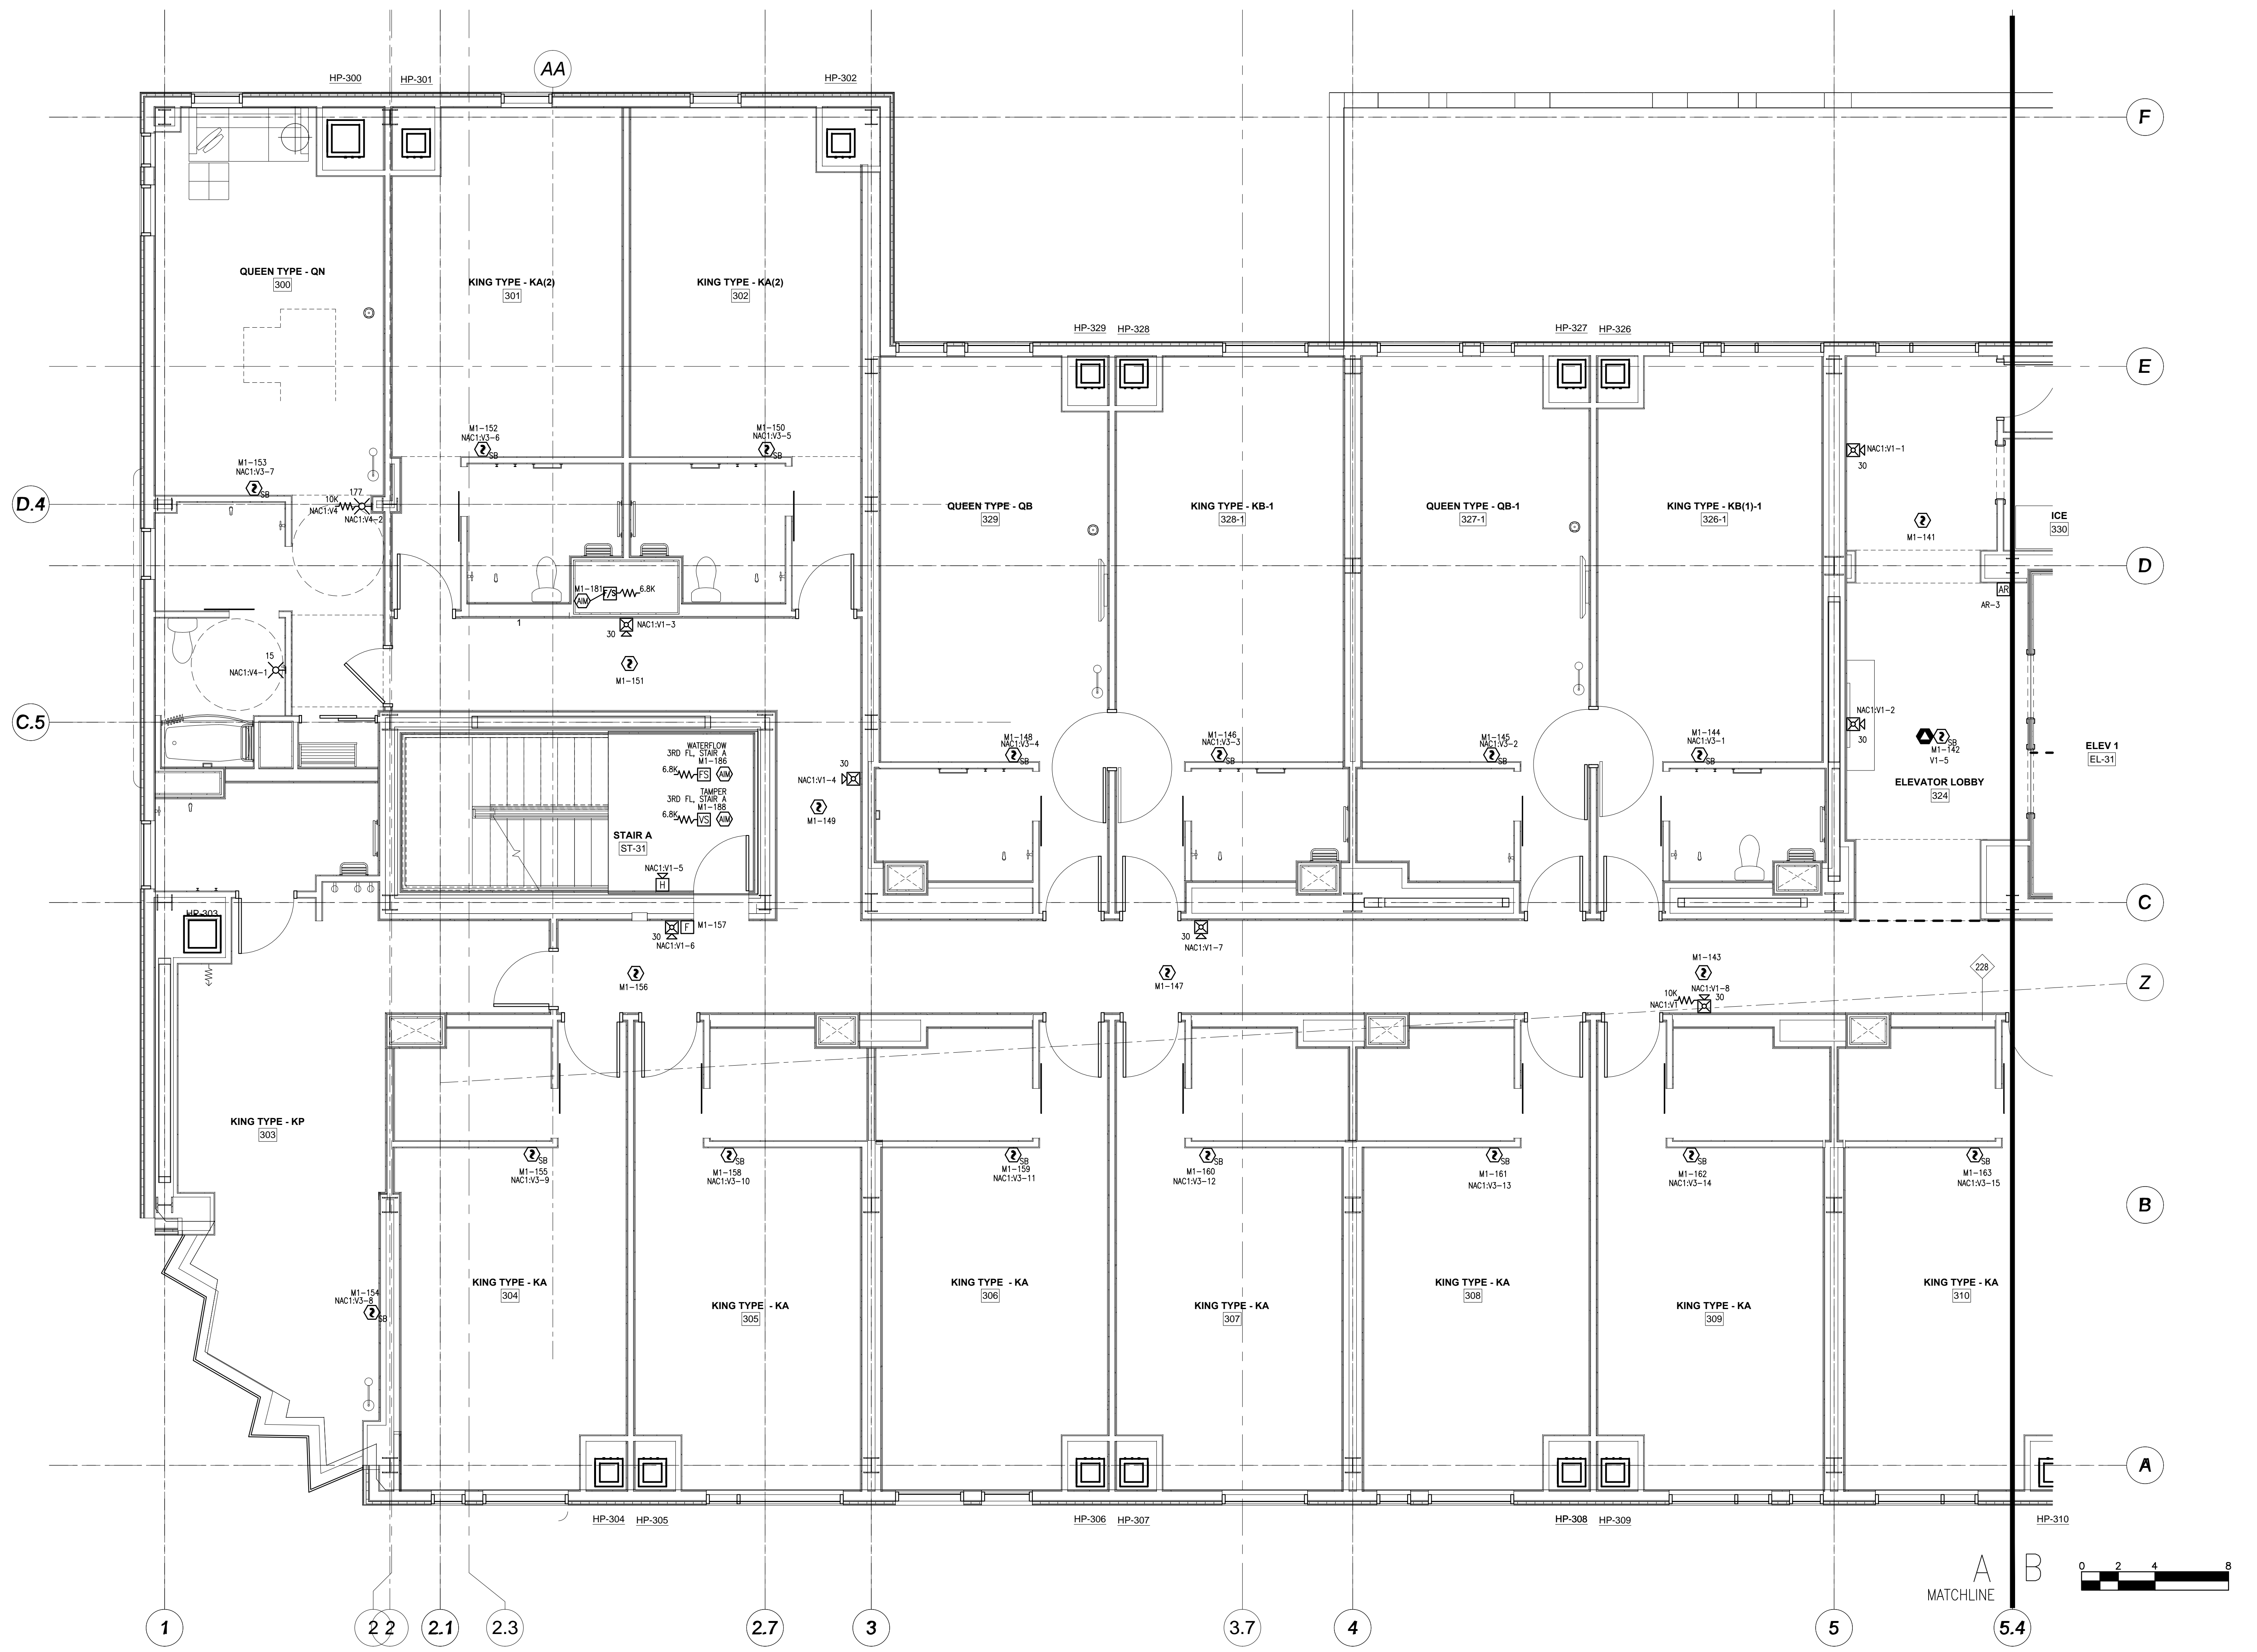

tyco
SimplexGrinnell

20 THOMAS DRIVE
WESTBROOK, ME 04092
SALES: 207-842-6440
SERVICE: 207-842-6440
FAX: 207-842-6439

© 2013 TYCO ENVIRONMENTAL LP
ALL RIGHTS RESERVED

| NO. | DATE | REVISION DESCRIPTION |
|-----|----------|--|
| 1 | 8/14/13 | REVISED PER ENGINEERS REVIEW COMMENTS DATED 7/19/13 & 8/5/13 |
| 2 | 9/10/13 | REVISED PER SUBMITTAL REVIEW DATED 8/29/13 |
| 3 | 10/07/13 | REVISED PER SUBMITTAL REVIEW DATED 10/1/13 |

FIRE ALARM & AREA OF REFUGE SYSTEMS
THIRD FLOOR PLAN PART A
HYATT PLACE PORTLAND - OLD PORT
433 FORE STREET
PORTLAND, ME

DRAWN BY: LORION DATE: 6/14/13
CHECKED BY: KALAFARSKI DATE: 7/12/13
PROJECT NUMBER: 971237001
SHEET TITLE: FIRE ALARM SYSTEM
THIRD FLR PLAN PART A
SHEET NUMBER: FA-105