 



FILE PATH: P:\2013\147\Hyatt Place\REV 3\REV 3 CAD\FA-106.dwg

LAST PRINTED: 2/10/2014 8:54:45 AM LAST SAVED BY: GLORION

24" x 36"

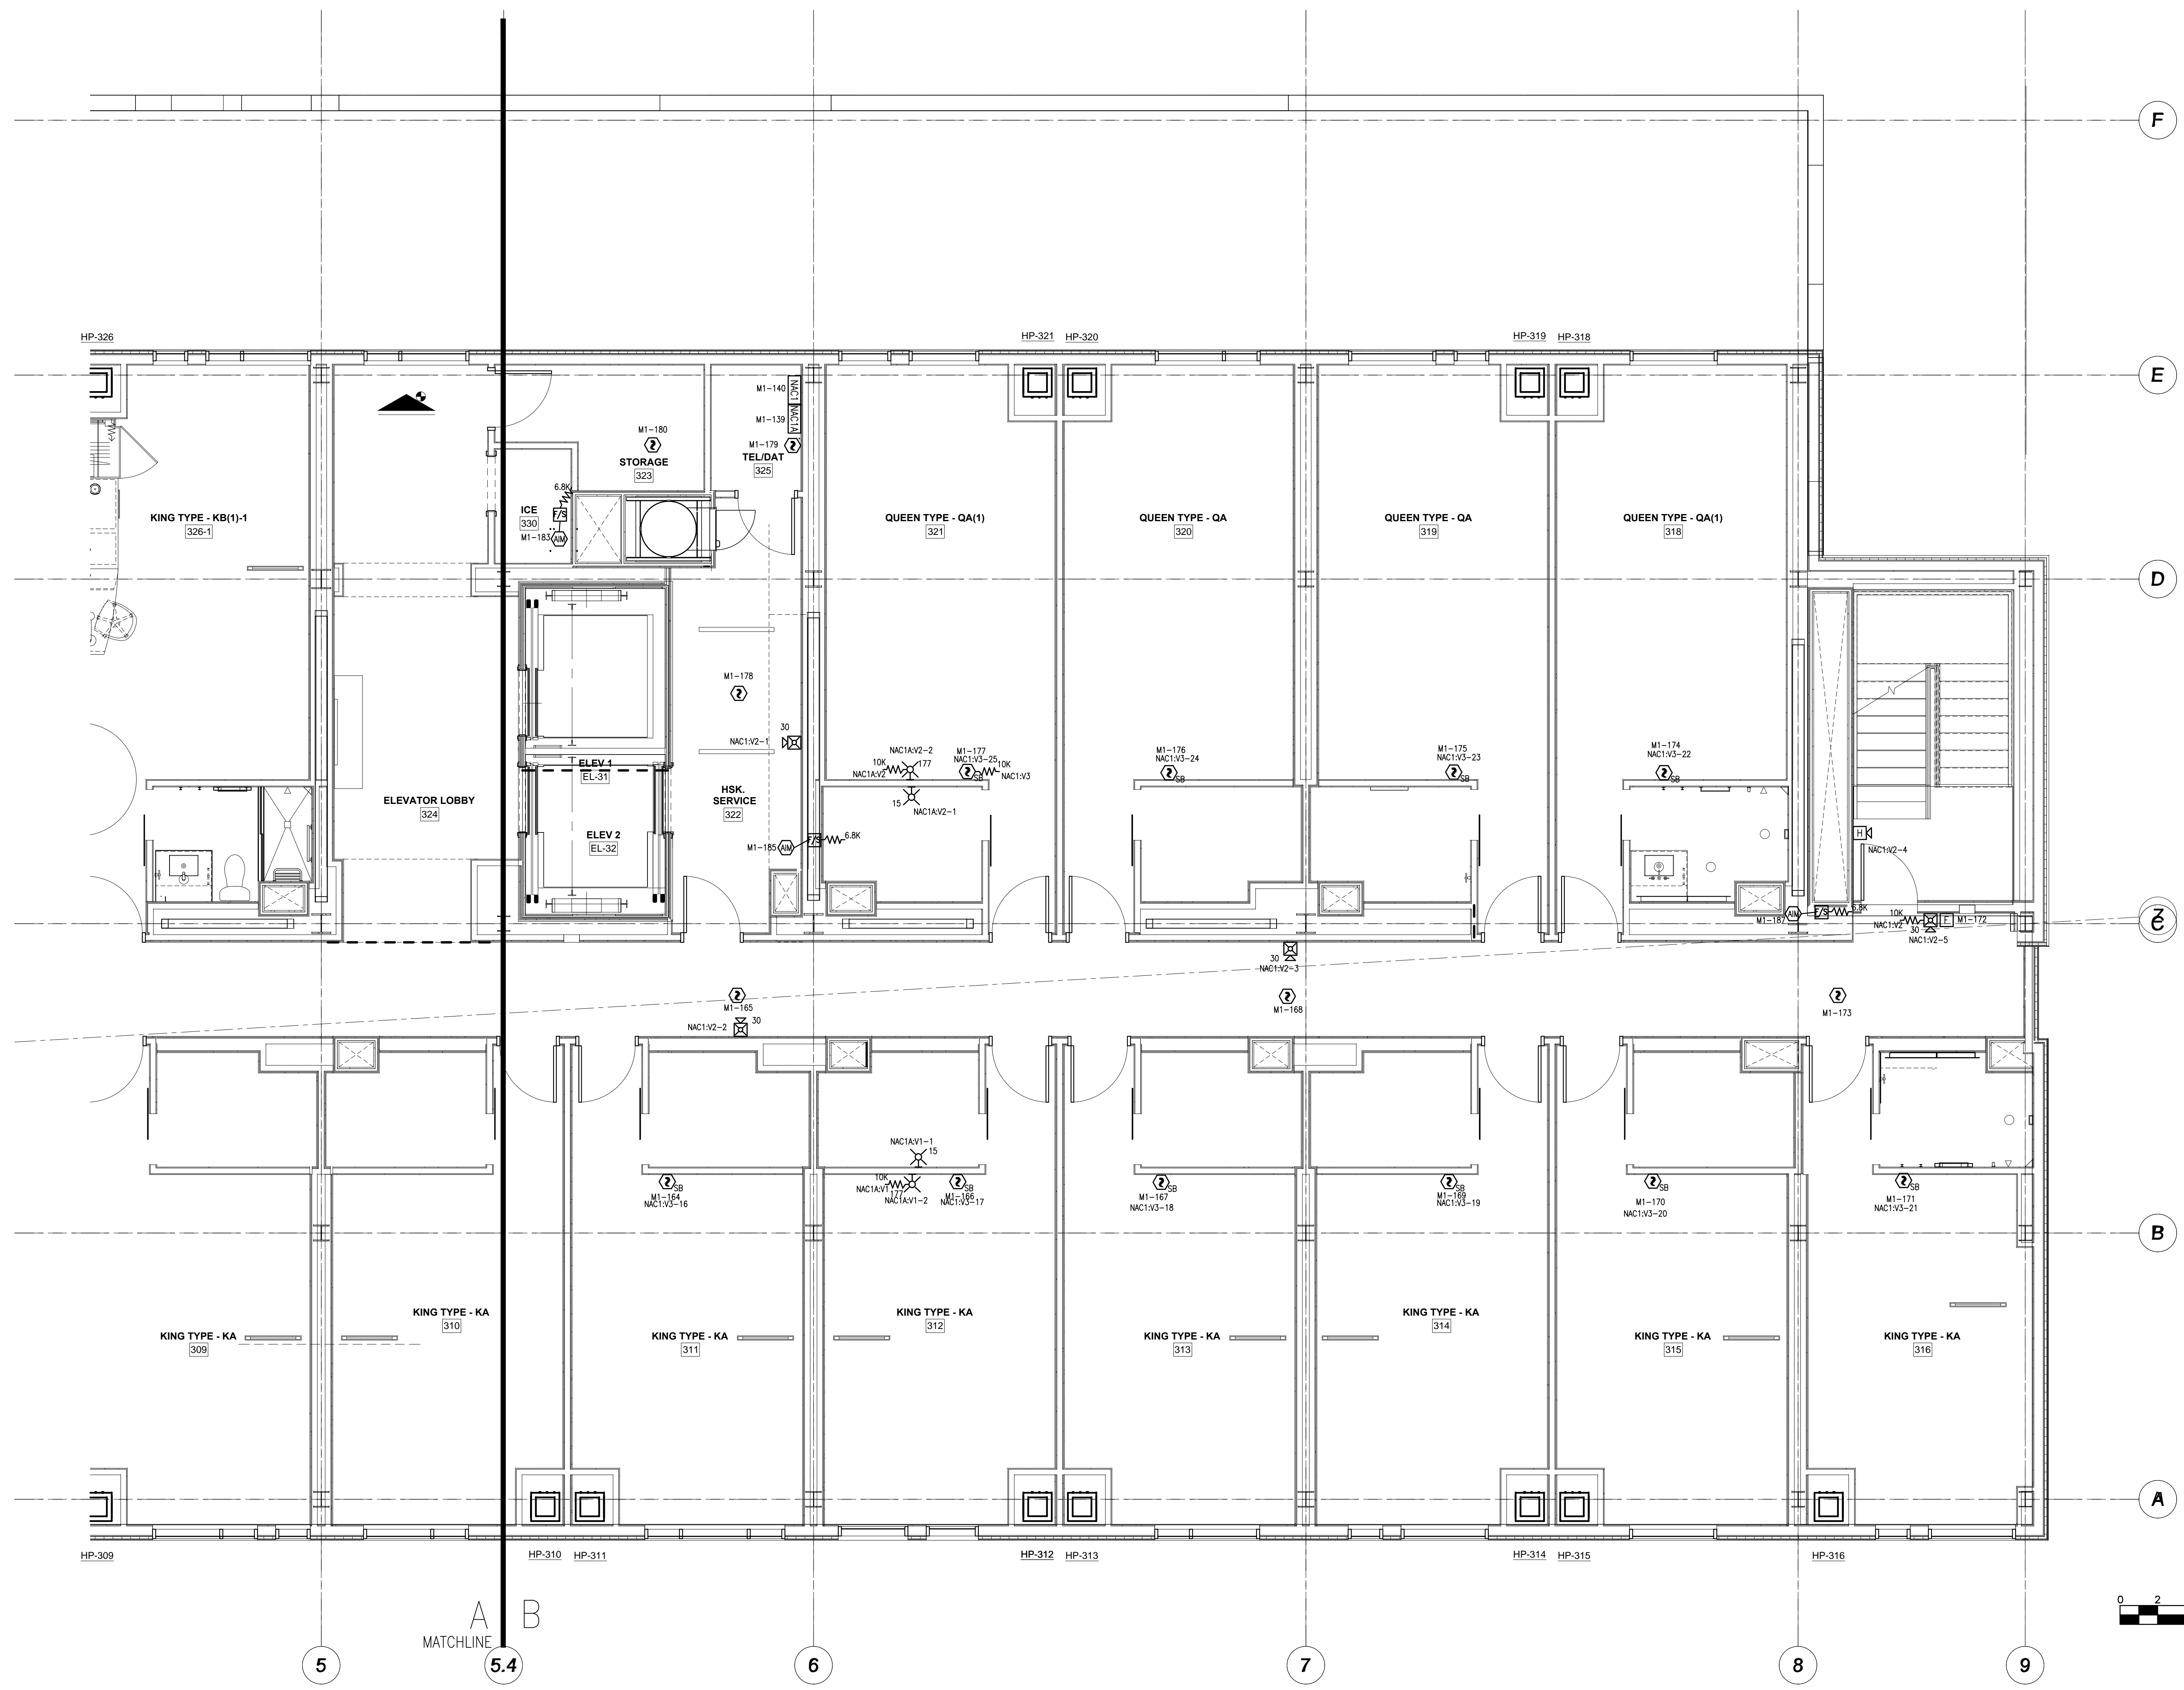

| | | | |
|--|---|--|---|
| | | 20 THOMAS DRIVE WESTBROOK, ME 04092 SALES: 207-842-6440 SERVICE: 207-842-6440 FAX: 207-842-6439 © 2013 SIMPLEXGRINNELL, LP ALL RIGHTS RESERVED | |
| | | CHG BY: JS DATE: 8/14/13 NO. 2 | REVISION DESCRIPTION: REVISED PER ENGINEERS REVIEW COMMENTS DATED 7/19/13 & 8/5/13 REVISED PER SUBMITTAL REVIEW DATED 8/29/13 |
| FIRE ALARM & AREA OF REFUGE SYSTEMS THIRD FLOOR PLAN PART B HYATT PLACE PORTLAND - OLD PORT 433 FORE STREET PORTLAND, ME | | CHG BY: SK DATE: 10/07/13 NO. 3 | REVISION DESCRIPTION: REVISED PER SUBMITTAL REVIEW DATED 10/1/13 |
| DRAWN BY: LORION DATE: 6/14/13 | CHECKED BY: KALAFARSKI DATE: 7/12/13 | PROJECT NUMBER: 971237001 | SHEET TITLE: FIRE ALARM SYSTEM THIRD FLR PLAN PART B |
| SHEET NUMBER: FA-106 | | FA-106.dwg | |