


FILE PATH: P:\2013\147\Hyatt Place\REV 3\REV 3 CAD\FA-107.dwg

LAST PRINTED: 2/10/2014 8:54:48 AM LAST SAVED BY: GLORION

24" x 36"

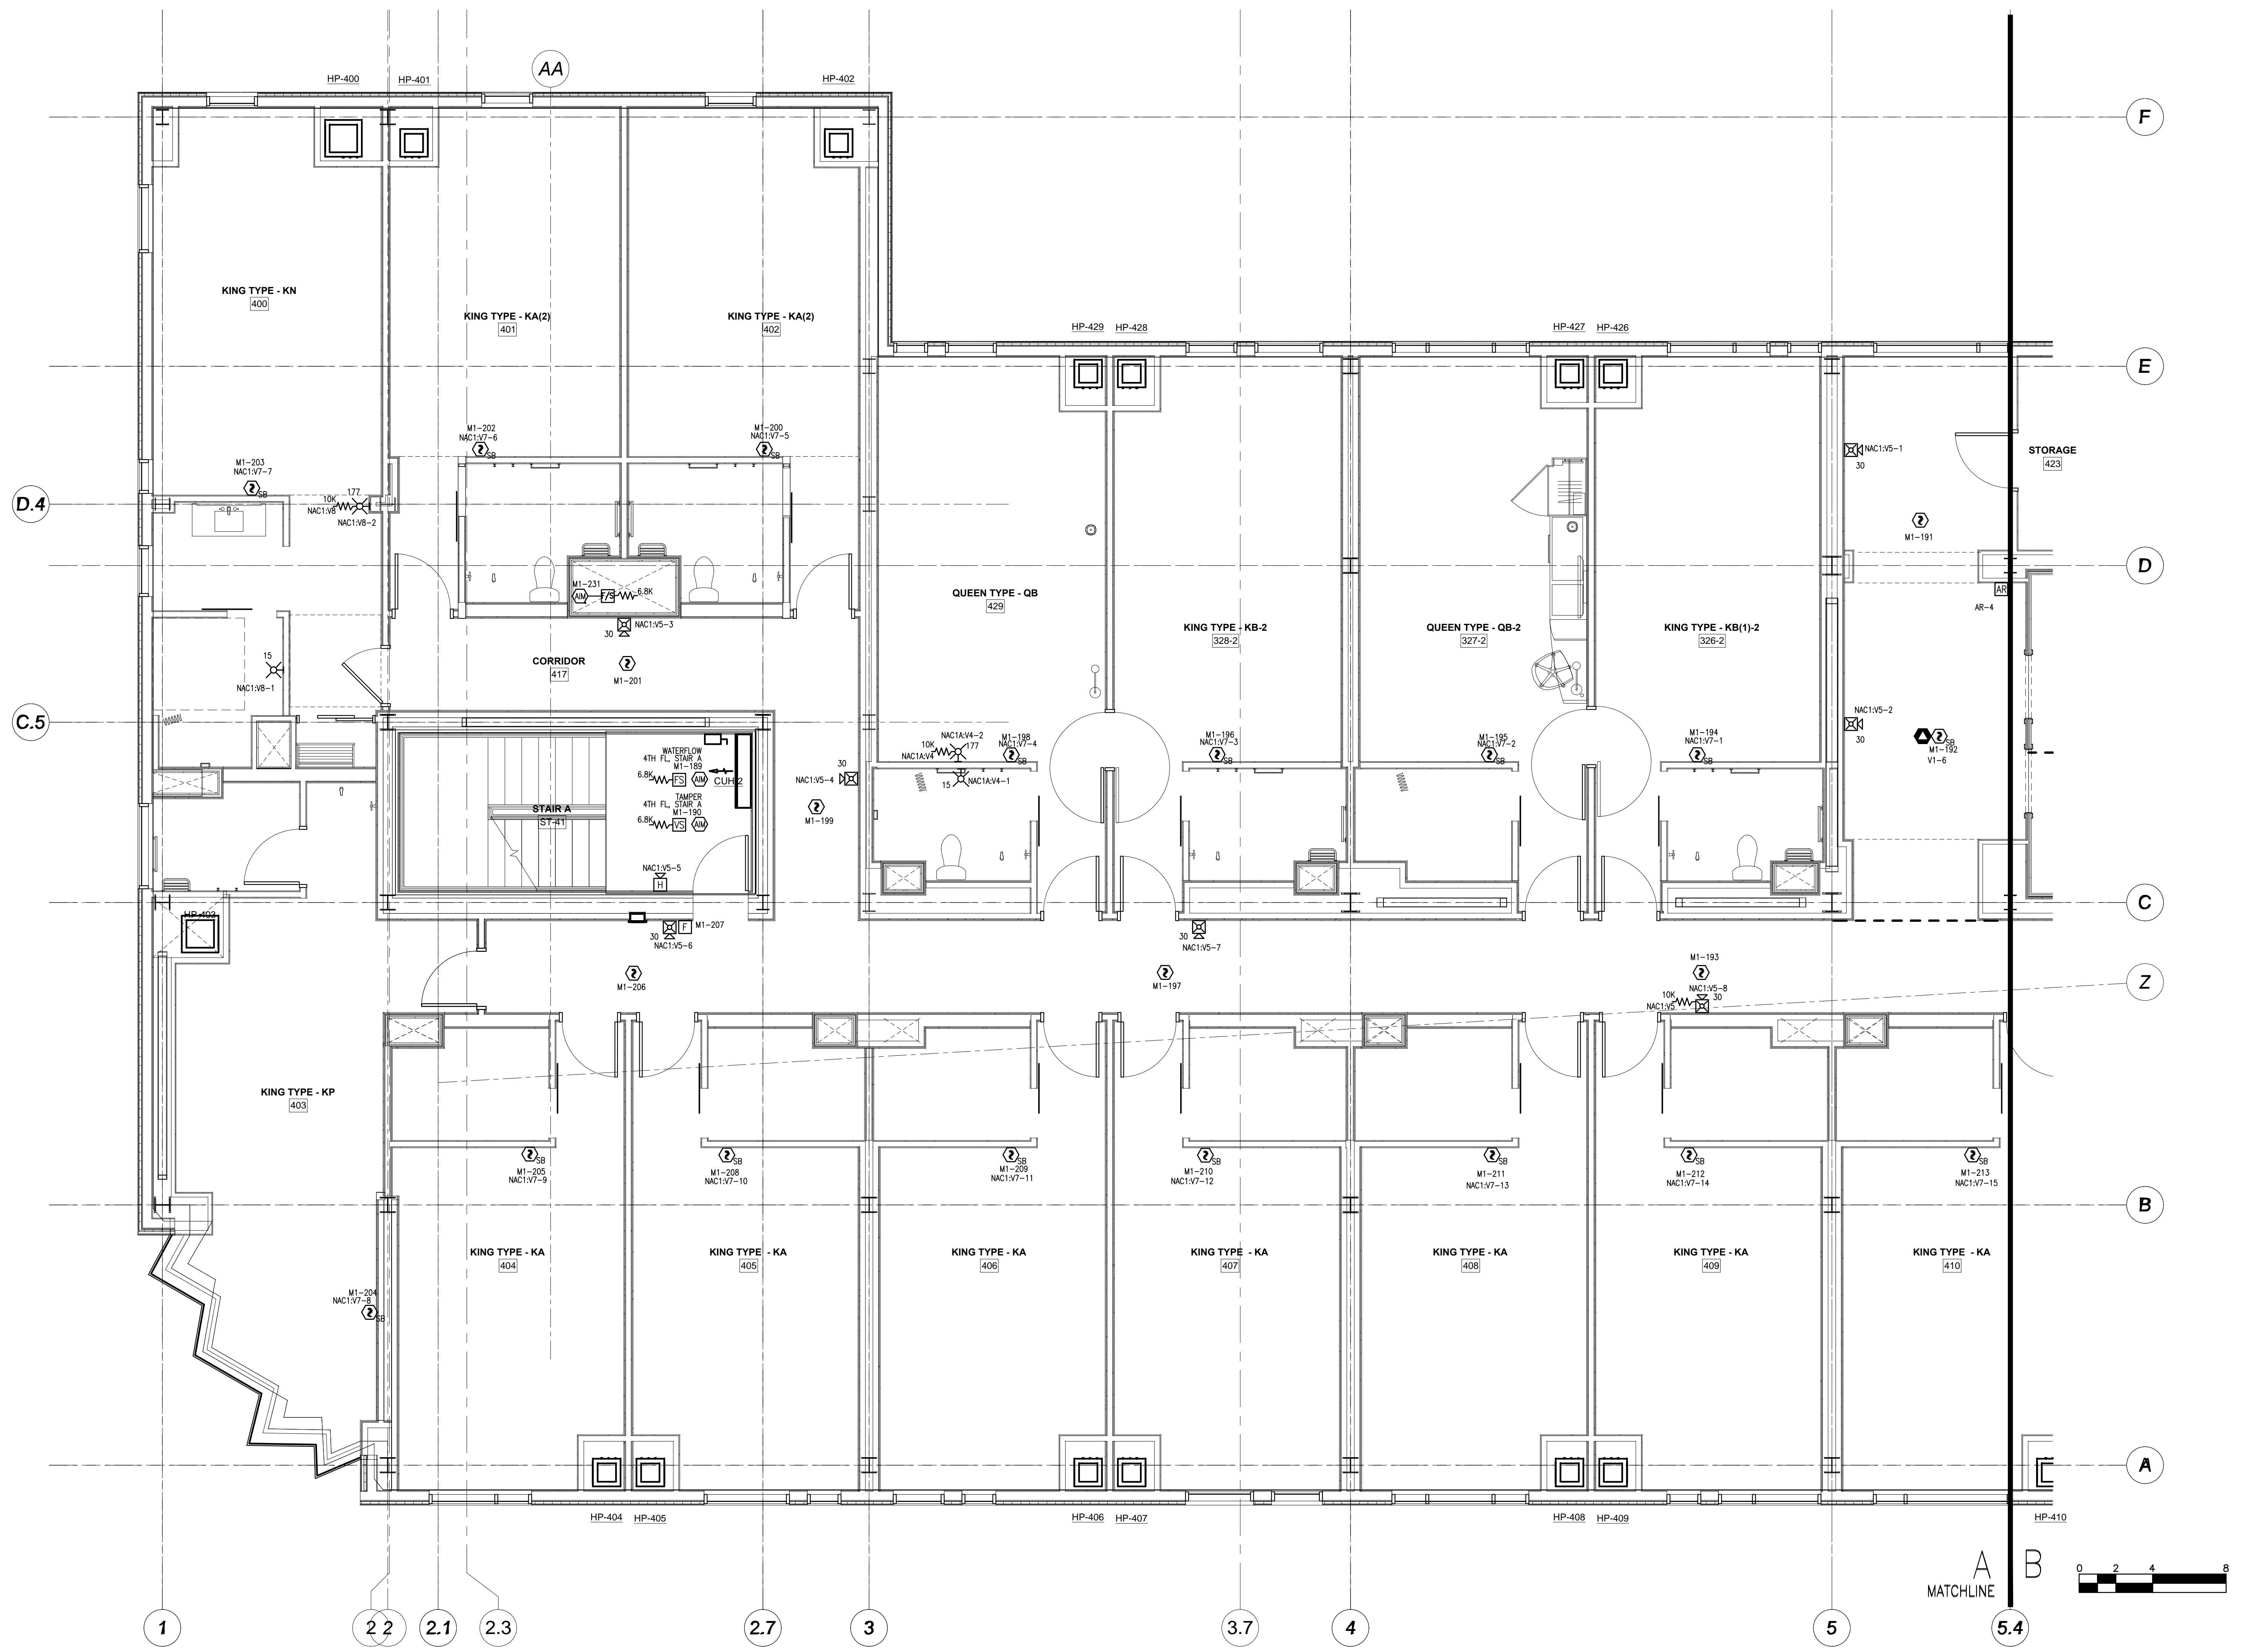

tyco
SimplexGrinnell

20 THOMAS DRIVE
WESTBROOK, ME 04092
SALES: 207-842-6440
SERVICE: 207-842-6440
FAX: 207-842-6439

NO.	DATE	REVISION DESCRIPTION
1	8/14/13	REVISED PER ENGINEERS REVIEW COMMENTS DATED 7/19/13 & 8/5/13
2	9/10/13	REVISED PER SUBMITTAL REVIEW DATED 8/29/13
3	10/07/13	REVISED PER SUBMITTAL REVIEW DATED 10/1/13

<p>CREATED BY: JS</p> <p>CHECKED BY: KALAFARSKI</p> <p>PROJECT NUMBER: 971237001</p> <p>SHEET NUMBER: FA-107</p>	<p>DATE: 6/14/13</p> <p>DATE: 7/12/13</p> <p>SHEET TITLE: FIRE ALARM SYSTEM FOURTH FLR PLAN PART A</p> <p>SHEET NUMBER: FA-107.dwg</p>
--	--

FIRE ALARM & AREA OF REFUGE SYSTEMS
FOURTH FLOOR PLAN PART A
HYATT PLACE PORTLAND - OLD PORT
 433 FORE STREET
 PORTLAND, ME