


FILE PATH: P:\2013\147\Hyatt Place\REV 3\CAD\FA-108.dwg

LAST PRINTED: 2/10/2014 8:54:52 AM LAST SAVED BY: GLORION

24" x 36"

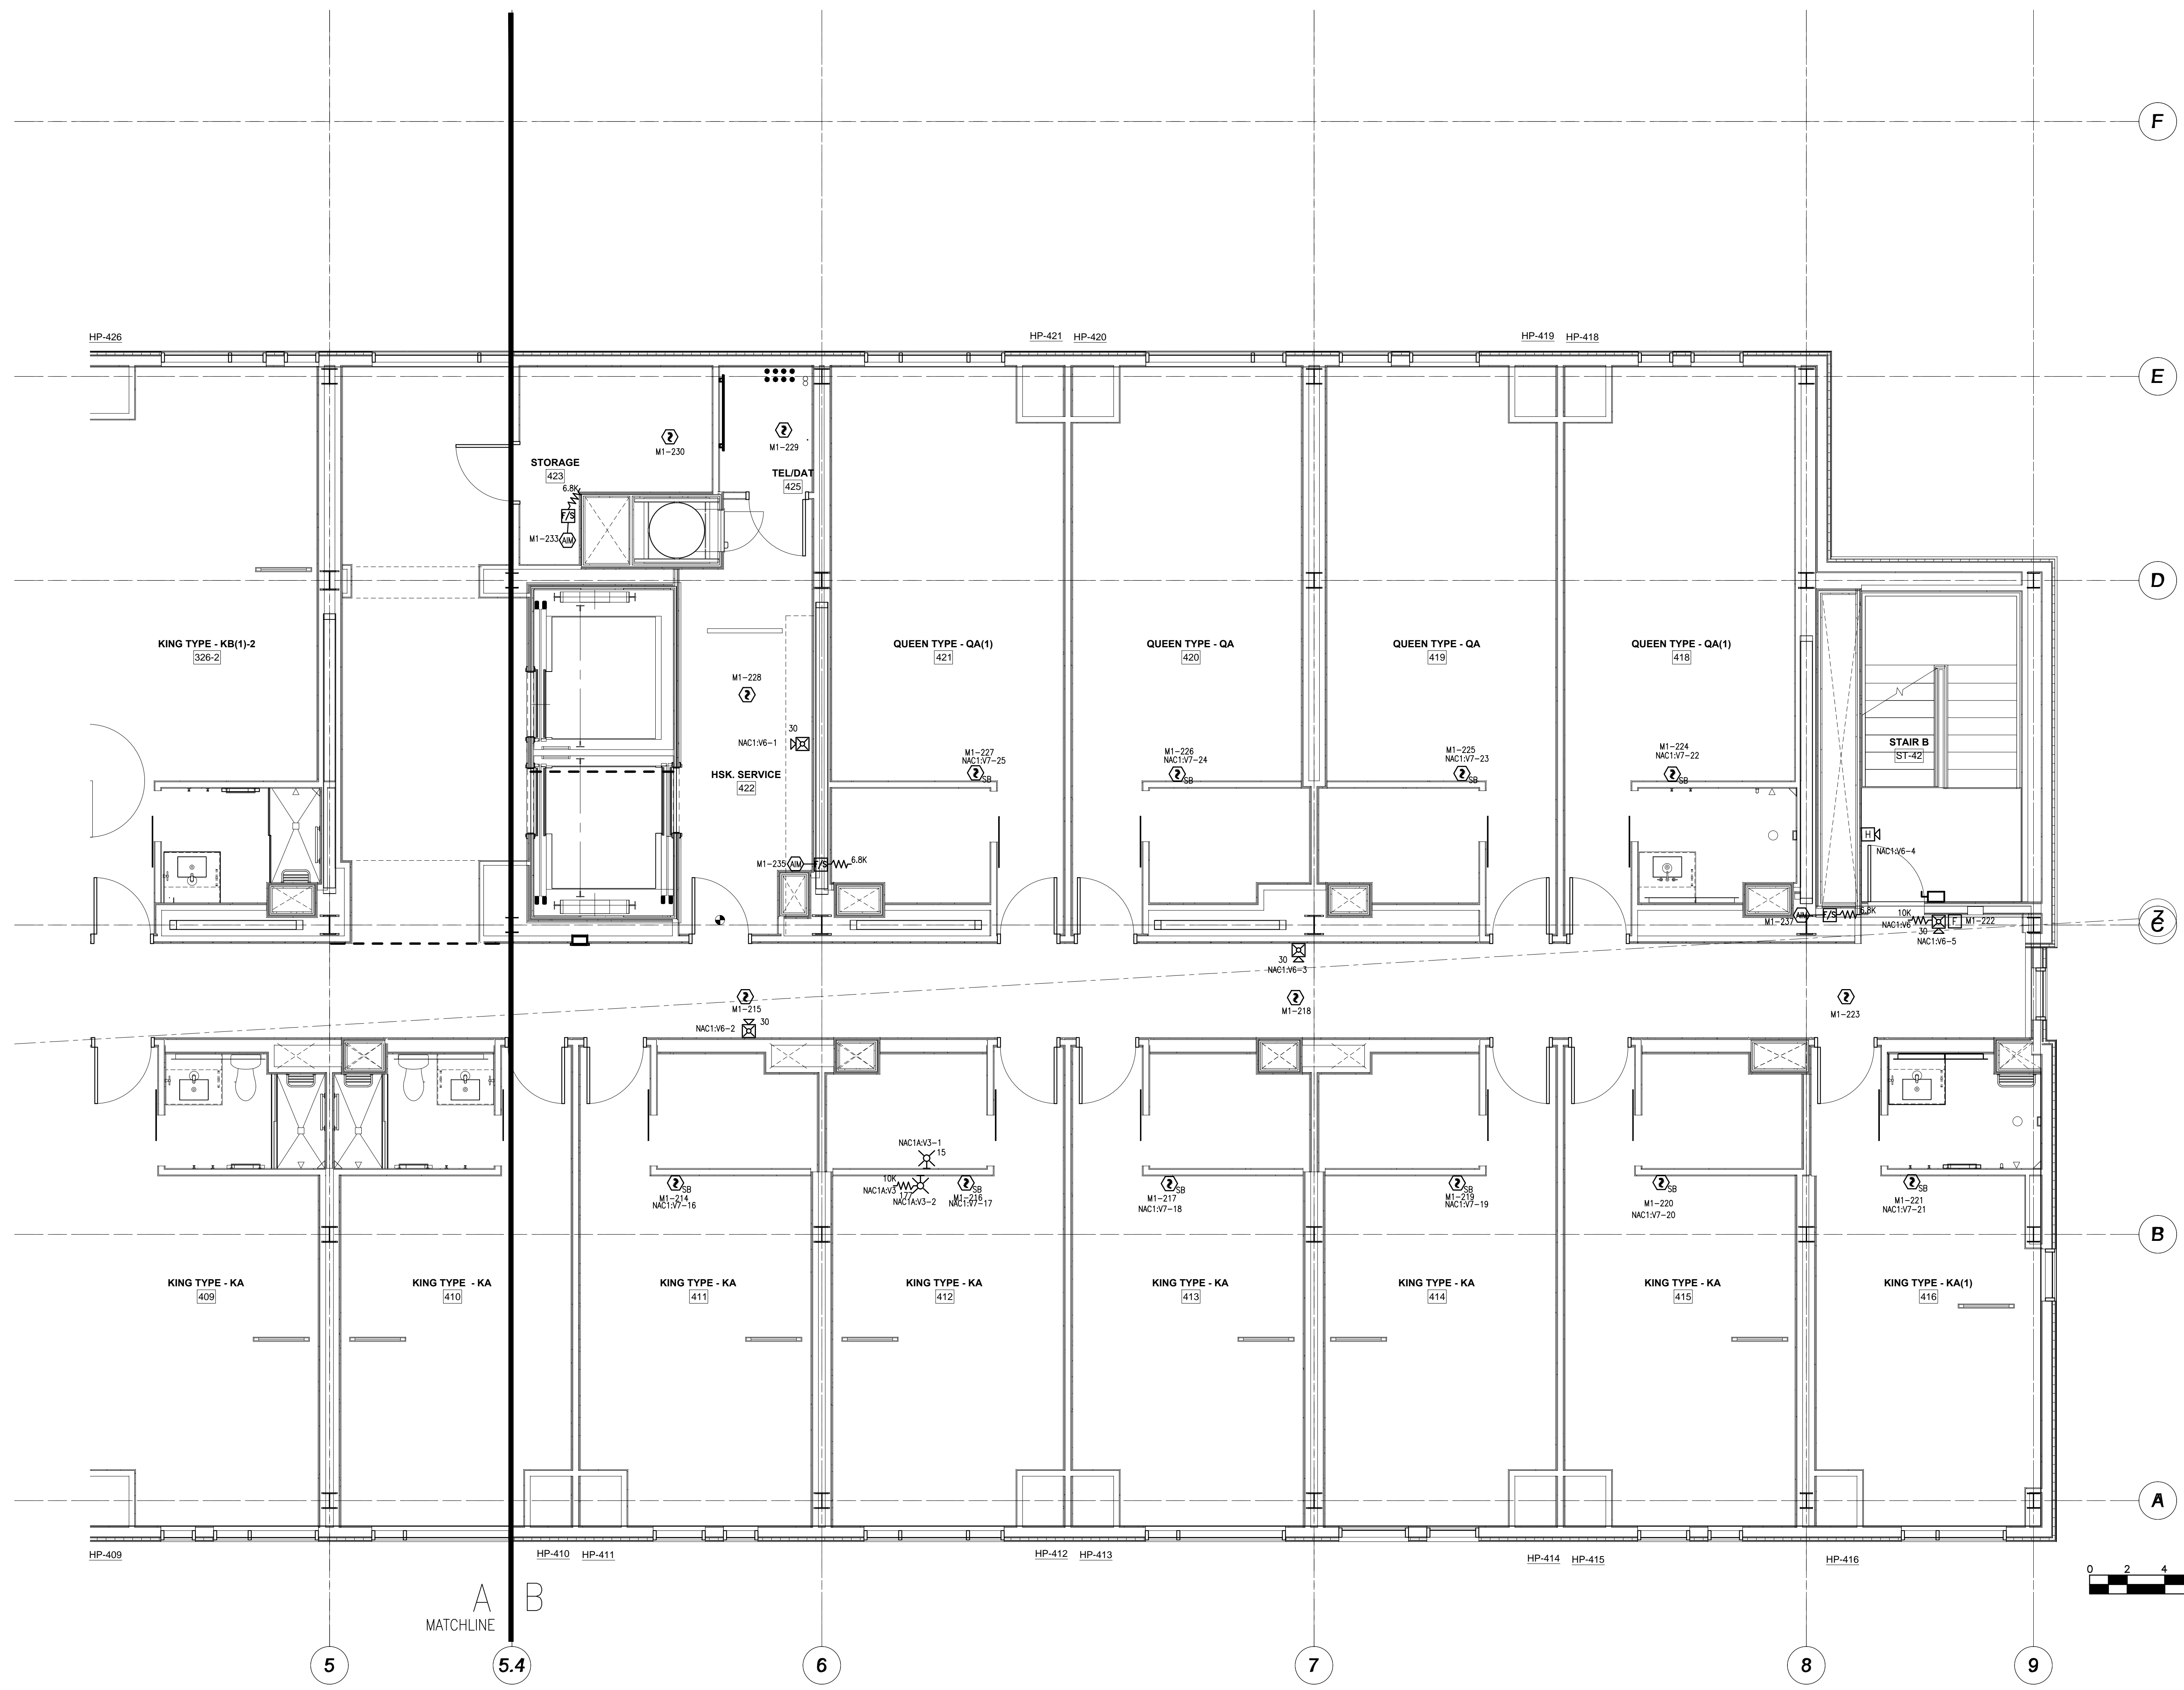

tyco
SimplexGrinnell

20 THOMAS DRIVE
WESTBROOK, ME 04092
SALES: 207-842-6440
SERVICE: 207-842-6440
FAX: 207-842-6439

CHG BY: JS
DATE: 8/14/13
NO. 1

REVISION DESCRIPTION:
REVISED PER ENGINEERS REVIEW COMMENTS DATED 7/19/13 & 8/5/13

DATE: 9/10/13
NO. 2

DATE: 10/07/13
NO. 3

REVISION DESCRIPTION:
REVISED PER SUBMITTAL REVIEW DATED 8/29/13

DATE: 10/07/13
NO. 3

REVISION DESCRIPTION:
REVISED PER SUBMITTAL REVIEW DATED 10/1/13

FIRE ALARM & AREA OF REFUGE SYSTEMS
FOURTH FLOOR PLAN PART B
HYATT PLACE PORTLAND-OLD PORT
433 FORE STREET
PORTLAND, ME

DRAWN BY: LORION	DATE: 6/14/13
CHECKED BY: KALAFARSKI	DATE: 7/12/13
PROJECT NUMBER: 971237001	
SHEET TITLE: FIRE ALARM SYSTEM FOURTH FLR PLAN PART B	
SHEET NUMBER: FA-108	