


FILE PATH: P:\2013\147\Hyatt Place\REV 3\REV 3 CAD\FA-113.dwg

LAST PRINTED: 2/10/2014 8:55:10 AM LAST SAVED BY: CLORION

24" x 36"

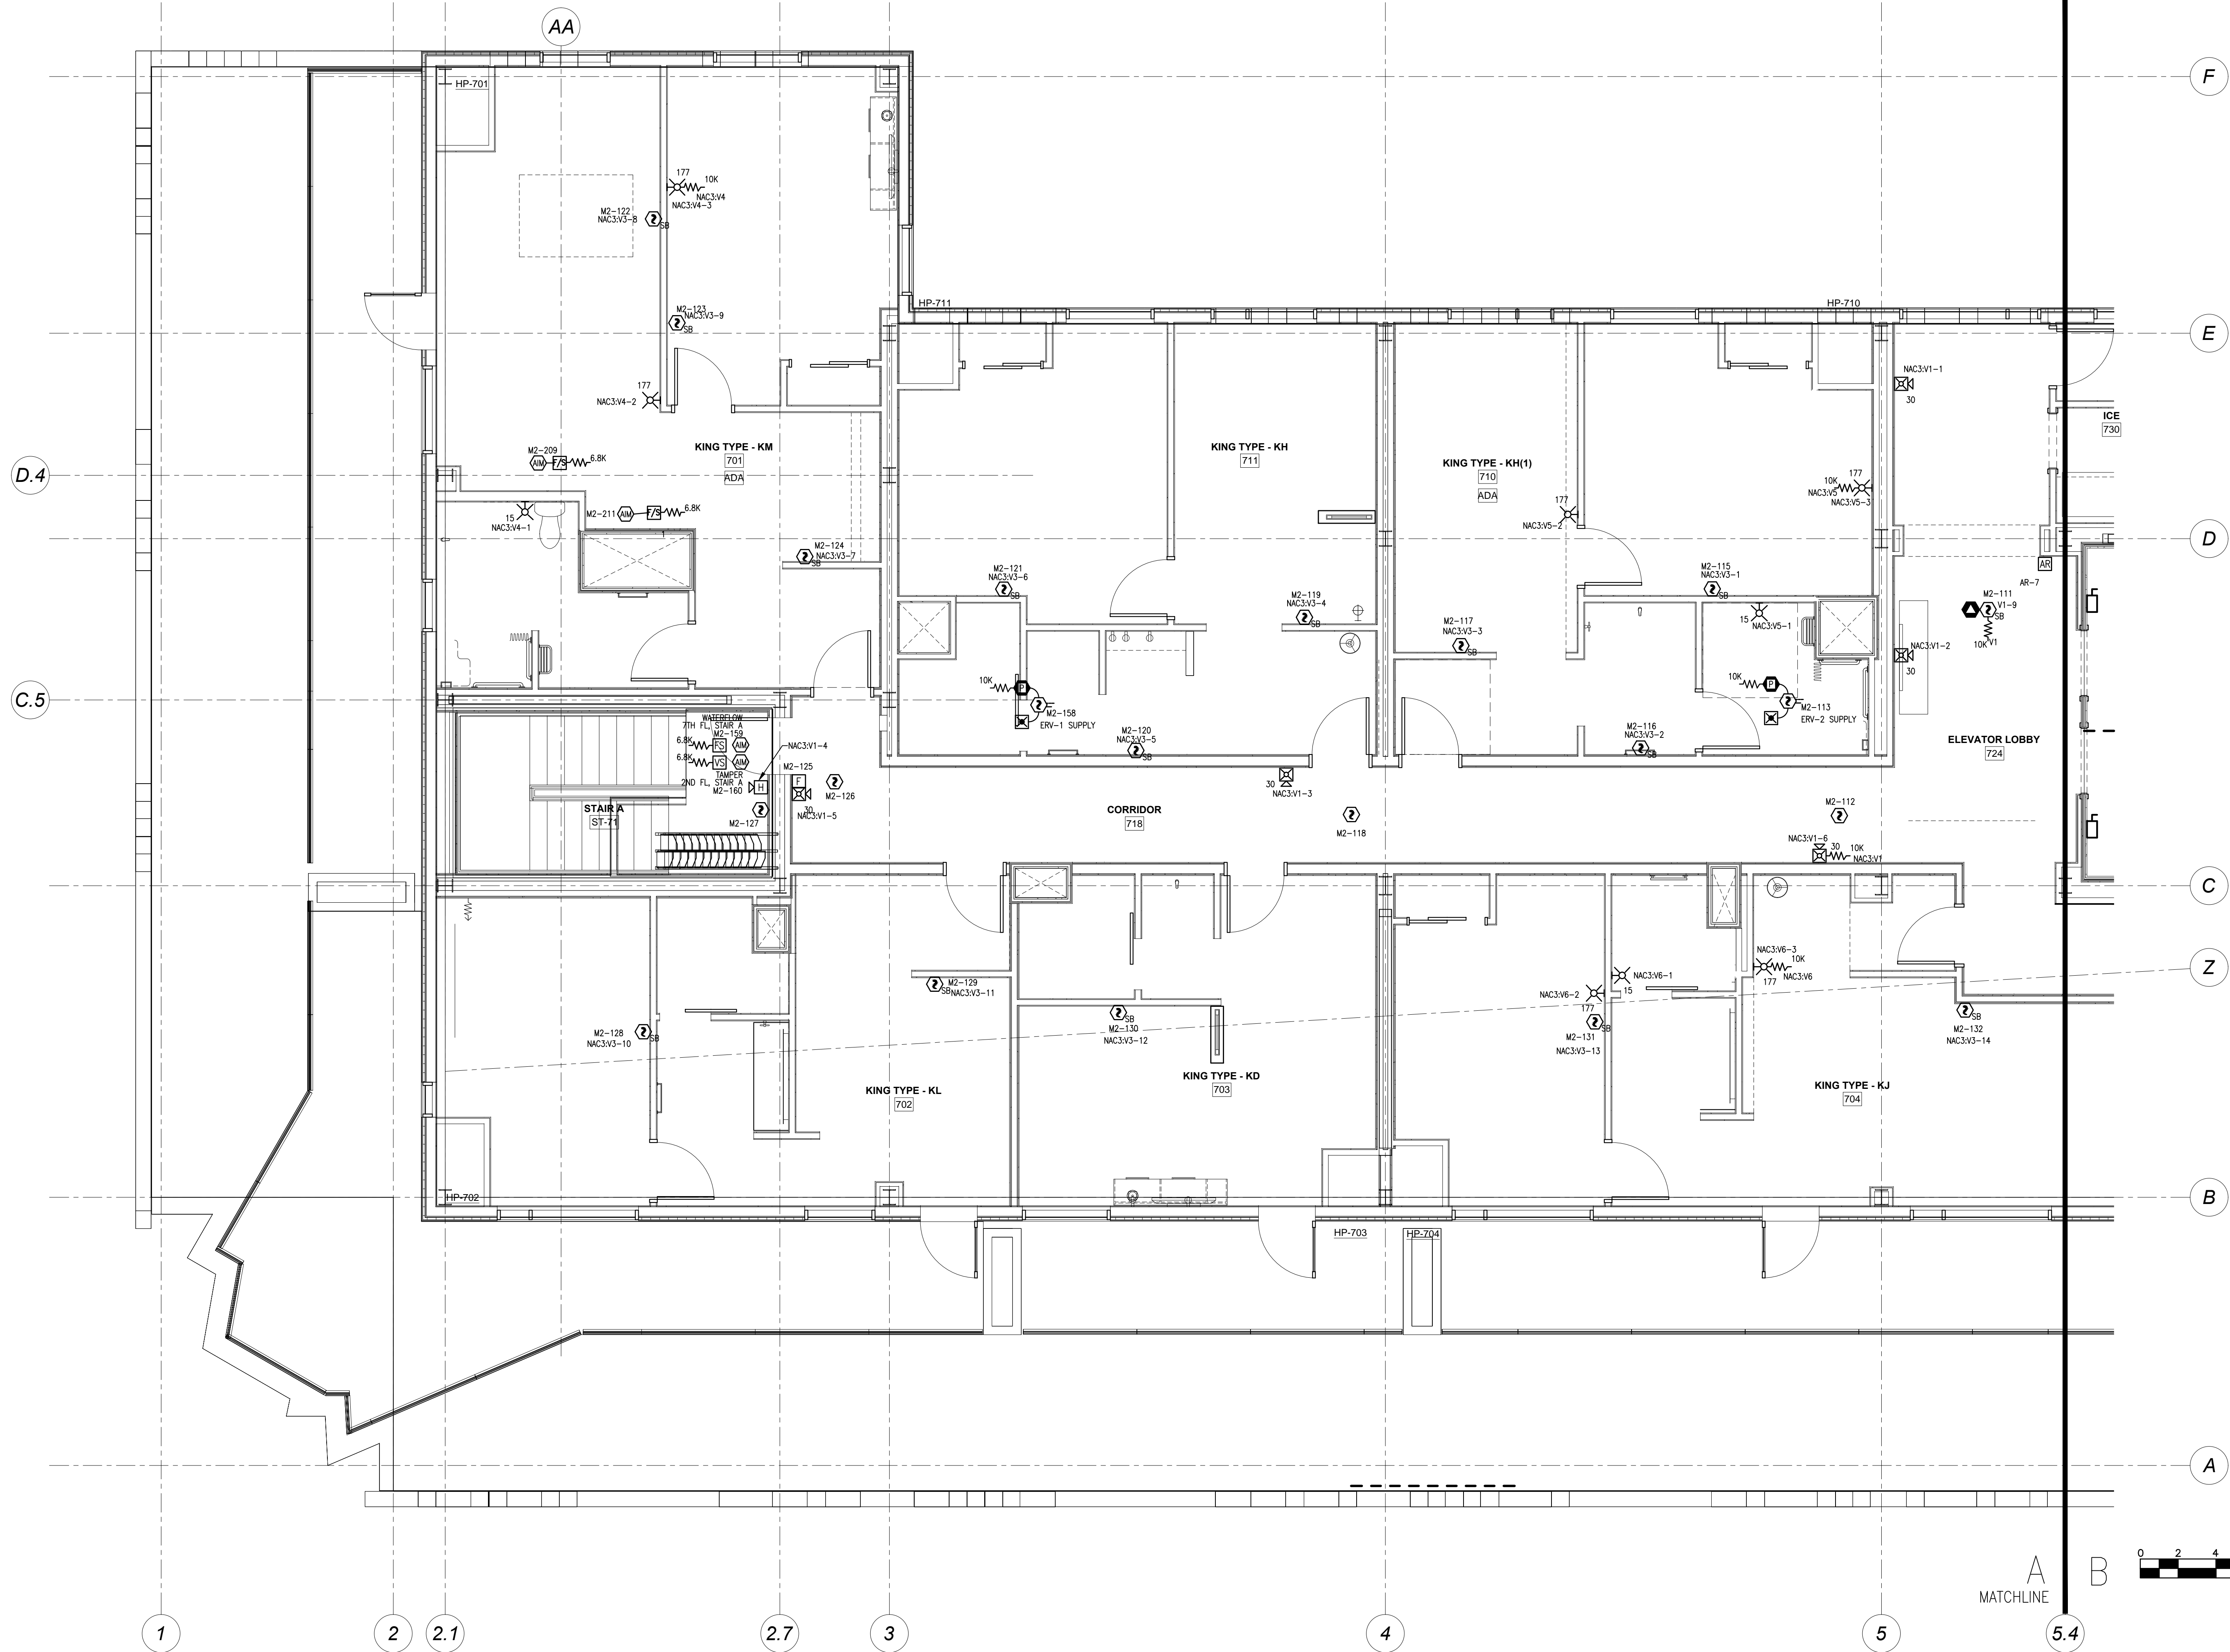

**tyco**  
SimplexGrinnell

20 THOMAS DRIVE  
WESTBROOK, ME 04092  
SALES: 207-842-6440  
SERVICE: 207-842-6440  
FAX: 207-842-6439  
© 2013 SIMPLEX GRINNELL, LP  
ALL RIGHTS RESERVED

NO.	DATE	REVISION DESCRIPTION
1	8/14/13	REVISED PER ENGINEERS REVIEW COMMENTS DATED 7/19/13 & 8/5/13
2	9/10/13	REVISED PER SUBMITTAL REVIEW DATED 8/29/13
3	10/07/13	REVISED PER SUBMITTAL REVIEW DATED 10/1/13

CHG BY	DATE
JS	
SK	

FIRE ALARM & AREA OF REFUGE SYSTEMS  
SEVENTH FLOOR PLAN PART A  
HYATT PLACE PORTLAND - OLD PORT  
433 FORE STREET  
PORTLAND, ME

DRAWN BY: LORION	DATE: 6/14/13
CHECKED BY: KALAFARSKI	DATE: 7/12/13
PROJECT NUMBER: 971237001	
SHEET TITLE: FIRE ALARM SYSTEM SEVENTH FLR PLAN PART A	
SHEET NUMBER: FA-113	

FA-113.dwg