


FILE PATH: P:\2013\147\Hyatt Place\REV 3\CAD\FA-201.FA-203.dwg

LAST PRINTED: 2/10/2014 8:55:18 AM LAST SAVED BY: GLORION

24" x 36"

SEE DWG FA-202

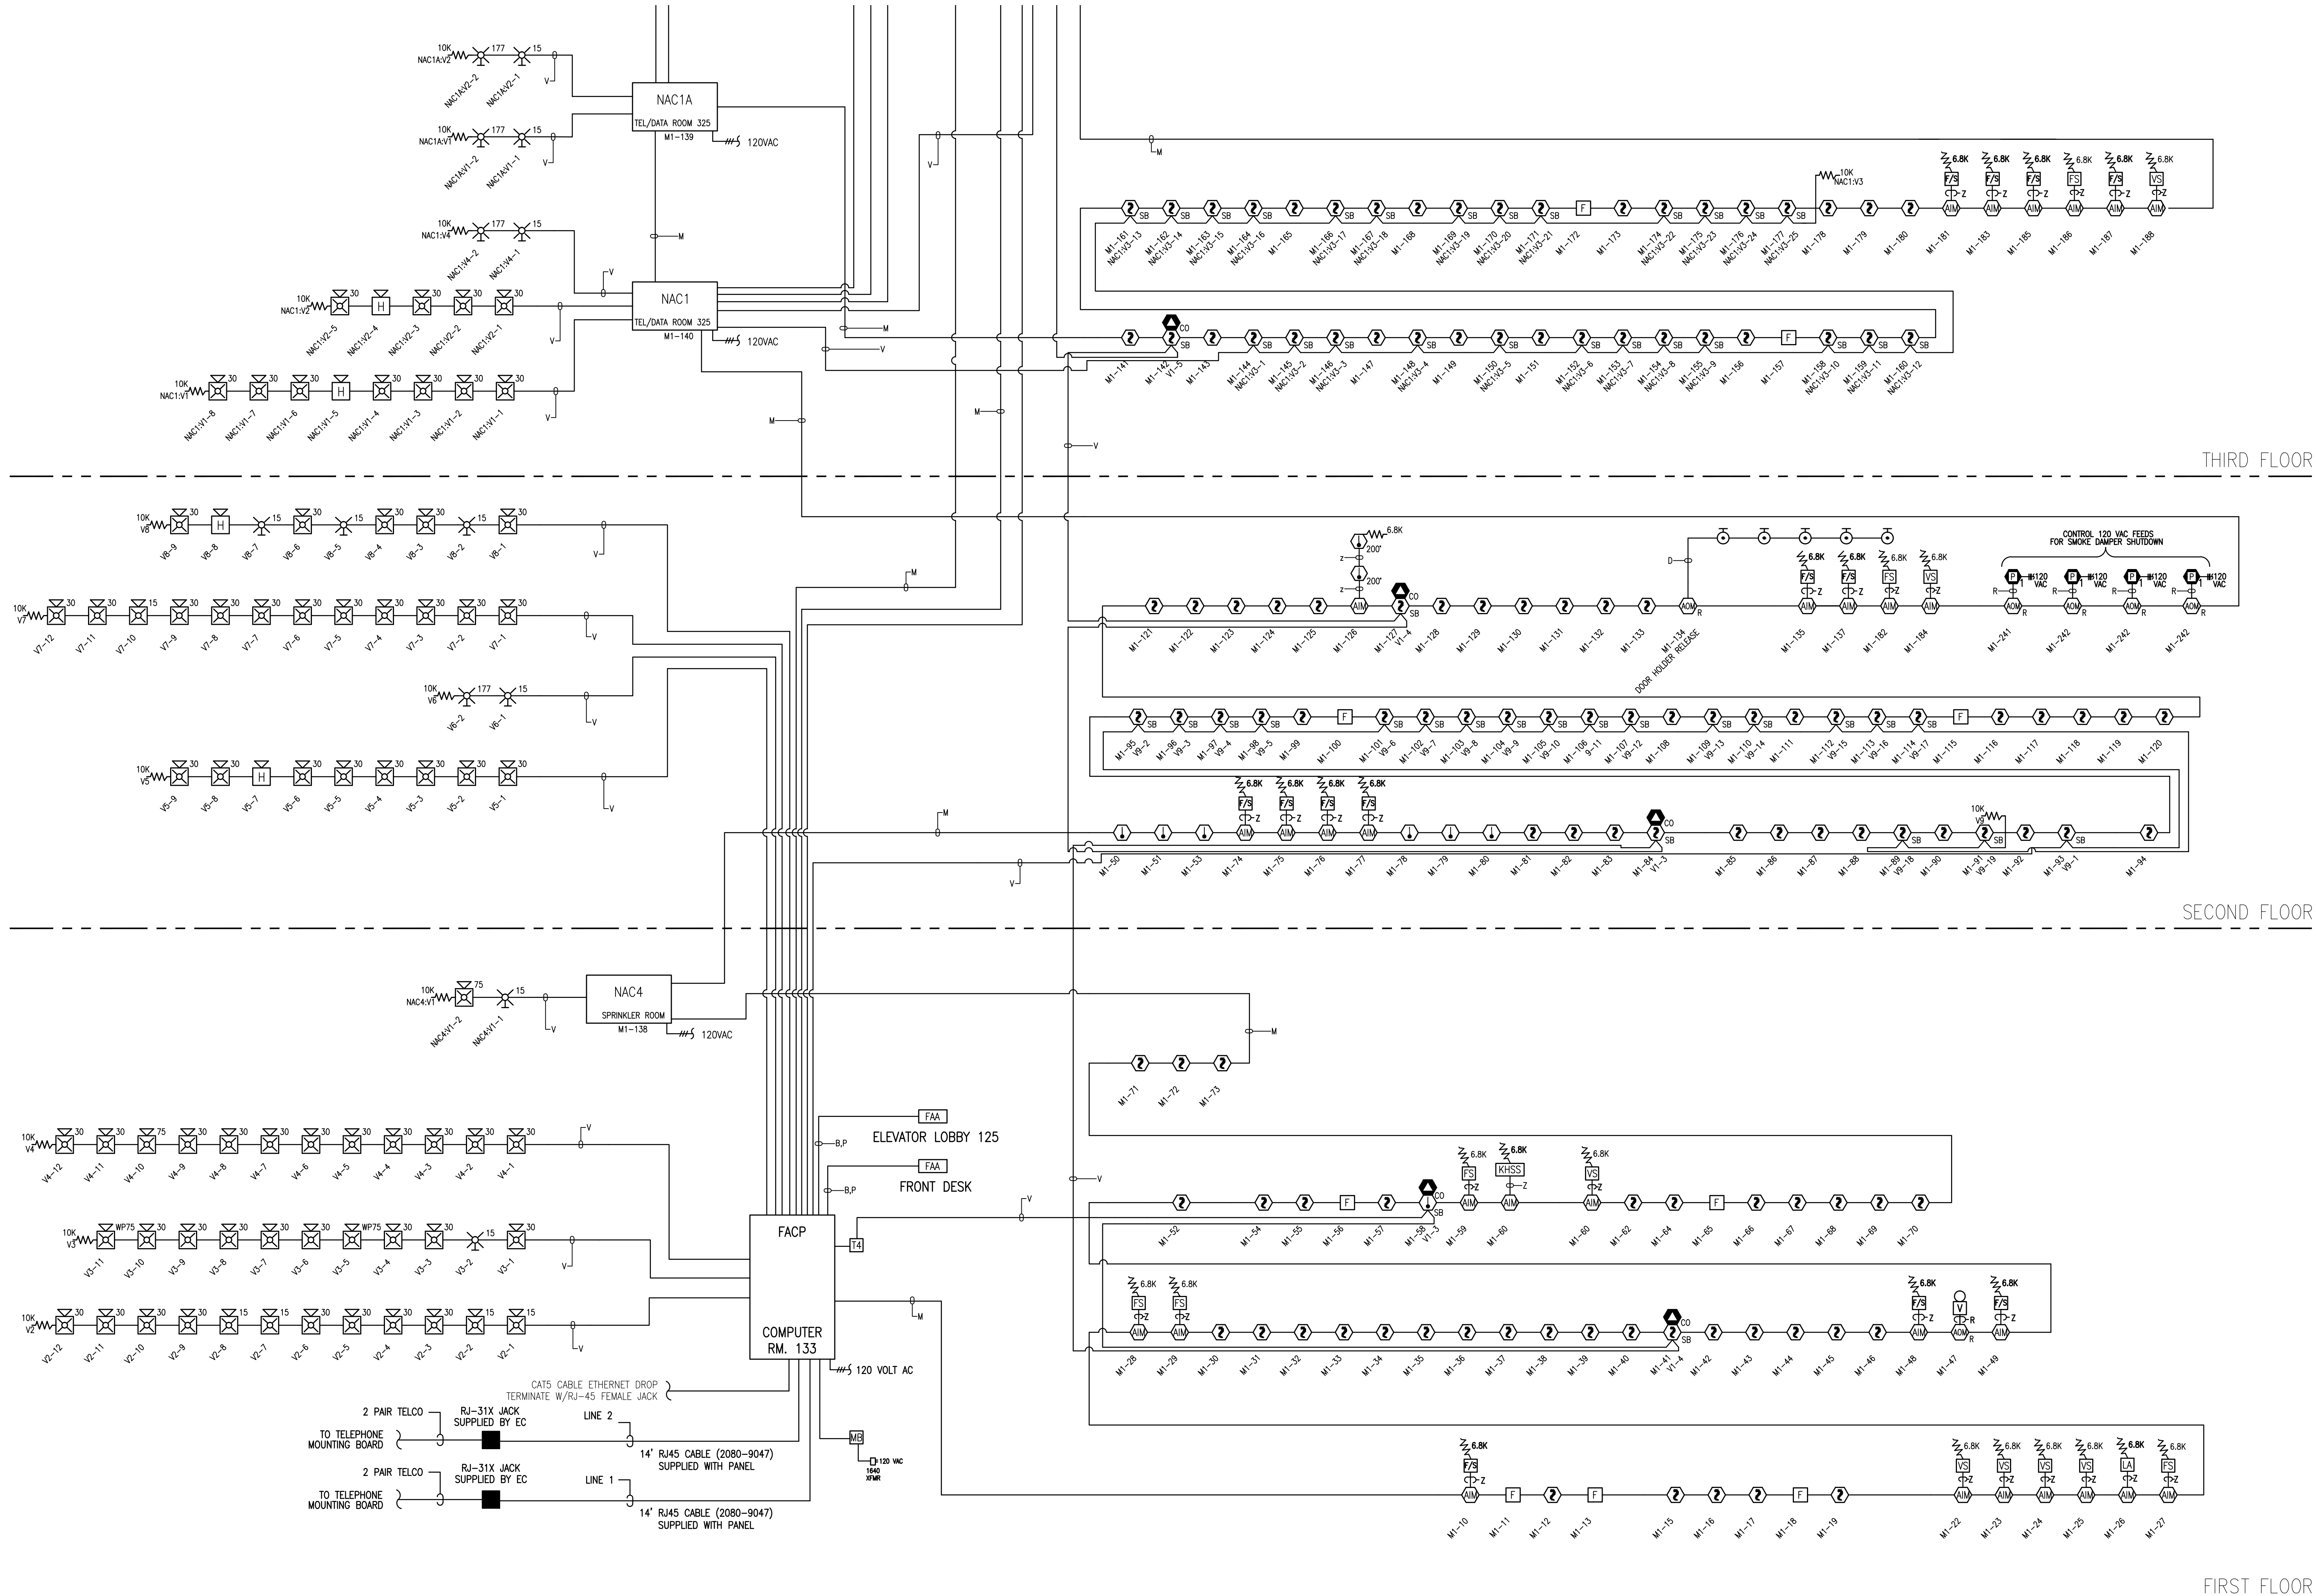

THIRD FLOOR

SECOND FLOOR

FIRST FLOOR

**tyco**  
SimplexGrinnell

20 THOMAS DRIVE  
WESTBROOK, ME 04092  
SALES: 207-842-6440  
SERVICES: 207-842-6440  
FAX: 207-842-6439

NO.	DATE	REVISION/DESCRIPTION
1	8/14/13	REVISED PER ENGINEERS REVIEW COMMENTS DATED 7/19/13 & 8/5/13
2	9/10/13	REVISED PER SUBMITTAL REVIEW DATED 8/29/13
3	10/07/13	REVISED PER SUBMITTAL REVIEW DATED 10/1/13

FIRE ALARM & AREA OF REFUGE SYSTEMS RISER DIAGRAM	
HYATT PLACE PORTLAND - OLD PORT 433 FORE STREET PORTLAND, ME	
DRAWN BY: LORION	DATE: 6/14/13
CHECKED BY: KALAFARSKI	DATE: 7/12/13
PROJECT NUMBER: 971237001	
SHEET TITLE: FIRE ALARM SYSTEM RISER DIAGRAM	
SHEET NUMBER: FA-201	