


FILE PATH: P:\2013\147\Hyatt Place\REV 3\REV 3 CAD\FA-201\_FA-203.dwg

LAST PRINTED: 2/10/2014 8:55:19 AM LAST SAVED BY: GLORION

24" x 36"

SEE DWG FA-203

SEE DWG FA-201

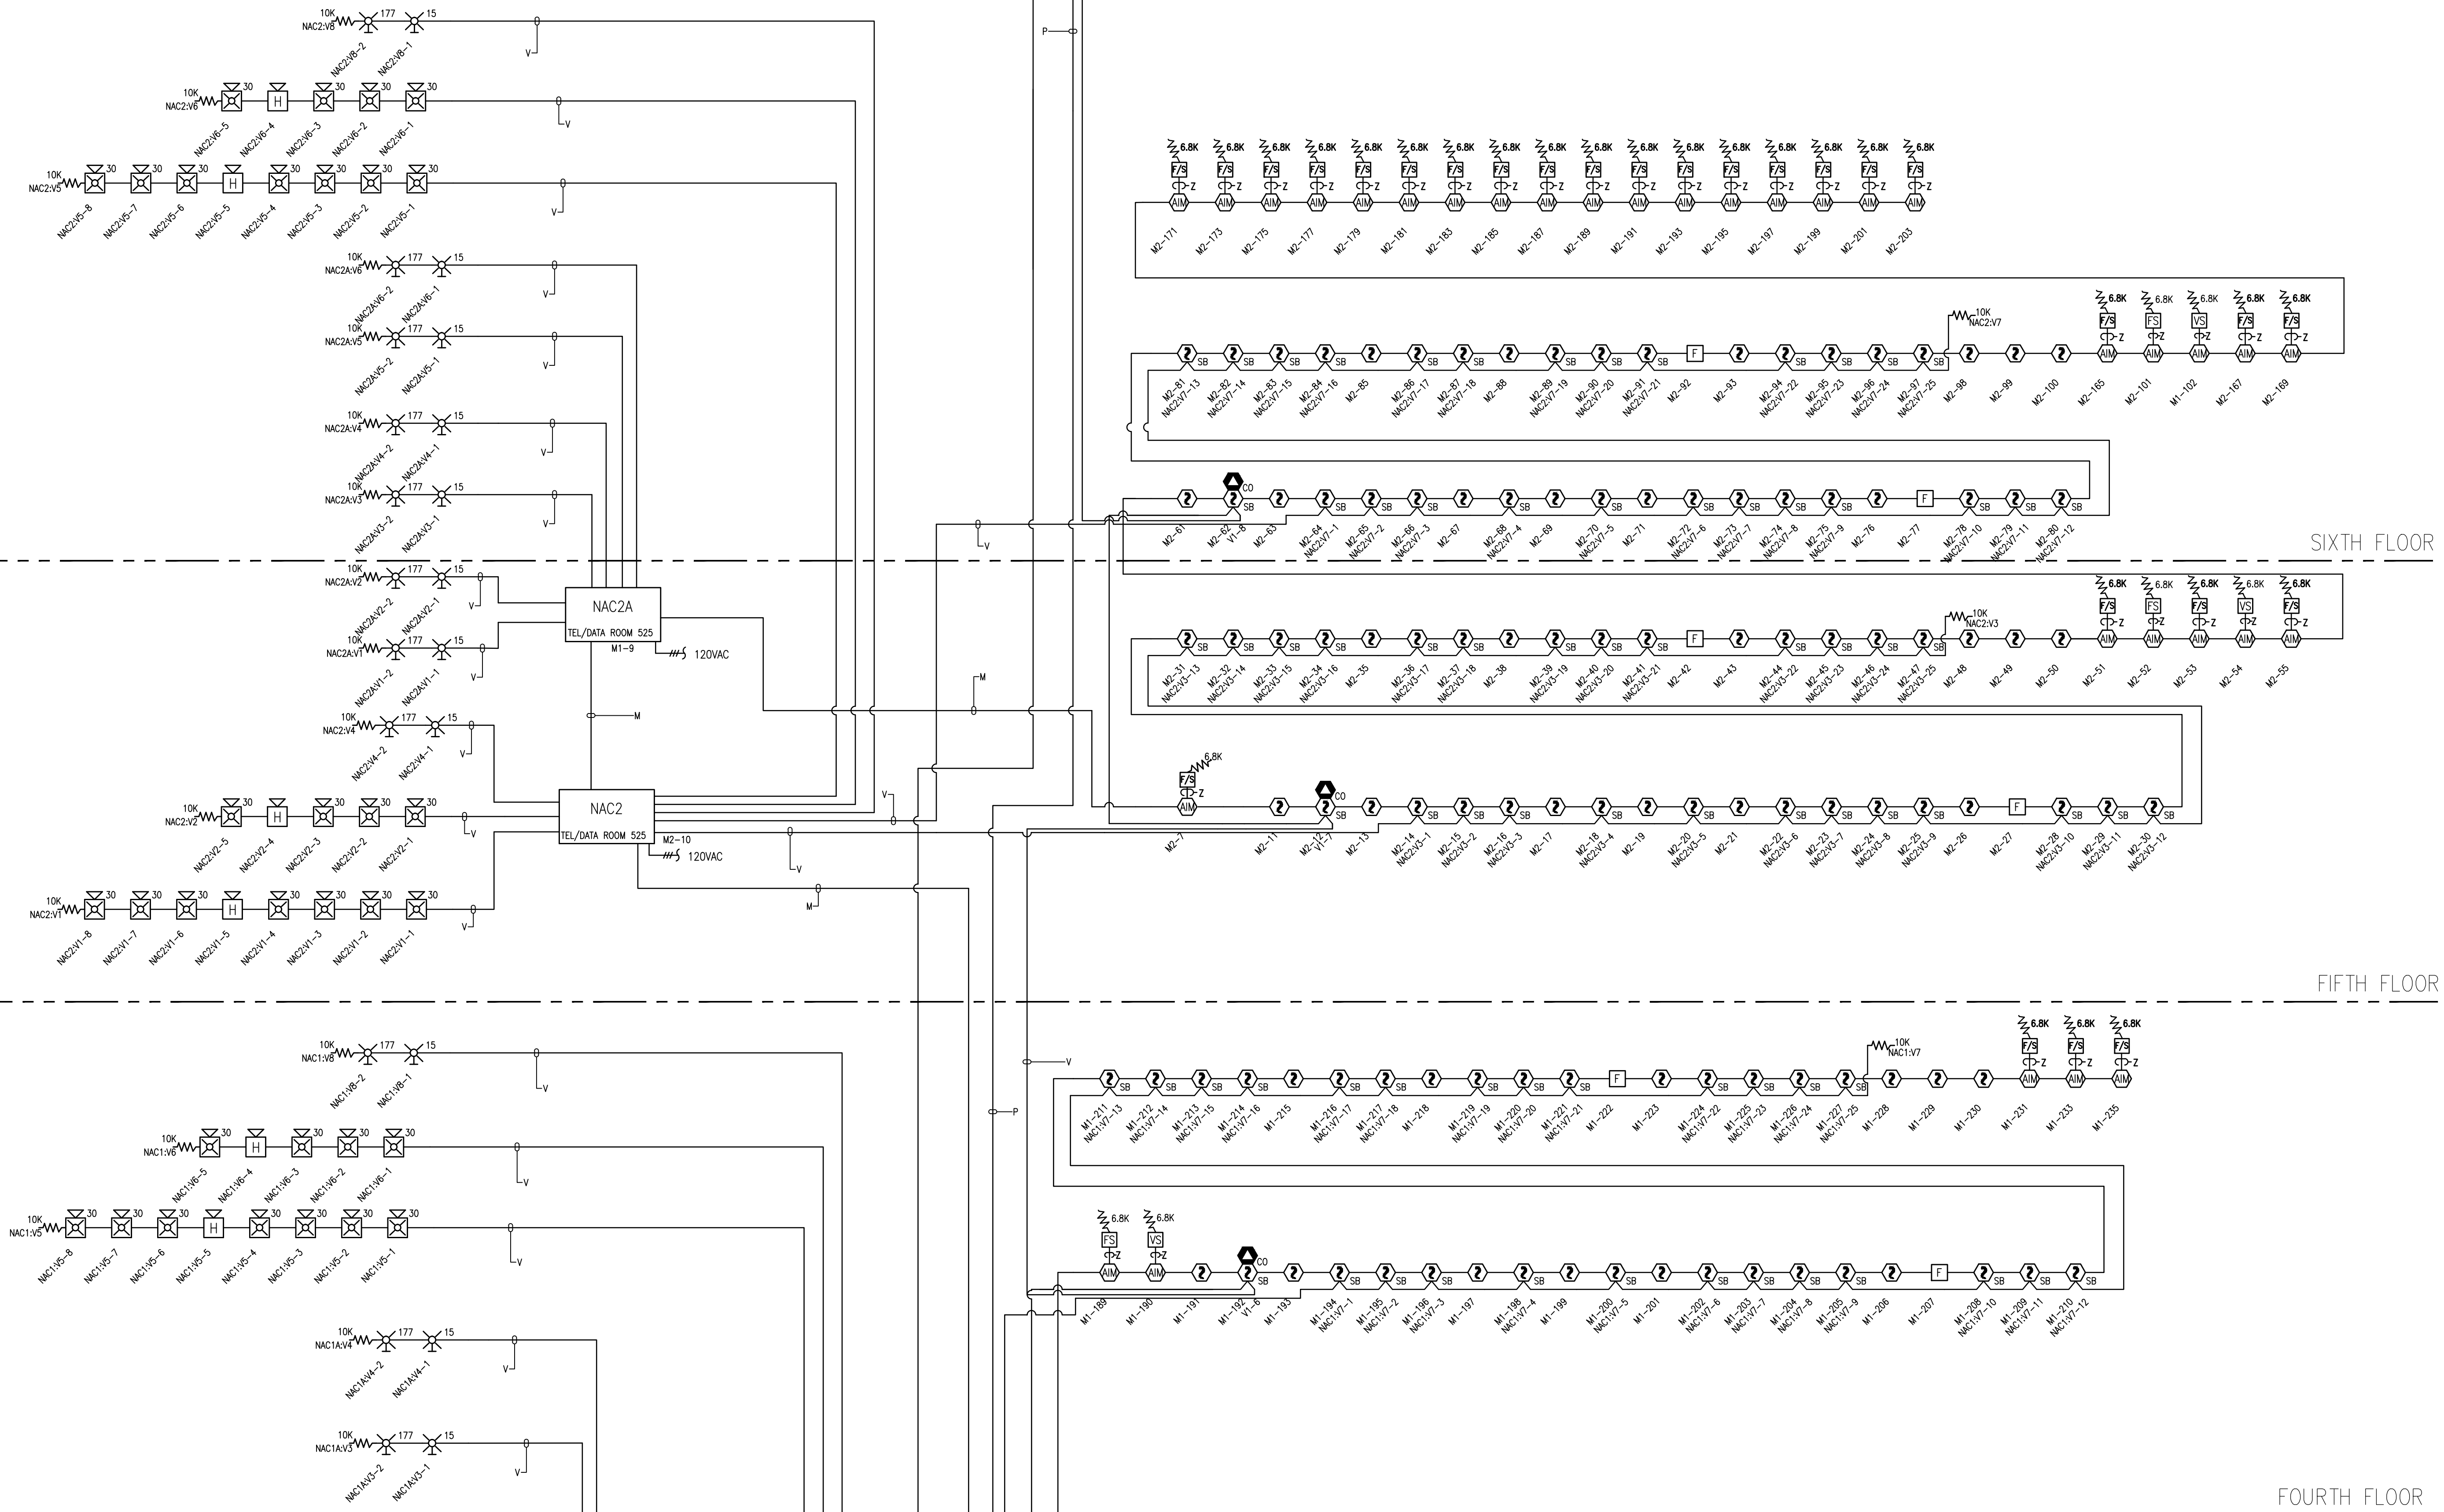

**tyco**  
SimplexGrinnell

200 THOMAS DRIVE  
WESTBROOK, ME 04092  
207-842-6440  
SALES: 207-842-6440  
SERVICE: 207-842-6439  
FAX: 207-842-6439

CHG BY: JS

REVISION DESCRIPTION

REVIS PER ENGINEERS REVIEW COMMENTS DATED 7/19/13 & 8/5/13

REVIS PER SUBMITTAL REVIEW DATED 8/29/13

REVIS PER SUBMITTAL REVIEW DATED 10/1/13

NO.	DATE	REVISION DESCRIPTION
1	8/14/13	REVIS PER ENGINEERS REVIEW COMMENTS DATED 7/19/13 & 8/5/13
2	9/10/13	REVIS PER SUBMITTAL REVIEW DATED 8/29/13
3	10/07/13	REVIS PER SUBMITTAL REVIEW DATED 10/1/13

**FIRE ALARM & AREA OF REFUGE SYSTEMS**

**RISER DIAGRAM**

**HYATT PLACE PORTLAND - OLD PORT**

433 FORE STREET  
PORTLAND, ME

DRAWN BY: LORION	DATE: 6/14/13
CHECKED BY: KALAFARSKI	DATE: 7/12/13
PROJECT NUMBER: 971237001	
SHEET TITLE: FIRE ALARM SYSTEM RISER DIAGRAM	
SHEET NUMBER: <b>FA-202</b>	