


FIRE ALARM CONTROL PANEL  
CABINET # 1 - FIRST FLOOR  
POOL MECH ROOM 120  
SCALE: NTS

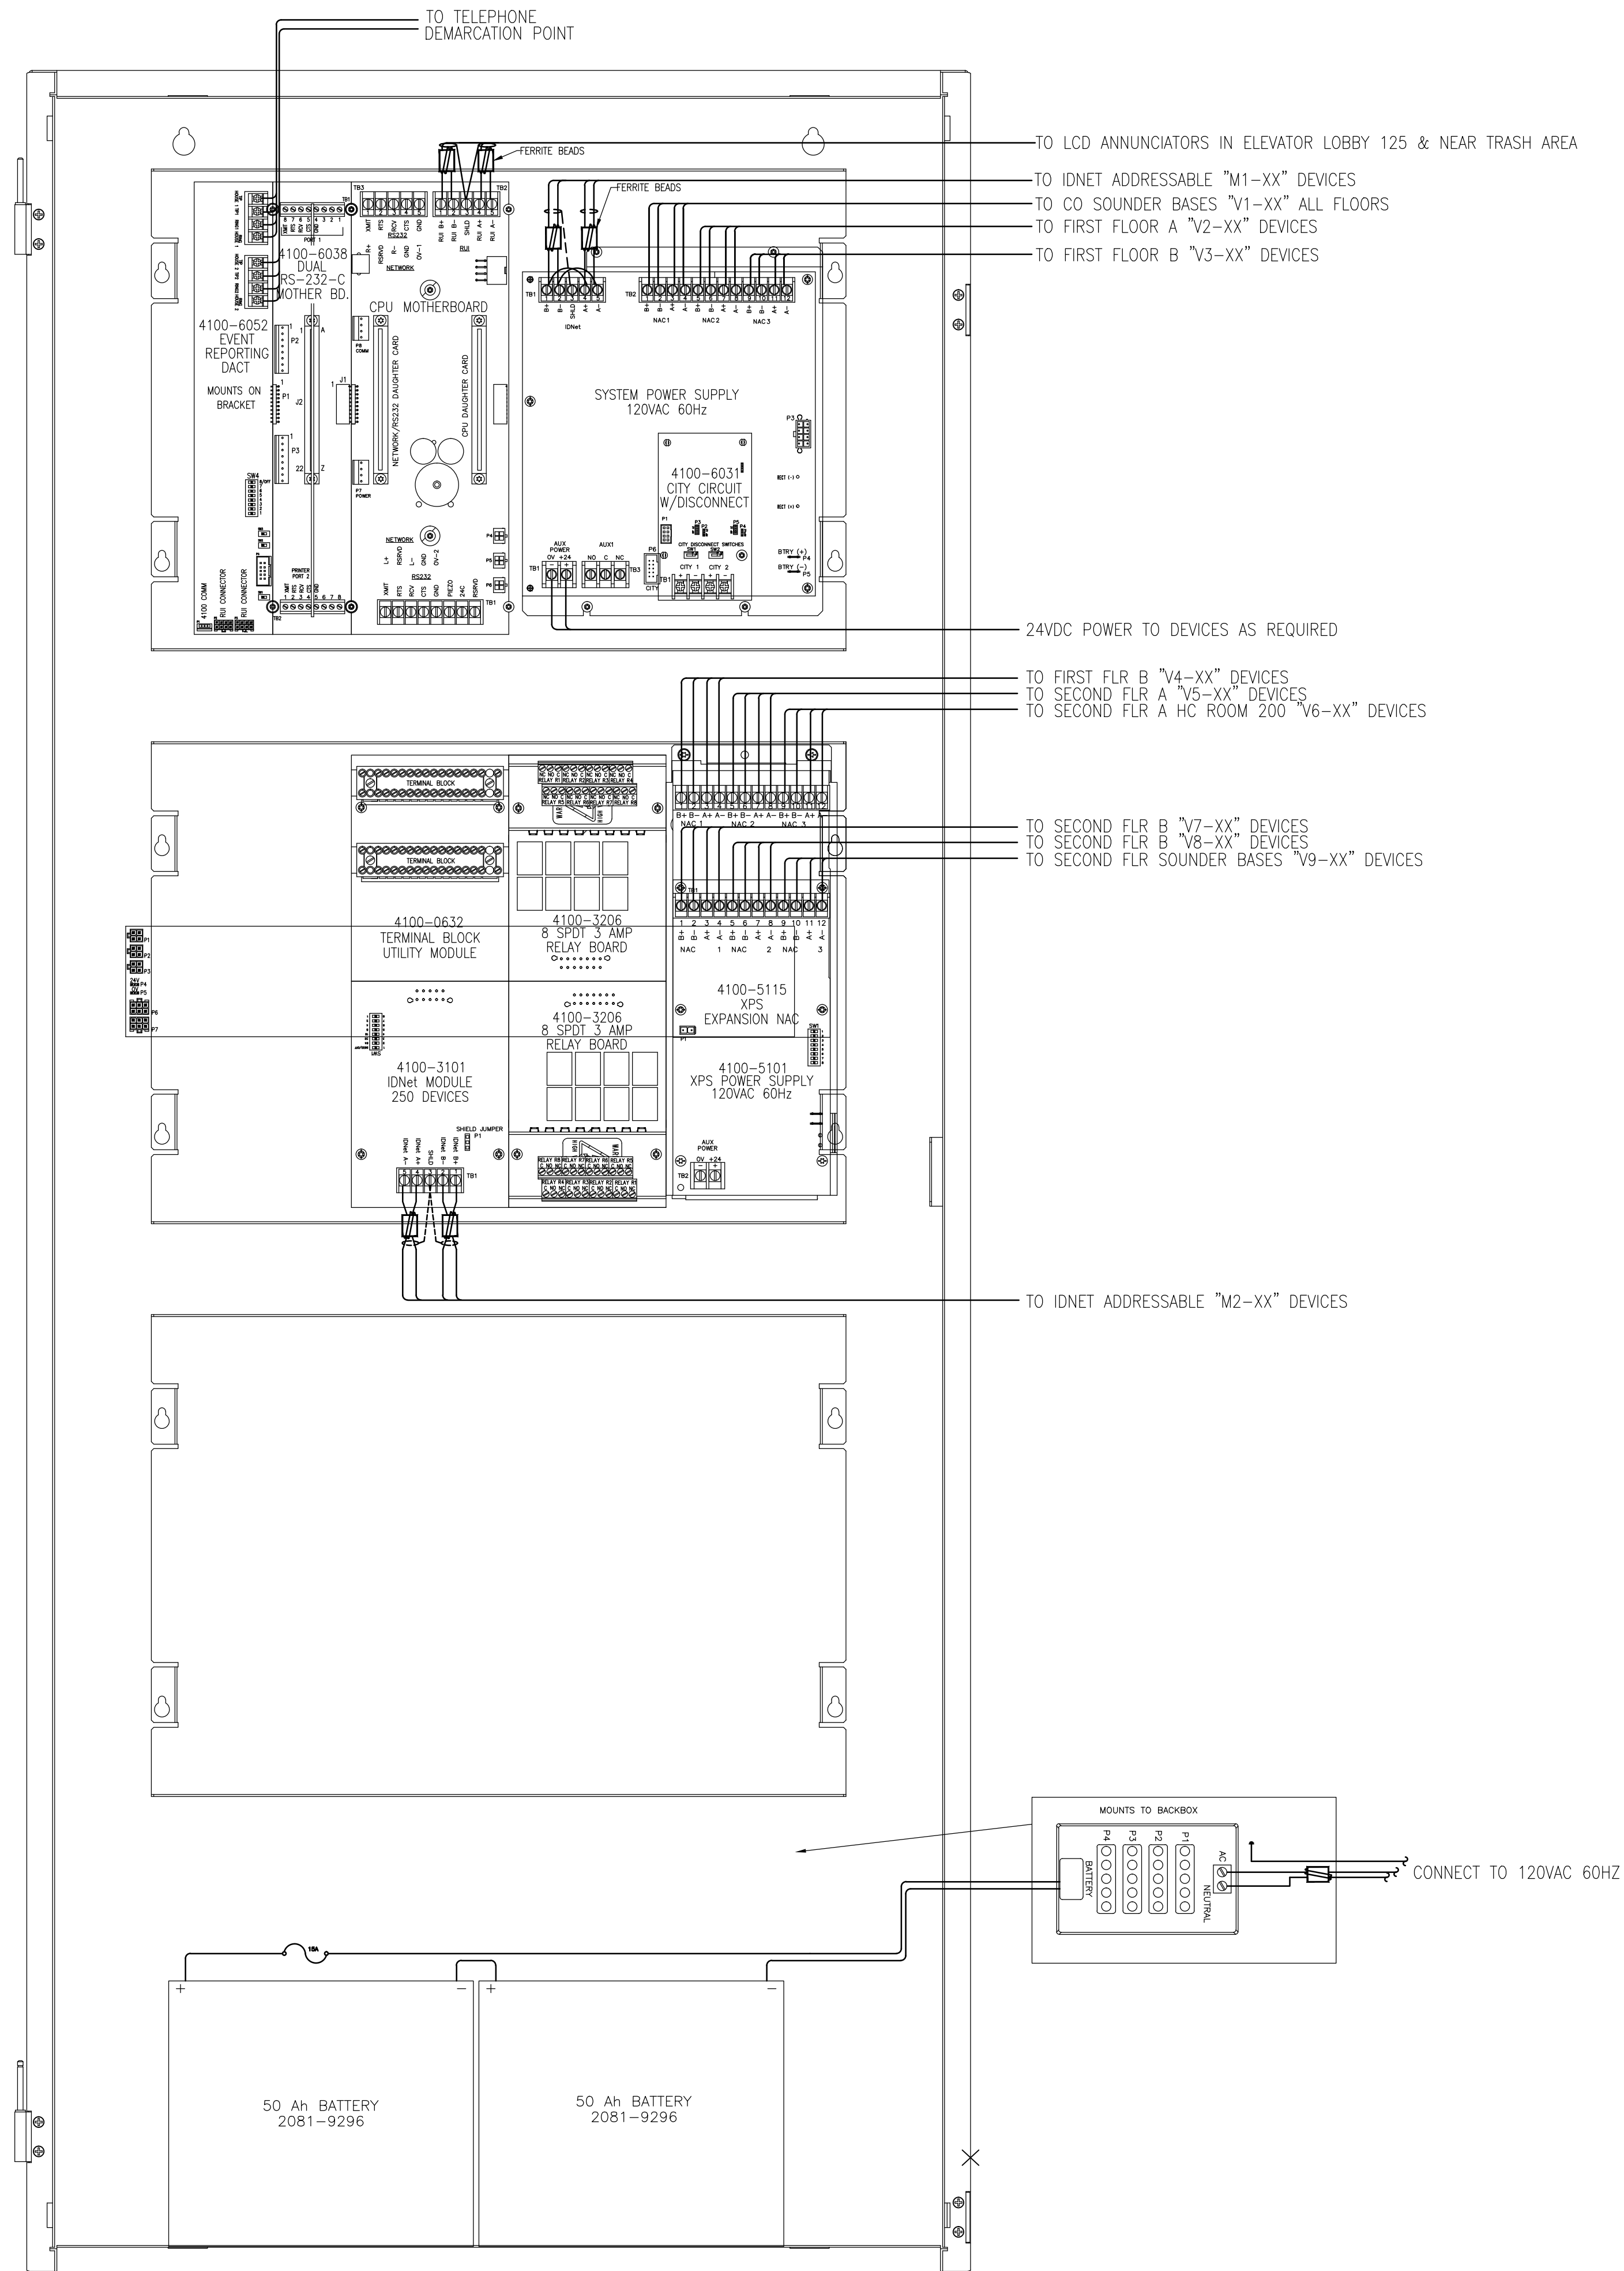

NO.	DATE	REVISION DESCRIPTION
1	8/14/13	REVISED PER ENGINEERS REVIEW COMMENTS DATED 7/19/13 & 8/5/13
2	9/10/13	REVISED PER SUBMITTAL REVIEW DATED 8/29/13
3	10/07/13	REVISED PER SUBMITTAL REVIEW DATED 10/1/13

CHG'D BY	DATE
JS	8/14/13
SK	9/10/13

FIRE ALARM & AREA OF REFUGE SYSTEMS  
PANEL WIRING DETAIL FACP  
HYATT PLACE PORTLAND - OLD PORT  
433 FORE STREET  
PORTLAND, ME

DRAWN BY: LORION	DATE: 6/14/13
CHECKED BY: KALAFARSKI	DATE: 7/12/13
PROJECT NUMBER: 971237001	
SHEET TITLE: FIRE ALARM SYSTEM PANEL WIRING DETAIL FACP	
SHEET NUMBER: FA-501	