


A-42XX CORNELL RESCUE ASSISTANCE SYSTEM WIRE DIAGRAM TYPICAL

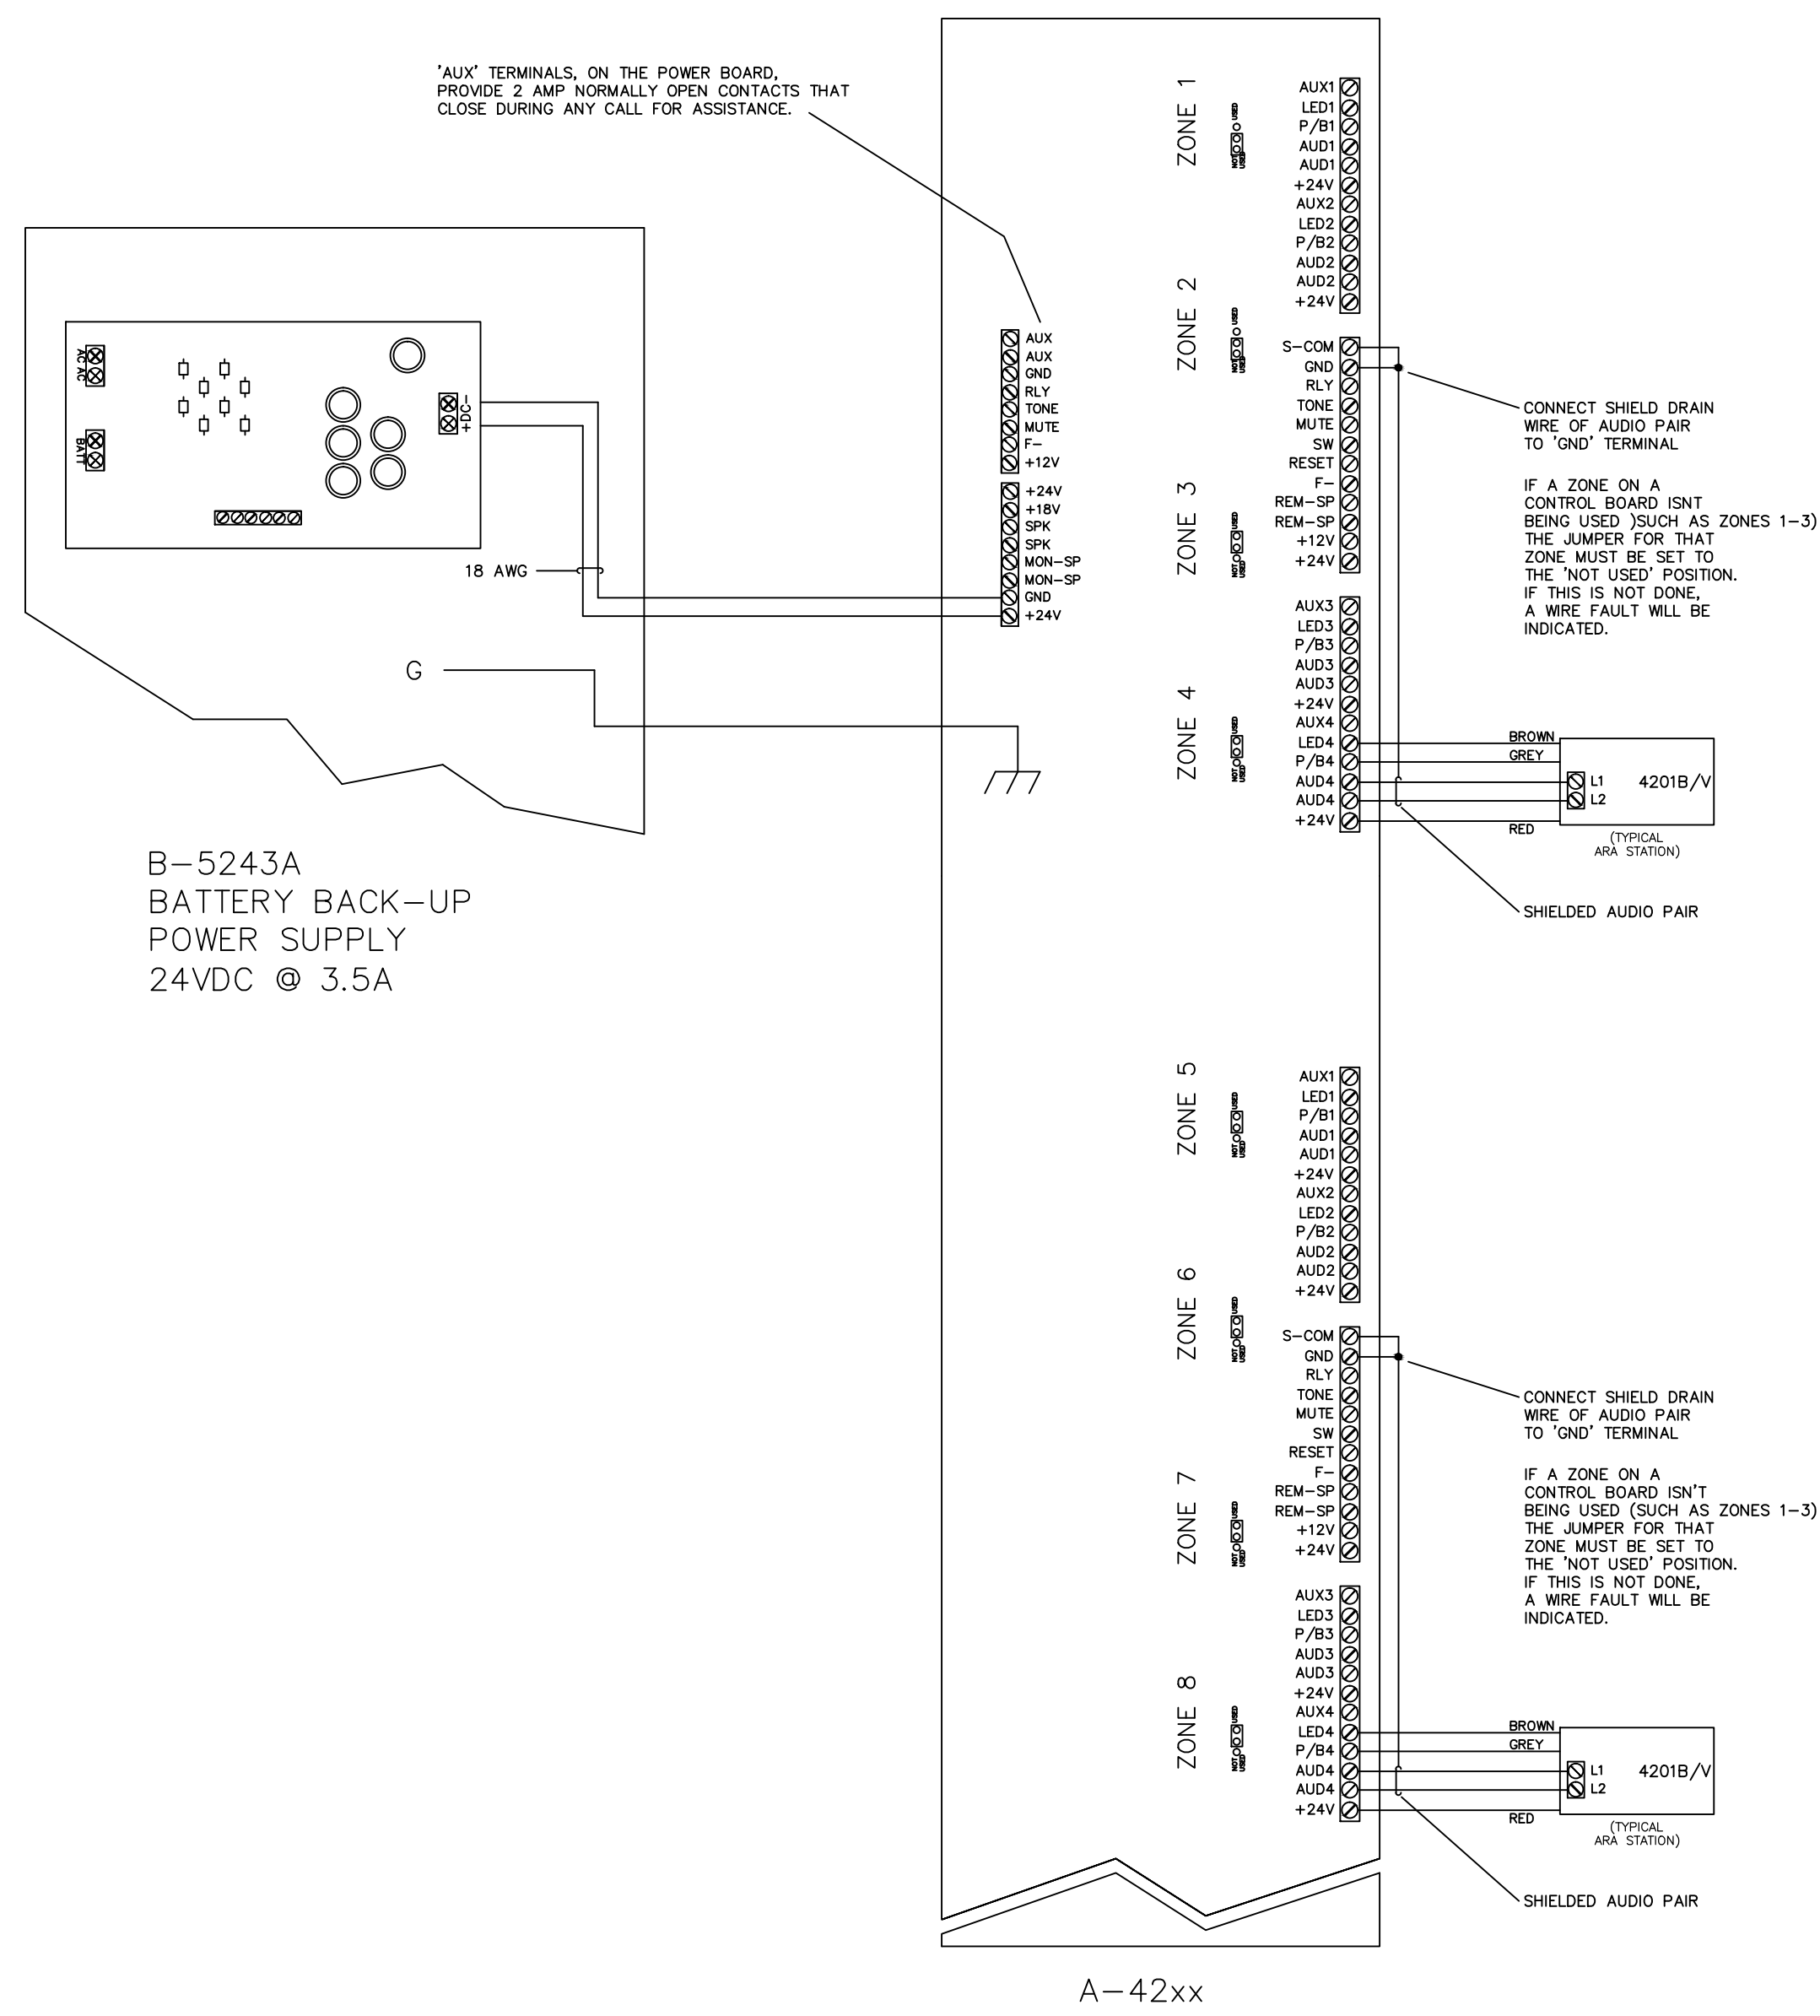

NOTES:
AUX1, AUX2, AUX3 AND AUX4 ARE OPEN COLLECTOR OUTPUTS FOR ZONES 1 THROUGH 4, RESPECTIVELY. EACH CAN SINK UP TO 100mA AND ARE ACTIVE DURING ALARM AND ACKNOWLEDGE CONDITIONS.

JUMPER BETWEEN 'GND' AND 'S-COM' TERMINALS ENABLE ZONE SWITCHES ON CONTROL BOARDS. REMOVE JUMPER AND REPLACE WITH NORMALLY OPEN CONTACTS TO ENABLE ZONE SWITCHES FROM AN EXTERNAL SOURCE (SUCH AS A FIRE ALARM PANEL).

FILE PATH: P:\2013\147\hyatt Place\REV 3\REV 3 CAD\FA-706.dwg

LAST PRINTED: 2/10/2014 8:55:54 AM LAST SAVED BY: GLORION

24" x 36"

tyco
SimplexGrinnell

20 THOMAS DRIVE
WESTBROOK, ME 04092
SALES: 207-842-6440
SERVICE: 207-842-6440
FAX: 207-842-6439
© 2013 SIMPLEXGRINNELL, LP
ALL RIGHTS RESERVED

NO.	DATE	REVISION DESCRIPTION	CHG'D BY
1	8/14/13	REVISED PER ENGINEERS REVIEW COMMENTS DATED 7/19/13 & 8/5/13	JS
2	9/10/13	REVISED PER SUBMITTAL REVIEW DATED 8/29/13	SK
3	10/07/13	REVISED PER SUBMITTAL REVIEW DATED 10/1/13	

FIRE ALARM & AREA OF REFUGE SYSTEMS	
DEVICE WIRING DETAILS	
HYATT PLACE PORTLAND - OLD PORT	
433 FORE STREET PORTLAND, ME	

DRAWN BY: LORION	DATE: 6/14/13
CHECKED BY: KALAFARSKI	DATE: 7/12/13
PROJECT NUMBER: 971237001	
SHEET TITLE: FIRE ALARM SYSTEM DEVICE WIRING DETAILS	
SHEET NUMBER: FA-706	

FA-706.dwg	
------------	--