



OUTLET PLACED WITHIN COVE FOR POWER SUPPLY TR24L96DC FOR USE WITH LED ROPE LIGHTING WITHIN COVE SEE ARCHITECTURAL DRAWINGS FOR COVE DETAILS.

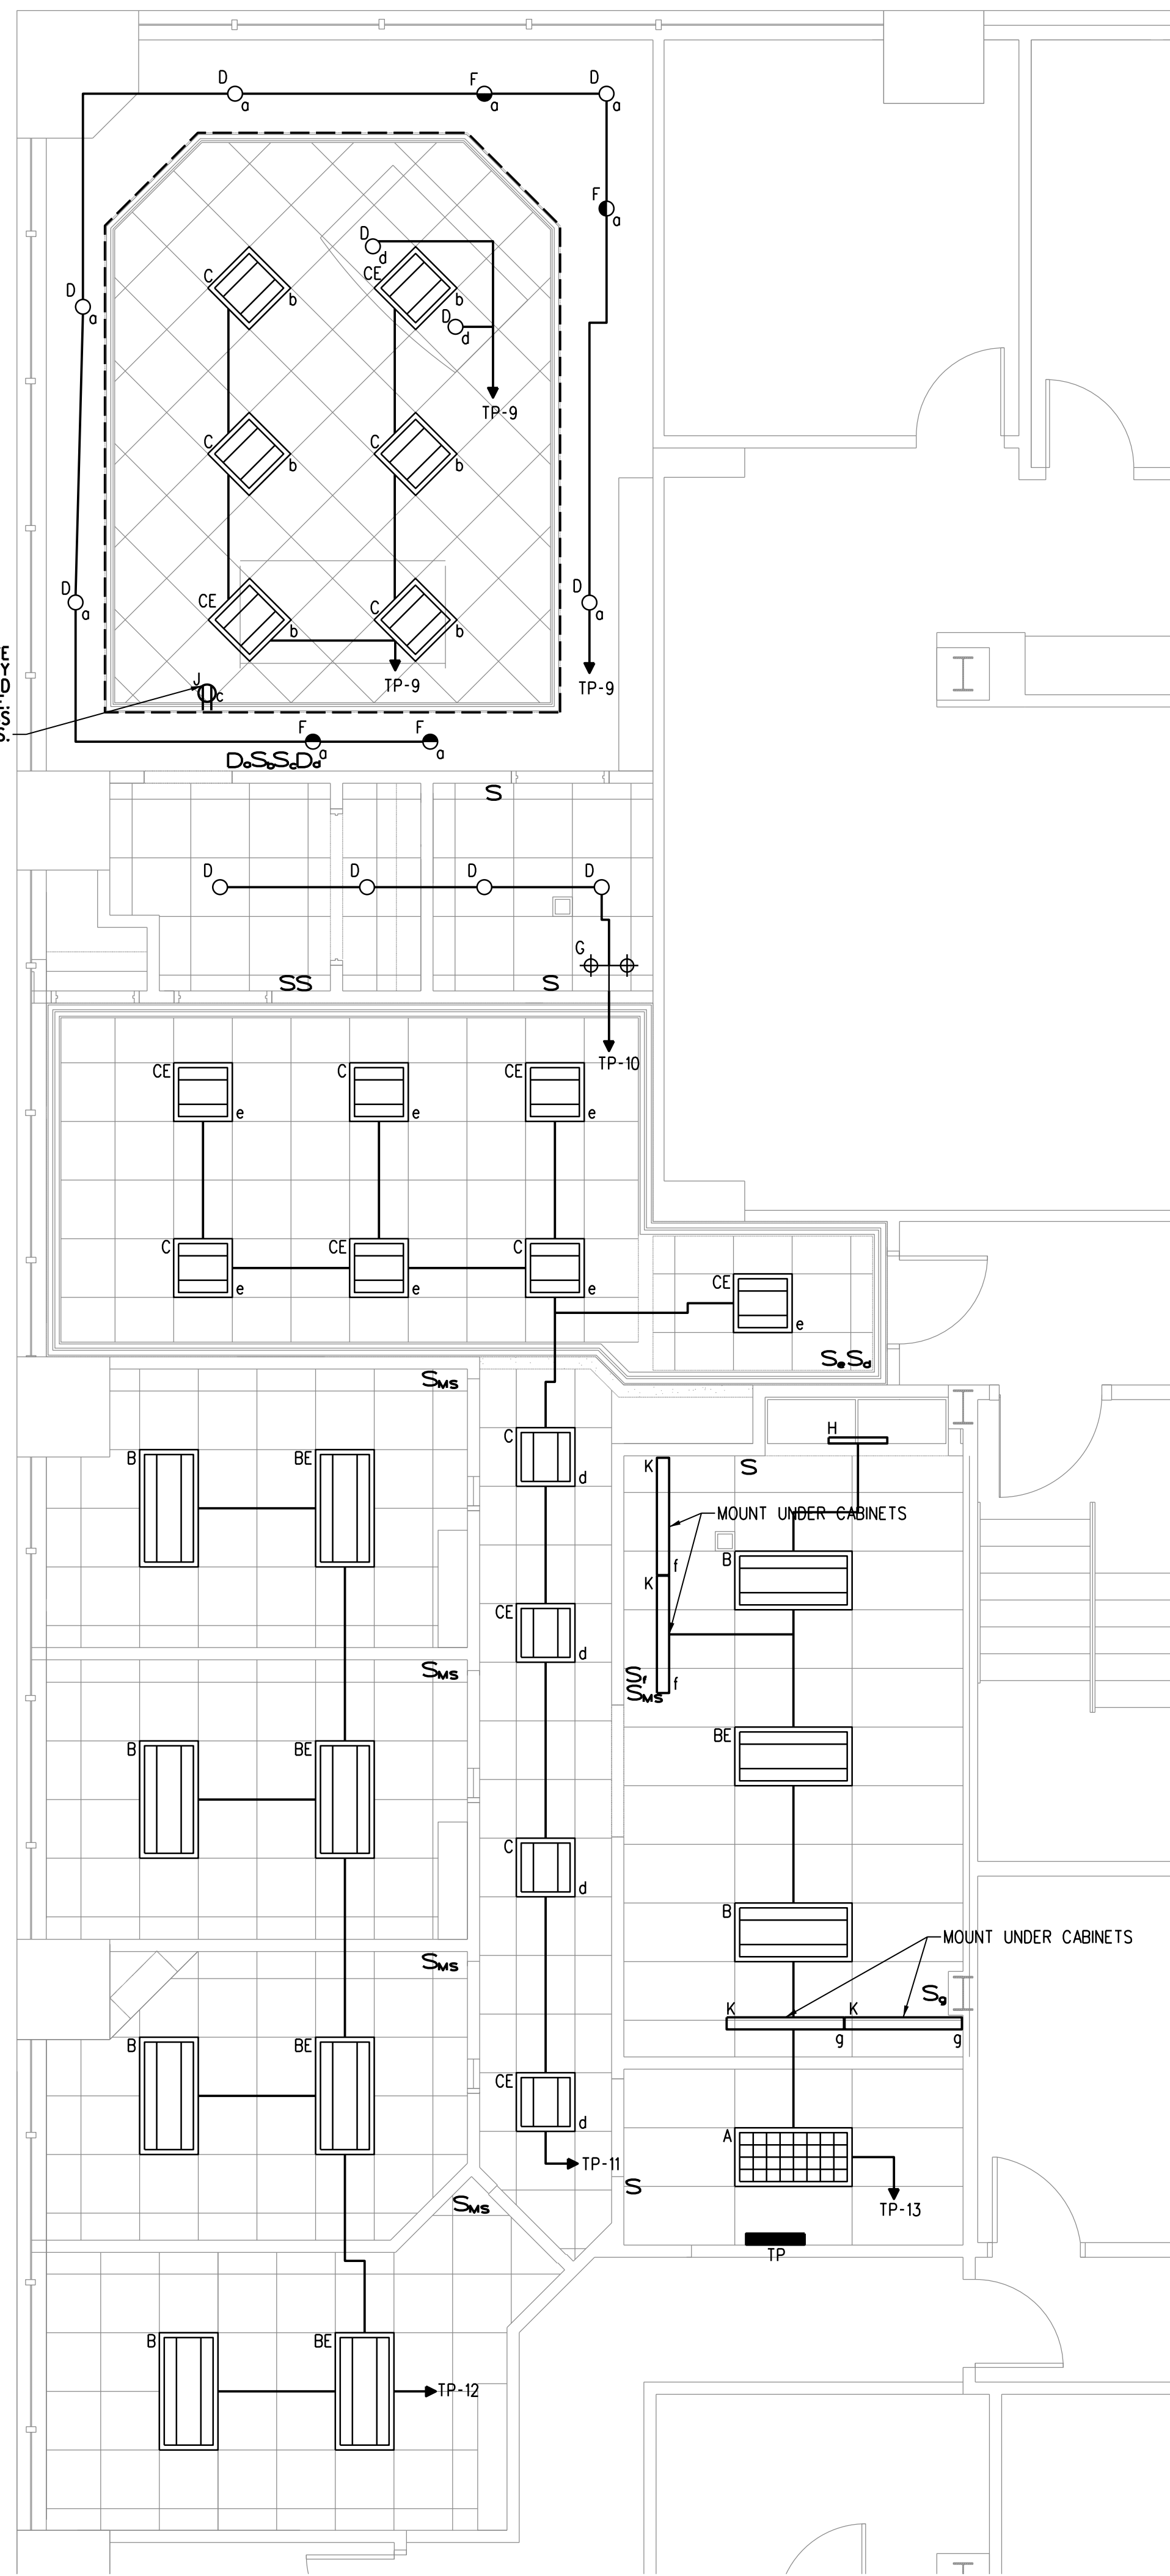

1 | SIXTH FLOOR LIGHTING PLAN  
SCALE: 1/4"=1'-0"

LIGHTING FIXTURE SCHEDULE			
TYPE	DESCRIPTION	LAMPS QUANTITY & TYPE	REMARKS
A	COLUMBIA-P224-228G-LD28-S-EU-EL	(2) 4', T5: 28 WATT LAMPS	2x4 PARABOLIC WITH EMERGENCY BATTERY PACK
B	COLUMBIA-STE24-228G-MPO-EPU	(2) 4', T5: 28 WATT LAMPS	2x4 STRATUS RECESSED INDIRECT
BE	COLUMBIA-STE24-228G-MPO-EPU-EL5	(2) 4', T5: 28 WATT LAMPS	2x4 STRATUS RECESSED INDIRECT WITH EMERGENCY BATTERY PACK
C	COLUMBIA-STE22-324G-MPO-3EPU	(3) 2', T5HO: 24 WATT LAMPS	2x2 STRATUS RECESSED INDIRECT
CE	COLUMBIA-STE22-324G-MPO-3EPU-EL5	(3) 2', T5HO: 24 WATT LAMPS	2x2 STRATUS RECESSED INDIRECT WITH EMERGENCY BATTERY PACK
D	FOCAL POINT FL6D-20LED-L35-LD1-120-RO-T-BH	2000 LUMEN LED MODULE	6" LED RECESSED CAN LIGHT
F	FOCAL POINT FL6W-20LED-L35-LD1-120-RO-T-BH	2000 LUMEN LED MODULE	6" LED RECESSED WALL WASHER LIGHT
G	VERIFY WITH OWNER FOR TYPE	T.B.D.	OVER THE VANITY WALL SCONCE
H	COLUMBIA-W4-228-EPU	(2) 4', T5: 28 WATT LAMPS	LIGHT ON BACK OF SOFFIT OVER CABINETS
J	NATIONAL SPECIALTY LIGHTING-LES-90-WW	.96 WATTS/FOOT LED STRIP LIGHT	UTILIZE POWER SUPPLY TR24L96DC TO POWER LED STRIP LIGHTING
K	COLUMBIA-UC48-132-EU	(1) 48", 32 WATT; T8 LAMP	UNDER CABINET LIGHTS IN KITCHETTE AND WORK COUNTER

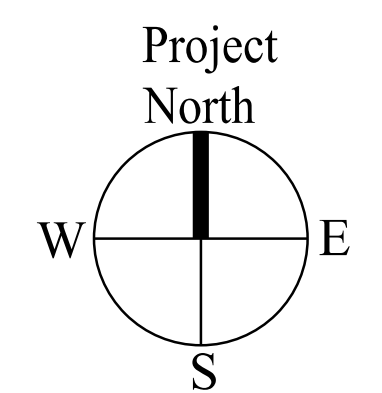

Prepared For:

Consulting Engineer: **BENNETT ENGINEERING** MECHANICAL (207) 866-9476

Architect: **ARCHETYPE architects** 48 Union Wharf Portland, Maine 04101 (207) 772-6022 Fax (207) 772-4056

Project: **GSA- FEDERAL JUDGE- 6th FLOOR** 2 MONUMENT SQUARE PORTLAND, MAINE

Revisions:

Date: July 23rd, 2013 Scale: 1/4" = 1'-0"

SXTH FLOOR LIGHTING PLAN

**E1.01**