



EXTENTS OF SPACE

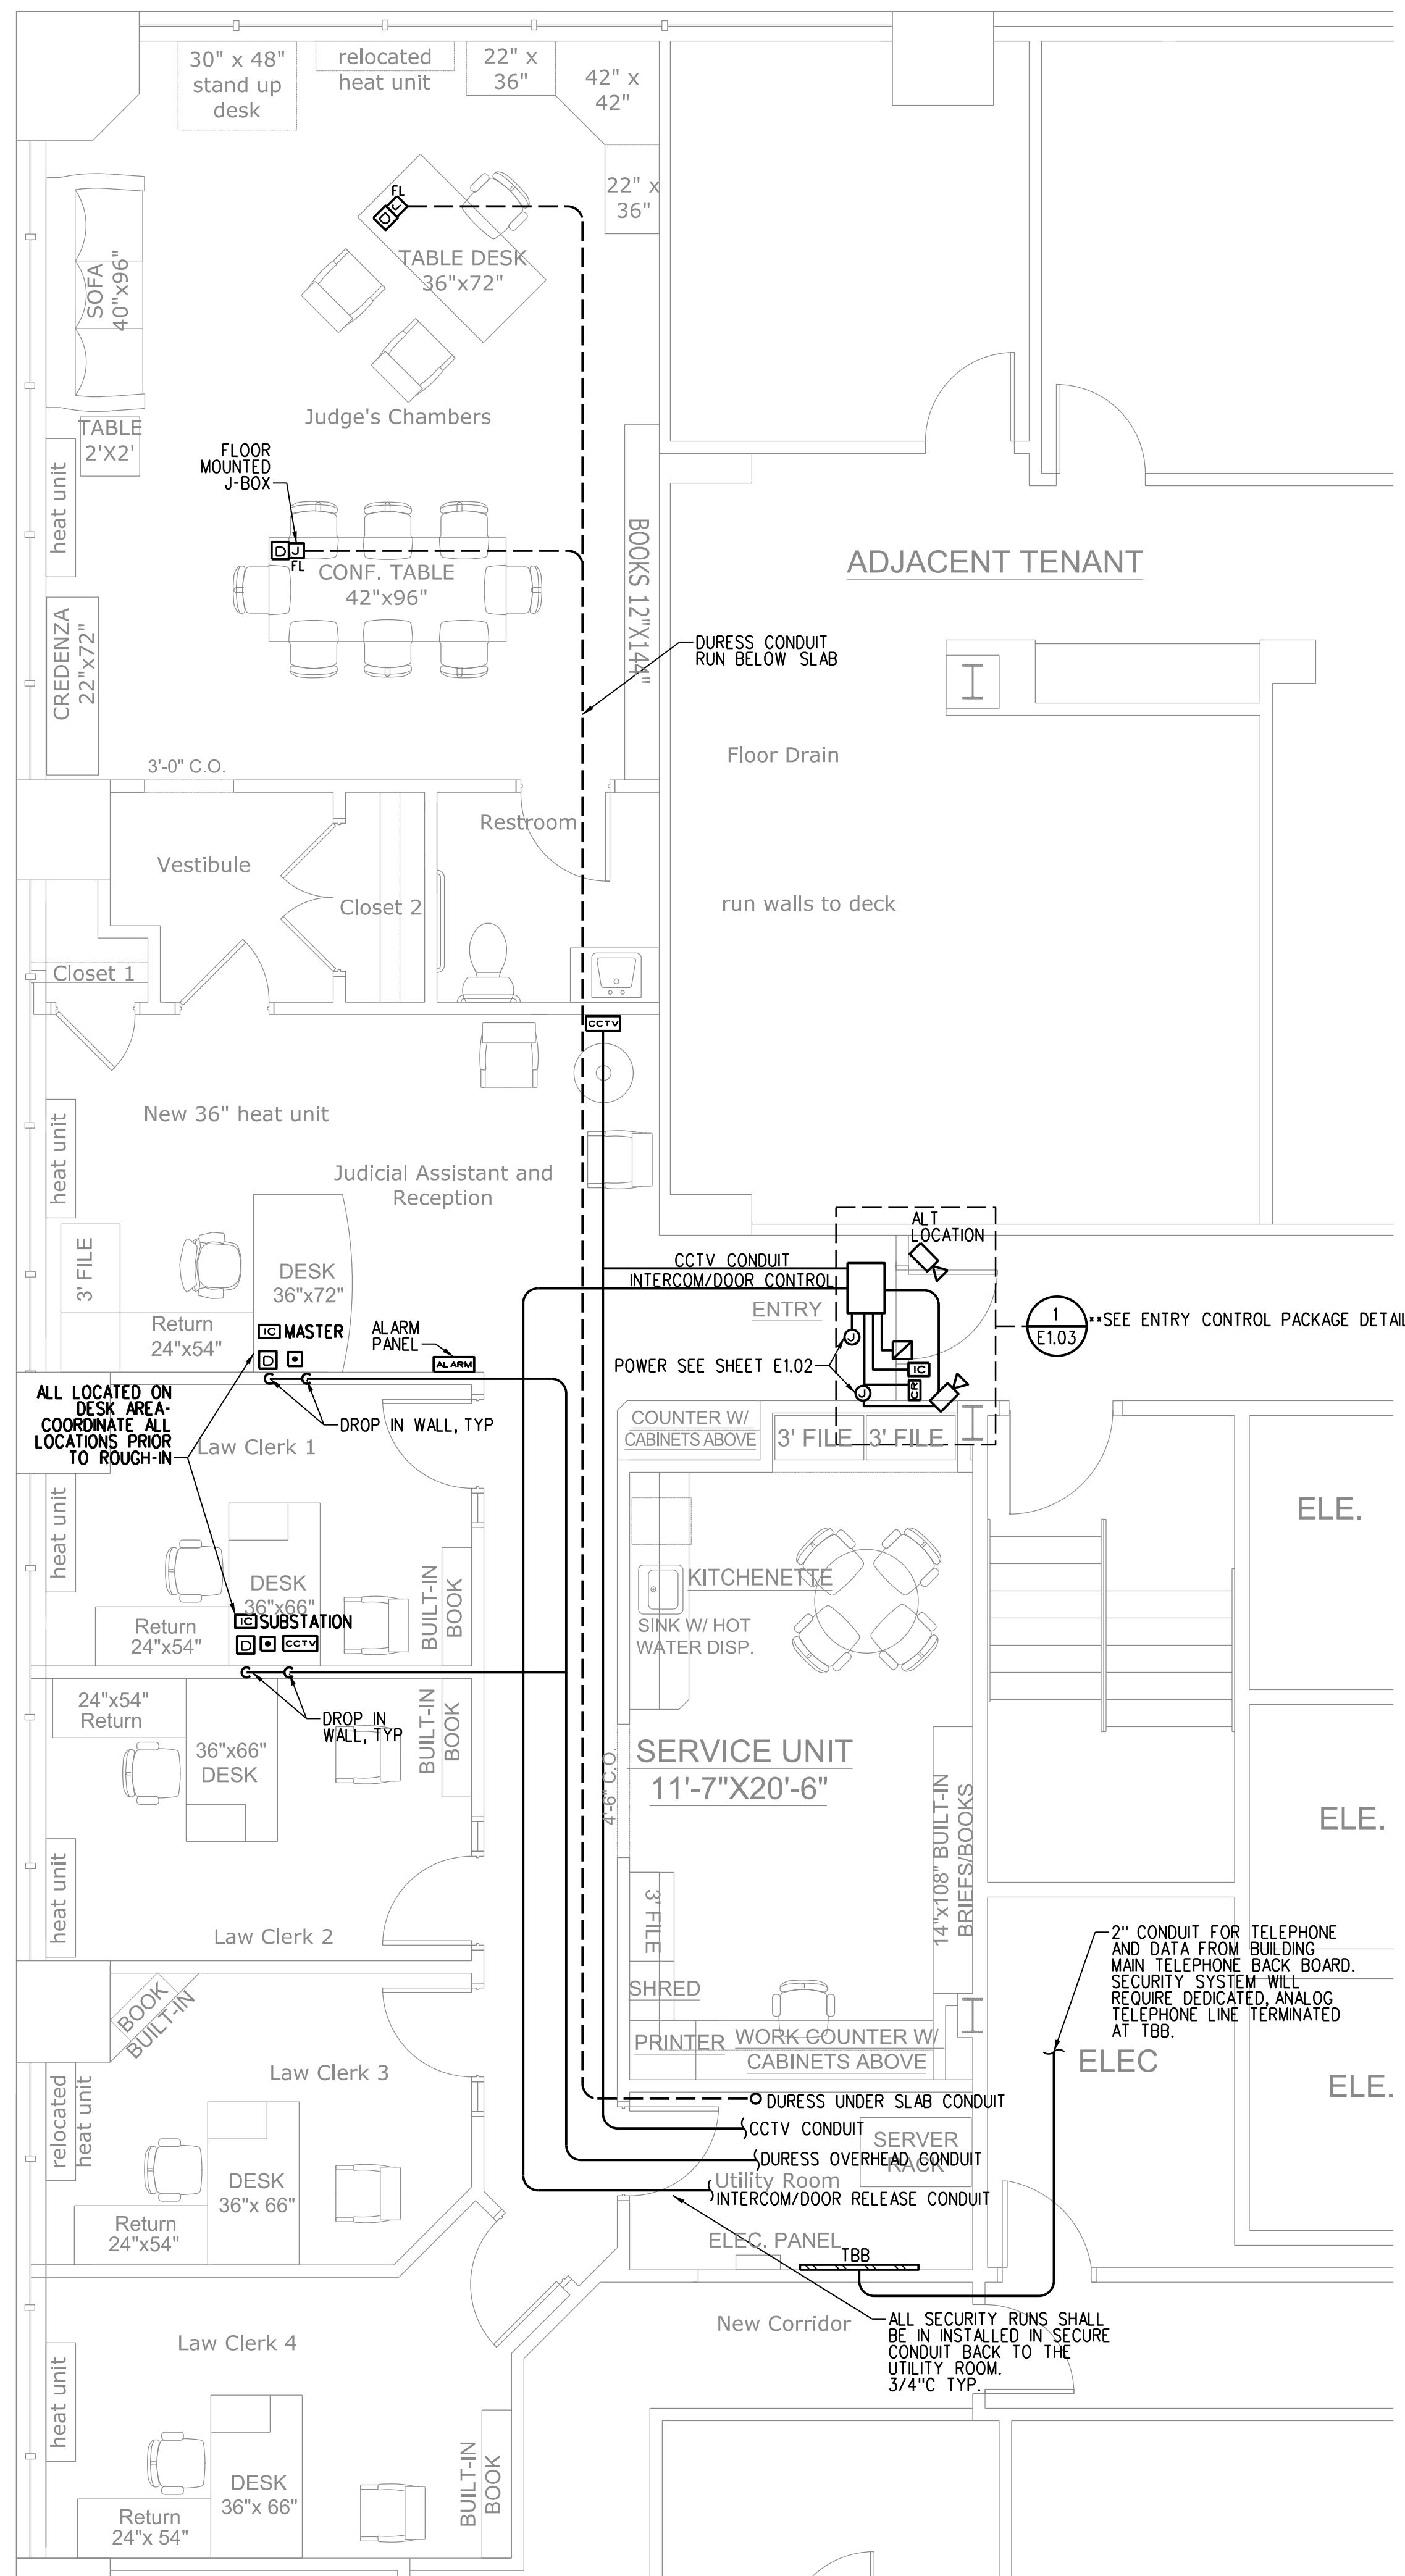


1 | SIXTH FLOOR SECURITY PLAN  
SCALE: 1/4"=1'-0"

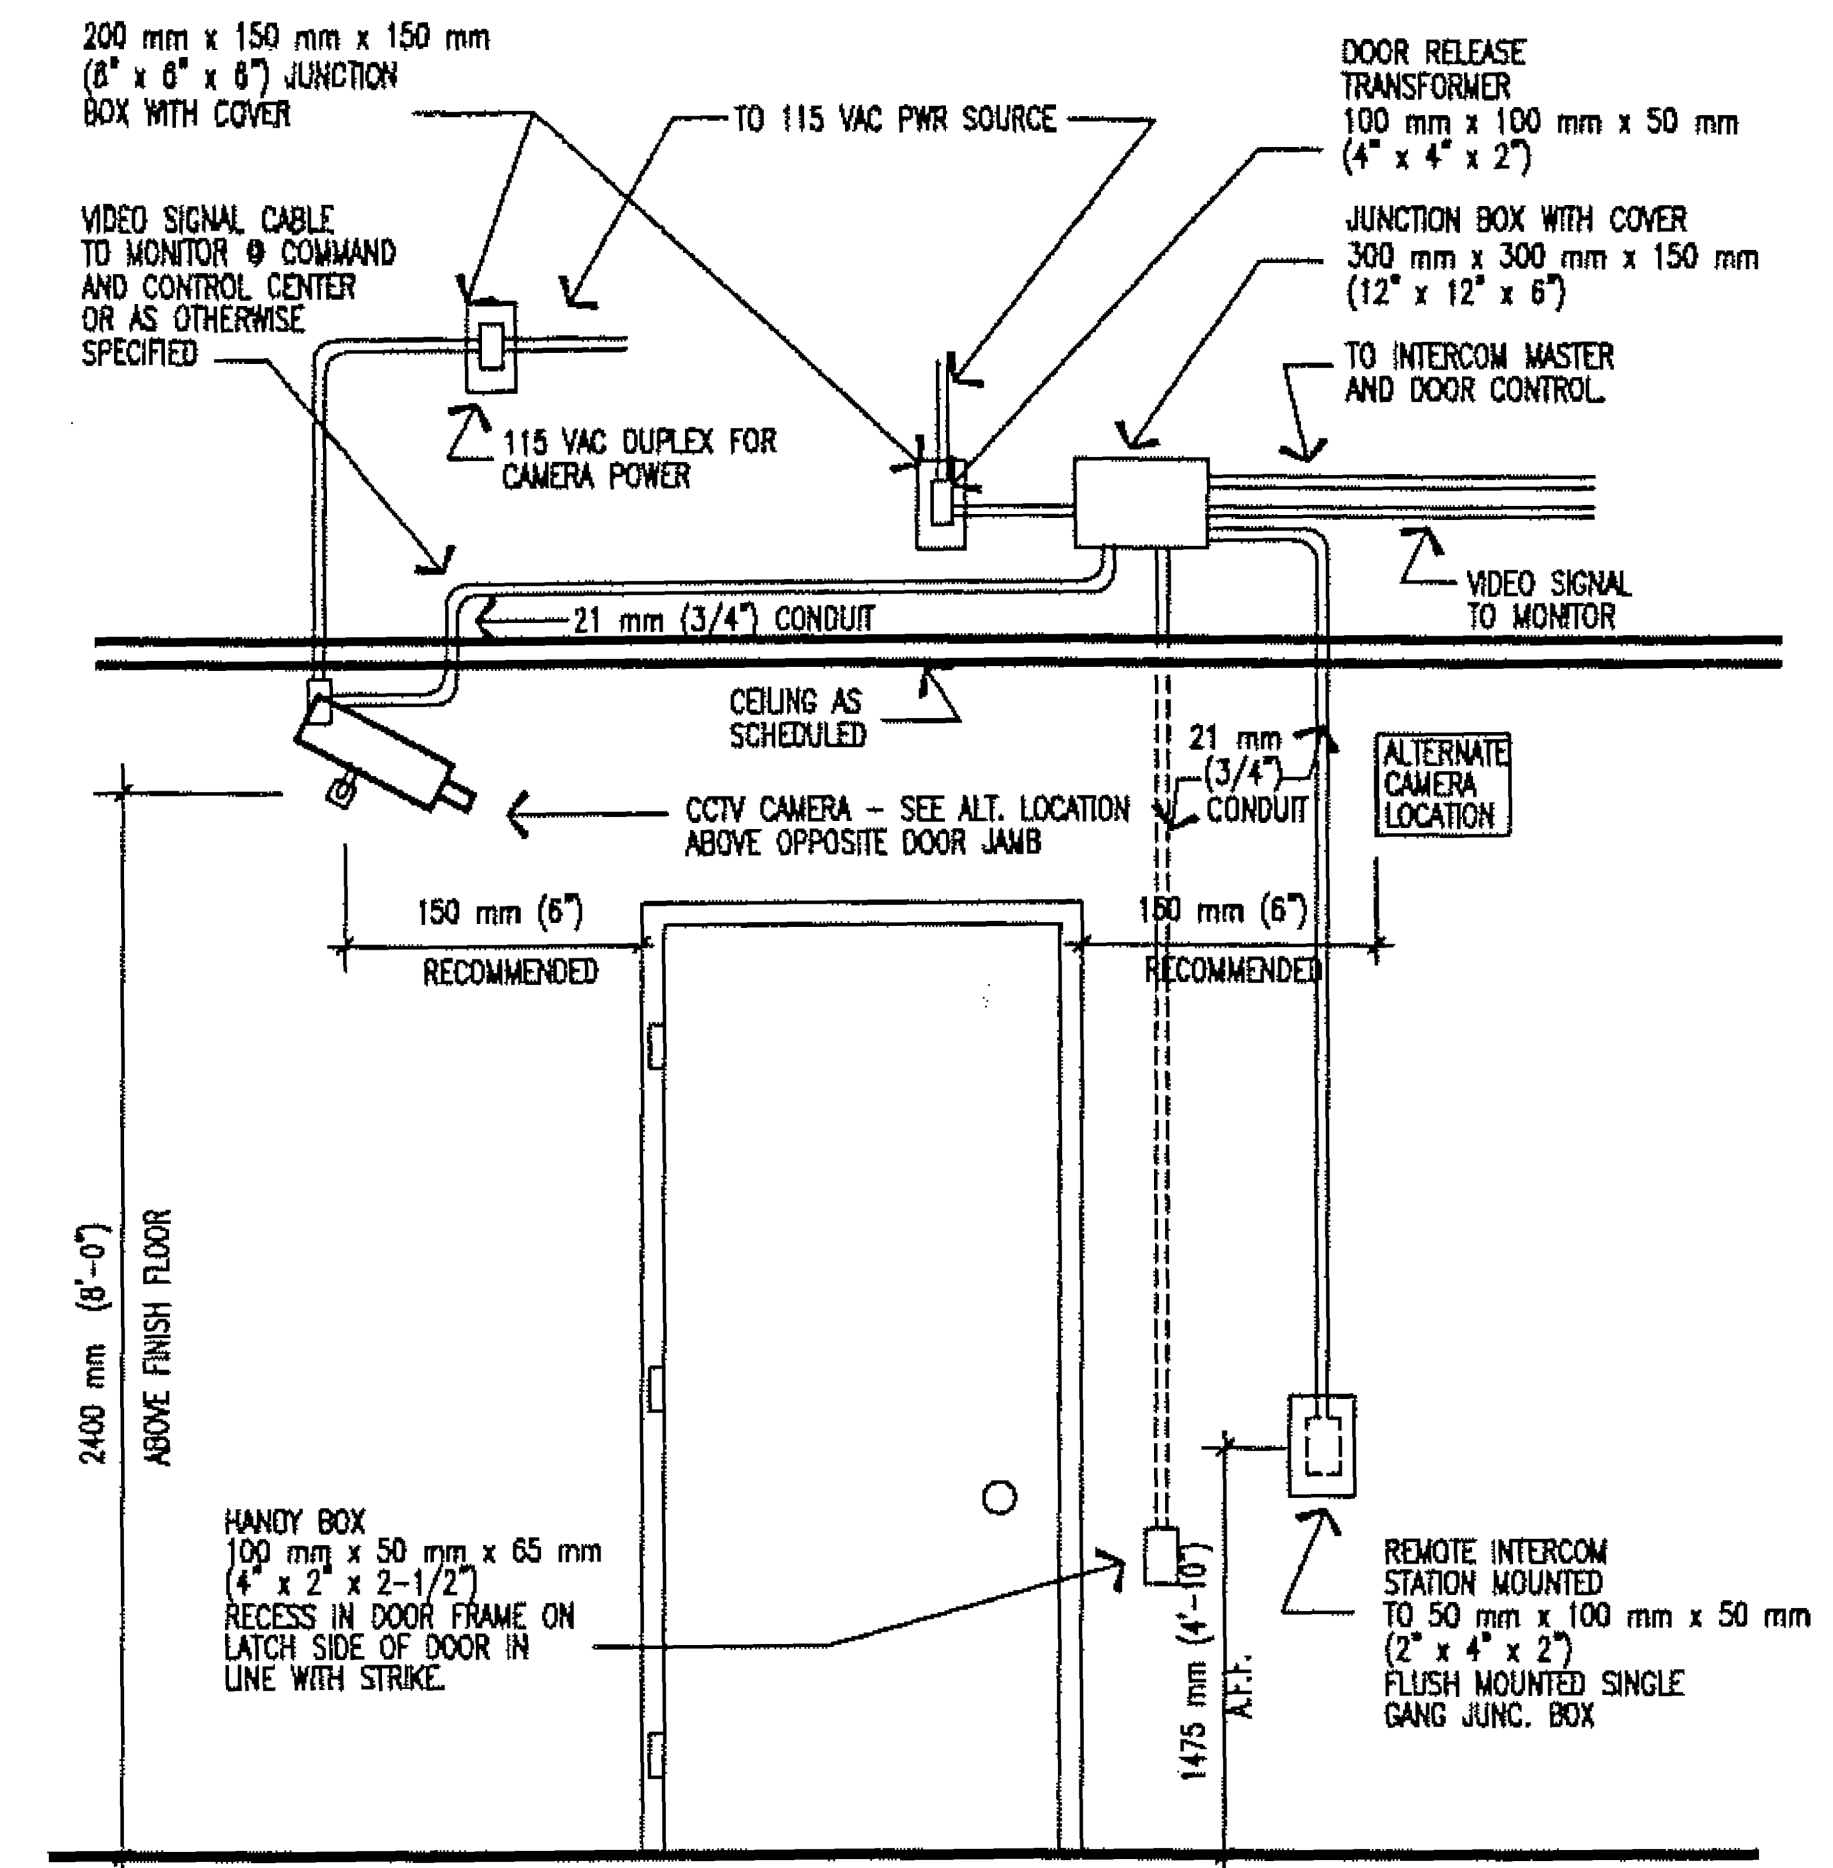

1 | ENTRY CONTROL PACKAGE-DOOR  
SCALE: NOT TO SCALE


SECURITY ELECTRICAL NOTES

1. COORDINATE ALL CONDUIT, BOX PLACEMENT AND DEVICE LOCATION WITH PUBLICATION 64 OF THE MARSHALS GUIDELINES.
2. ALL CONDUIT SHALL BE 3/4" TYPICAL UNLESS OTHERWISE NOTED.
3. ANY POWER REQUIREMENTS, REFERENCE DRAWING E1.02 FOR CIRCUITING.

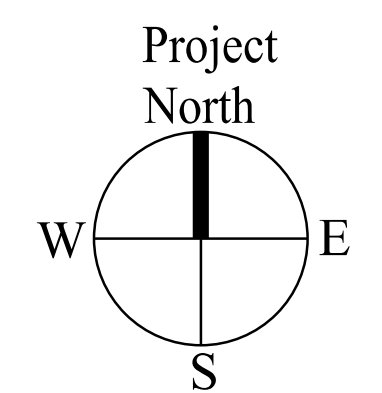

EXTENTS OF SPACE

Prepared For:

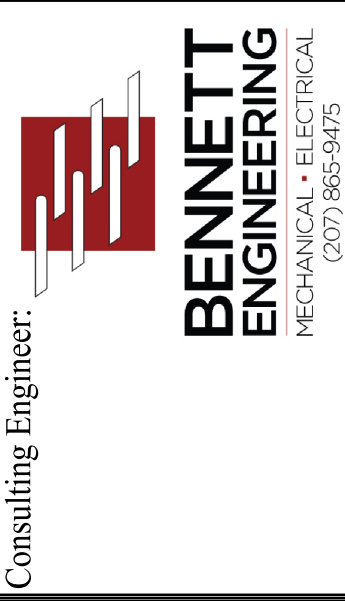

Project: GSA- FEDERAL JUDGE- 6th FLOOR  
2 MONUMENT SQUARE PORTLAND, MAINE

Revisions:

Date: July 23rd, 2013  
Scale: 1/4" = 1'-0"

SXTH FLOOR SECURITY PLAN  
E1.03