


C:\Revit\2015 Local Files\ME PORTLAND_1\MONUMENT SQ_09-10_FP_BAC_CENTRAL_msklinen.rvt

DYER BROWN & ASSOCIATES, INC. ©2015 ALL RIGHTS RESERVED - PLOTTED: 5/11/2015 2:46:11 PM

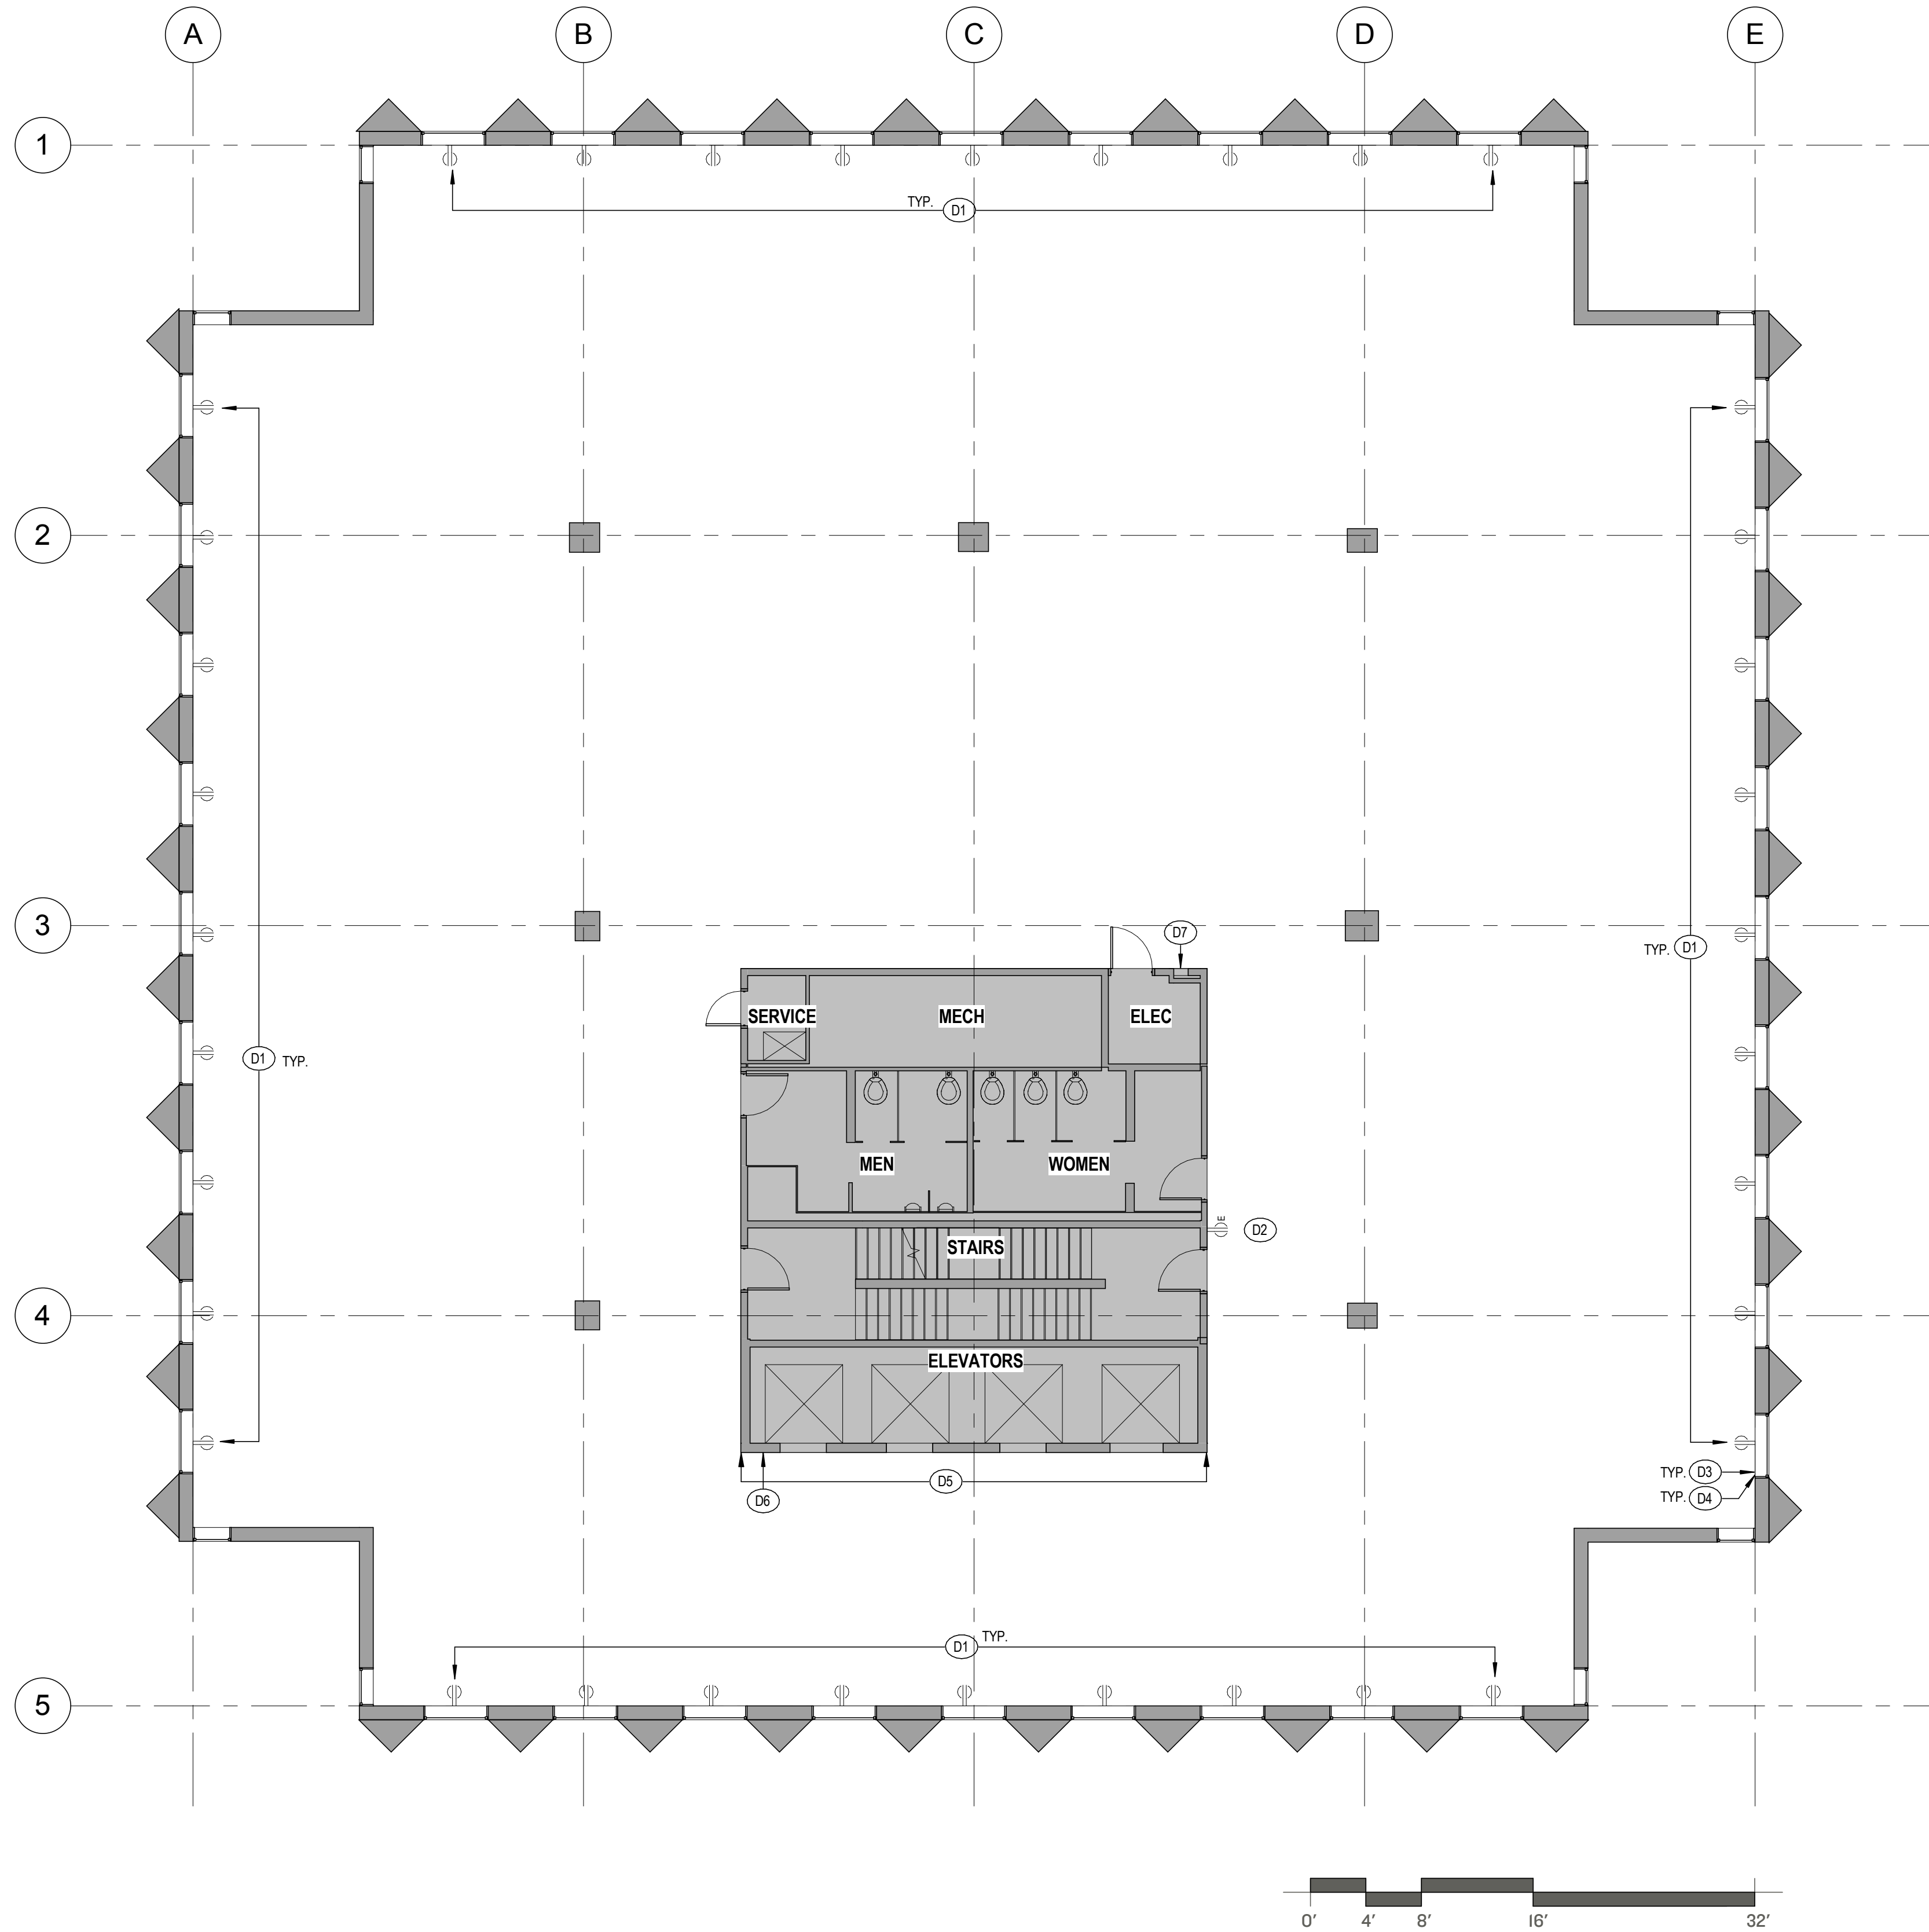

1 9th FLOOR DEMOLITION PLAN
1/8" = 1'-0"

DEMOLITION NOTES

1. DEMOLITION NOTES BELOW APPLY TO THE ENTIRE PLAN AREA SHOWN WITHIN THE SCOPE OF WORK LINE.
2. COORDINATE DEMOLITION WITH NEW WORK. G.C. TO REVIEW CONSTRUCTION DOCUMENTS WITH EXISTING CONDITIONS AND NOTIFY ARCHITECT IMMEDIATELY OF ANY CONFLICTS.
3. CONTRACTOR TO MAINTAIN SECURITY OF ALL SPACES DURING TO DEMOLITION AND THROUGHOUT CONSTRUCTION.
4. REMOVE ALL MISCELLANEOUS ITEMS ATTACHED TO COLUMNS (1" WIRE MOLD, OUTLETS, BASE, MOLDINGS, ETC) UNLESS NOTED OTHERWISE.
5. REMOVE PIPING WHERE INDICATED ON ENGINEERING DRAWINGS.
6. REMOVE PIPING IN CHASES OR COLUMNS STRIPPED OF FURRING AS INDICATED. COORDINATE WITH DEMOLITION WITH ENGINEERING DRAWINGS.
7. FIRE ALARM SYSTEM SHALL REMAIN IN OPERATION DURING CONSTRUCTION.
8. EXISTING ELECTRICAL PANELS TO REMAIN.
9. REMOVE ALL TELEPHONE WIRING AND EQUIPMENT. REMOVAL TO BE COORDINATED WITH DATA VENDOR.
10. IF CIRCUIT IS IN DEMOLITION SCOPE, REMOVE WIRING BACK TO PANEL.
11. EXISTING WINDOW TREATMENTS TO BE REMOVED BY LANDLORD AND REPLACED BY LANDLORD AT COMPLETION OF PROJECT.

DEMOLITION PLAN KEYNOTES

NOTE	DESCRIPTION
D1	EXISTING ELECTRICAL OUTLETS LOCATED ON PERIMETER WALLS AND CORE WALLS TO BE REMOVED.
D2	EXISTING ELECTRICAL OUTLETS ON THE CORE TO BE REMOVED AND REPLACED WITH NEW.
D3	REMOVE EXISTING WOOD & ALUMINUM SILLS, TYPICAL ALL LOCATIONS.
D4	REMOVE HORIZONTAL WOOD TRIM AT WINDOW HEADS, TYPICAL ALL LOCATIONS.
D5	REMOVE WOOD PANELING AND WOOD BASE.
D6	REMOVE EXISTING MAIL CHUTE RUNNING THROUGH FLOORS 9 AND 10. CAP CHUTE FLUSH WITH FLOOR AS DIRECTED BY LANDLORD.
D7	REMOVE EXISTING FIRE EXTINGUISHER CABINET AND EXTINGUISHER. MAINTAIN OPENING TO RECEIVE NEW FEC.



Brent D. Zeigler

REVISIONS

BANK OF AMERICA - 9TH & 10TH FLOORS

BANK OF AMERICA
1 MONUMENT SQUARE
Portland, ME

TITLE
9TH FLOOR DEMOLITION PLAN

DATE May 11, 2015
JOB NO. 15051.00

DRAWING NO. **D1.09**

ISSUED FOR CONSTRUCTION