



NOTES:

- 1. SEE SHEET M-001 FOR LEGEND AND ABBREVIATIONS.

KEYED NOTES:

- ① RS/RL TO BE SIZED PER MANUFACTURERS RECOMMENDATIONS.

**SMRT** ARCHITECTURE 144 Fore Street/P.O. Box 618  
 ENGINEERING Portland, Maine 04104  
 PLANNING tel. (207) 772-3846  
 INTERIOR DESIGN fax. (207) 772-1070  
 COMMISSIONING www.smrtinc.com  
 SMRT PROJECT #15035

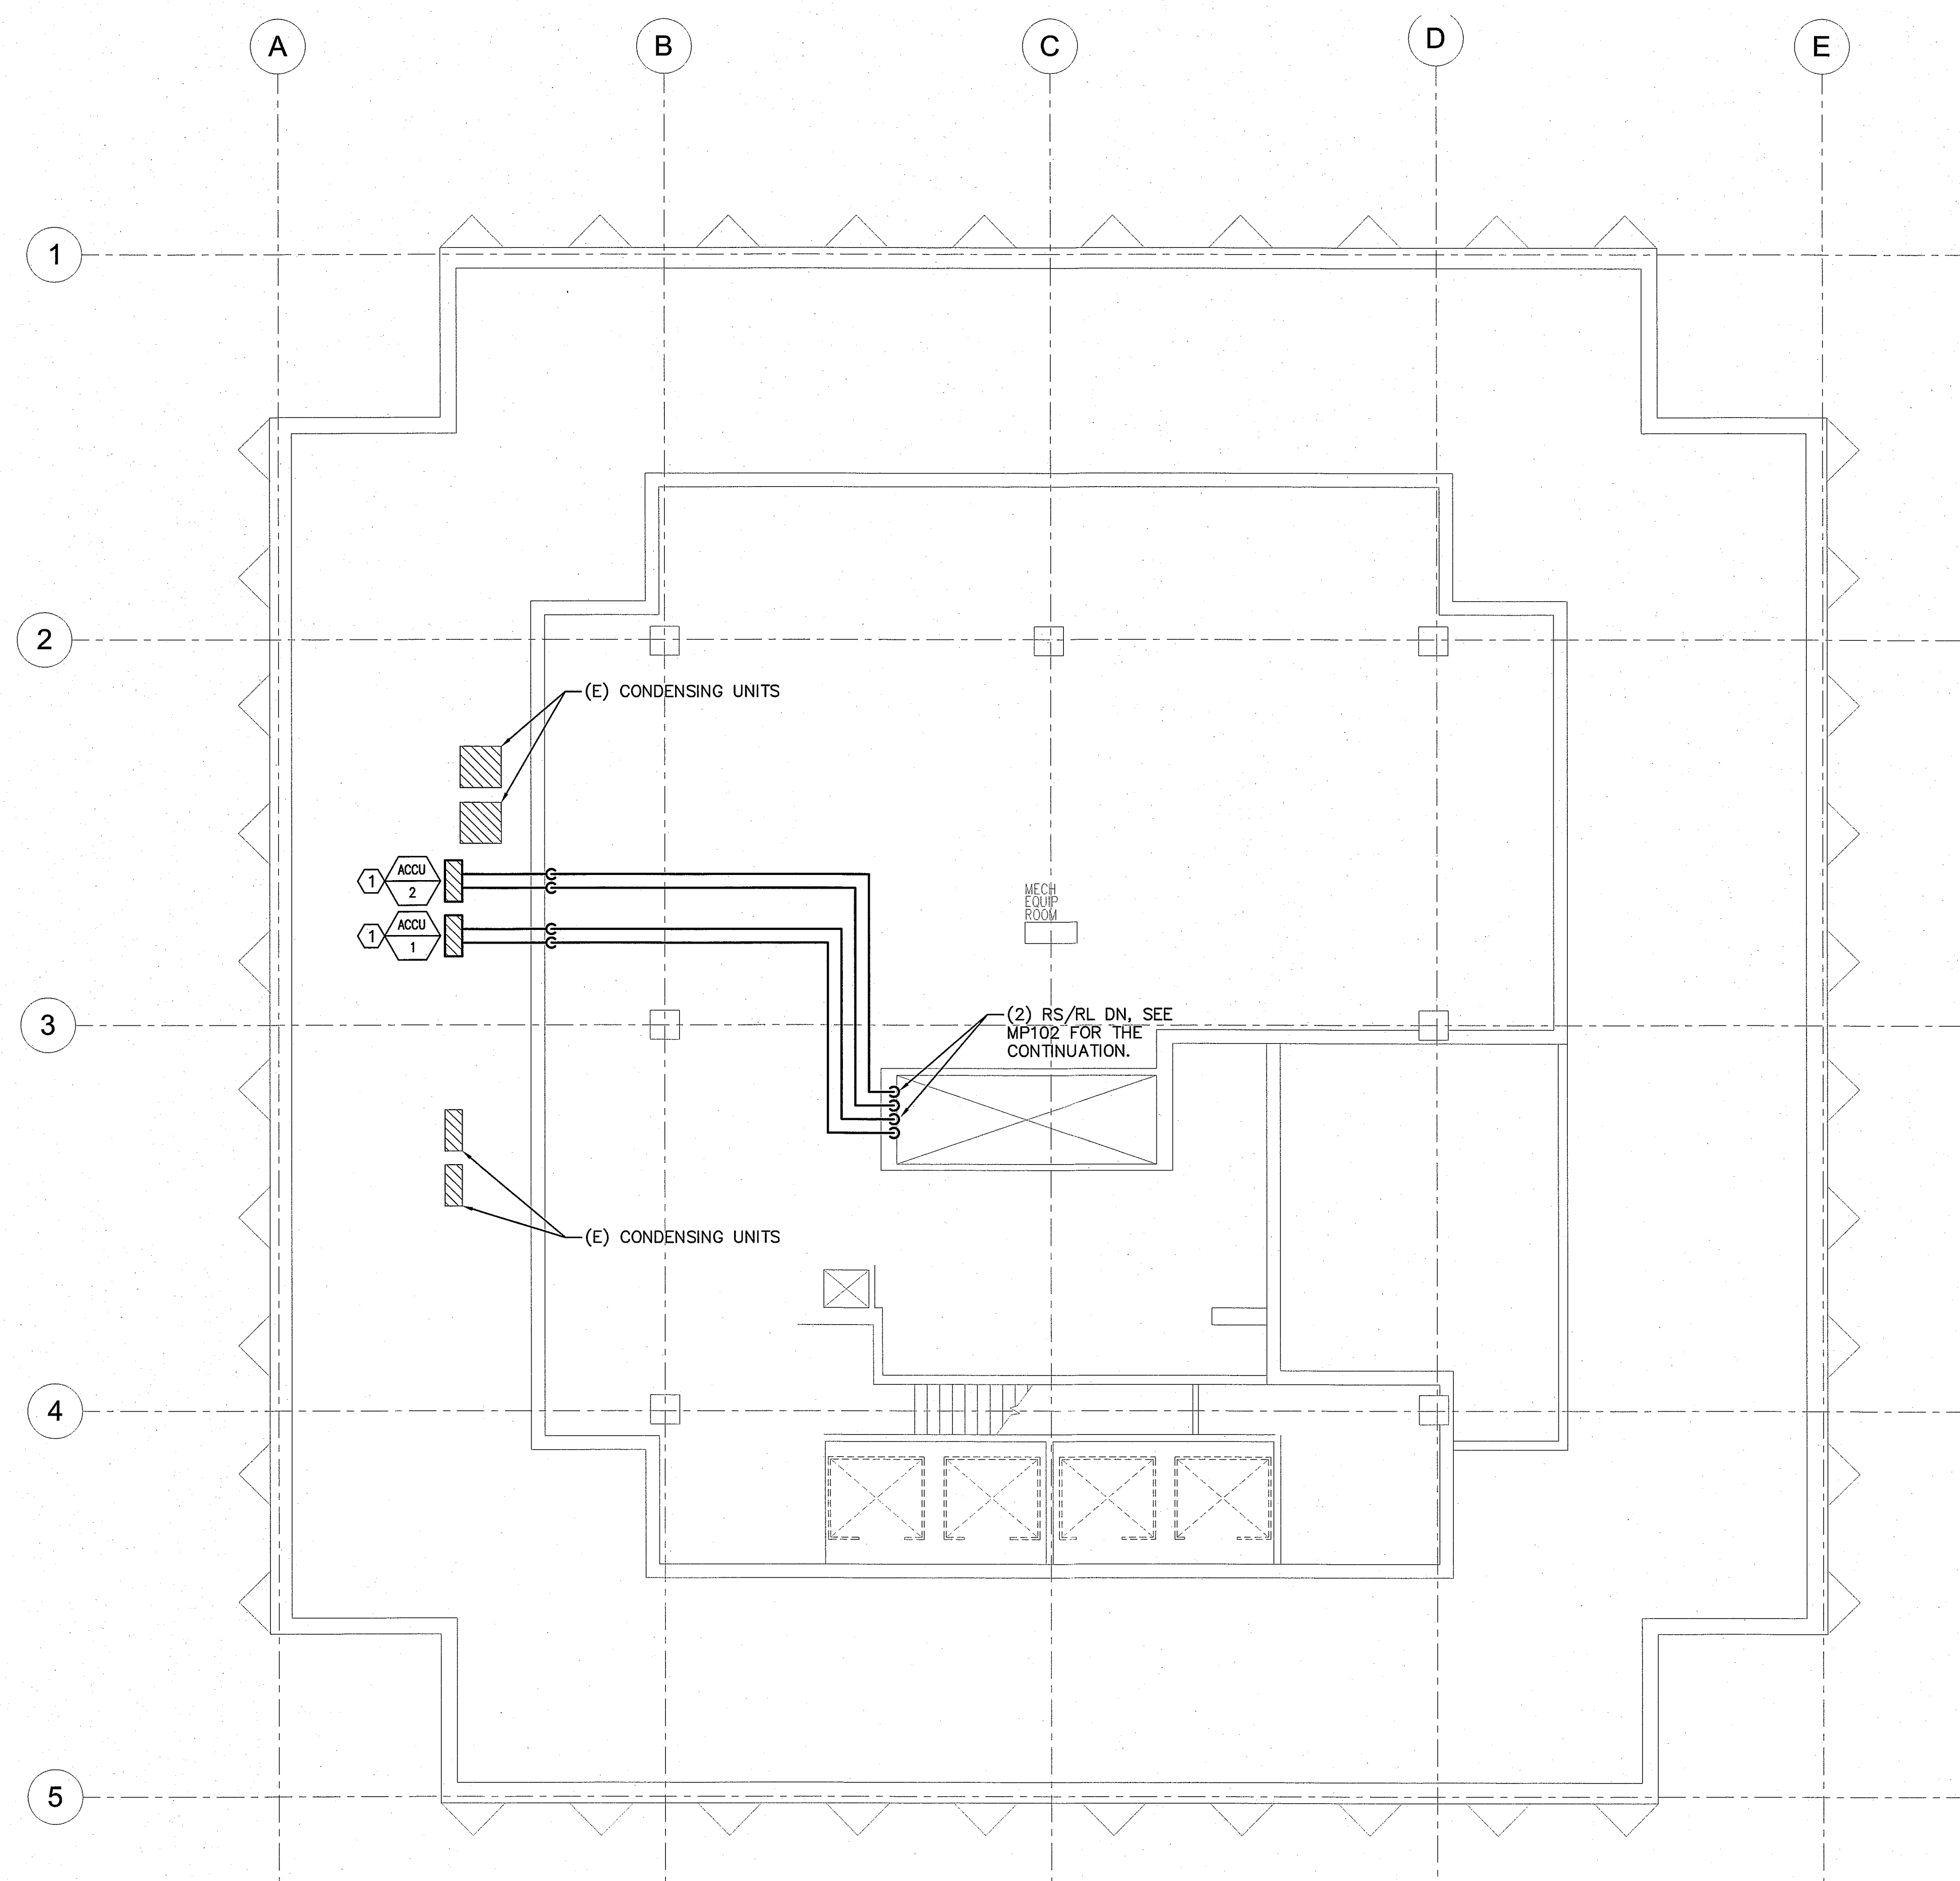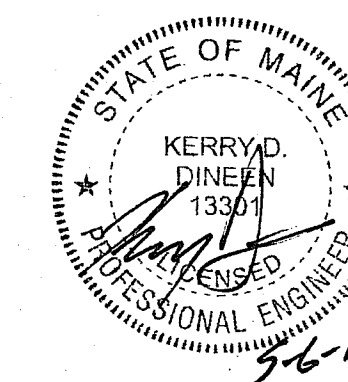

**1** PENTHOUSE AND ROOF FLOOR PLAN  
 1/8" = 1'-0"

**REVISIONS**

**BANK OF AMERICA - 9TH & 10TH FLOORS**

BANK OF AMERICA  
 1 MONUMENT SQUARE  
 Portland, ME

**TITLE**  
 PENTHOUSE AND ROOF HVAC PIPING PLAN

**DATE**                      **JOB NO.**  
 May 11, 2015              15051.00

**DRAWING NO.**              **MPI03**

ISSUED FOR CONSTRUCTION

