



1 7TH FLOOR REFLECTED CEILING PLAN
 SCALE: 1/8" = 1'-0"
 2' 4' 8' 16'
 AREA N.I.C.

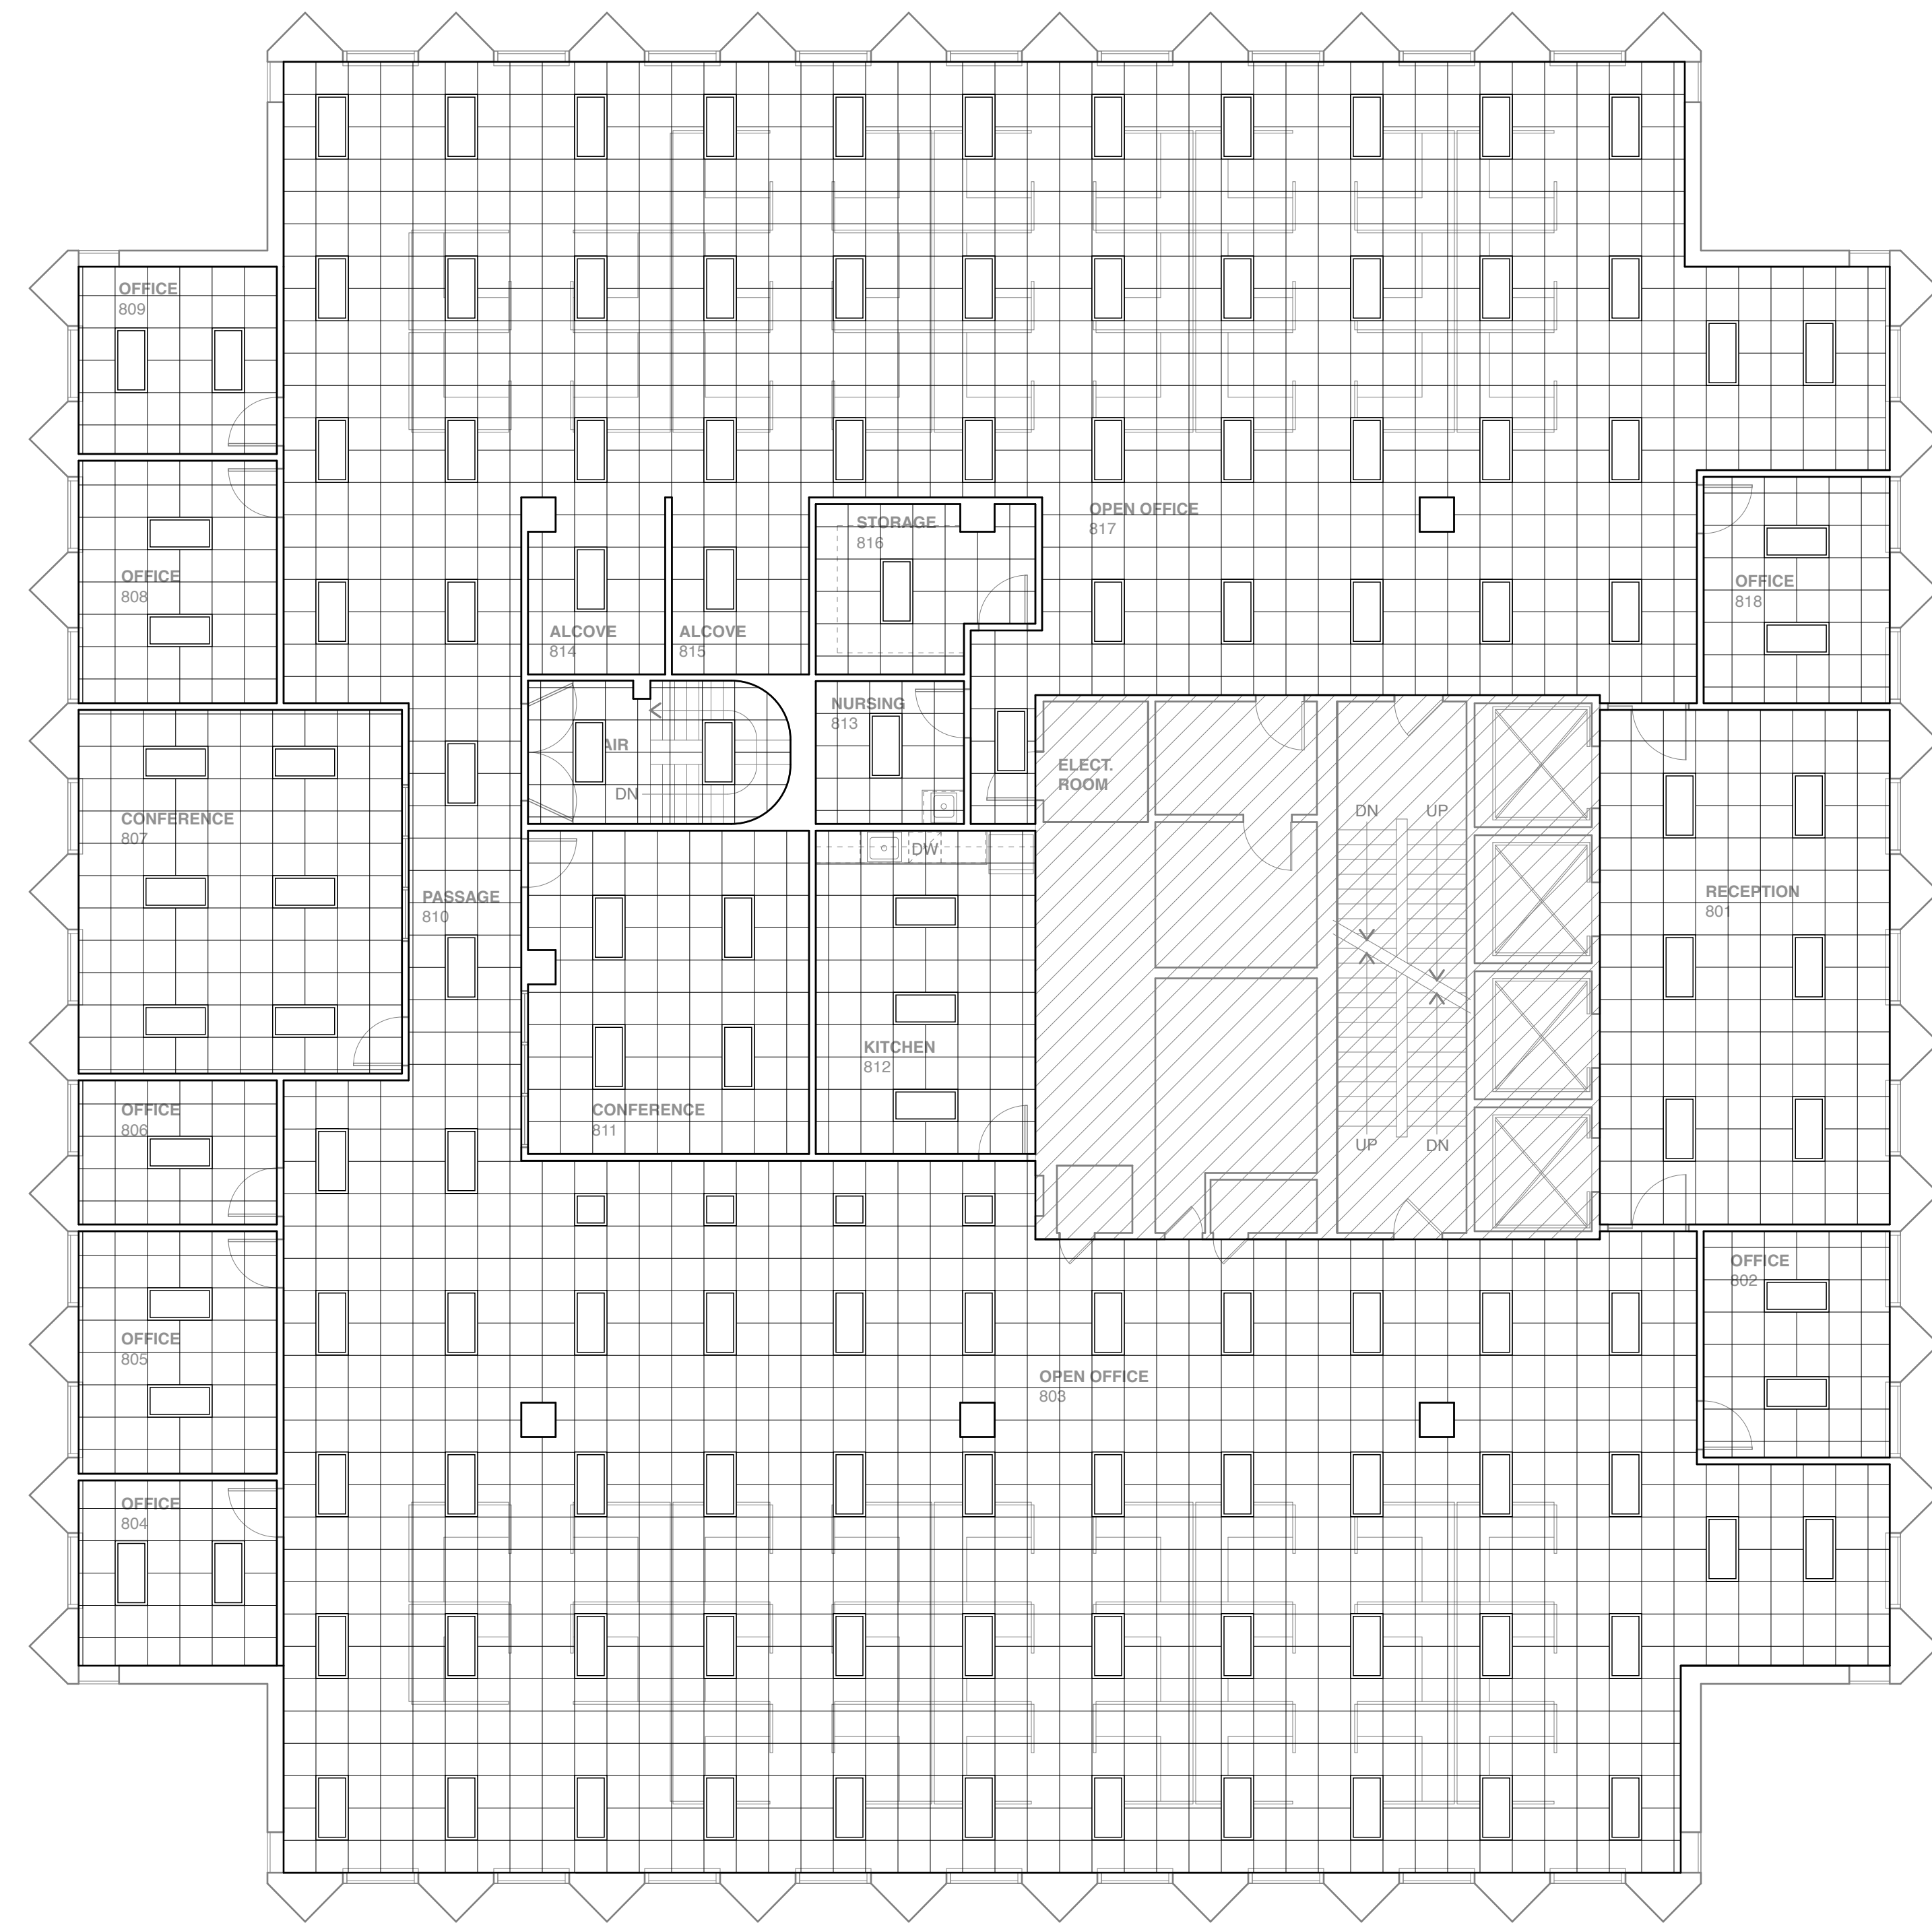

1 8TH FLOOR REFLECTED CEILING PLAN
 SCALE: 1/8" = 1'-0"
 2' 4' 8' 16'
 AREA N.I.C.


- REFLECTED CEILING PLAN GENERAL NOTES**
1. PLAN SHOWS CEILING GRID AND LIGHT FIXTURE LAYOUT ONLY.
 2. DIFFUSER AND GRILLE LOCATIONS, SIZES, AND TYPES, TO BE DETERMINED BY MECHANICAL CONTRACTOR
 3. SPRINKLER HEAD LOCATIONS TO BE DETERMINED BY SPRINKLER CONTRACTOR.

- REFLECTED CEILING PLAN LEGEND**
- 2 X 4 GRID SUSPENDED CEILING
 - 2 X 4 LED TROFFER
 - 2 X 2 LED TROFFER

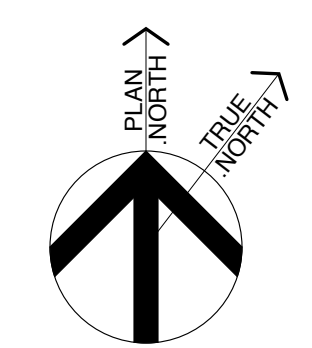

Michael Charek Architects

25 Hartley Street
 Portland, Maine 04103
 (207) 761-0556

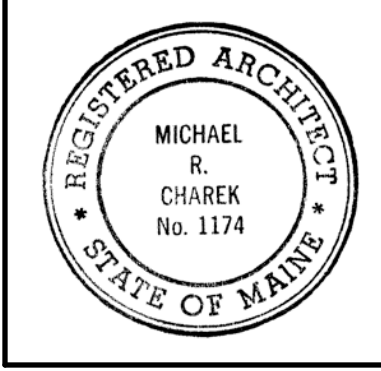

Offices for BlueTarp Financial

Seventh and Eighth Floor
 One Monument Square
 Portland, Maine

Title
 REFLECTED CEILING PLANS

Scale: 1/8" = 1'-0"

Date: 4/10/15

Revisions

Sheet
A3