



*Brent D. Zeigler*

LIGHTING FIXTURE SCHEDULE				
Type Mark	Description	Manufacturer	Model	Comments
F1a	8'-0" LED PENDANT	LITECONTROL	RAIL	
F1b	4'-0" LED PENDANT	LITECONTROL	RAIL	
F2a	1x4" RECESSED LED	LITHONIA	VTL	
F2b	2x2" RECESSED LED	LITHONIA	2xTL	
F3	4" LED DOWNLIGHT	GOTHAM	EVO	
F4	4" LED WALL WASHER	GOTHAM	EVO	
F5	DECORATIVE LED PENDANT	FLOS	FUCSIA	
F6	DECORATIVE LED PENDANT	ARTEMIDE	LOGICO	
F7	UNDER SHELF TASK LIGHT	PHILIPS DAY-BRITE	LINCS	
F8	4'-0" UTILITY STRIP FIXTURE	LITHONIA	ZLIN	
F9	RECESSED LINEAR LED	FOCAL POINT	FSM	
F10	RECESSED LINEAR WALL WASHER	FOCAL POINT	FSMA	

- RCP NOTES**
- FINISH CEILING HEIGHT SHALL BE AS NOTED.
  - UNLESS NOTED OTHERWISE, ALL FIXTURES, ACT AND CEILING GRID SHOWN ARE NEW.
  - THE CONTRACTOR SHALL CAREFULLY REVIEW ALL ATTACHMENT CONDITIONS FOR NEW FURRED OR SUSPENDED CEILINGS TO PROVIDE PROPER CLEARANCES.
  - SEE ELECTRICAL PLAN FOR SMOKE, HEAT, AND MOTION DETECTORS.
  - SEE ELECTRICAL PLAN FOR FIXTURES, CIRCUITS, AND EMERGENCY POWER.
  - SEE SPRINKLER PLAN TO COORDINATE HEAD LOCATIONS.
  - SEE HVAC PLAN TO COORDINATE CEILING DIFFUSERS, GRILLES, AND FAN LOCATIONS.
  - PROVIDE ACCESS PANELS REQUIRED BY ELECTRICAL, PLUMBING, HVAC AND OTHER TRADES.
  - ALL SPRINKLER HEADS IN ACOUSTIC TILE CEILINGS SHALL BE CENTERED IN THE TILE. IN GWB CEILINGS, THEY SHALL BE SPECIFICALLY LOCATED PER DIMENSIONED PLAN OR ARCHITECT'S DIRECTION.
  - SWITCH MOUNTING HEIGHT TO BE 48" AFF UNLESS NOTED OTHERWISE.
  - SEE ENGINEERING DRAWINGS FOR ROOMS THAT REQUIRE OCCUPANCY SENSORS.

BANK OF AMERICA HAS A NATIONAL AGREEMENT WITH WIEDENBACH BROWN FOR PURCHASING LIGHT FIXTURES AND CONTROLS. CONTACT ROBERT NELSON robert.nelson@wblight.com or (214) 679-2400.

CEILING PLAN KEYNOTES	
NOTE	DESCRIPTION
R1	GWB CEILING TO RECEIVE BENJAMIN MOOR CEILING WHITE.

**REVISIONS**

**BANK OF AMERICA - 9TH & 10TH FLOORS**

BANK OF AMERICA  
 1 MONUMENT SQUARE  
 Portland, ME




**TITLE**  
 10TH FLOOR REFLECTED CEILING PLAN

**DATE** May II, 2015  
**JOB NO.** 15051.00


**DRAWING NO.** **A3.10**

ISSUED FOR CONSTRUCTION

C:\Revit\2015 Local Files\ME PORTLAND\_1\MONUMENT SQ\_09-10\_FP\_BAC\_CENTRAL\_mckinnon.rvt  
 DYER BROWN & ASSOCIATES, INC. ©2015 ALL RIGHTS RESERVED - PLOTTED: 5/11/2015 2:44:59 PM

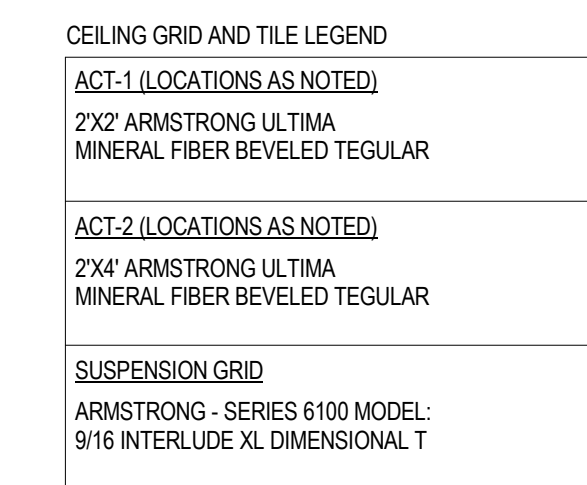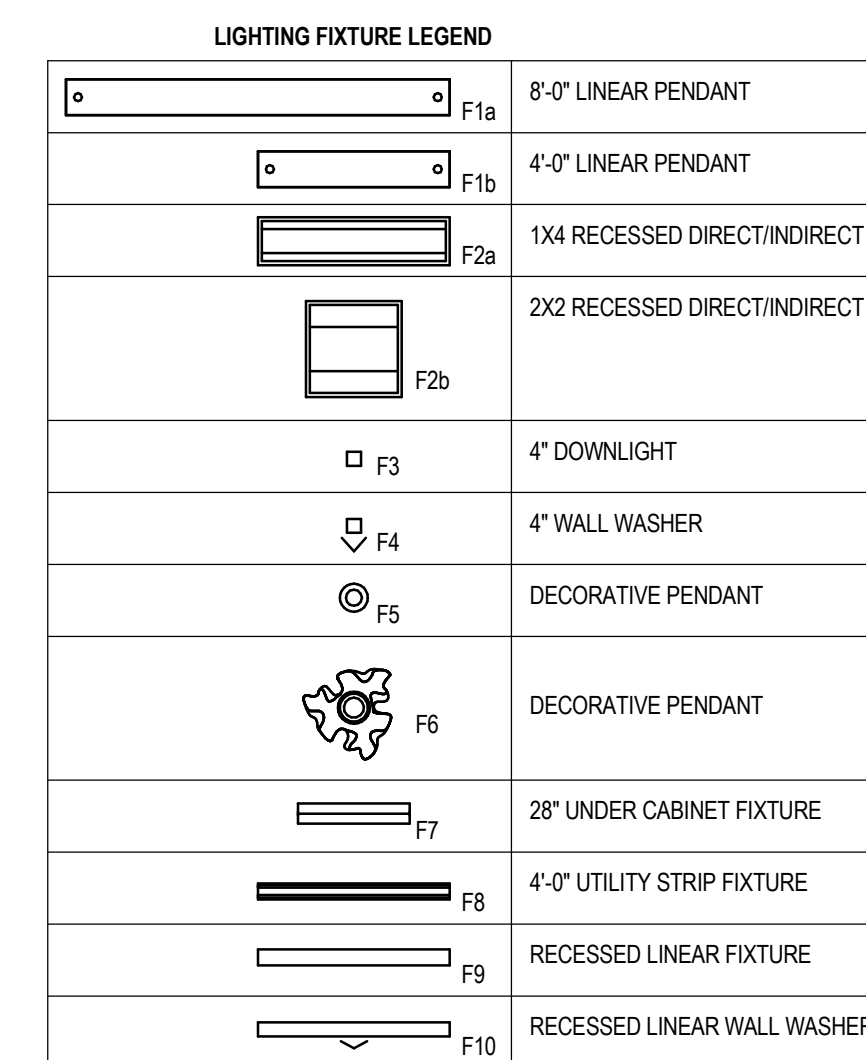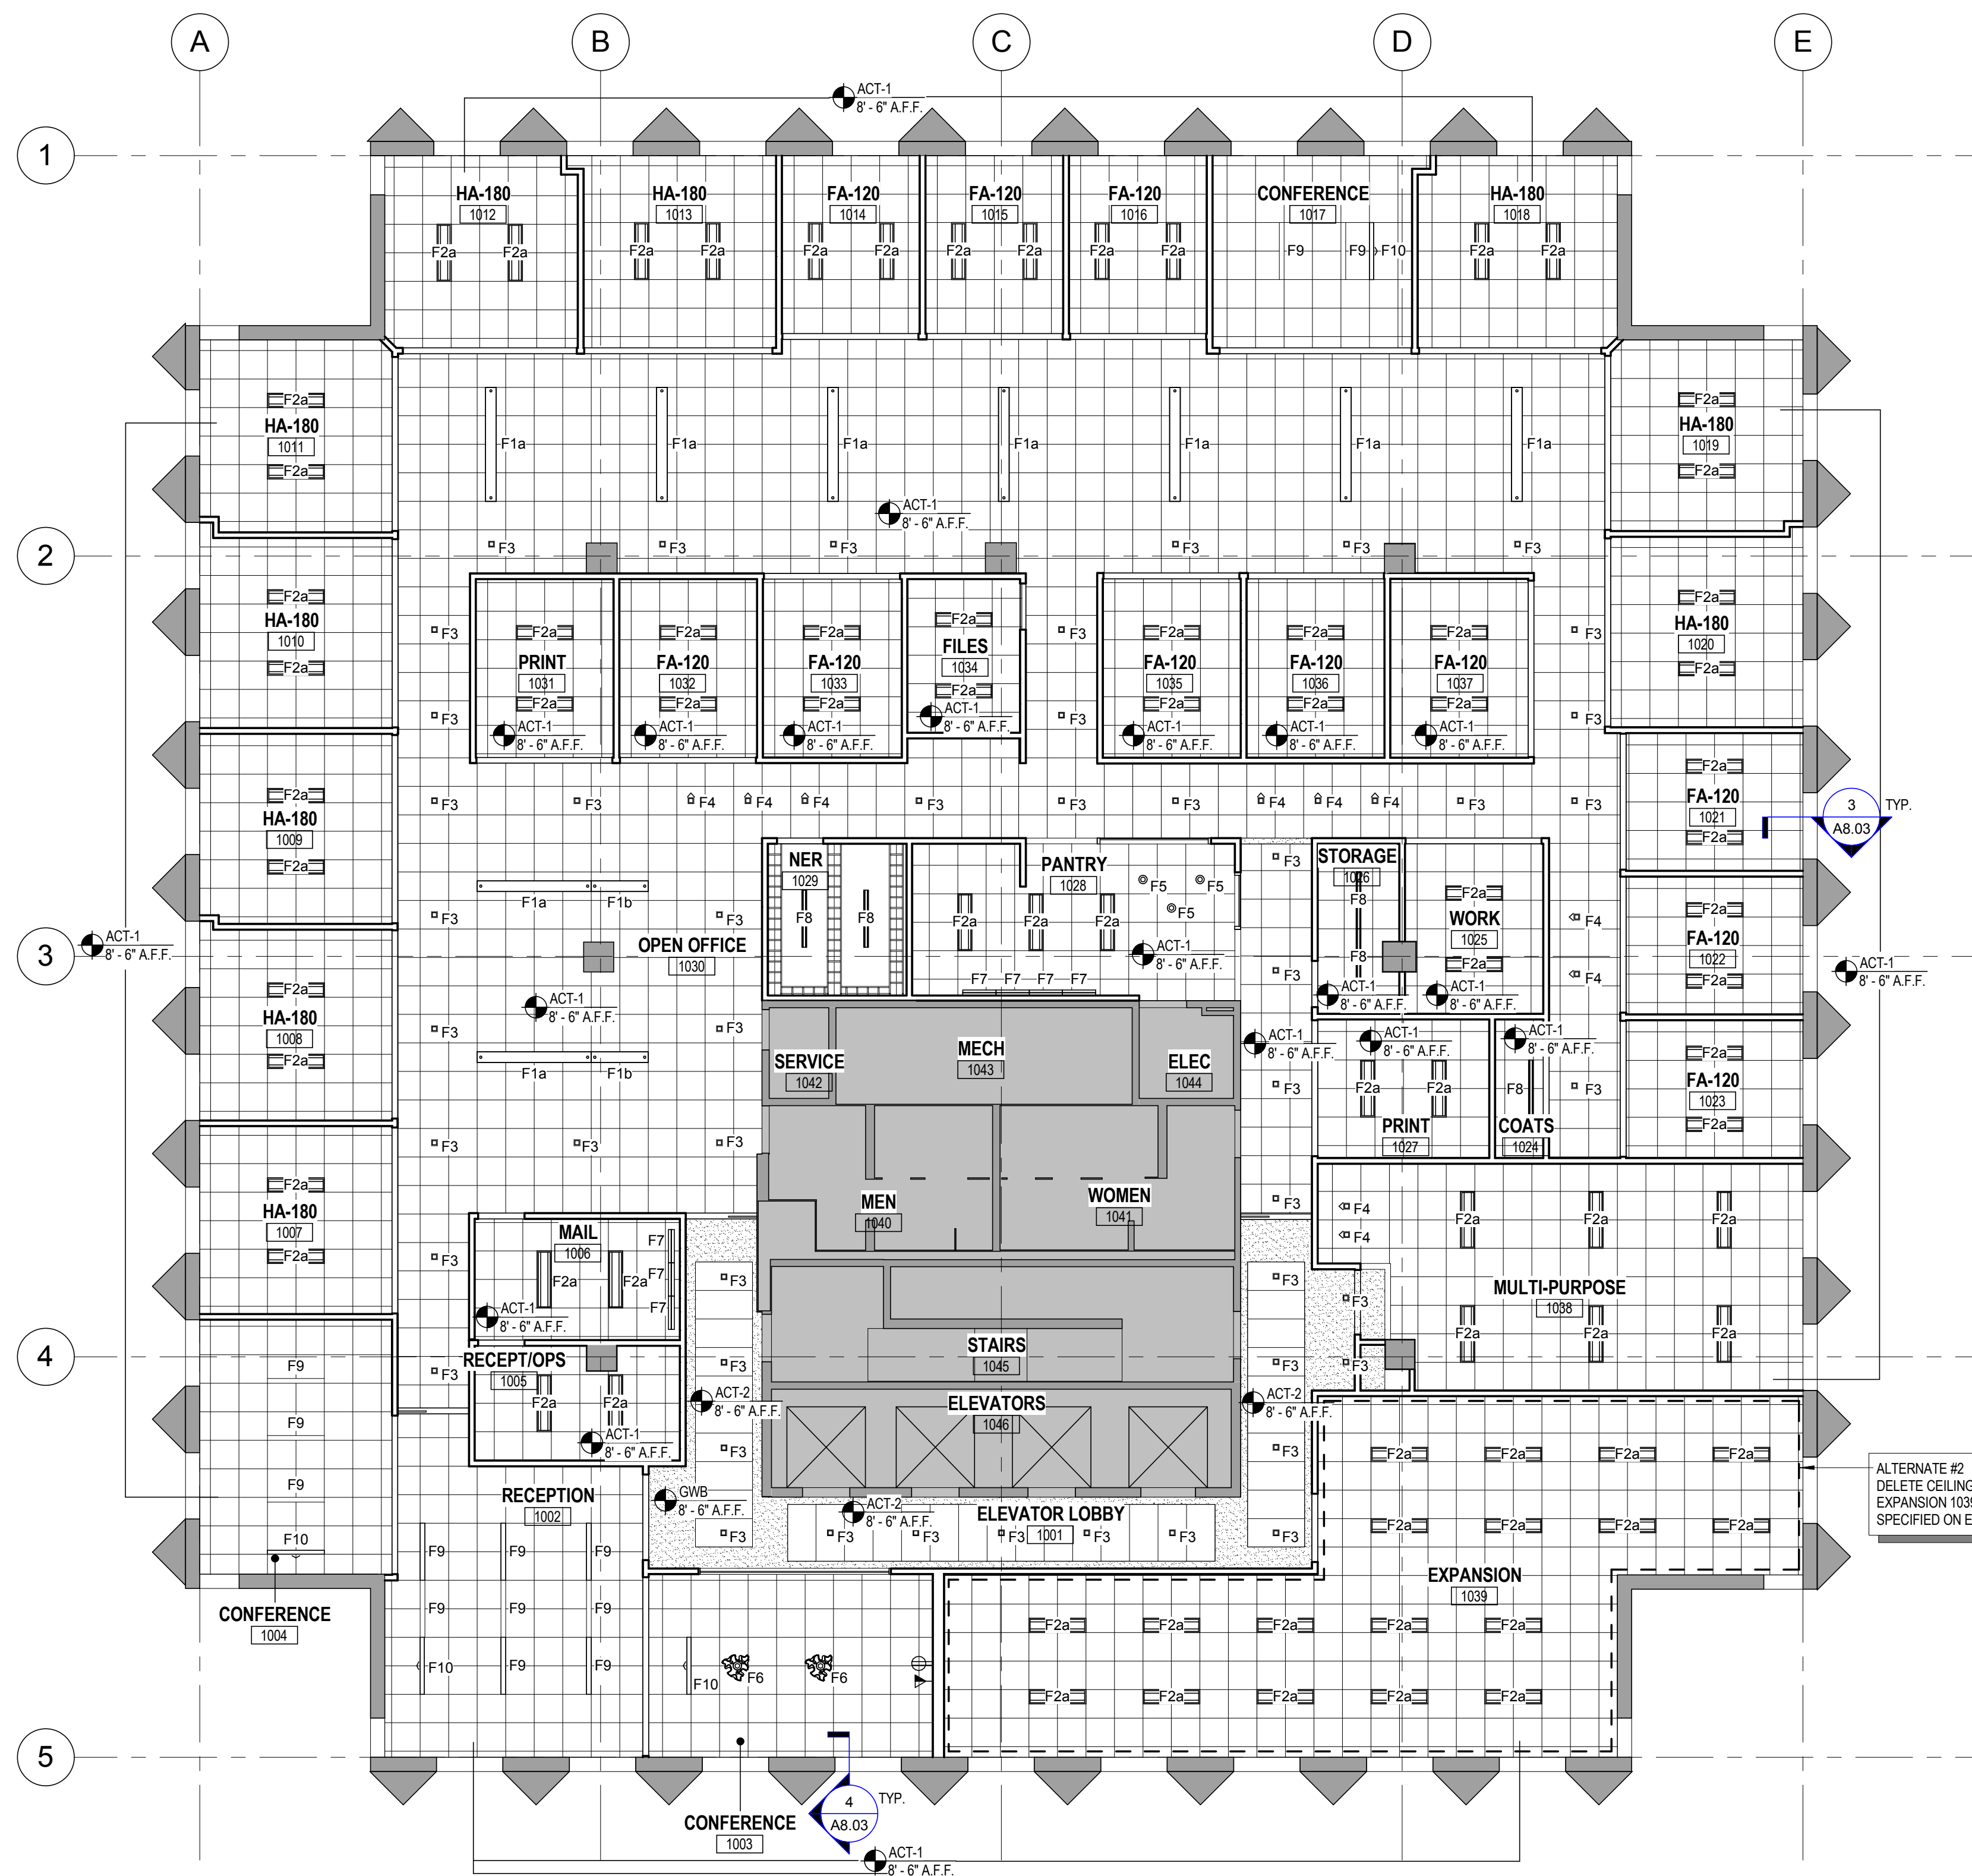

ALTERNATE #2  
 DELETE CEILING AND LIGHTING IN ROOM: EXPANSION 1039. PROVIDE UTILITY LIGHTING AS SPECIFIED ON ELECTRICAL DRAWINGS.

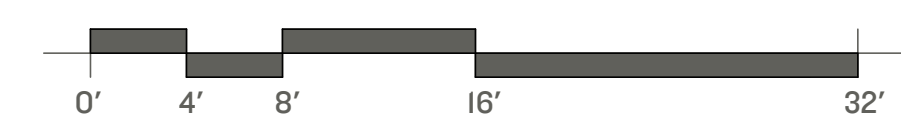

**10th FLOOR REFLECTED CEILING PLAN**  
 1/8" = 1'-0"