
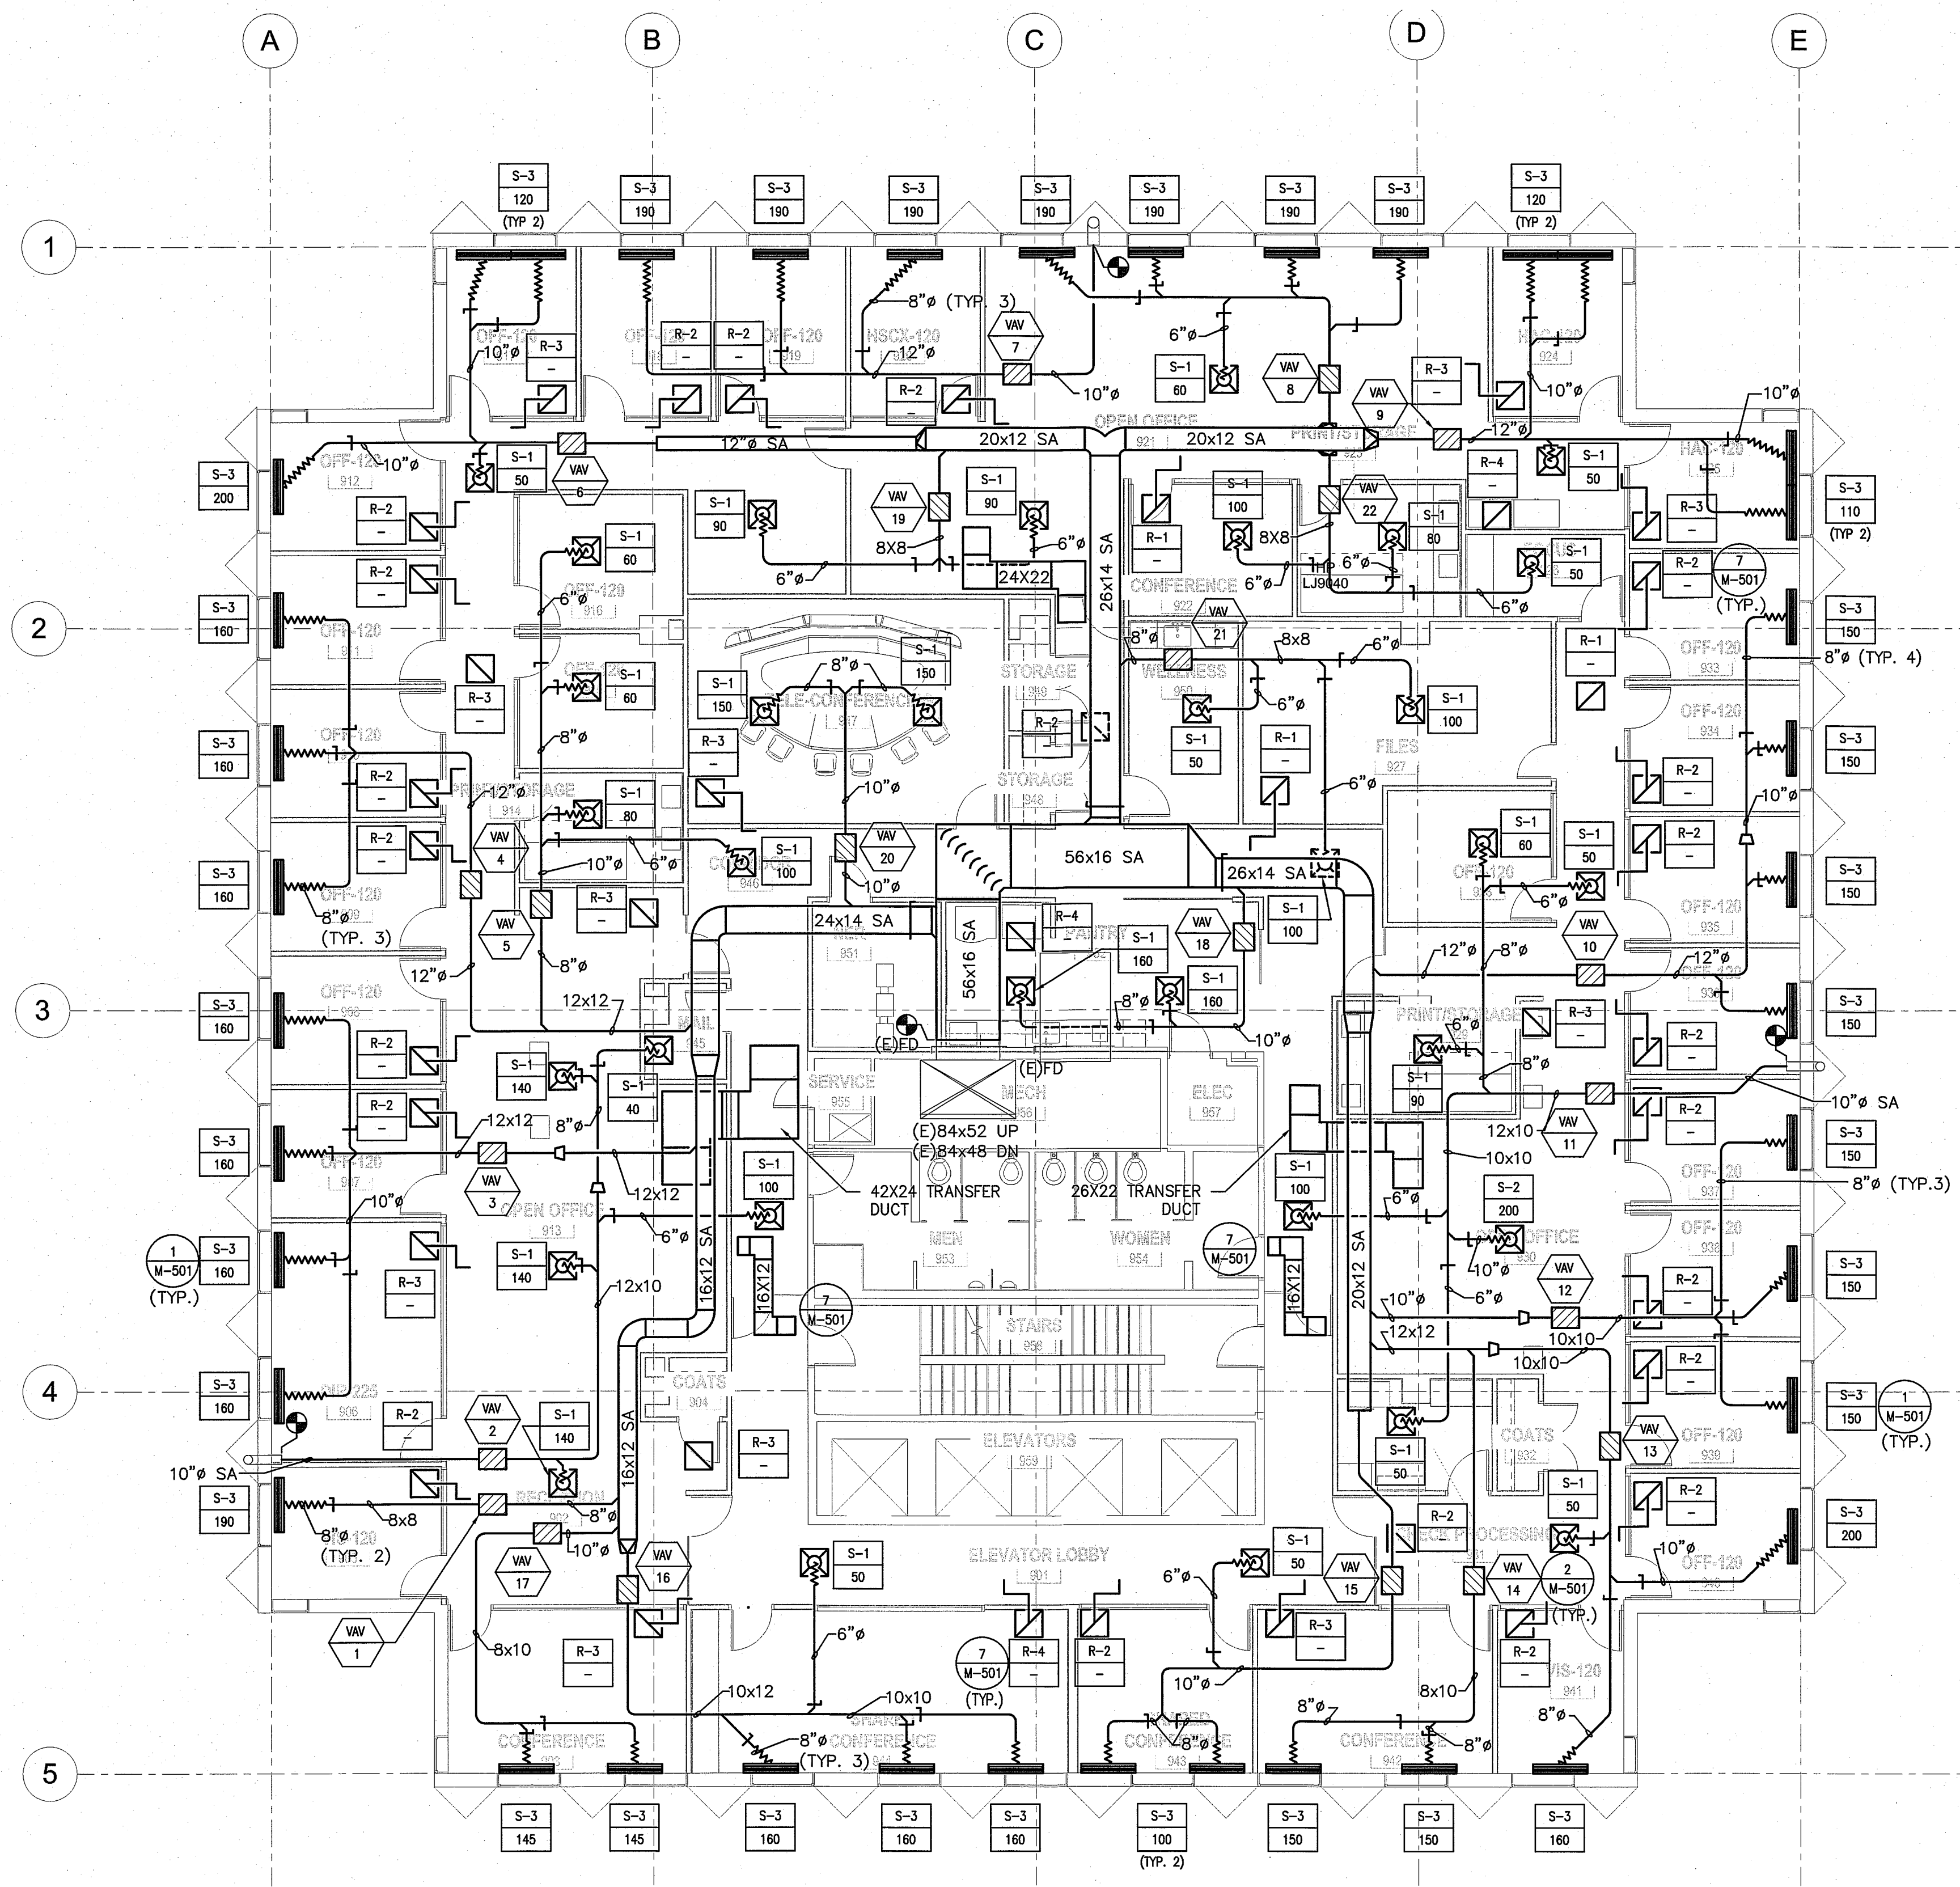


**NOTES:**

1. SEE SHEET M-001 FOR LEGEND AND ABBREVIATIONS.

<b>SMRT</b>	ARCHITECTURE	144 Fore Street/P.O. Box 618
	ENGINEERING	Portland, Maine 04104
	PLANNING	tel. (207) 772-3846
	INTERIOR DESIGN	fax. (207) 772-1070
	COMMISSIONING	www.smrtinc.com
		SMRT PROJECT #15035

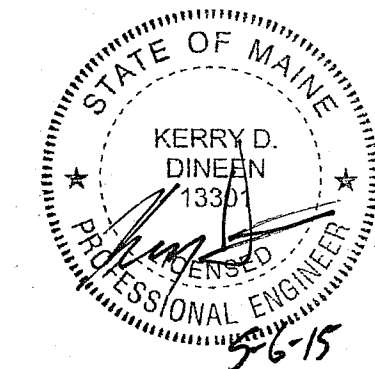

**REVISIONS**

**BANK OF AMERICA - 9TH & 10TH FLOORS**

BANK OF AMERICA  
 1 MONUMENT SQUARE  
 Portland, ME

**TITLE**  
 NINTH FLOOR HVAC DUCTWORK PLAN

 
**DATE**                      **JOB NO.**  
 May 11, 2015                      15051.00

**DRAWING NO.**                      **MH101**

ISSUED FOR CONSTRUCTION

**AIRFLOW NOTE**

1. BUILDING OWNER TO PROVIDE 9,200 CFM OF 55 DEG F AT A MINIMUM OF 30% OUTSIDE AIR TO MEET SPACE LOAD AND VENTILATION REQUIREMENTS.



**1 NINTH FLOOR PLAN**  
 1/8" = 1'-0"