




Dyer Brown & Associates Inc. - ©2017 ALL RIGHTS RESERVED - PLOTTED: 03/01/2017 07:02:37 - BDA Home Loans Collaboration 1 Monument Square, Portland, ME 04101

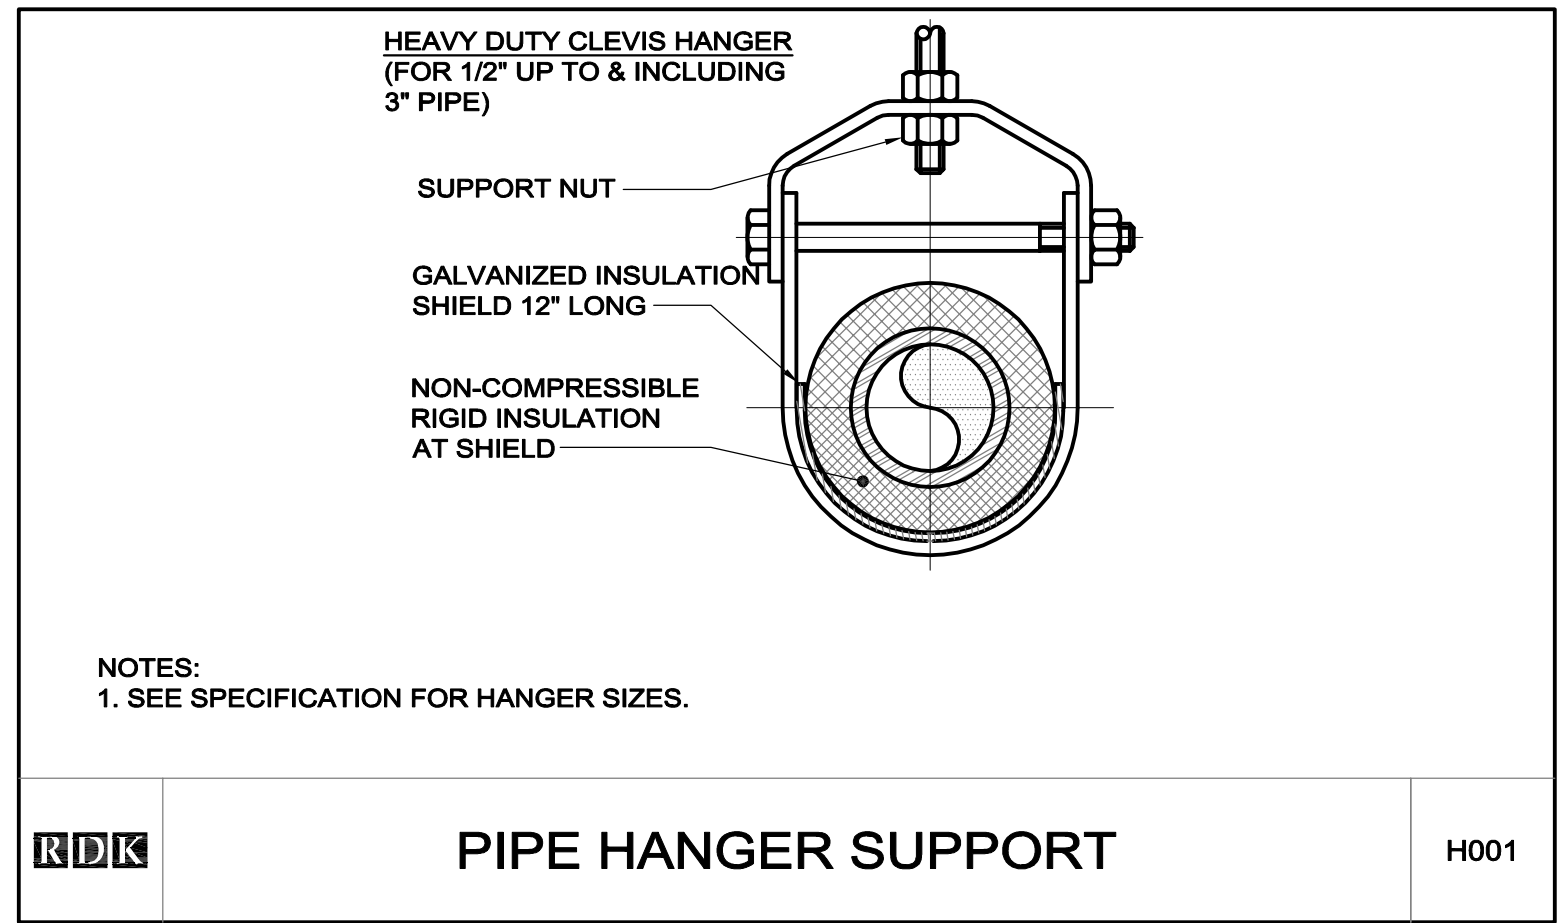


**PIPE HANGER SUPPORT** H001

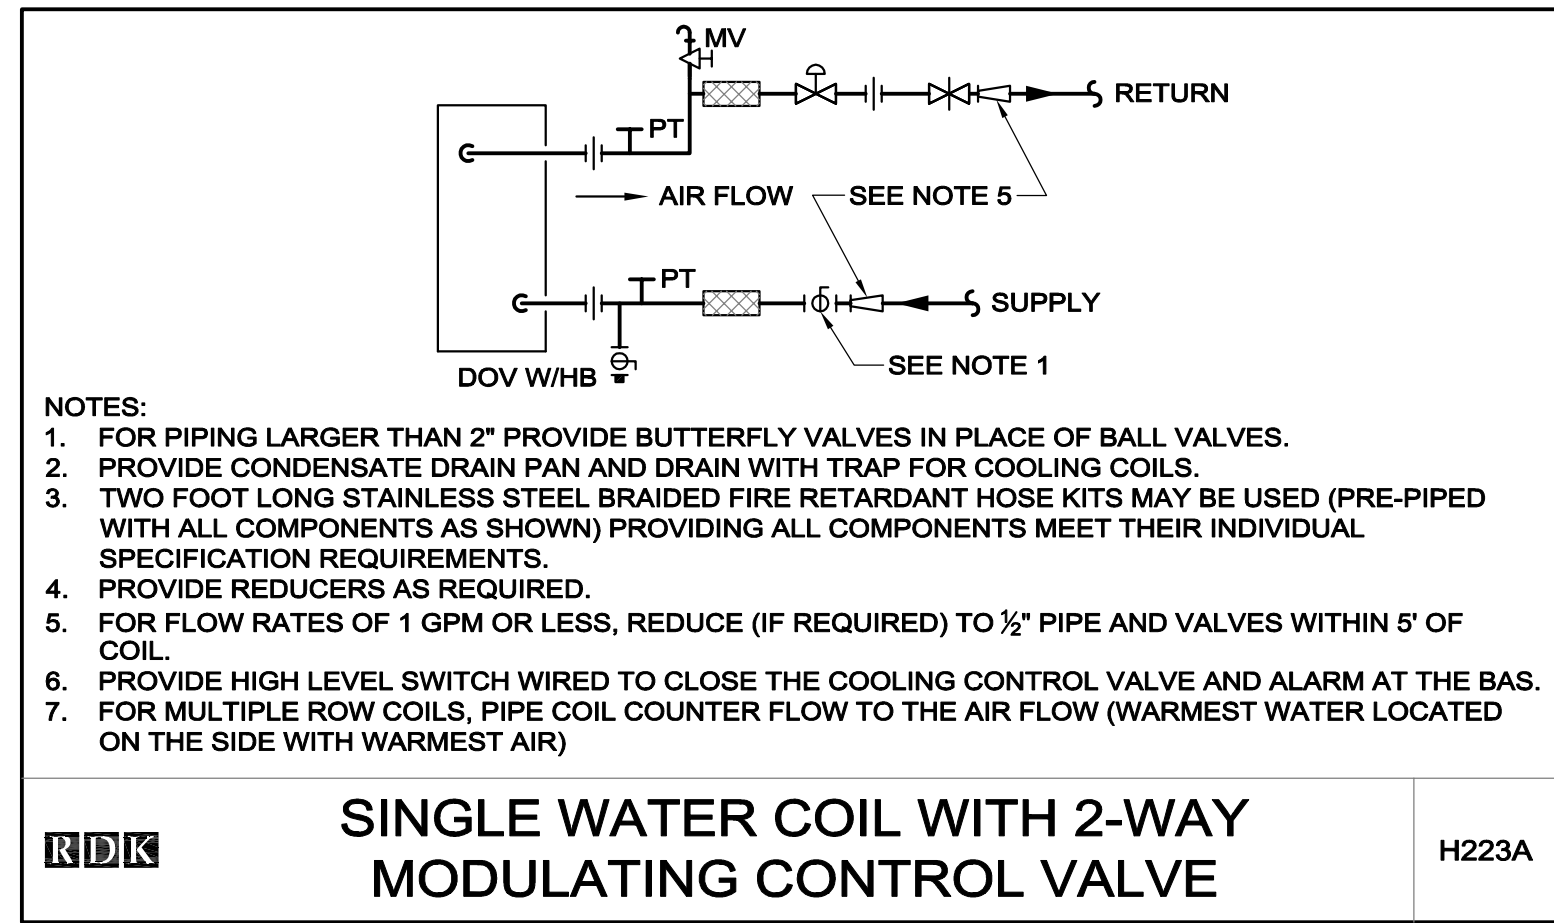


**SINGLE WATER COIL WITH 2-WAY MODULATING CONTROL VALVE** H223A

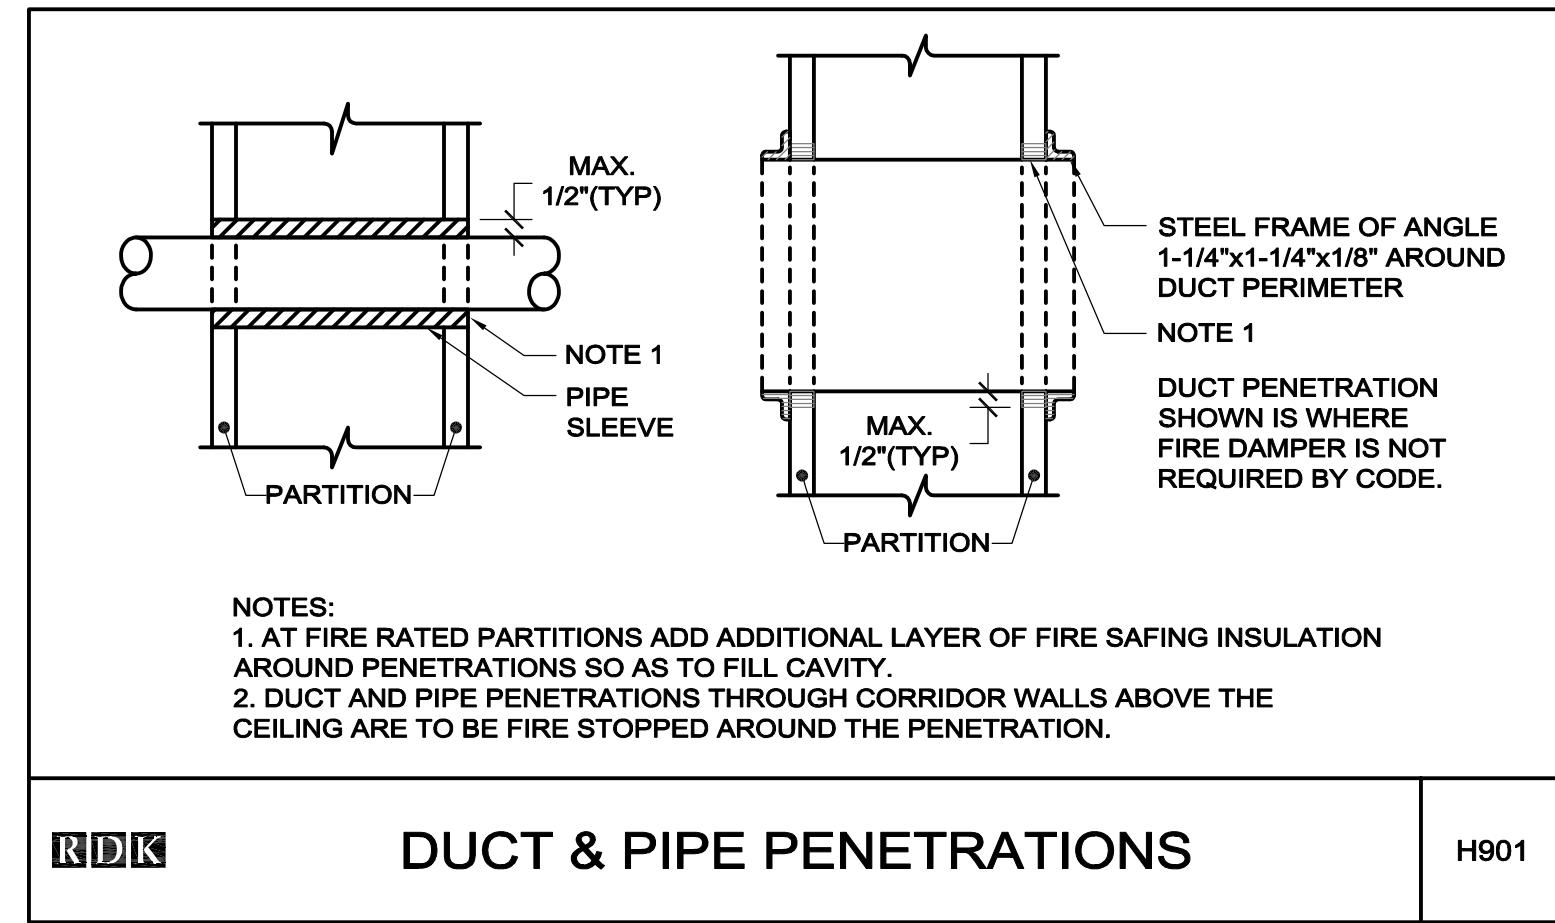


**DUCT & PIPE PENETRATIONS** H901

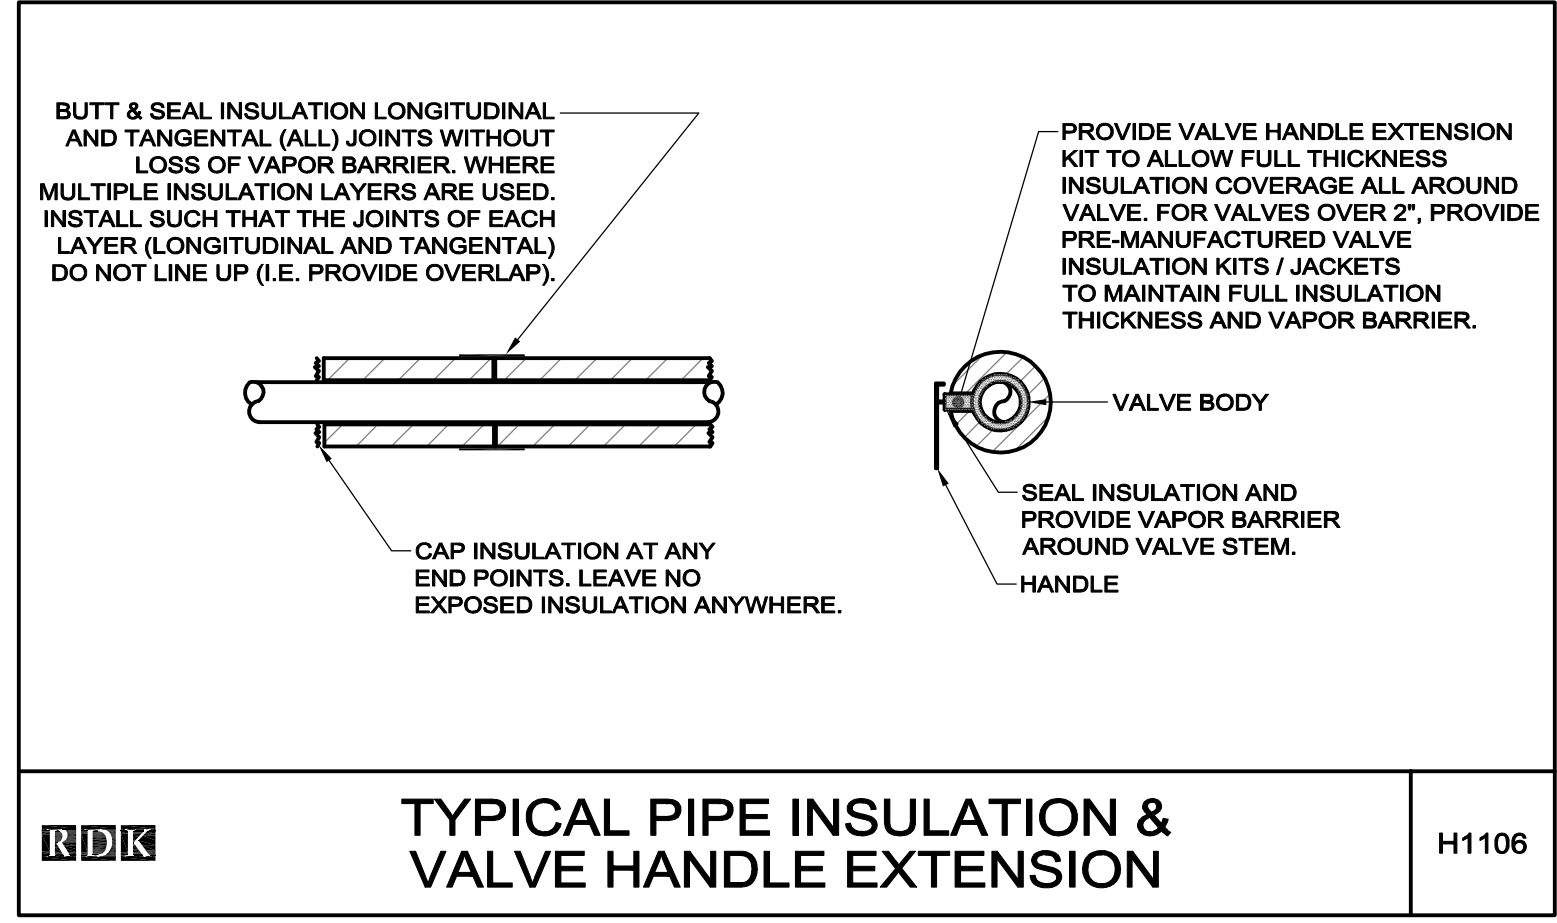


**TYPICAL PIPE INSULATION & VALVE HANDLE EXTENSION** H1106

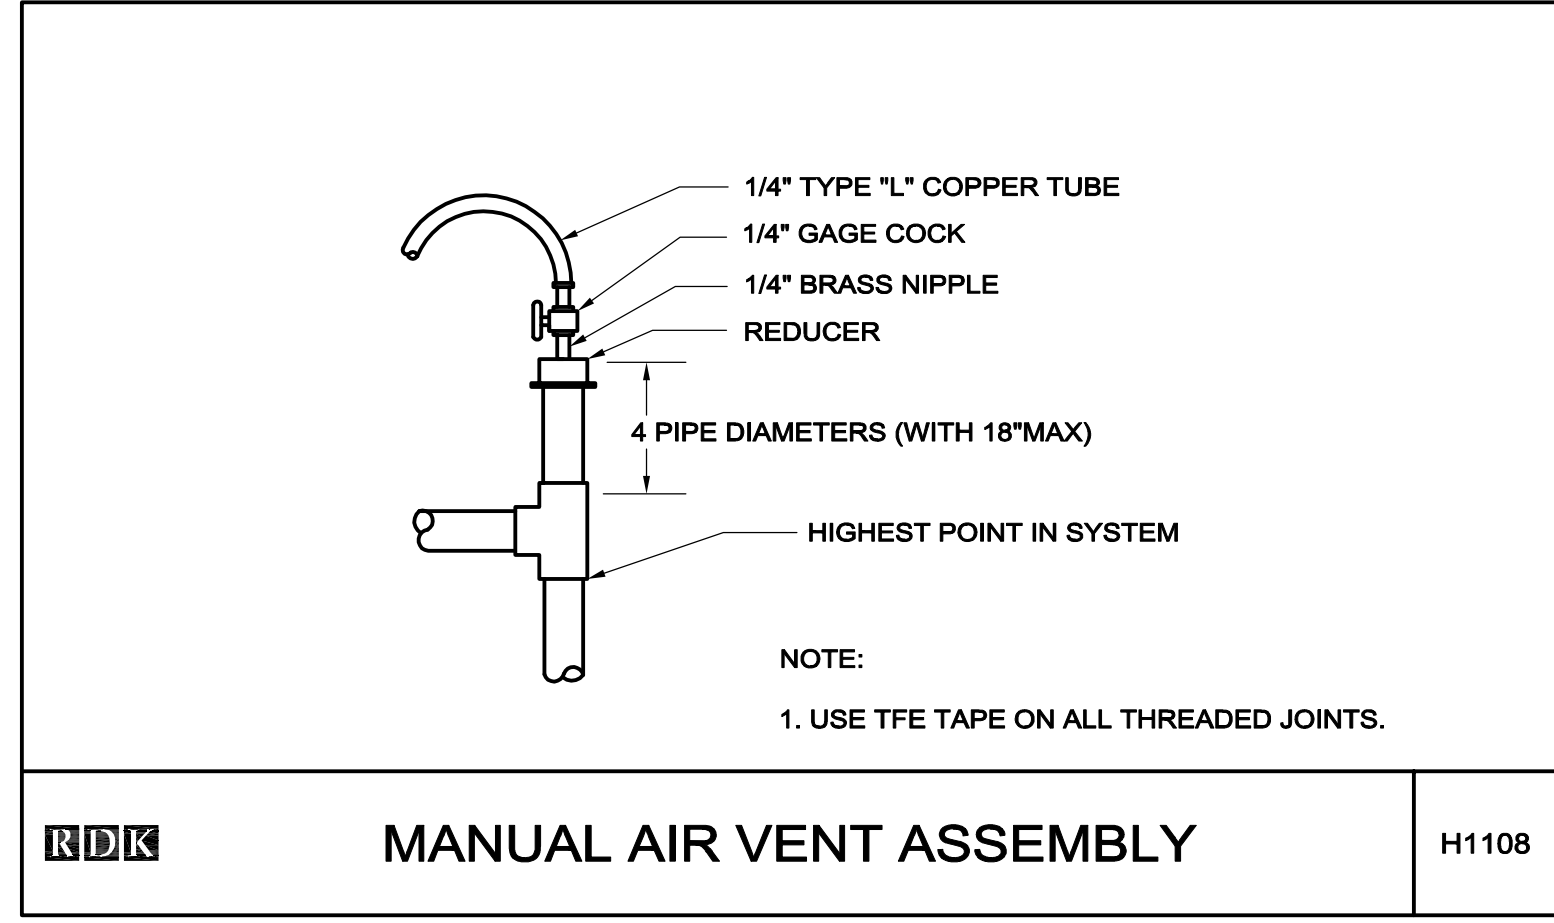


**MANUAL AIR VENT ASSEMBLY** H1108

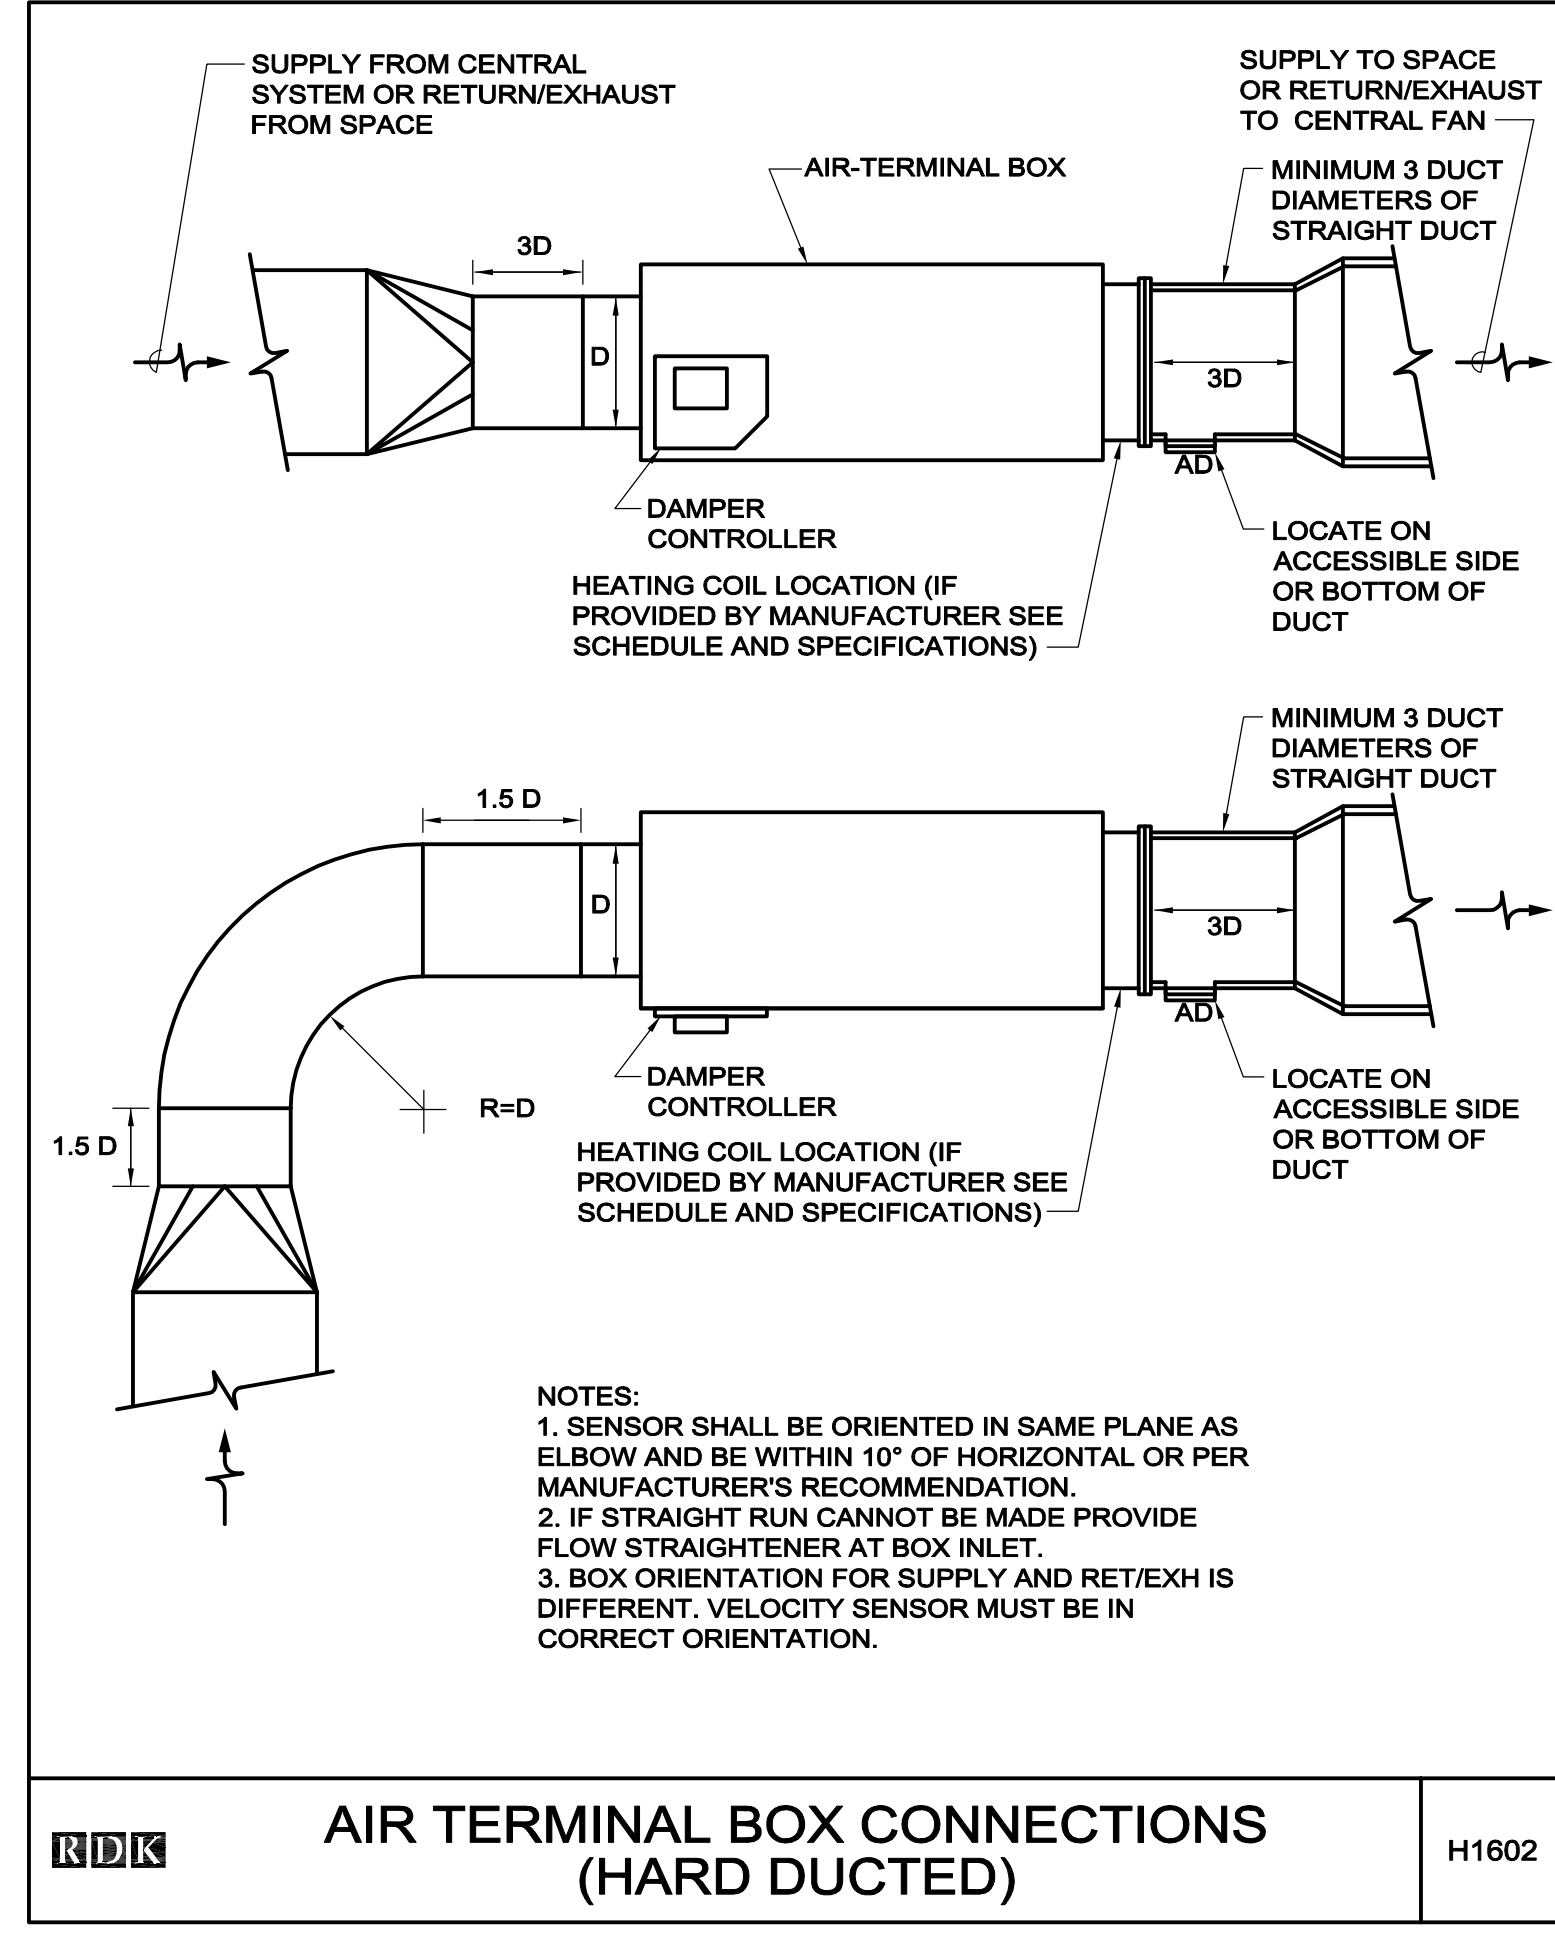


**AIR TERMINAL BOX CONNECTIONS (HARD DUCTED)** H1602

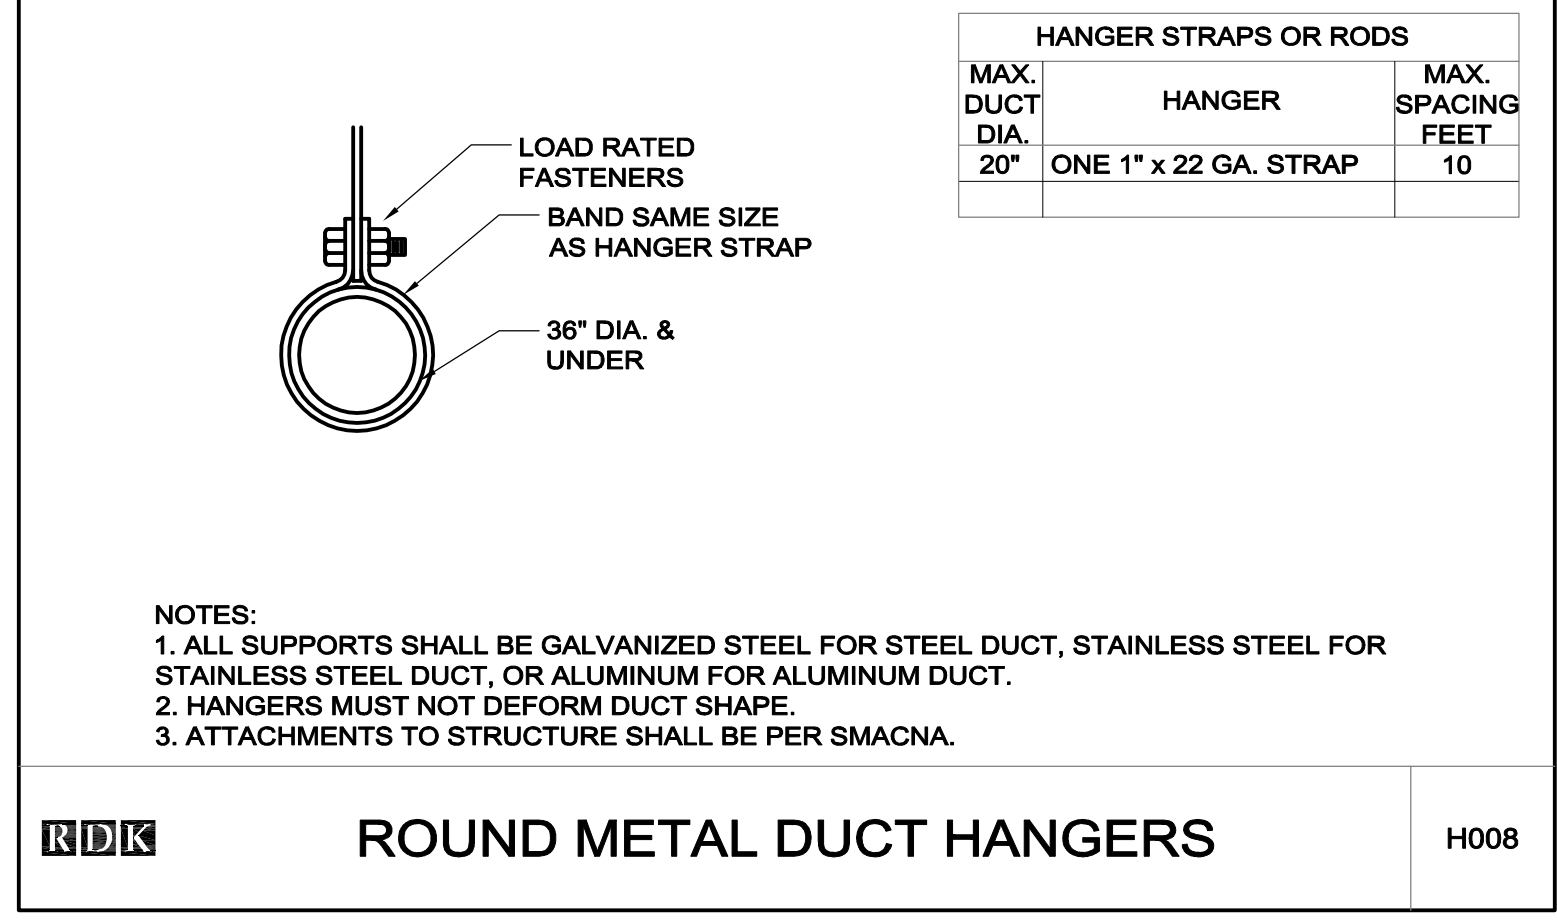


**ROUND METAL DUCT HANGERS** H008

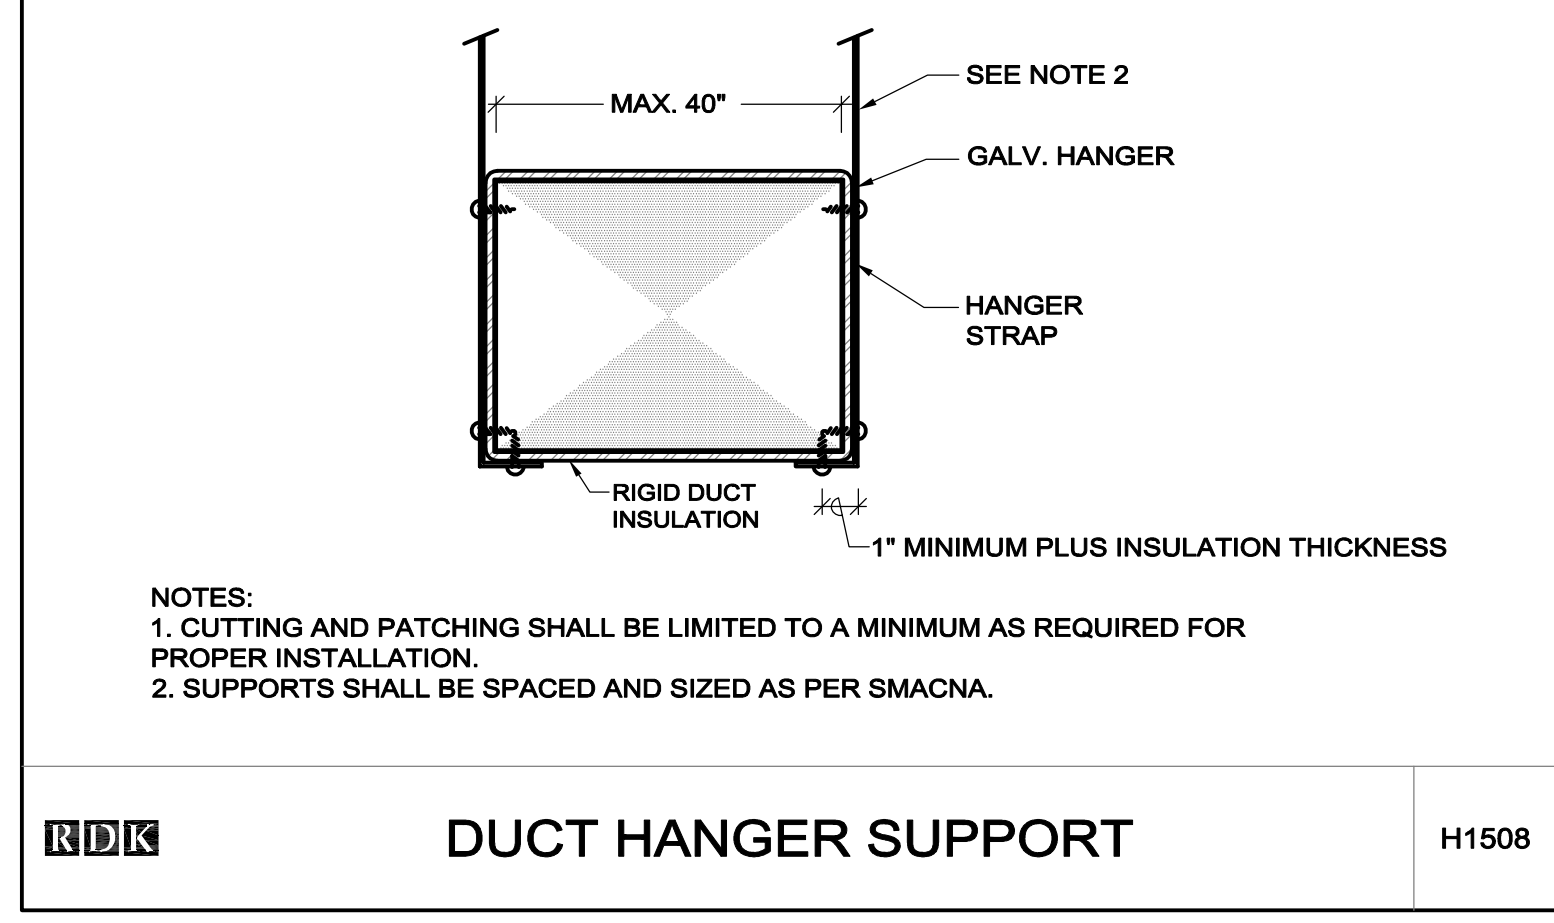


**DUCT HANGER SUPPORT** H1508

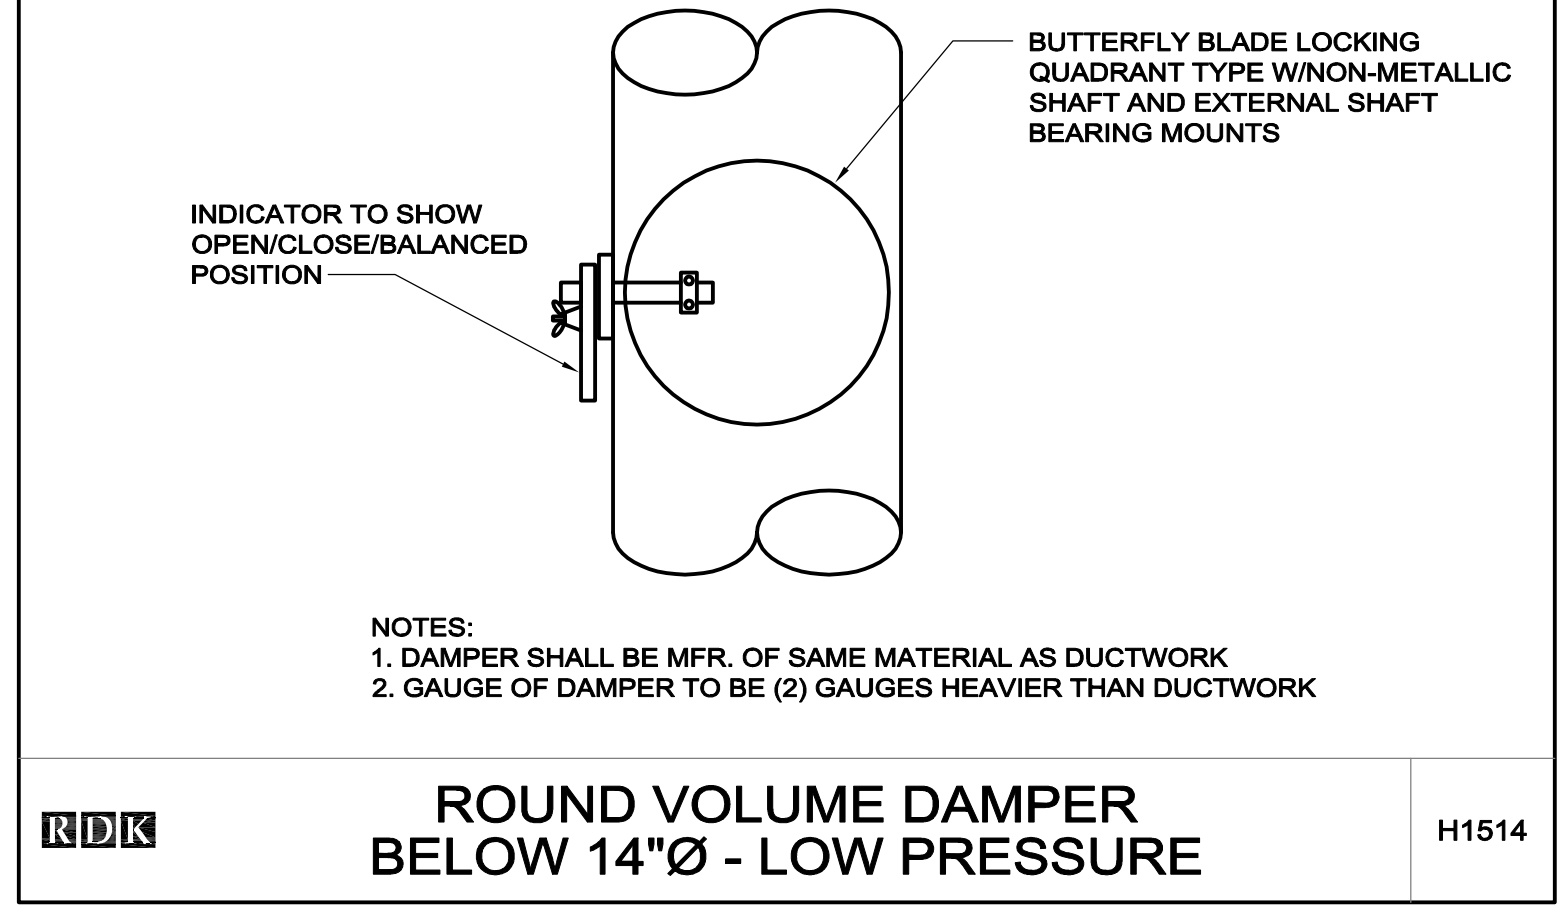


**ROUND VOLUME DAMPER BELOW 14"Ø - LOW PRESSURE** H1514

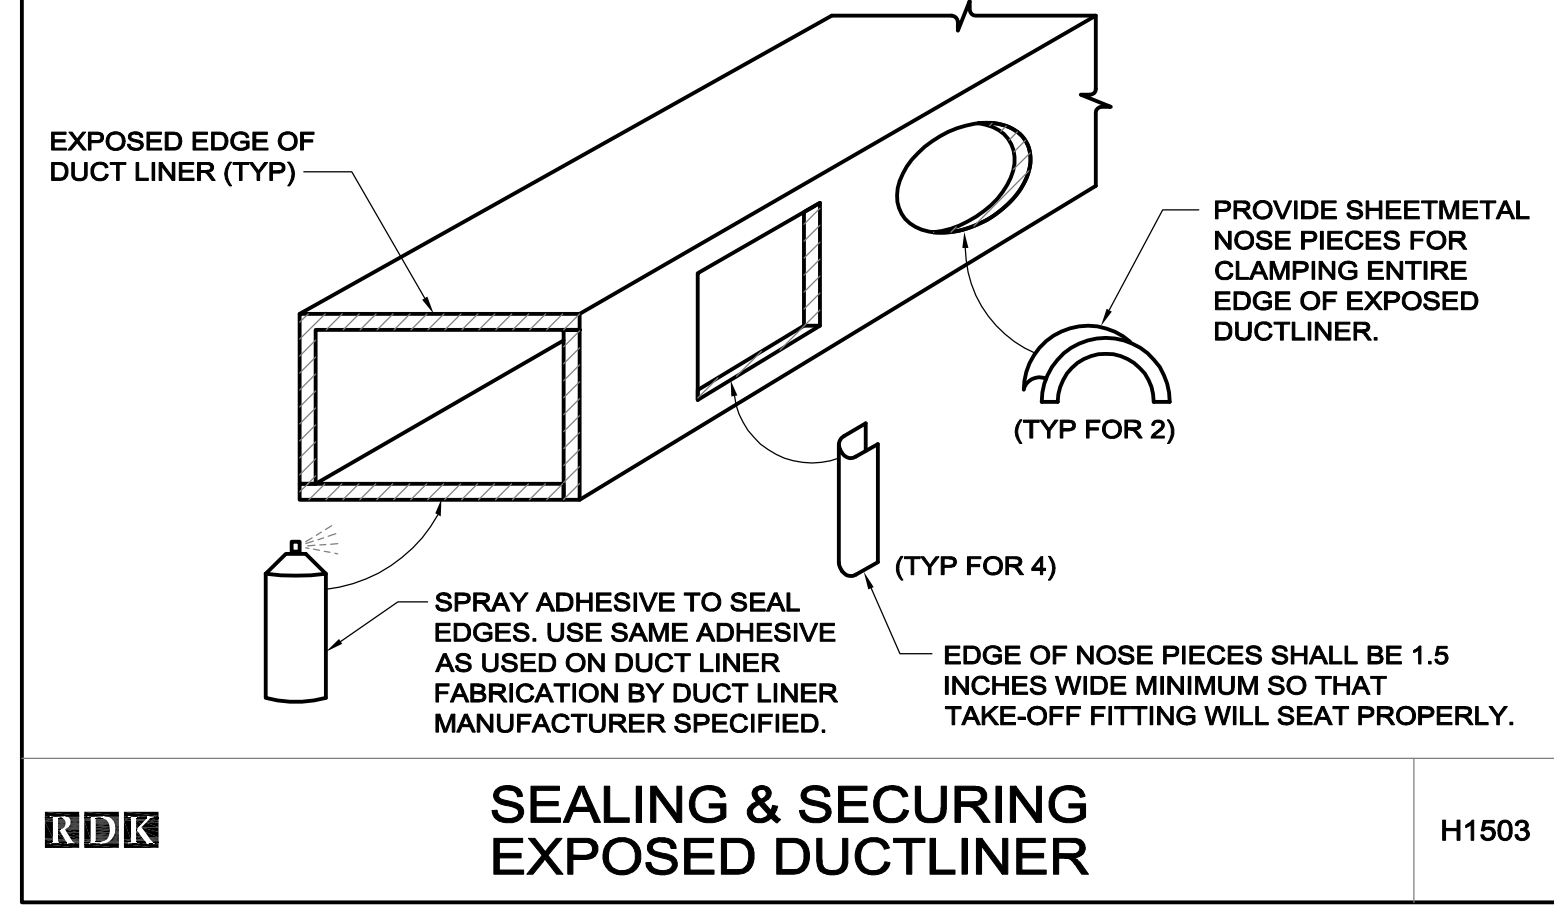

**SEALING & SECURING EXPOSED DUCTLINER** H1503

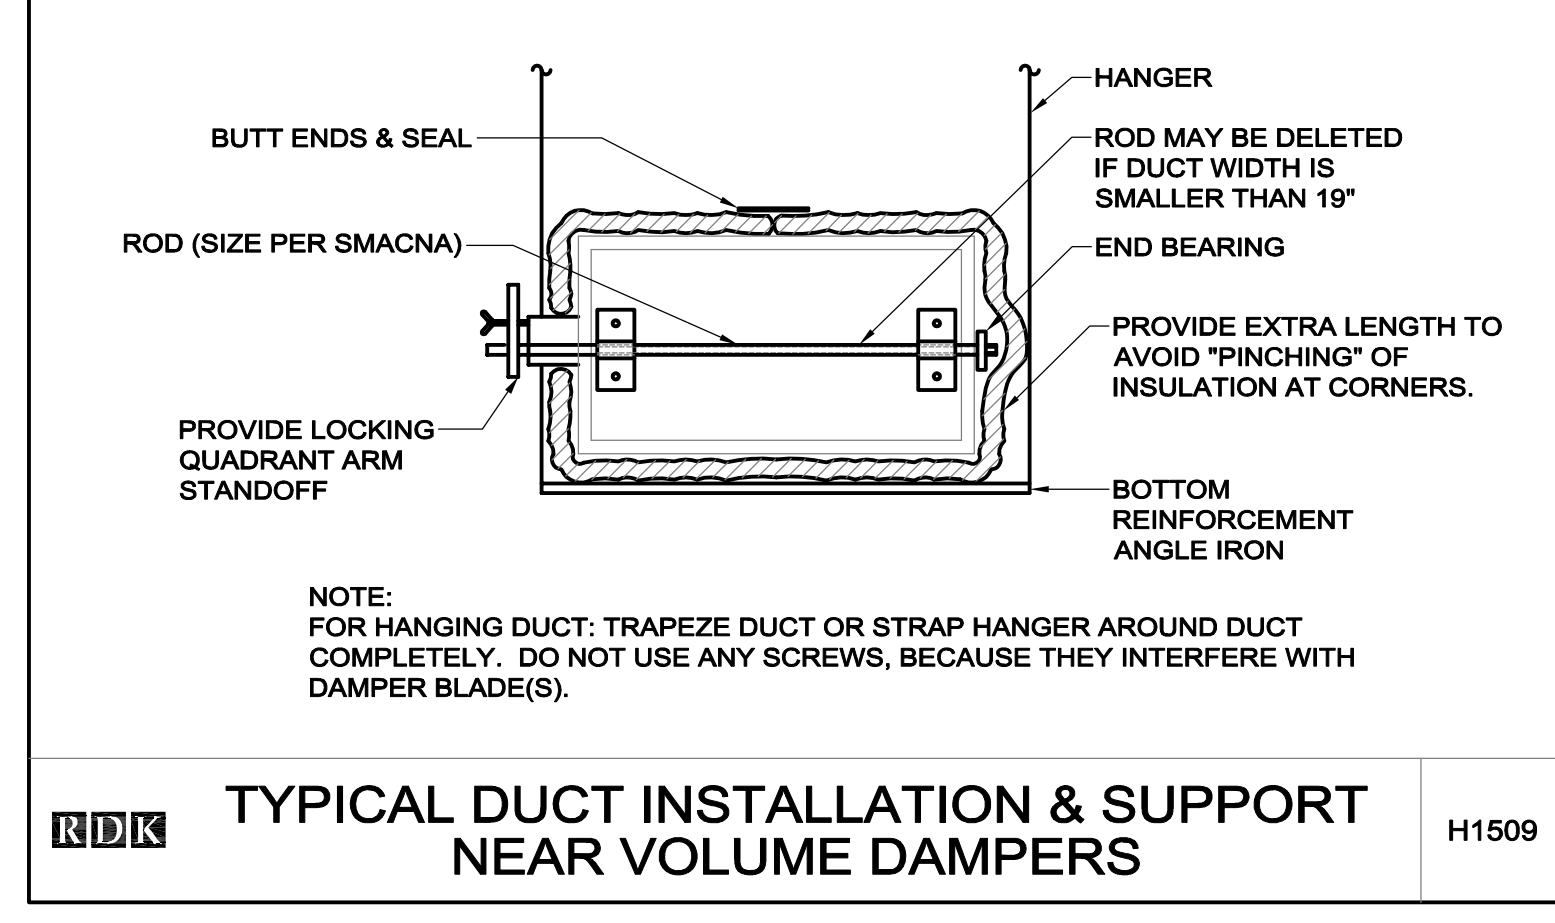

**TYPICAL DUCT INSTALLATION & SUPPORT NEAR VOLUME DAMPERS** H1509

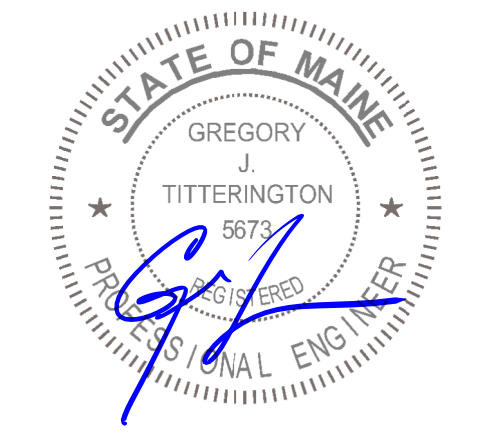

**REVISIONS**

**BANK OF AMERICA - HOME LOANS**

BANK OF AMERICA  
1 MONUMENT SQUARE, PORTLAND ME

**TITLE**  
HVAC DETAILS SHEET 1

**DATE** 06/29/17  
**JOB NO.** 20170237

**DRAWING NO.**

**M-7**

ISSUED FOR CONSTRUCTION