



[Handwritten Signature]

Type Mark	Description	Manufacturer	Model	Comments
F1a	8'-0" LED PENDANT	LITECONTROL	RAIL	
F1b	4'-0" LED PENDANT	LITECONTROL	RAIL	
F2a	1x4 RECESSED LED	LITHONIA	VTL	
F2b	2x2 RECESSED LED	LITHONIA	ZVTL	
F3	4" LED DOWNLIGHT	GOYAM	EVO	
F4	4" LED WALL WASHER	GOYAM	EVO	
F5	DECORATIVE LED PENDANT	FLOS	FUCSIA	
F6	DECORATIVE LED PENDANT	ARTEMIDE	LOGICO	
F7	UNDER SHELF TASK LIGHT	PHILIPS DAY-BRITE	LINCS	
F8	4'-0" UTILITY STRIP FIXTURE	LITHONIA	ZL1N	
F9	RECESSED LINEAR LED	FOCAL POINT	FSMA	
F10	RECESSED LINEAR WALL WASHER	FOCAL POINT	FSMA	

- RCP NOTES**
- FINISH CEILING HEIGHT SHALL BE AS NOTED.
 - UNLESS NOTED OTHERWISE, ALL FIXTURES, ACT AND CEILING GRID SHOWN ARE NEW.
 - THE CONTRACTOR SHALL CAREFULLY REVIEW ALL ATTACHMENT CONDITIONS FOR NEW FURRED OR SUSPENDED CEILINGS TO PROVIDE PROPER CLEARANCES.
 - SEE ELECTRICAL PLAN FOR SMOKE, HEAT, AND MOTION DETECTORS.
 - SEE ELECTRICAL PLAN FOR FIXTURES, CIRCUITS, AND EMERGENCY POWER.
 - SEE SPRINKLER PLAN TO COORDINATE HEAD LOCATIONS.
 - SEE HVAC PLAN TO COORDINATE CEILING DIFFUSERS, GRILLES, AND FAN LOCATIONS.
 - PROVIDE ACCESS PANELS REQUIRED BY ELECTRICAL, PLUMBING, HVAC AND OTHER TRADES.
 - ALL SPRINKLER HEADS IN ACOUSTIC TILE CEILINGS SHALL BE CENTERED IN THE TILE. IN GWB CEILINGS, THEY SHALL BE SPECIFICALLY LOCATED PER DIMENSIONED PLAN OR ARCHITECTS DIRECTION.
 - SWITCH MOUNTING HEIGHT TO BE 48" AFF UNLESS NOTED OTHERWISE.
 - SEE ENGINEERING DRAWINGS FOR ROOMS THAT REQUIRE OCCUPANCY SENSORS.

LIGHTING FIXTURE LEGEND

	F1a	8'-0" LINEAR PENDANT
	F1b	4'-0" LINEAR PENDANT
	F2a	1X4 RECESSED DIRECT/INDIRECT
	F2b	2X2 RECESSED DIRECT/INDIRECT
	F3	4" DOWNLIGHT
	F4	4" WALL WASHER
	F5	DECORATIVE PENDANT
	F6	DECORATIVE PENDANT
	F7	28" UNDER CABINET FIXTURE
	F8	4'-0" UTILITY STRIP FIXTURE
	F9	RECESSED LINEAR FIXTURE
	F10	RECESSED LINEAR WALL WASHER

CEILING GRID AND TILE LEGEND


ACT-1 (LOCATIONS AS NOTED)
2X2' ARMSTRONG ULTIMA
MINERAL FIBER BEVELED TEGULAR

ACT-2 (LOCATIONS AS NOTED)
2X4' ARMSTRONG ULTIMA
MINERAL FIBER BEVELED TEGULAR

SUSPENSION GRID
ARMSTRONG - SERIES 6100 MODEL:
916 INTERLUDE XL DIMENSIONAL T

CEILING PLAN KEYNOTES

NOTE	DESCRIPTION
R1	GWB CEILING TO RECEIVE BENJAMIN MOOR CEILING WHITE.

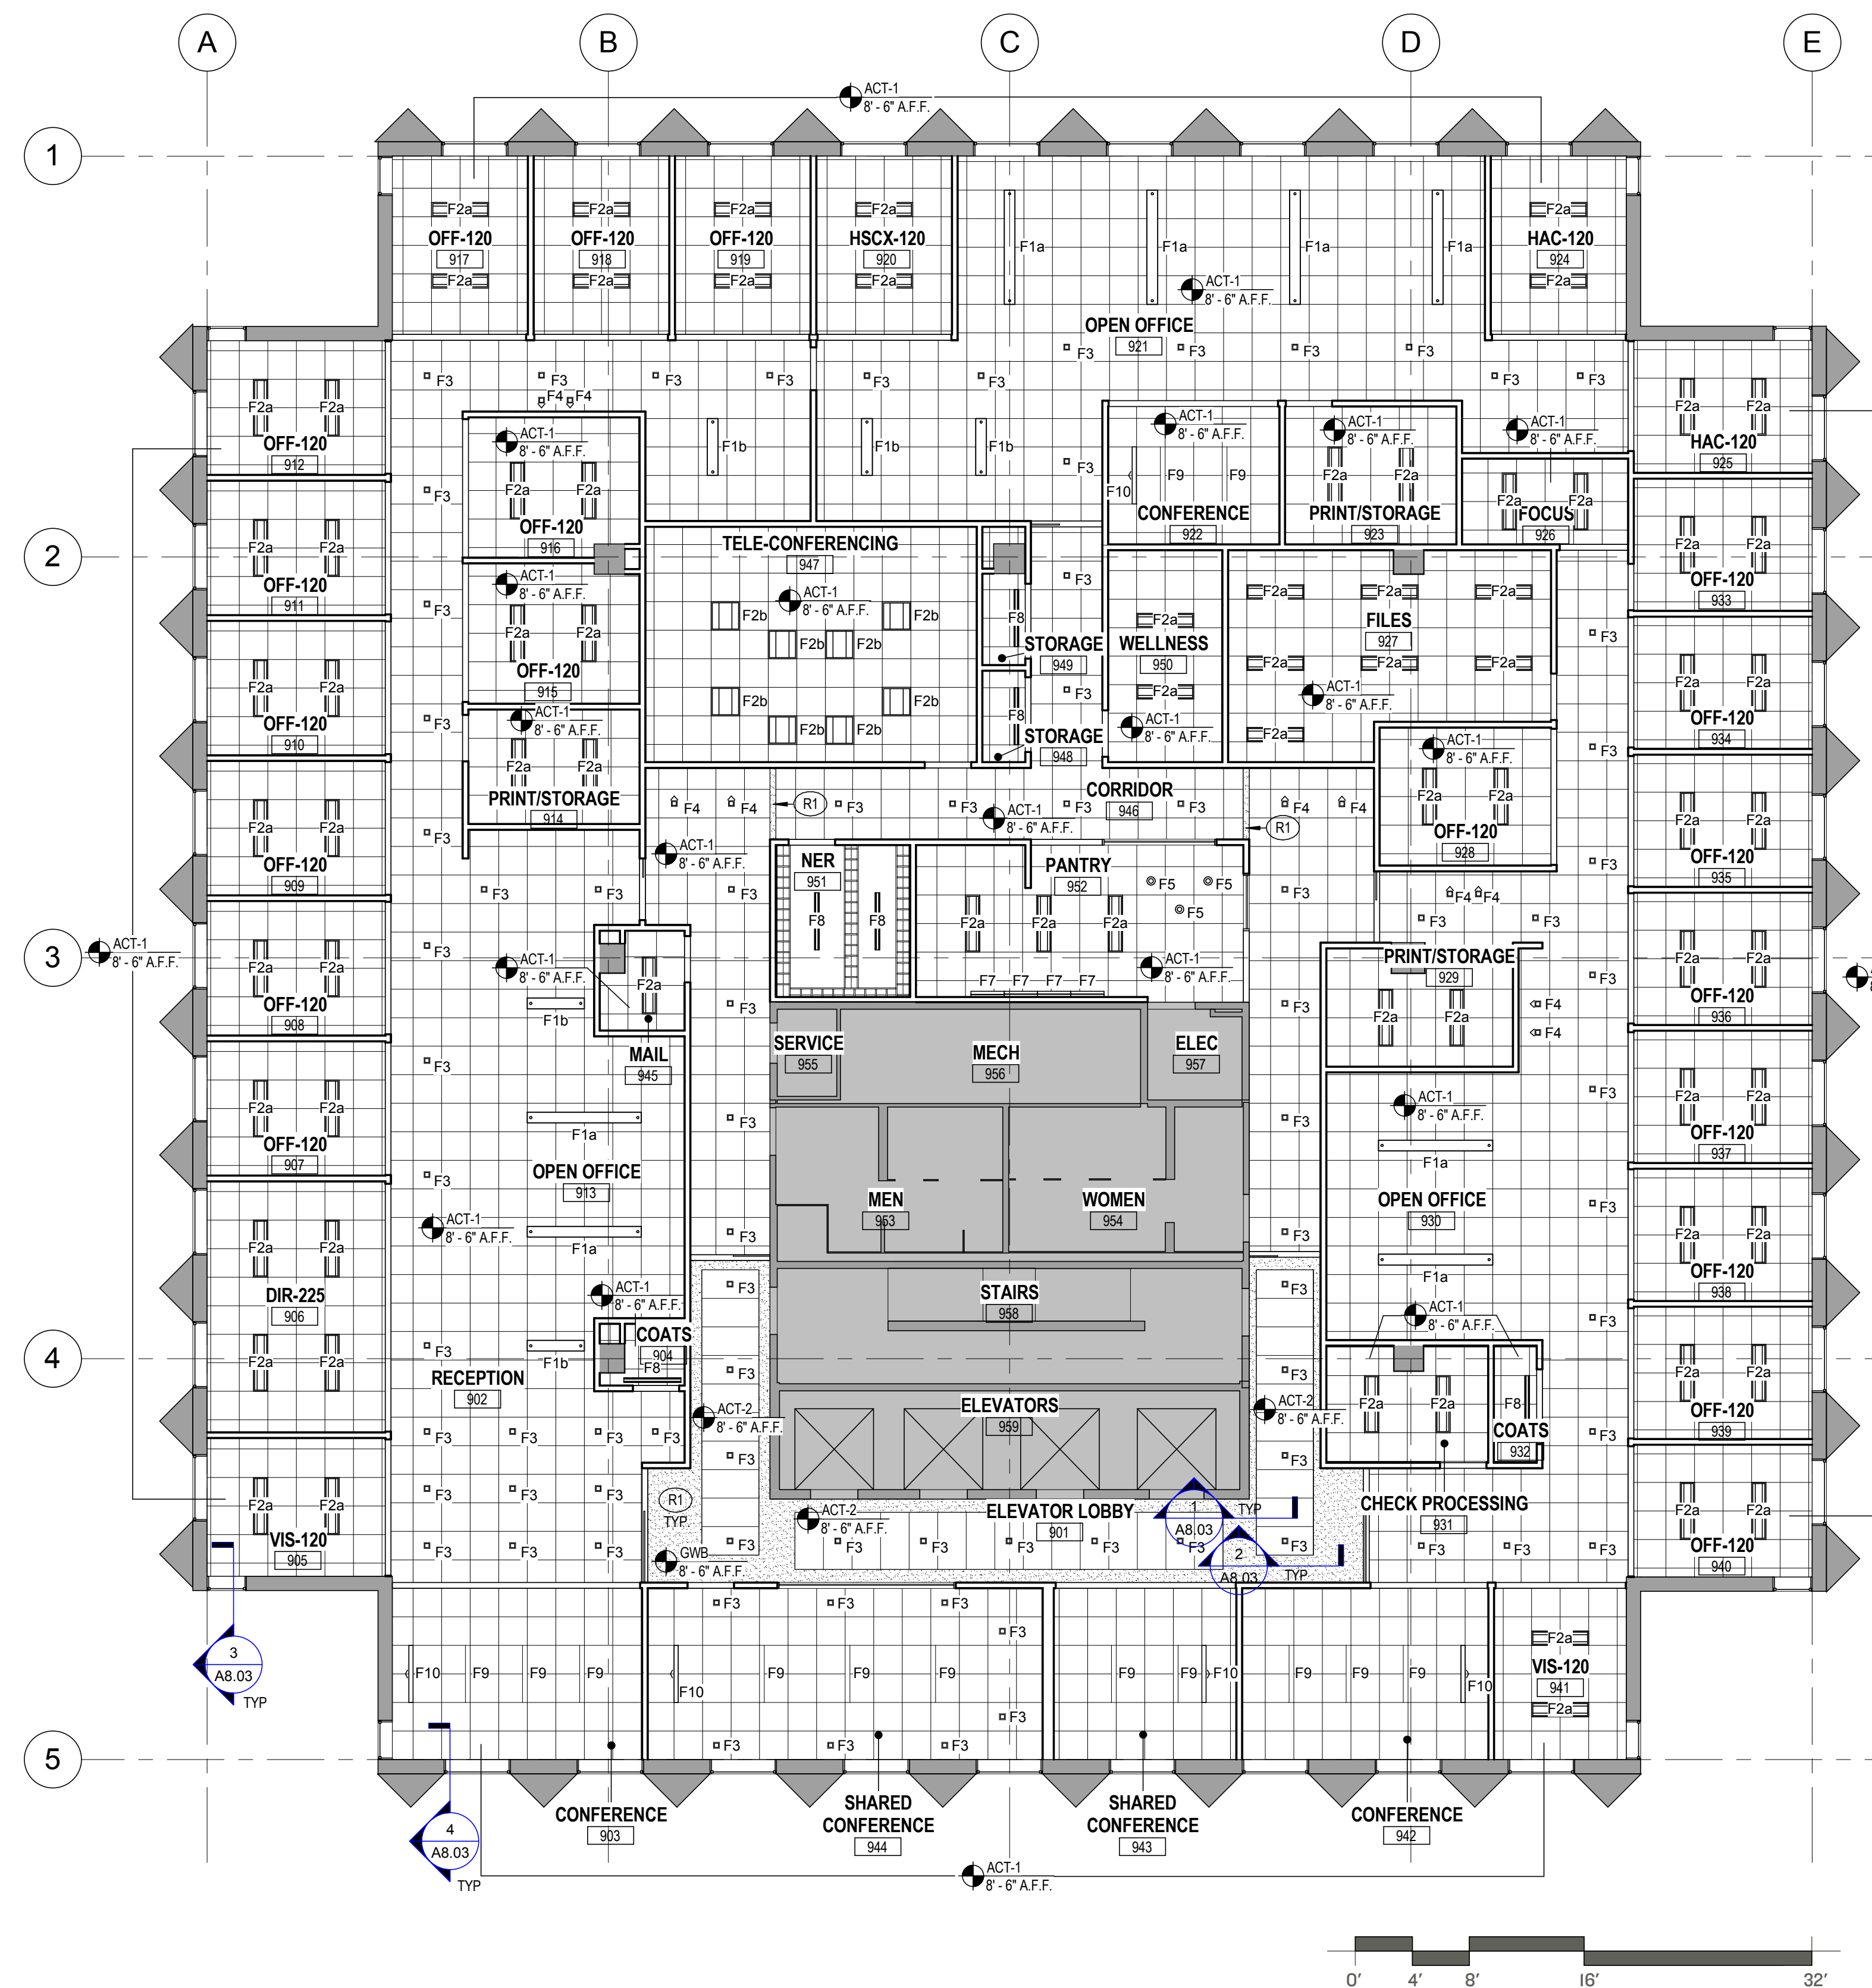

REVISIONS

BANK OF AMERICA - 9TH & 10TH FLOORS

BANK OF AMERICA
1 MONUMENT SQUARE
Portland, ME

TITLE
9TH FLOOR REFLECTED CEILING PLAN

DATE May 11, 2015
JOB NO. 15051.00

DRAWING NO. **A3.09**

ISSUED FOR CONSTRUCTION

1 9th FLOOR REFLECTED CEILING PLAN
1/8" = 1'-0"

DYER BROWN & ASSOCIATES, INC. ©2015 ALL RIGHTS RESERVED - PLOTTED: 5/11/2015 2:44:53 PM C:\Revit\2015 Local Files\ME PORTLAND_1\MONUMENT SQ_09-10_FP_BAC_CENTRAL_mckinnon.rvt