


**NOTE:**

- SEE SHEET E-001 FOR LEGEND AND GENERAL NOTES.

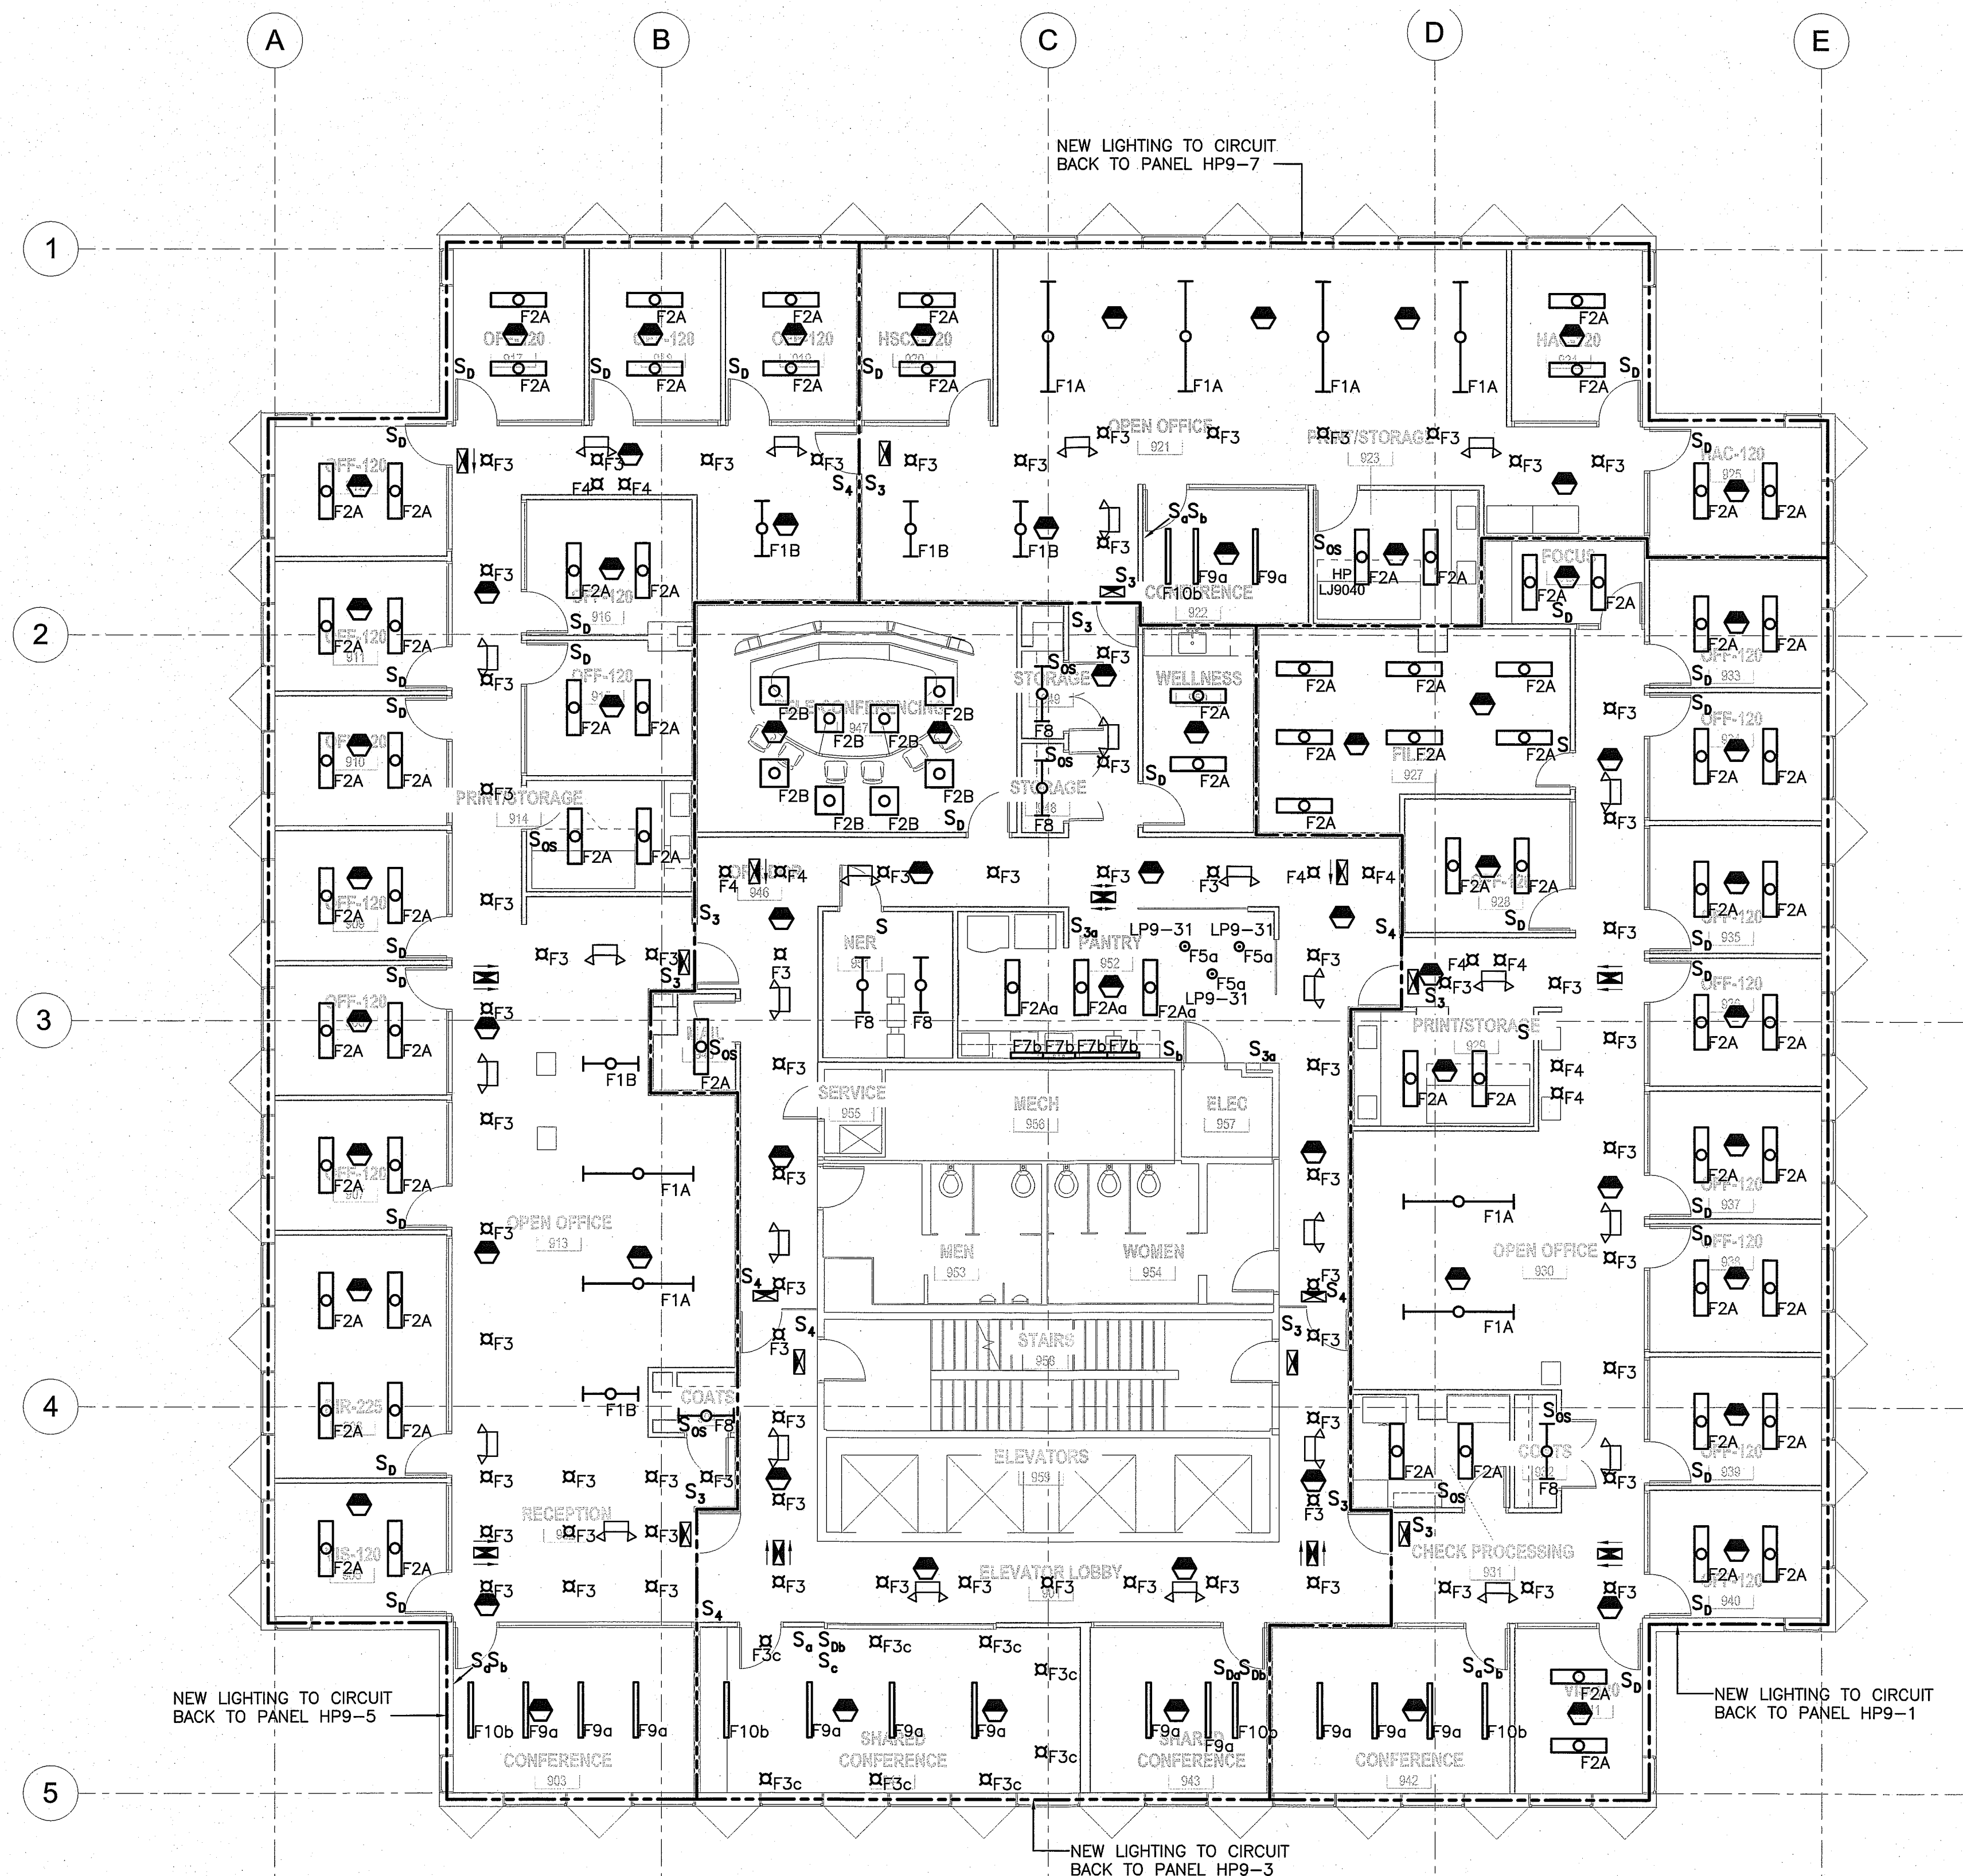

**1** NINTH FLOOR PLAN  
1/8" = 1'-0"

**REVISIONS**

**BANK OF AMERICA - 9TH & 10TH FLOORS**

BANK OF AMERICA  
1 MONUMENT SQUARE  
Portland, ME

**TITLE**  
NINTH FLOOR ELECTRICAL LIGHTING PLAN

**DATE**                      **JOB NO.**  
May 11, 2015                      15051.00

**DRAWING NO.**                      **EL101**

ISSUED FOR CONSTRUCTION

