
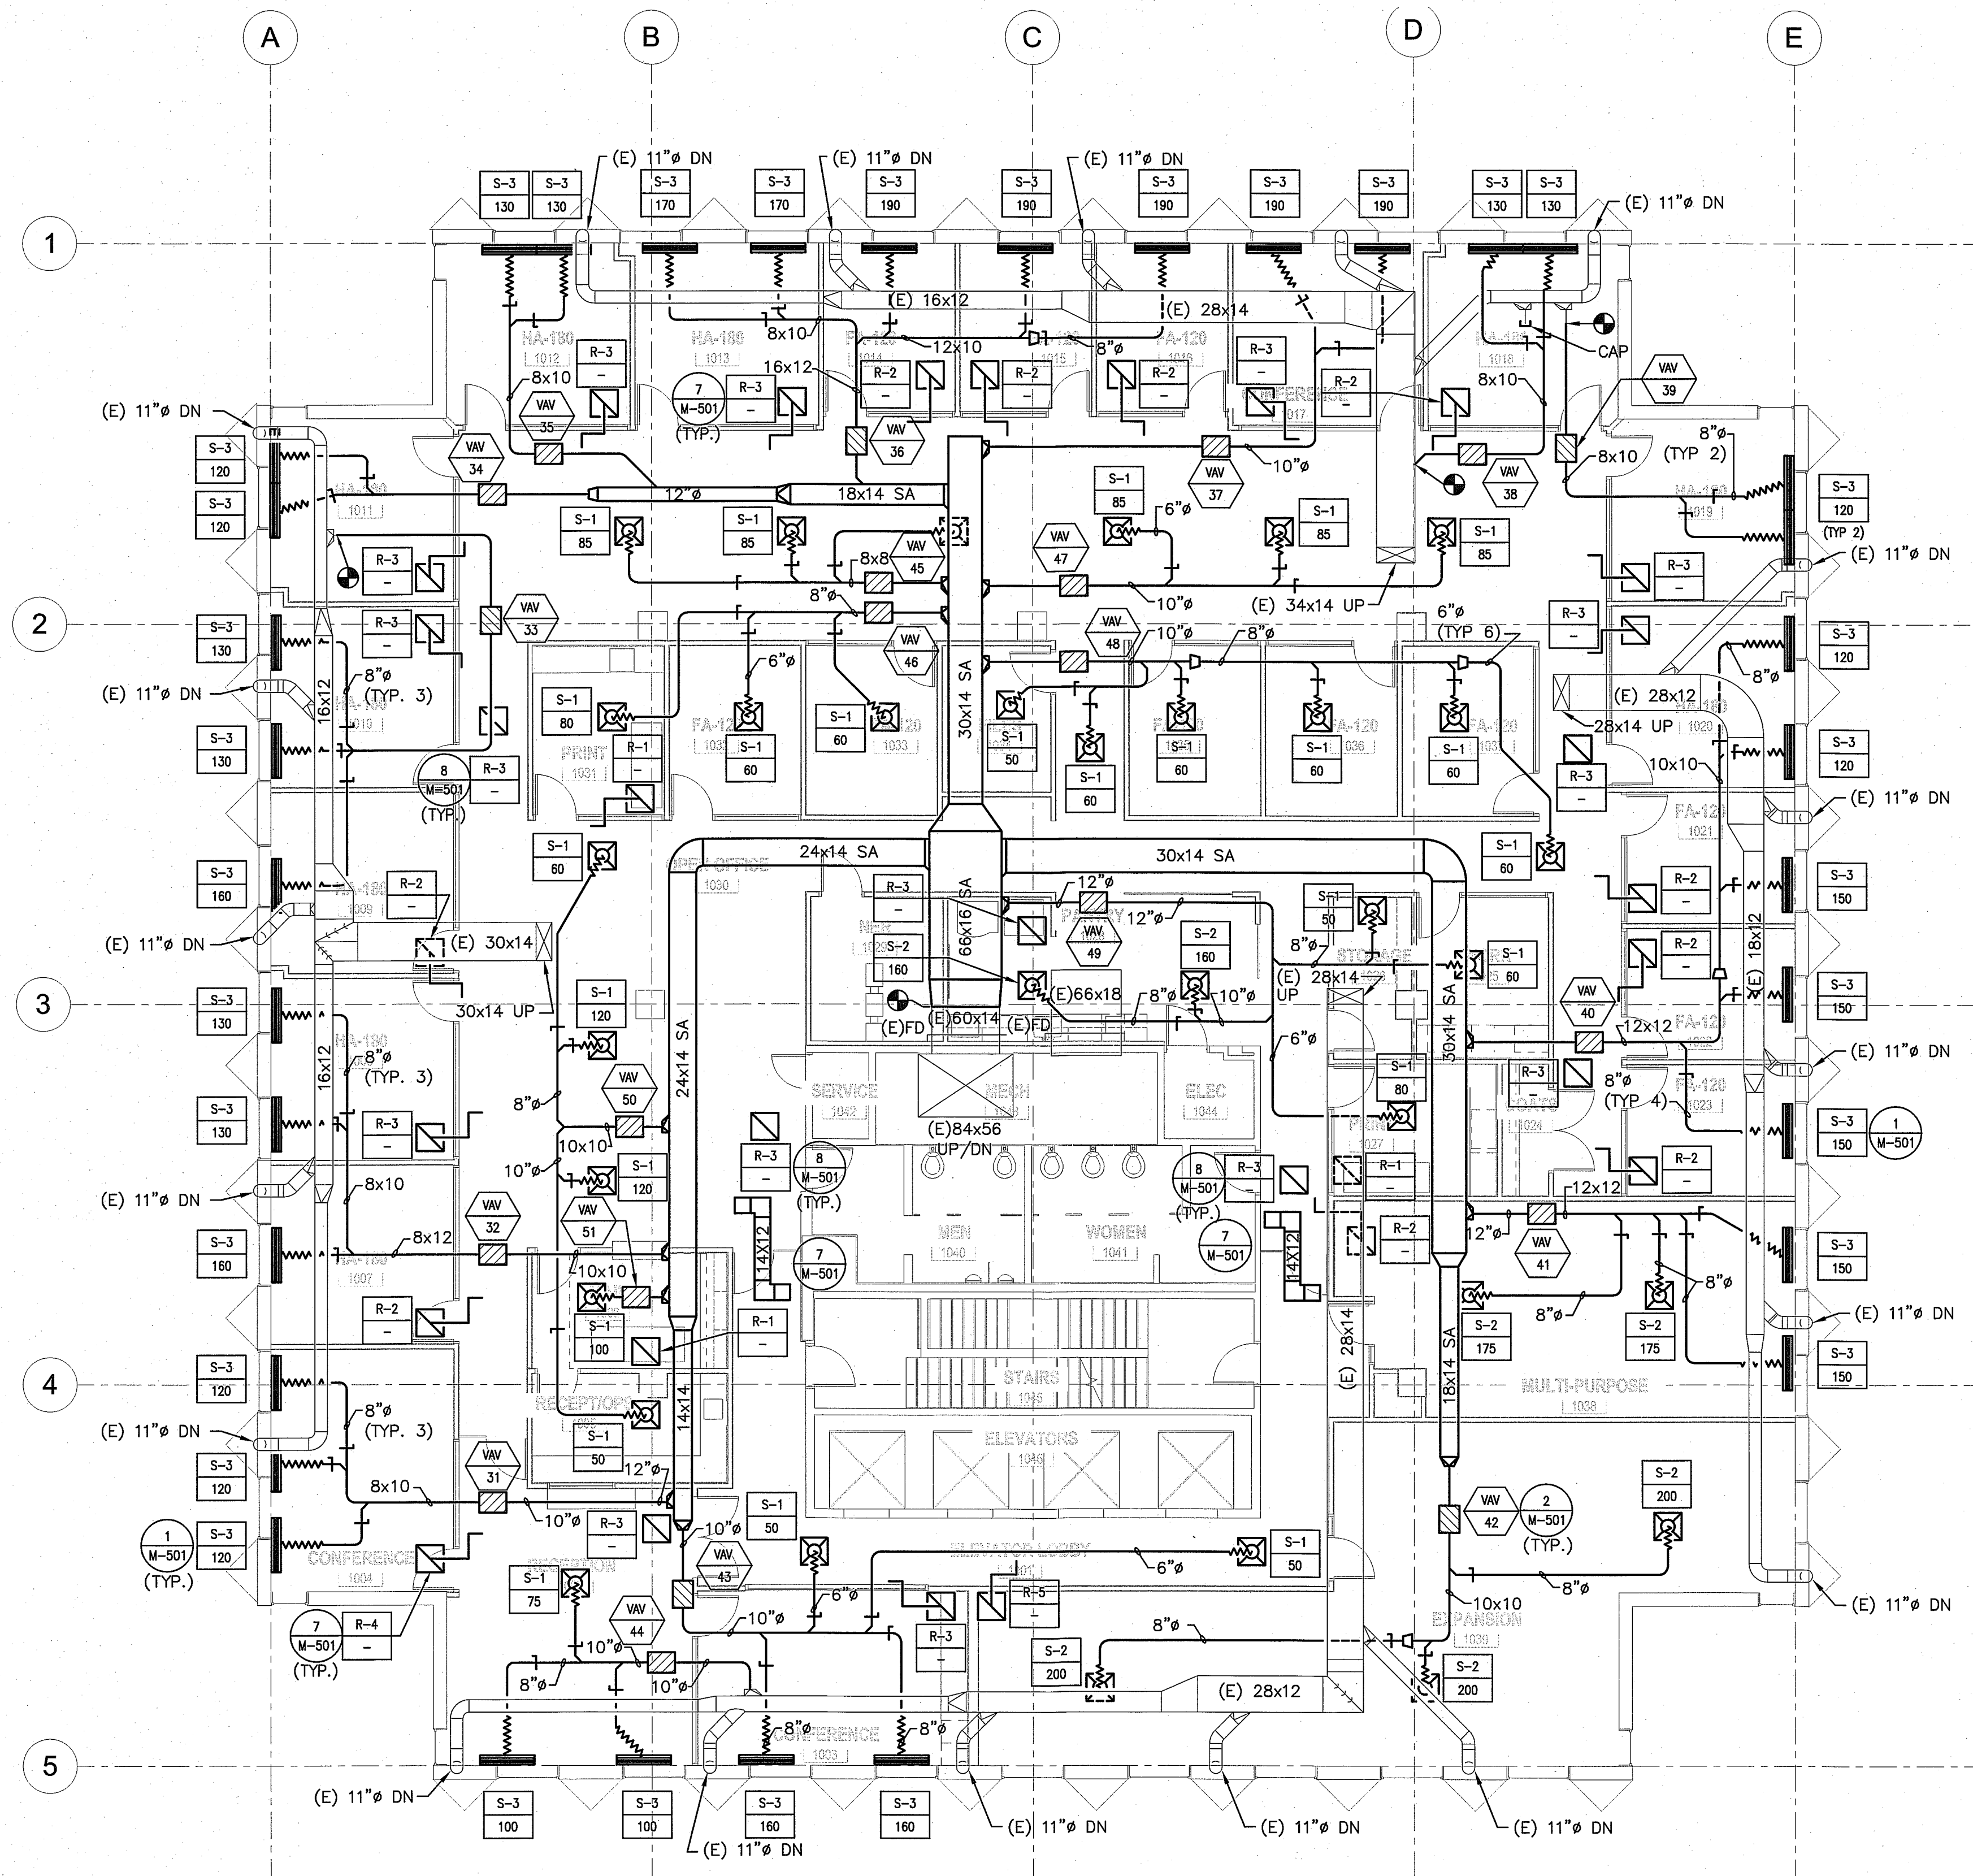


NOTES:

1. SEE SHEET M-001 FOR LEGEND AND ABBREVIATIONS.

SMRT ARCHITECTURE ENGINEERING PLANNING INTERIOR DESIGN COMMISSIONING

144 Fore Street, P.O. Box 618
 Portland, Maine 04104
 tel. (207) 772-3846
 fax. (207) 772-1070
 www.smrtinc.com
 SMRT PROJECT #15035

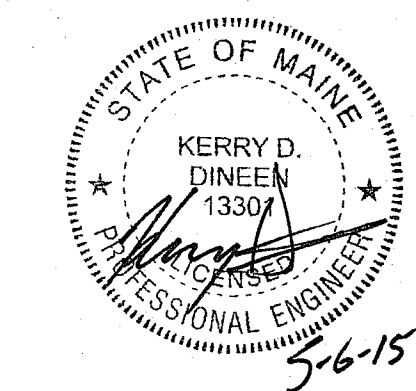

1 TENTH FLOOR PLAN
 1/8" = 1'-0"

REVISIONS

BANK OF AMERICA - 9TH & 10TH FLOORS

BANK OF AMERICA
 1 MONUMENT SQUARE
 Portland, ME

TITLE
 TENTH FLOOR HVAC DUCTWORK PLAN

DATE **JOB NO.**
 May 11, 2015 15051.00

DRAWING NO. **MH102**

ISSUED FOR CONSTRUCTION

AIRFLOW NOTE
 1. BUILDING OWNER TO PROVIDE 9,200 CFM OF 55 DEG F AT A MINIMUM OF 30% OUTSIDE AIR TO MEET SPACE LOAD AND VENTILATION REQUIREMENTS. CFM VALUE INCLUDES PROVISIONS FOR FUTURE FITOUT OF EXPANSION 1039.

