



- POWER TEL-DATA NOTES**
- ALL DEVICES TO BE NEW UNLESS NOTED AS "EX" FOR EXISTING TO REMAIN. ANY DEVICES NOT SHOWN ON PLAN ARE EXISTING TO REMAIN.
 - GC RESPONSIBLE FOR REMOVAL OF ALL DEVICES IN THEIR ENTIRETY IF NOTED ON PLAN TO BE DEMOLISHED. BLANK COVER PLATES ARE NOTE ACCEPTABLE. PATCH WALL AS REQUIRED FOR FINAL FINISH.
 - ALL DEVICES TO BE MOUNTED AT 18" AFF UNLESS NOTED OTHERWISE.
 - VERIFY LOCATION OF FLOOR-MOUNTED OUTLETS / FLOOR CORES WITH ARCHITECT IN FIELD.
 - OUTLETS SHOWN ABOVE COUNTERS (COFFEE STATIONS, KITCHENS) TO BE MOUNTED AT 44" AFF TO CENTER LINE UNLESS NOTED OTHERWISE.
 - CENTER ALL THERMOSTATS OVER CENTER LINE OF SWITCH OR SWITCH-BANK WHERE APPLICABLE.
 - AFFIX DEVICE BOXES TO CLOSEST STUD UNLESS SPECIFIC DIMENSION SHOWN.
 - STAGGER DEVICE BOXES IN STUD BAYS.
 - SEE ENGINEERING DRAWINGS FOR EMERGENCY LIGHTING, EXIT SIGNS AND SMOKE DETECTORS. COORDINATE WITH ENGINEERING DRAWINGS.
 - THIS DRAWING IS FOR LOCATION PURPOSES ONLY. COORDINATE WORK WITH MEP/FP DRAWINGS. REPORT ANY DISCREPANCIES TO THE ARCHITECT BEFORE PROCEEDING WITH AFFECTED WORK.
 - THERMOSTAT AND OUTLET DIMENSIONS ARE TO CENTER OF DEVICE
 - GC SHALL REVIEW ALL LIGHTING AND POWERED FIXTURES TO CONFIRM AND PROVIDE CORRECT MOUNTING AND INSTALLATION CLEARANCES AND CONSTRUCTION, COMPLYING WITH MANUFACTURERS SPECIFICATIONS.
 - REFER TO BANK OF AMERICA TBOD AND TYCO SECURITY DRAWINGS FOR LOCATIONS, SPECIFICATIONS AND POWER REQUIREMENTS OF EQUIPMENT INCLUDING SECURITY CAMERAS AND WIRELESS ACCESS POINTS. G.C. TO COORDINATE INSTALLATION AND ANY CABLING CONDUIT REQUIREMENTS.

POWER PLAN KEYNOTES

NOTE	DESCRIPTION
E1	SEE ENGINEERS DRAWINGS FOR ADDITIONAL INFORMATION
E2	CONFIRM ALL FLOOR BOX LOCATIONS WITH FURNITURE VENDOR. COORDINATE WITH WAFFLE SLAB STRUCTURE. FLOOR CORES CANNOT BE PLACED AT STRUCTURAL WEB MEMBERS.

REVISIONS

BANK OF AMERICA - 9TH & 10TH FLOORS


BANK OF AMERICA
1 MONUMENT SQUARE
Portland, ME

TITLE
9TH FLOOR POWER/TEL/DATA PLAN


DATE May 11, 2015
JOB NO. 15051.00

DRAWING NO. **A4.09**


ISSUED FOR CONSTRUCTION

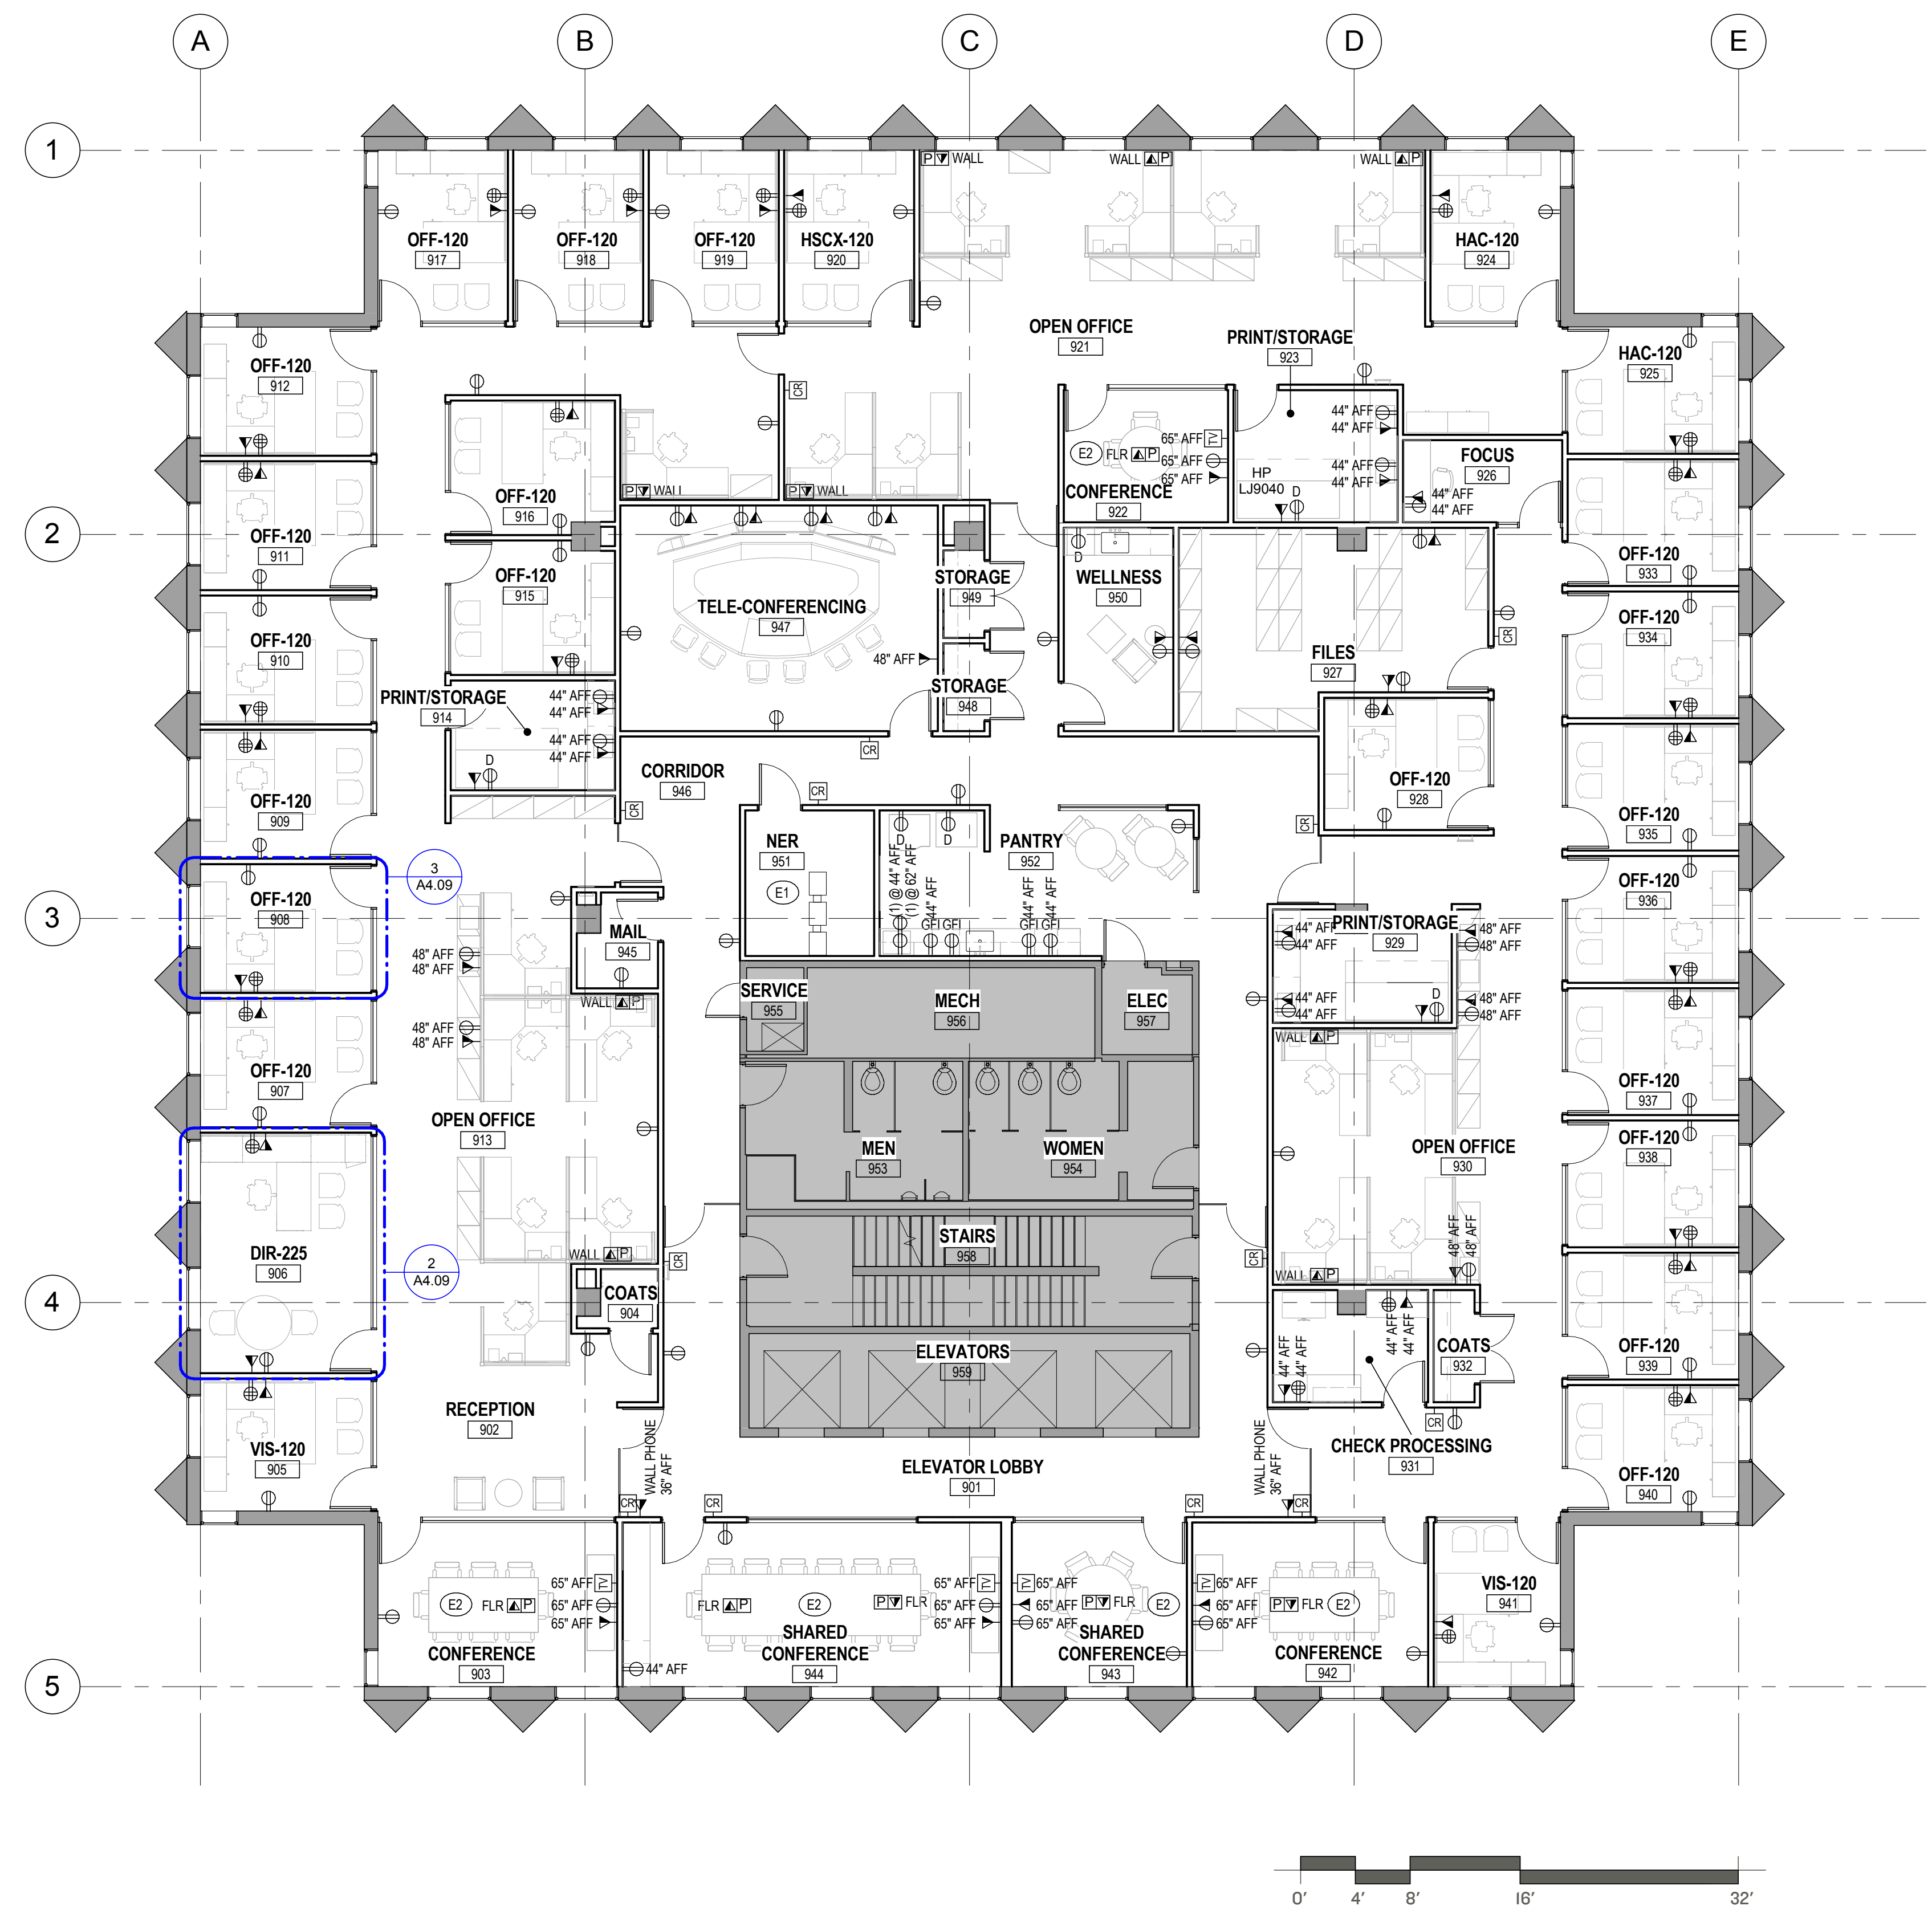


① 9th FLOOR POWER/TEL/DATA PLAN
1/8" = 1'-0"

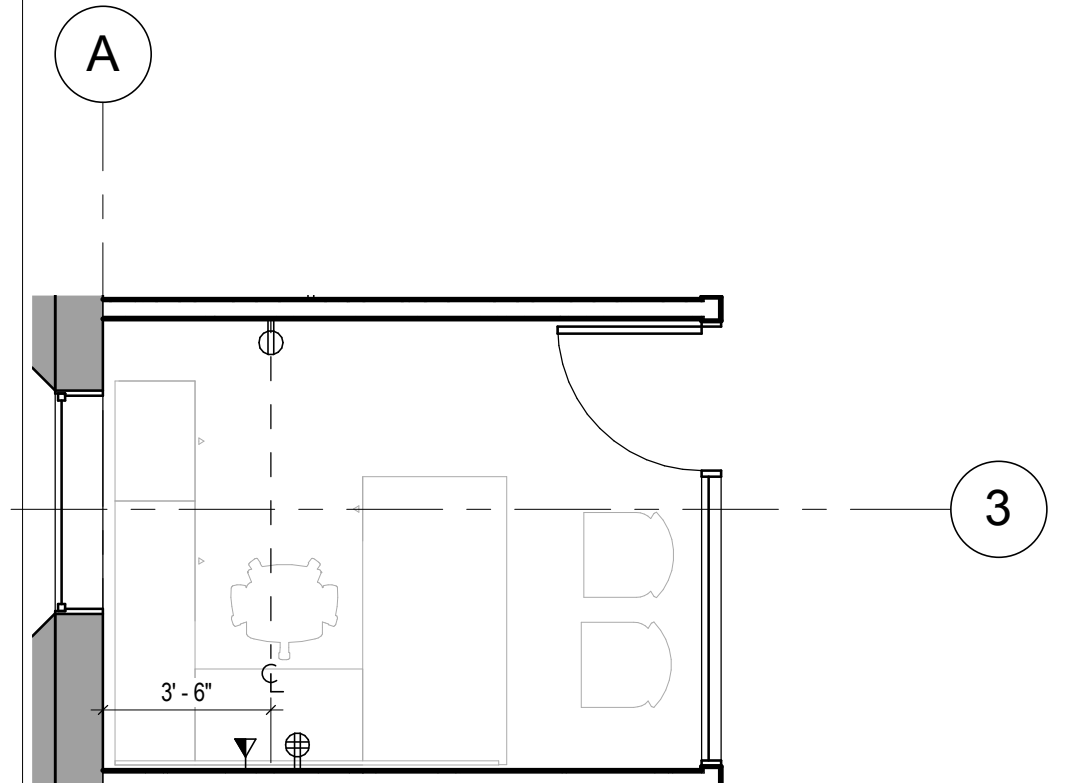

③ TYPICAL 9TH FLOOR OFFICE 120 - NEW FURNITURE
1/4" = 1'-0"

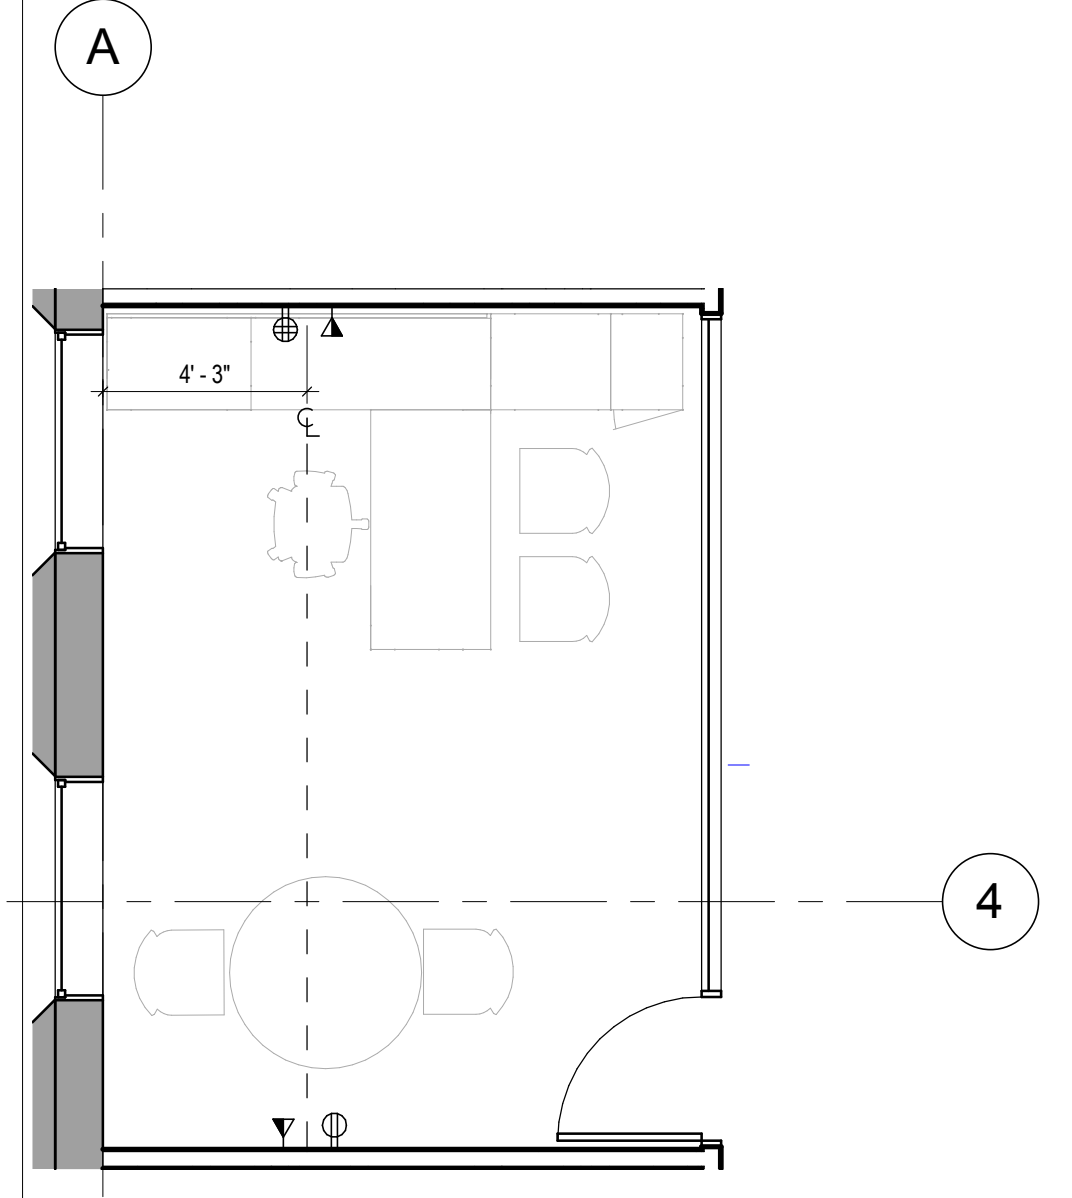

② TYPICAL 9TH FLOOR DIR 225 - NEW FURNITURE
1/4" = 1'-0"

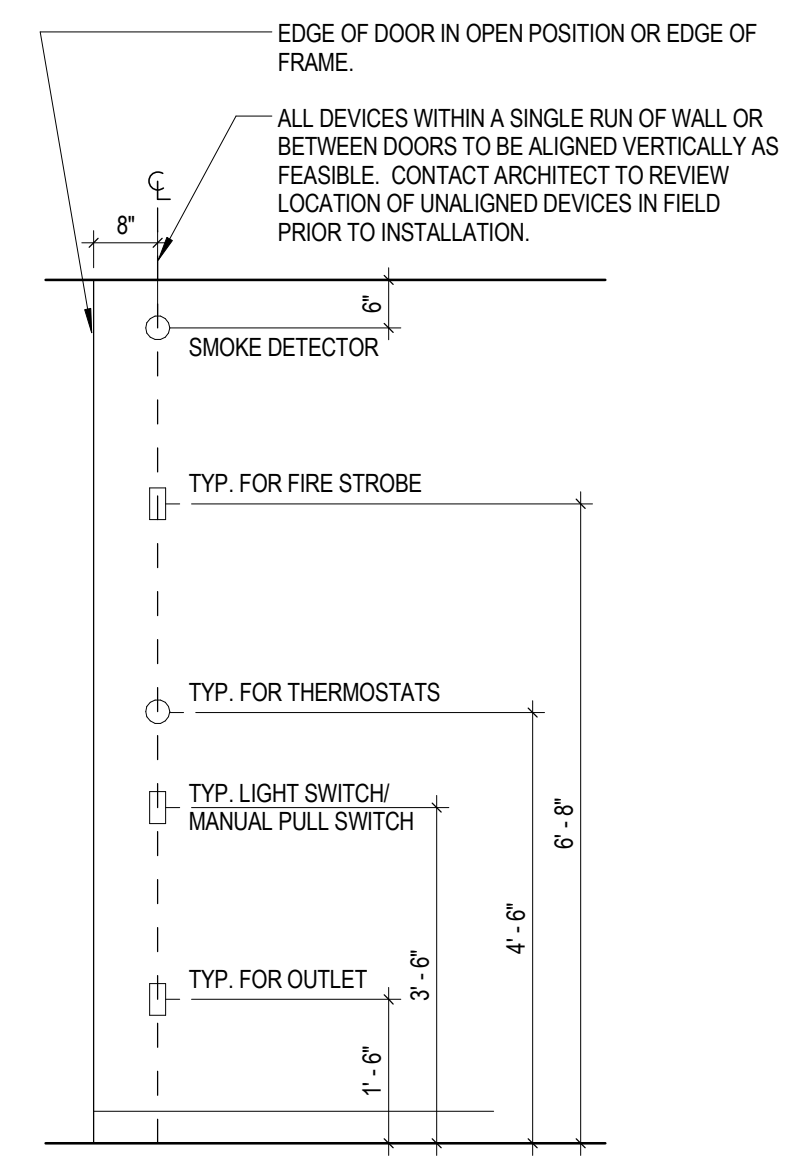

TYPICAL OUTLET AND DEVICE LOCATIONS
1/2" = 1'-0"