




**LEGEND:**

RISER DIAG SYM	DESCRIPTION	CATALOG #
⊙	SMOKE DETECTOR	ASD-PL2F
F	PULL STATION	MS-7AF
⊗	SPEAKER STROBE	ES0-24MCW-FR
⊠	STROBE UNIT	STR

Title: Ninth Floor  
 Scale: 1/8" = 1'-0"  
 Project: Bank of America - One Monument Square

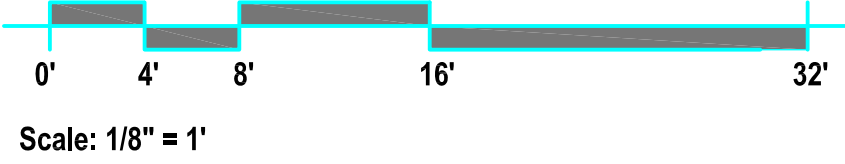

DWG NAME: Bank of America - 9th Floor  
 One Monument Square  
 Portland, ME  
 FIRE ALARM FLOOR PLAN  
 DWG No: 87871\_FlrPin

**R.B. Allen Co., Inc.**  
 P.O. BOX 170  
 131 LAL...  
 N.H. HAMPTON, NH 03842  
 1-800-258-7264

**ES**  
 EDWARDS SYSTEM TECHNOLOGY

JOB NAME: Bank of America - 9th Floor  
 One Monument Square  
 Portland, ME  
 FIRE ALARM FLOOR PLAN  
 Contractor:

SCALE: NTS

REV.	DATE	DESCRIPTION	DRWN:	IRW/D:
0	6/15	Original Issue		

PO No. 87871  
 BOA - 9th Floor  
 One Monument Square  
 Portland, ME  
 FIRE ALARM FLOOR PLAN  
 DWG No. 87871\_FlrPin