


Title: Tenth Floor  
 Scale: 1/8" = 1'-0"  
 Project: Bank of America - One Monument Square

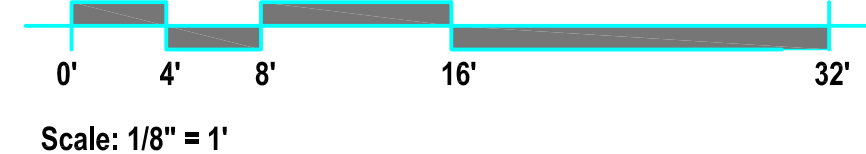

**LEGEND:**

RISER DIAG SYM	DESCRIPTION	CATALOG #
?	SMOKE DETECTOR	ASD-PL2F
F	PULL STATION	MS-7AF
⊗	SPEAKER STROBE	ES0-24MCW-FR
⊠	STROBE UNIT	STR

DWG NAME:  
 Bank of America - 10th Floor  
 One Monument Square  
 Portland, ME  
 FIRE ALARM RISER DIAGRAM  
 DWG No: 87871\_FlrPln

**R.B. Allen Co., Inc.**  
 P.O. BOX 770  
 131 LAKE ST  
 NO. HAMPTON, NH 03842  
 1-800-258-7284

EDWARDS SYSTEM TECHNOLOGY

JOB NAME:  
 Bank of America - 10th Floor  
 One Monument Square  
 Portland, ME  
 FIRE ALARM FLOOR PLAN  
 Contractor:

SCALE:	NTS	DATE	DRWN:	IRW/D:
Original Issue	6/15	CLA	TRD	
REV.		DATE	DRWN:	IRW/D:

PO No. 87871  
 BOA - 10th Floor  
 One Monument Square  
 Portland, ME  
 FIRE ALARM FLOOR PLAN  
 DWG No. 87871\_FlrPln