


17th Floor 2 Ductless split
 Computer room

2 units @ 50lbs each

w/ Refrigerant piping
 no venting

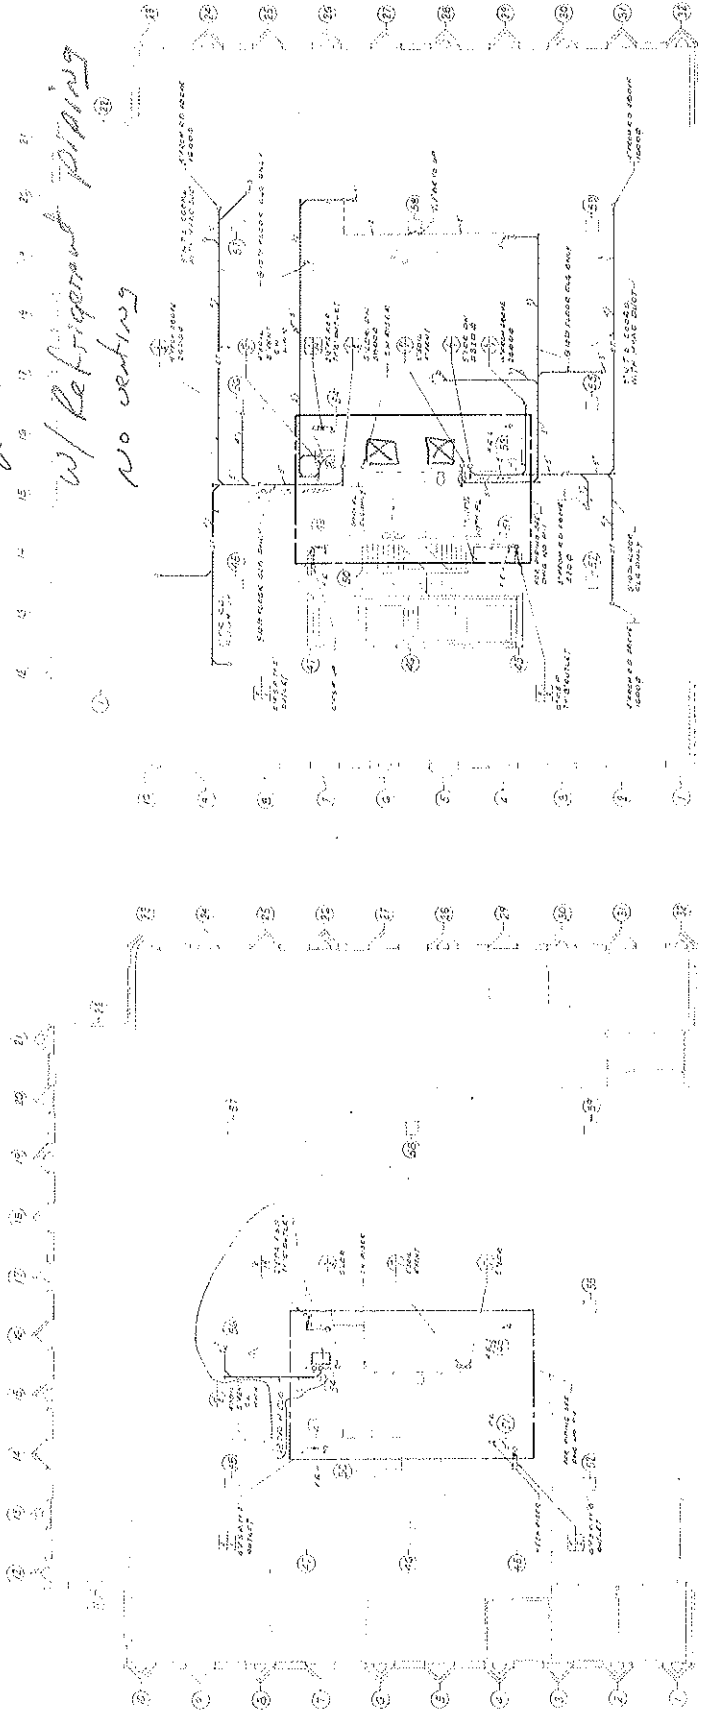

17th FLOOR PLAN
 COMPUTER ROOM
 SPLIT SPLIT SPLIT SPLIT

SEE ELEVATION FOR
 SPLIT SPLIT SPLIT SPLIT
 SPLIT SPLIT SPLIT SPLIT

17th FLOOR PLAN
 COMPUTER ROOM

CASCO BANK & TRUST CO MONUMENT SQUARE PORTLAND, MAINE WALKER O'CAIN & ASSOCIATES ARCHITECTS 101 PARK AVENUE NEW YORK, N.Y. 10017 A. O'CAIN PROJECT NUMBER 17-002-1-1-1		17th FLOOR PLAN COMPUTER ROOM SPLIT SPLIT SPLIT SPLIT SPLIT SPLIT SPLIT SPLIT
PROJECT NO. 17-002-1-1-1	DRAWING NO. 17-002-1-1-1	SHEET NO. P-4

17th Floor

