


 

 
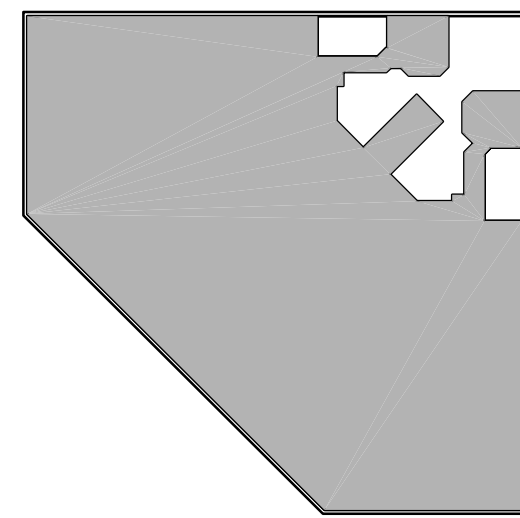
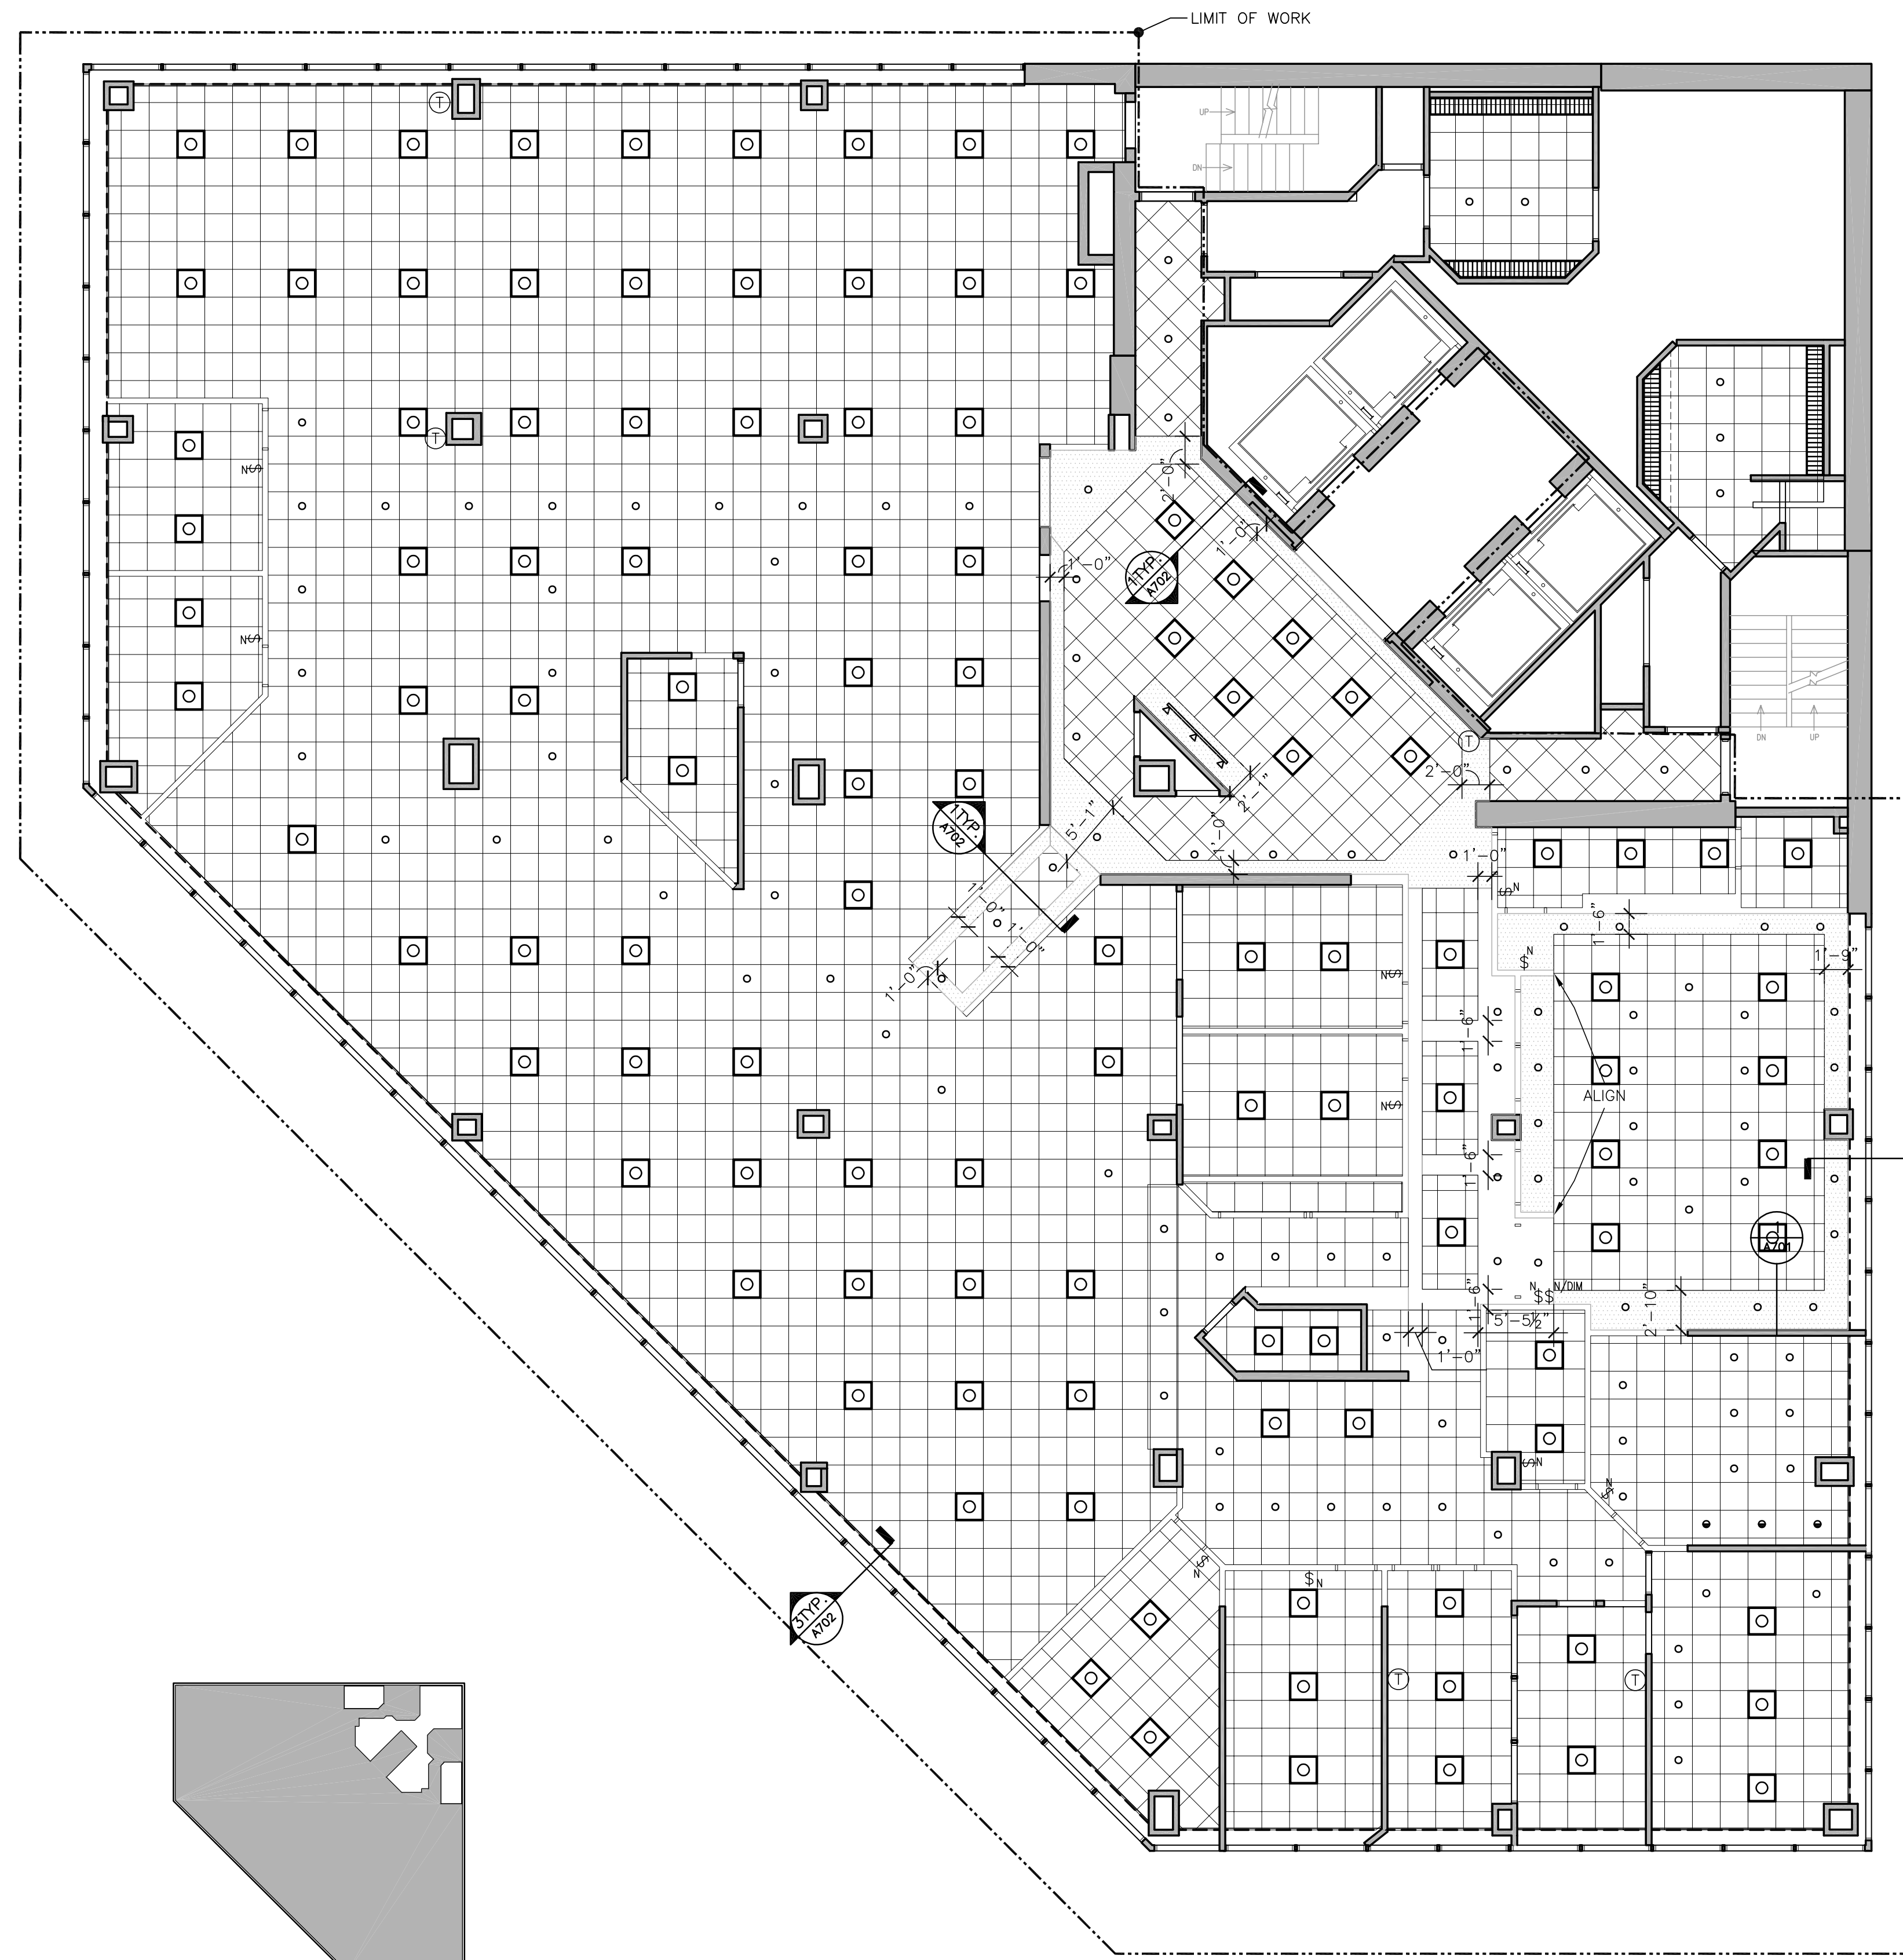


**REFLECTED CEILING NOTES**

1. THIS PLAN IS FOR CEILING FIXTURE, SWITCH AND T-STAT LOCATIONS ONLY. REFER TO MEP ENGINEERING DRAWINGS FOR ADDITIONAL INFORMATION.
2. NEW SPRINKLER HEADS, LIGHT FIXTURES, DIFFUSERS AND ANY CEILING MOUNTED ITEMS SHALL BE CENTERED IN CEILING PANELS AND WILL BE SHOWN ON MEP ENGINEERING DRAWINGS.
3. CEILING HEIGHT TO BE 8'-0" AFF UNLESS OTHERWISE NOTED.

**REFLECTED CEILING LEGEND**

-  2x2 FLUORESCENT LIGHT FIXTURE
  -  COMPACT FLUORESCENT DOWNLIGHT
  -  NEW 2x2 ACOUSTIC CEILING PANEL SYSTEM
  -  NEW GWB SOFFIT
  -  THERMOSTAT
  -  RELOCATED MOTORIZED PROJECTOR SCREEN. COORDINATE OPENING SIZE W/SUB-CONTRACTOR.
- ALL FIXTURES ARE NEW U.O.N.  
 "E" DENOTES EXISTING  
 "R" DENOTES RELOCATED




LOCUS PLAN 

1 REFLECTED CEILING PLAN 9TH FLOOR  
 1/8" = 1'-0"

COPYRIGHT (C) BY CUBELLIS ASSOCIATES INC. ALL RIGHTS RESERVED. NO PART OF THIS DRAWING OR ANY PARTS THEREOF MAY BE REPRODUCED, COPIED, OR TRANSMITTED IN ANY FORM OR BY ANY MEANS, ELECTRONIC, MECHANICAL, PHOTOCOPIING, RECORDING OR OTHERWISE, WITHOUT THE EXPRESS WRITTEN CONSENT OF CUBELLIS ASSOCIATES INC. ANY REVISIONS MADE TO THIS DOCUMENT WITHOUT THE WRITTEN PERMISSION OF CUBELLIS ASSOCIATES INC. SHALL REMAIN IT UNVALID.

NO.	DATE	REVISIONS
B	07/07/03	ISSUED FOR PERMIT & PRICING
C	08.18.03	ISSUED FOR CONSTRUCTION

PROJECT NORTH

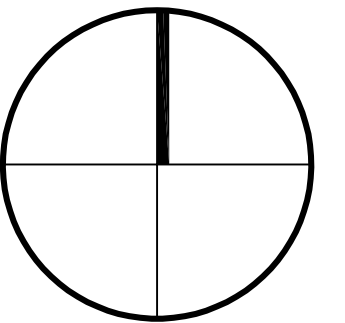

**MEDICAL MUTUAL  
 INSURANCE COMPANY**  
 1 CITY CENTER - PORTLAND, ME

OWNER

TITLE  
**REFLECTED  
 CEILING PLAN  
 9TH FLOOR**

SCALE  
 1/8" = 1'-0"

**Cubellis  
 Associates Inc.**  
 Architecture Interiors Engineering  
 428 Fore Street, 3rd Fl.  
 Portland, ME 04101  
 Tel: 207-874-2775  
 Fax: 207-874-2775  
 www.cubellis.com

CHECKED BY  
 MW/SP

DATE  
 1/6/03

DRAWN BY  
 JAT/GC

**A409**

02278