

29 BLACK POINT ROAD
SCARBOROUGH, MAINE 04074
207-883-6307
WWW.GAWRONTURGEON.COM

**GAWRON
TURGEON**
ARCHITECTS

ELEVENTH FLOOR
ONE CITY CENTER
PORTLAND, MAINE


REVISIONS		
#	DATE	DESCRIPTION

DATE:	10-04-16
PROJECT #:	120715
DRAWN BY:	DLP
CHECKED BY:	MET
DRAWING SCALE:	AS NOTED

SHEET TITLE
ELEVENTH FLOOR
REFLECTED CEILING
PLAN
LEGEND/NOTES
SOFFIT DETAILS


A300

© COPYRIGHT 1985-2008
REPRODUCTION OR REUSE OF THIS
DOCUMENT WITHOUT WRITTEN
PERMISSION OF GAWRON TURGEON
ARCHITECTS IS PROHIBITED.

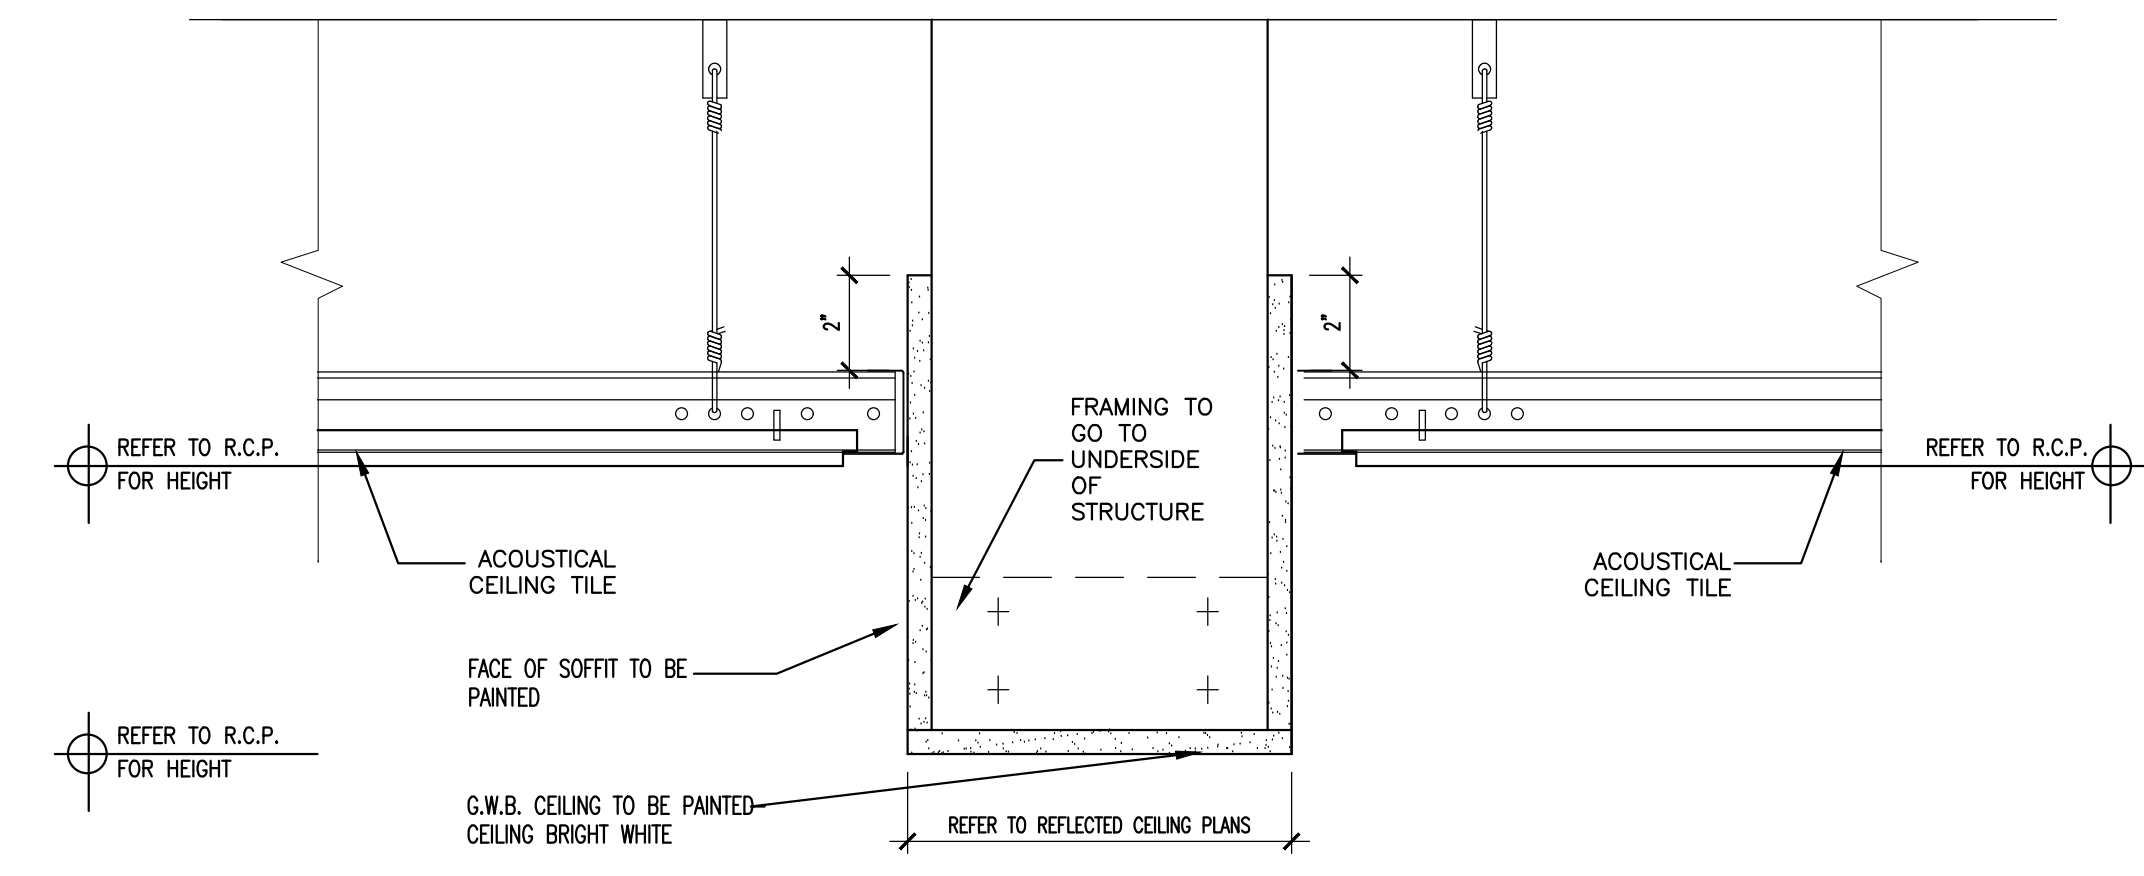

M13 SOFFIT DETAIL

3"=1'-0"

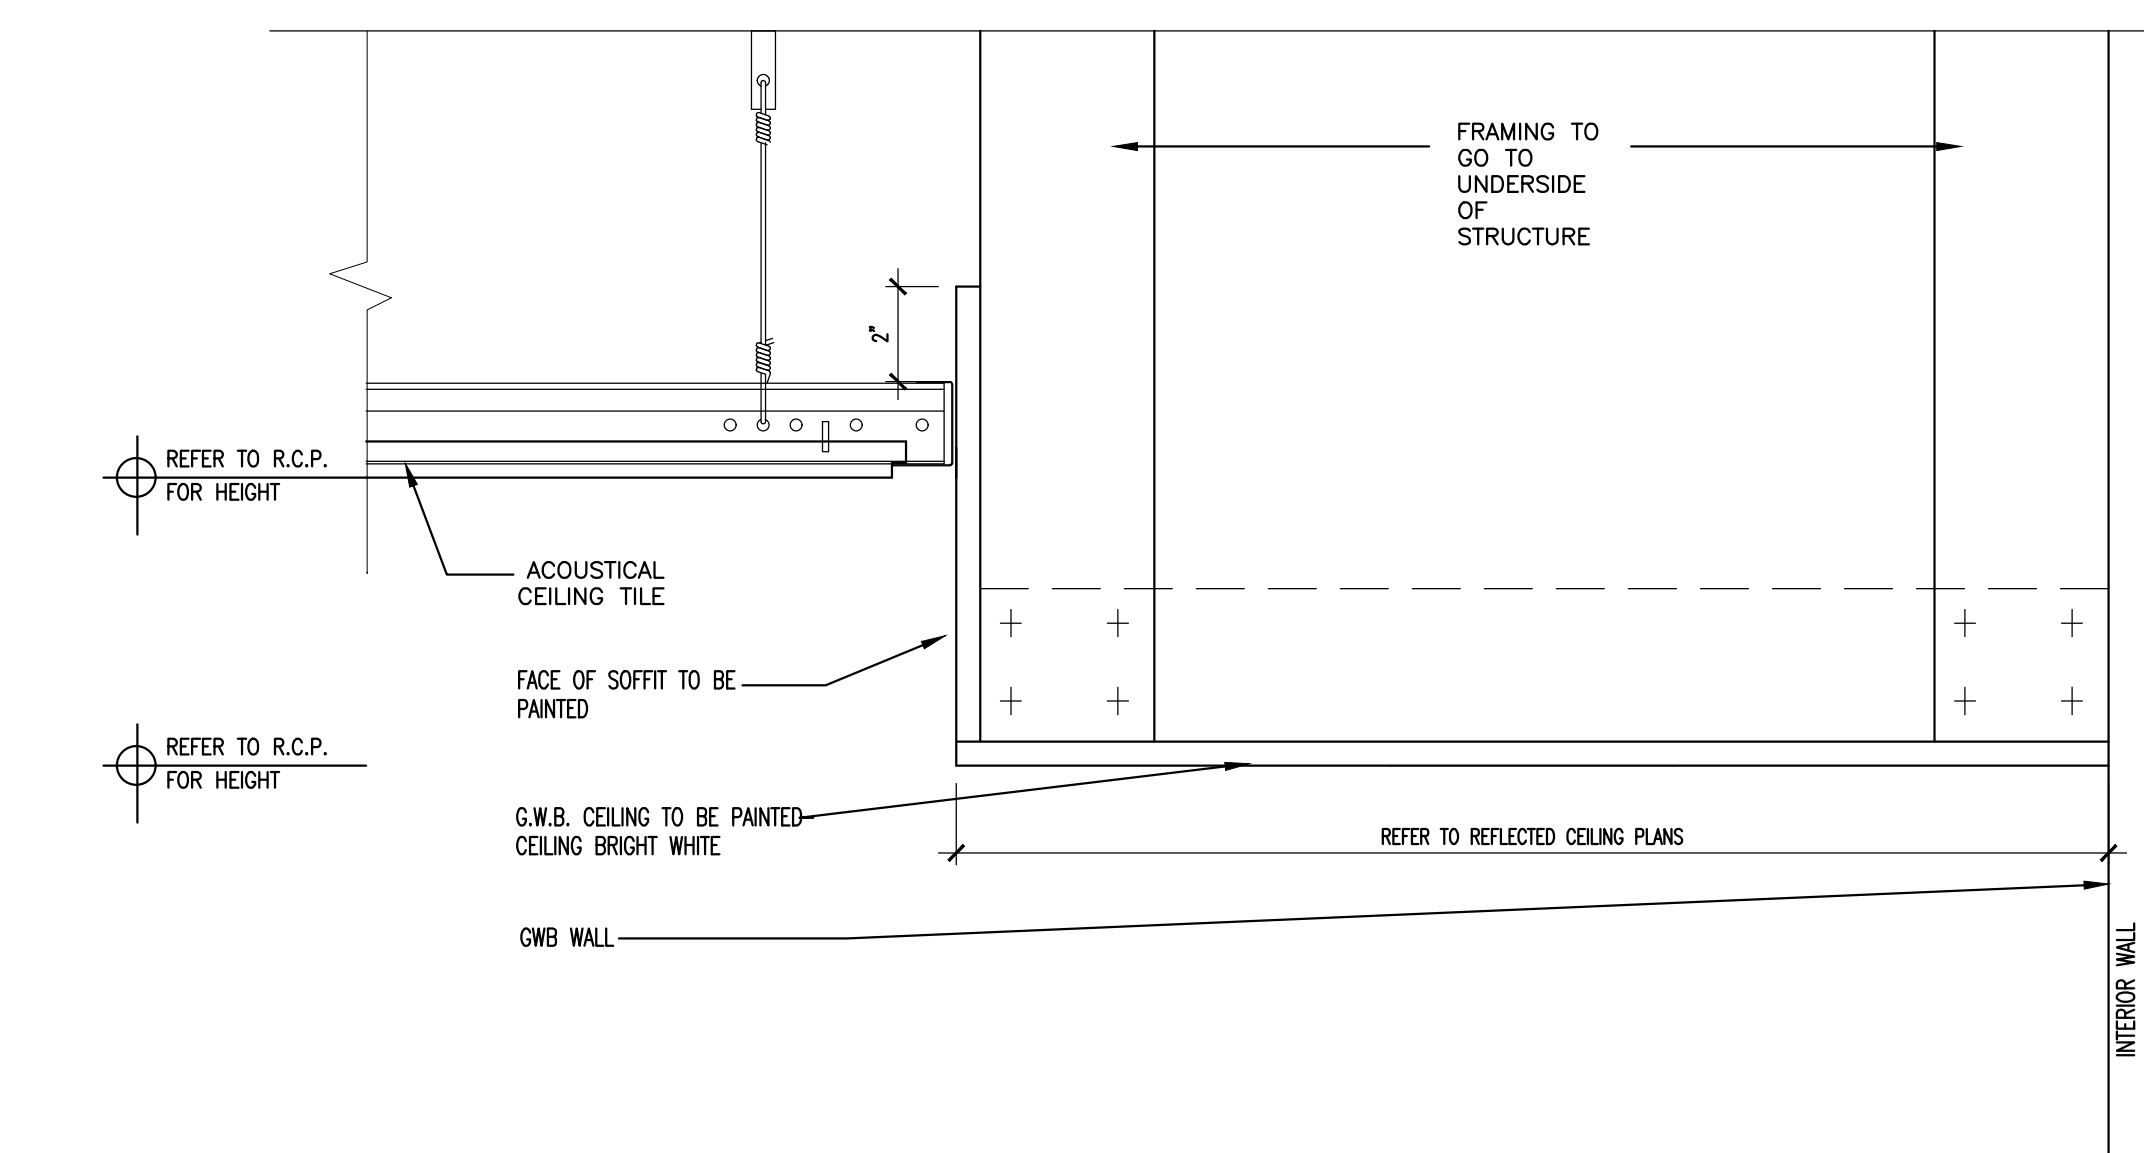

G13 SOFFIT DETAIL

3"=1'-0"

LIGHT FIXTURE LEGEND


- EMERGENCY BATTERY UNIT
- EXIT SIGN
- HORN STROBE
- FE FIRE EXTINGUISHER
- 2x2 LED LIGHTING
- LED RECESSED DOWNLIGHT

ACT1- ARMSTRONG CEILINGS, DUNE 18" ANGLED
REGULAR 24x24"

NOTES:

- MECHANICAL SUBCONTRACTOR TO VERIFY SIZE AND LOCATION OF ANY MECHANICAL REGISTERS WITH ARCHITECT PRIOR TO CONSTRUCTION.
- SWITCH ALL OFFICES INDEPENDENTLY. DOUBLE SWITCH ALL CONFERENCE ROOMS AND PUT RECESSED CANS ON DIMMER SWITCH.
- ELECTRICAL CONTRACTOR SHALL COORDINATE OWNER SUPPLIED TELEPHONE & DATA BOXES WITH LOCATIONS OF OUTLETS.
- G.C. TO COORDINATE ALL SPECIALTY EQUIPMENT WITH TENANTS VENDOR.
- G.C. TO SALVAGE EXISTING LED LIGHTING FOR RE-INSTALLATION. NEW FIXTURES SHALL BE ADDED AS NEEDED.
- REVIEW LIGHTING SPACING WITH EXISTING DIFFUSER LOCATIONS AND SPRINKLER HEADS - VERIFY ANY DISCREPANCIES WITH ARCHITECT.
- ALL EXISTING LIFE SAFETY DEVICES TO REMAIN AS IS - ADD NEW FIXTURES PER REFLECTED CEILING PLAN.

A13 LEGEND/NOTES

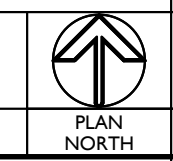

PLAN NORTH



A1 ELEVENTH FLOOR REFLECTED CEILING PLAN

1/8"=1'-0"