


Mark	Date	Description
05-21-13	75% REVIEW	
05-31-13	ISSUED FOR CONSTRUCTION	
06-10-13	ISSUED FOR PERMITTING	
07-26-13	RE-ISSUED FOR CONSTRUCTION	
09-23-13	RE-ISSUED FOR CONSTRUCTION	

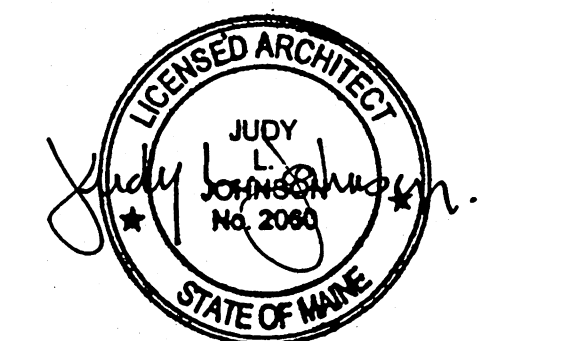



Drawing Scales	0	2'	4'	6'
1/4" = 1'-0"	[Scale bar]			
1/4" = 1'-0"	[Scale bar]			

PA / PE: RBB © 2013
 Drawn By: CMP Harriman Associates

EQUIPMENT SCHEDULE				
MARK	SUPPLY/INSTALL	NAME	MANUFACTURER	MODEL #
27	OS/CI	HAND SINK	PERLICK	TS12HSN
28	OS/CI	THREE COMPARTMENT SINK	PERLICK	TS43L
29	OS/CI	DRAINBOARD	PERLICK	7055A-D
30	OS/CI	WALK-IN COOLER	KOLPAK	KL846-C
31	OS/CI	MOP SINK	CENTAUR	FMS-252110
31A	OS/CI	SERVICE SINK FAUCET	T&S BRASS	B-0665-01
32	OS/CI	WORK TABLE	EAGLE	T2460SE-BS
32A	OS/CI	WALL SHELF	EAGLE	WS1260-16/4
33	OS/CI	WORKTABLE	EAGLE	T2448SE-BS
33A	OS/CI	WALL SHELF	EAGLE	WS1248-16/4
34	OS/CI	WORKTABLE	EAGLE	T2484SE-BS
35	OS/CI	WALL SHELF	EAGLE	WS1260-16/4
36	OS/CI	WORKTABLE	EAGLE	T2472SE-BS
37	OS/CI	WALL SHELF	EAGLE	WS1272-16/4
38	OS/CI	WORKTABLE	EAGLE	T2454SE
39	OS/CI	BEER SYSTEM	PERLICK	4404
40	OS/CI	BEER DISPENSING TOWER	PERLICK	4006-8B

EQUIPMENT SCHEDULE				
MARK	SUPPLY/INSTALL	NAME	MANUFACTURER	MODEL #
17A	OS/CI	PRE-RINSE UNIT	T&S BRASS	B-0133-B
17B	OS/CI	DOUBLE SIDED SHORTING SHELF	EAGLE	606295
18	OS/CI	THREE COMPARTMENT SINK	EAGLE	314-18-3-24
18A	OS/CI	PRE-RINSE UNIT	T&S BRASS	B-0133-B
18B	OS/CI	SPLASH MOUNT FAUCET	T&S BRASS	B-0231-CC
19	OS/CI	EXHAUST HOOD	CAPTIVE AIRE	CUSTOM
19A	OS/CI	EXHAUST FAN AND DUCTWORK	NIC	BY OTHERS
19B	OS/CI	SUPPLY FAN AND DUCTWORK	NIC	BY OTHERS
19C	OS/CI	WALL PANELING	CAPTIVE AIRE	FABRICATE
19D	OS/CI	FIRE SUPPRESSION SYSTEM	ANSUL	R-102
20	OS/CI	WORKTABLE	EAGLE	T3084SE-BS
20A	OS/CI	WORKTABLE	EAGLE	T2472SE-BS
20B	OS/CI	WORKSHELF	EAGLE	WS1272-16/4
21	OS/CI	TWO COMPARTMENT SINK	EAGLE	314-18-2
21A	OS/CI	SPLASH MOUNT FAUCET	T&S BRASS	B-0231-CC
21B	OS/CI	WALL SHELF	EAGLE	WS1542-16/4
22	OS/CI	STORAGE SHELVING	CENTAUR	GREEN EPOXY
23	OS/CI	WORKTABLE	EAGLE	T2436SE-BS
24	OS/CI	MOBILE PAN RACK	WIN-HOLT	AL-1820B
25	OS/CI	WALL SHELF W/ POT RACK	EAGLE	WSP1572
26	OS/CI	ICE BIN	PERLICK	TSD24IC

EQUIPMENT SCHEDULE				
MARK	SUPPLY/INSTALL	NAME	MANUFACTURER	MODEL #
1	OS/CI	PLANCHA TOP RANGE	JADE RANGE	JTRH-24P-1HT-36
2	OS/CI	RANGE W/ CONVECTION OVEN	JADE RANGE	JTRH-4-1HT-36C
3	OS/CI	FILLER TABLE	EAGLE	UT3618STE
4	OS/CI	6 BURNER RANGE W/ OVEN	JADE RANGE	JTRH-6-36
5	OS/CI	WORKTABLE	EAGLE	T3024SE-BS
6	OS/CI	FRYER	PITCO	SG18S
7	OS/CI	REFRIGERATED ROOM	NIC	BY OTHERS
7A	OS/CI	COOLER EVAPORATOR	TRIMARK	FABRICATE
7B	OS/CI	COOLER CONDENSING UNIT	TRIMARK	FABRICATE
8	OS/CI	WORKTOP REFRIGERATOR	TRUE	TWT-60D-2
8A	OS/CI	WORKTOP REFRIGERATOR	TRUE	TWT-72D-4
9	OS/CI	REFRIGERATED SANDWICH UNIT	TRUE	TSSU-48-18M-B
10	OS/CI	WORKTOP FREEZER	TRUE	TWT-27F
11	OS/CI	BACKBAR COOLER	TRUE	TBB-24-72
12	OS/CI	ICE MAKER	KOLD-DRAFT	GB564AC
13	OS/CI	DISHWASHER	HOBART	AM15VLT-2
14	OS/CI	UNDERCOUNTER DISHWASHER	HOBART	LXEH-5
15	OS/CI	HAND SINK	CENTAUR	HS-12
16	OS/CI	CLEAN DISHTABLE	EAGLE	CDTL-48-16/4SL
16A	OS/CI	SLANTED RACK SHELF	EAGLE	606642
17	OS/CI	SOILED DISHTABLE	EAGLE	SDTCR-72-16/4MOD

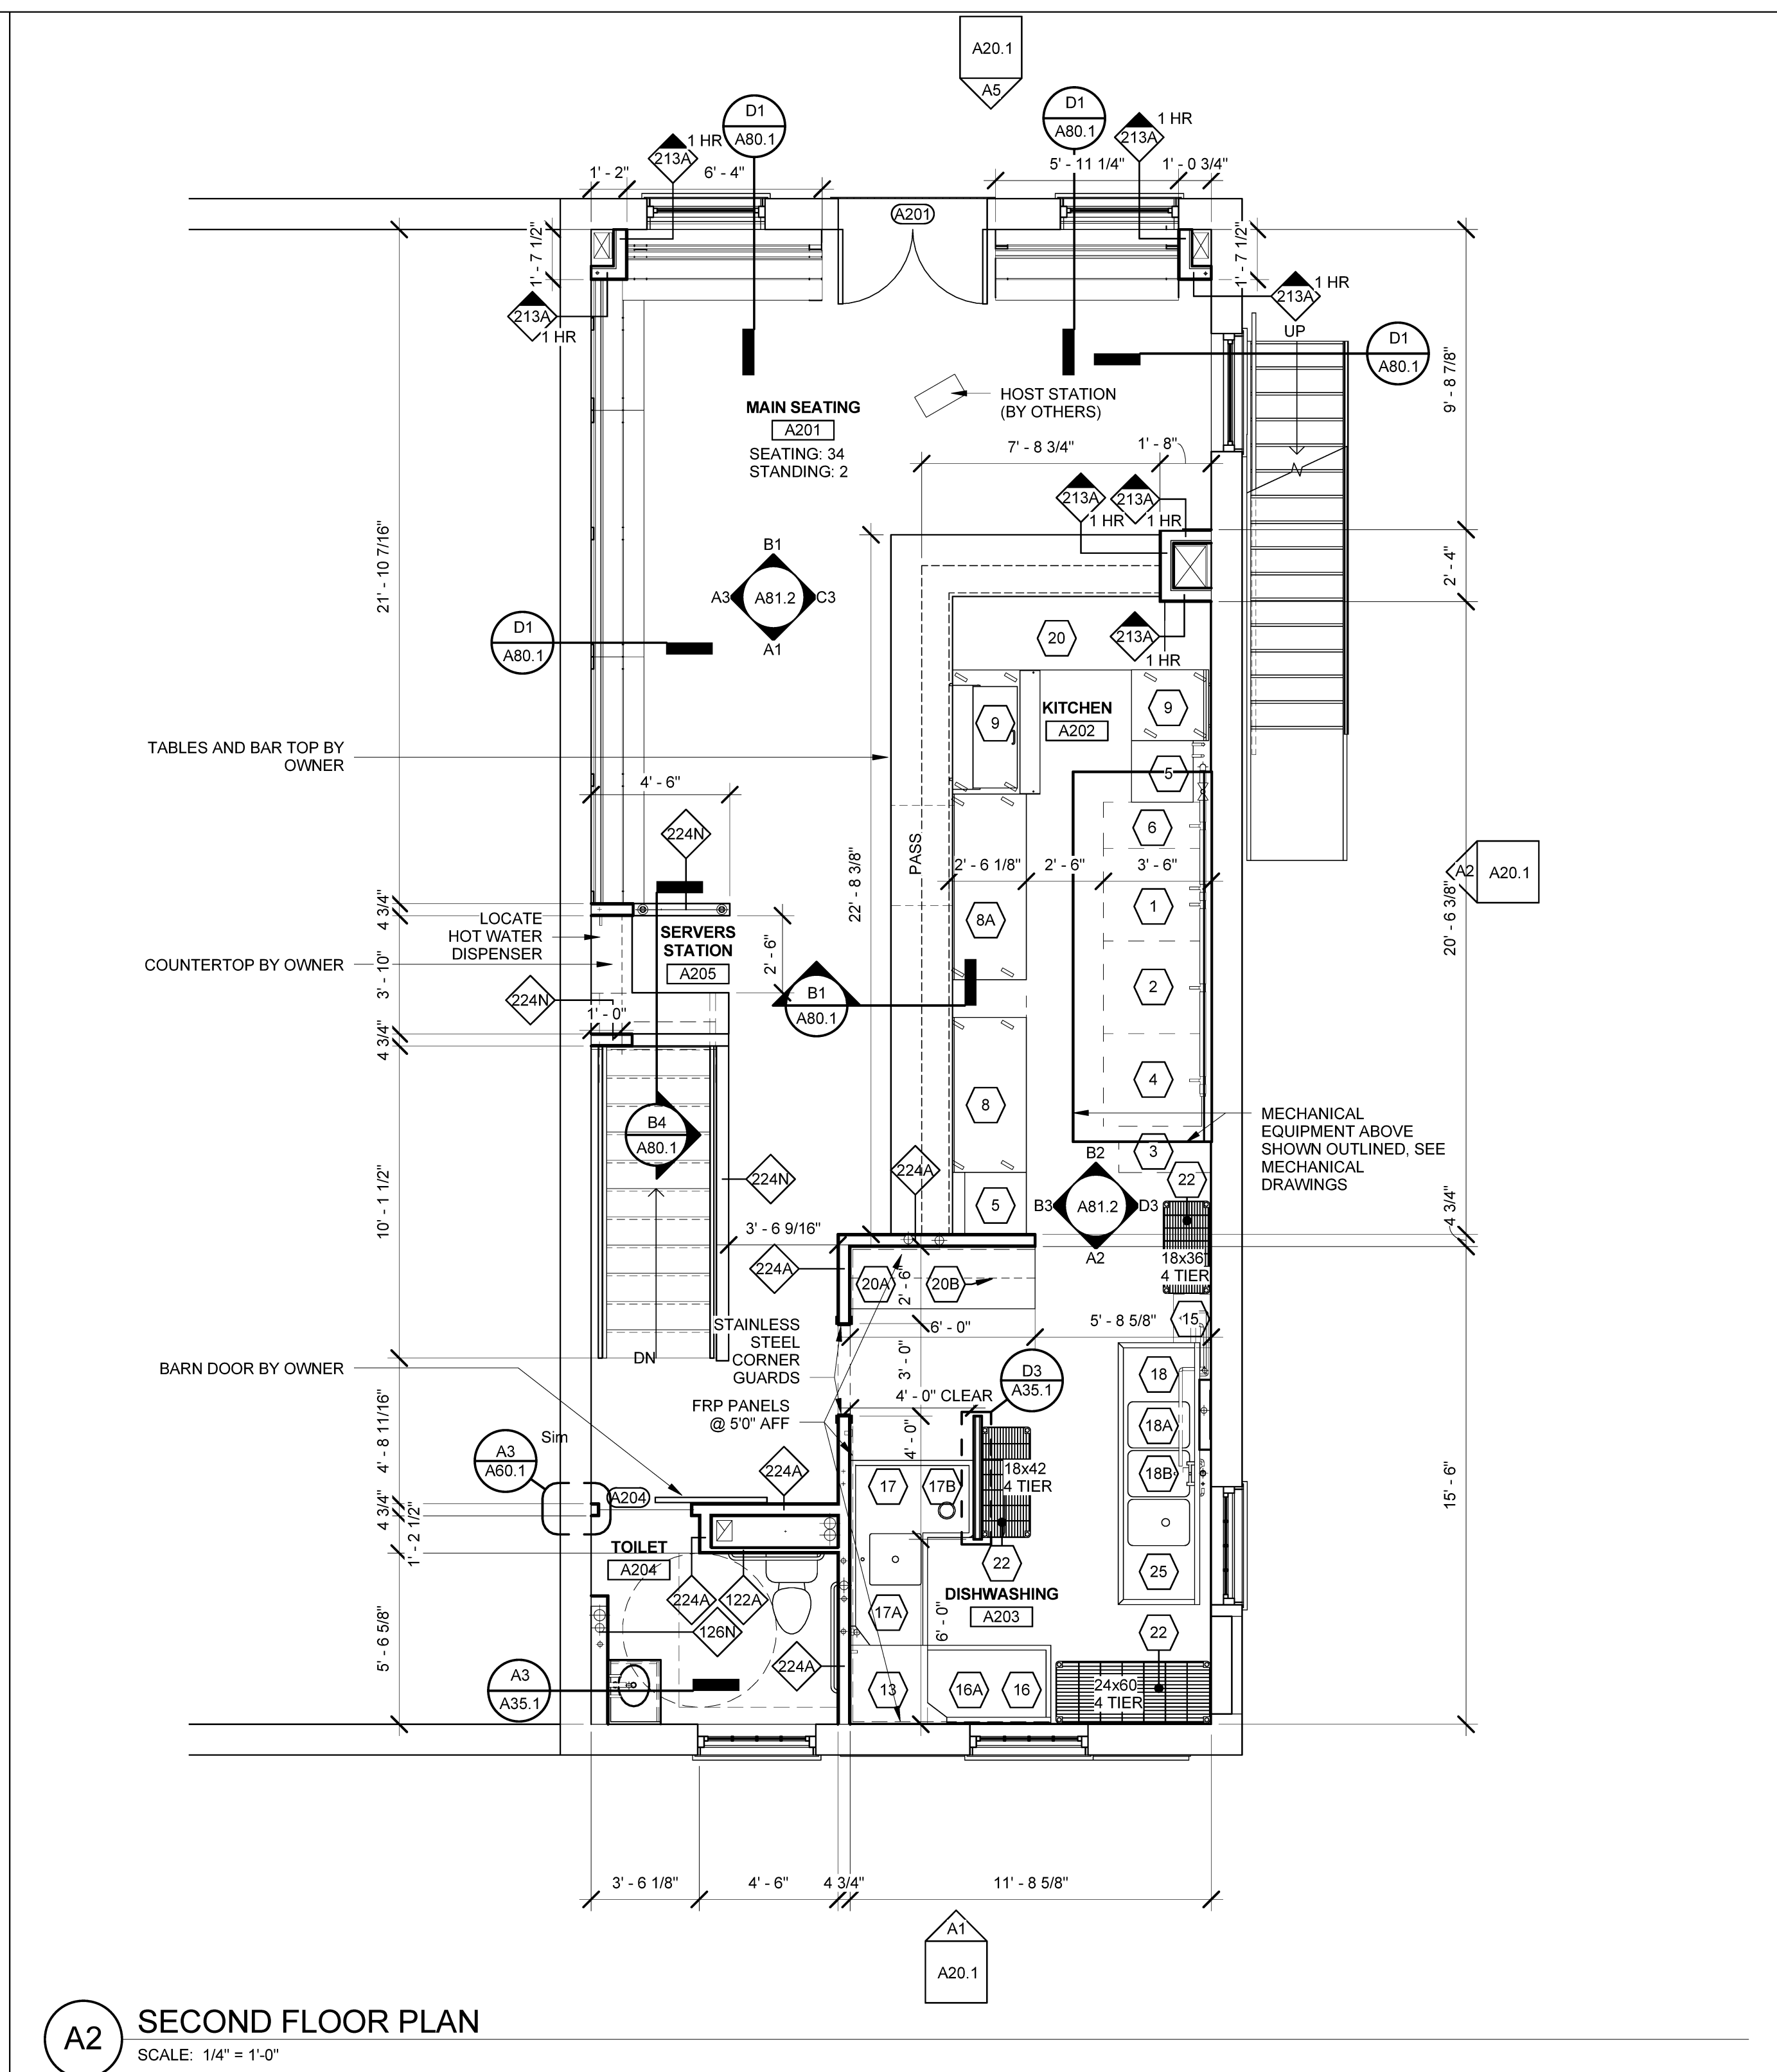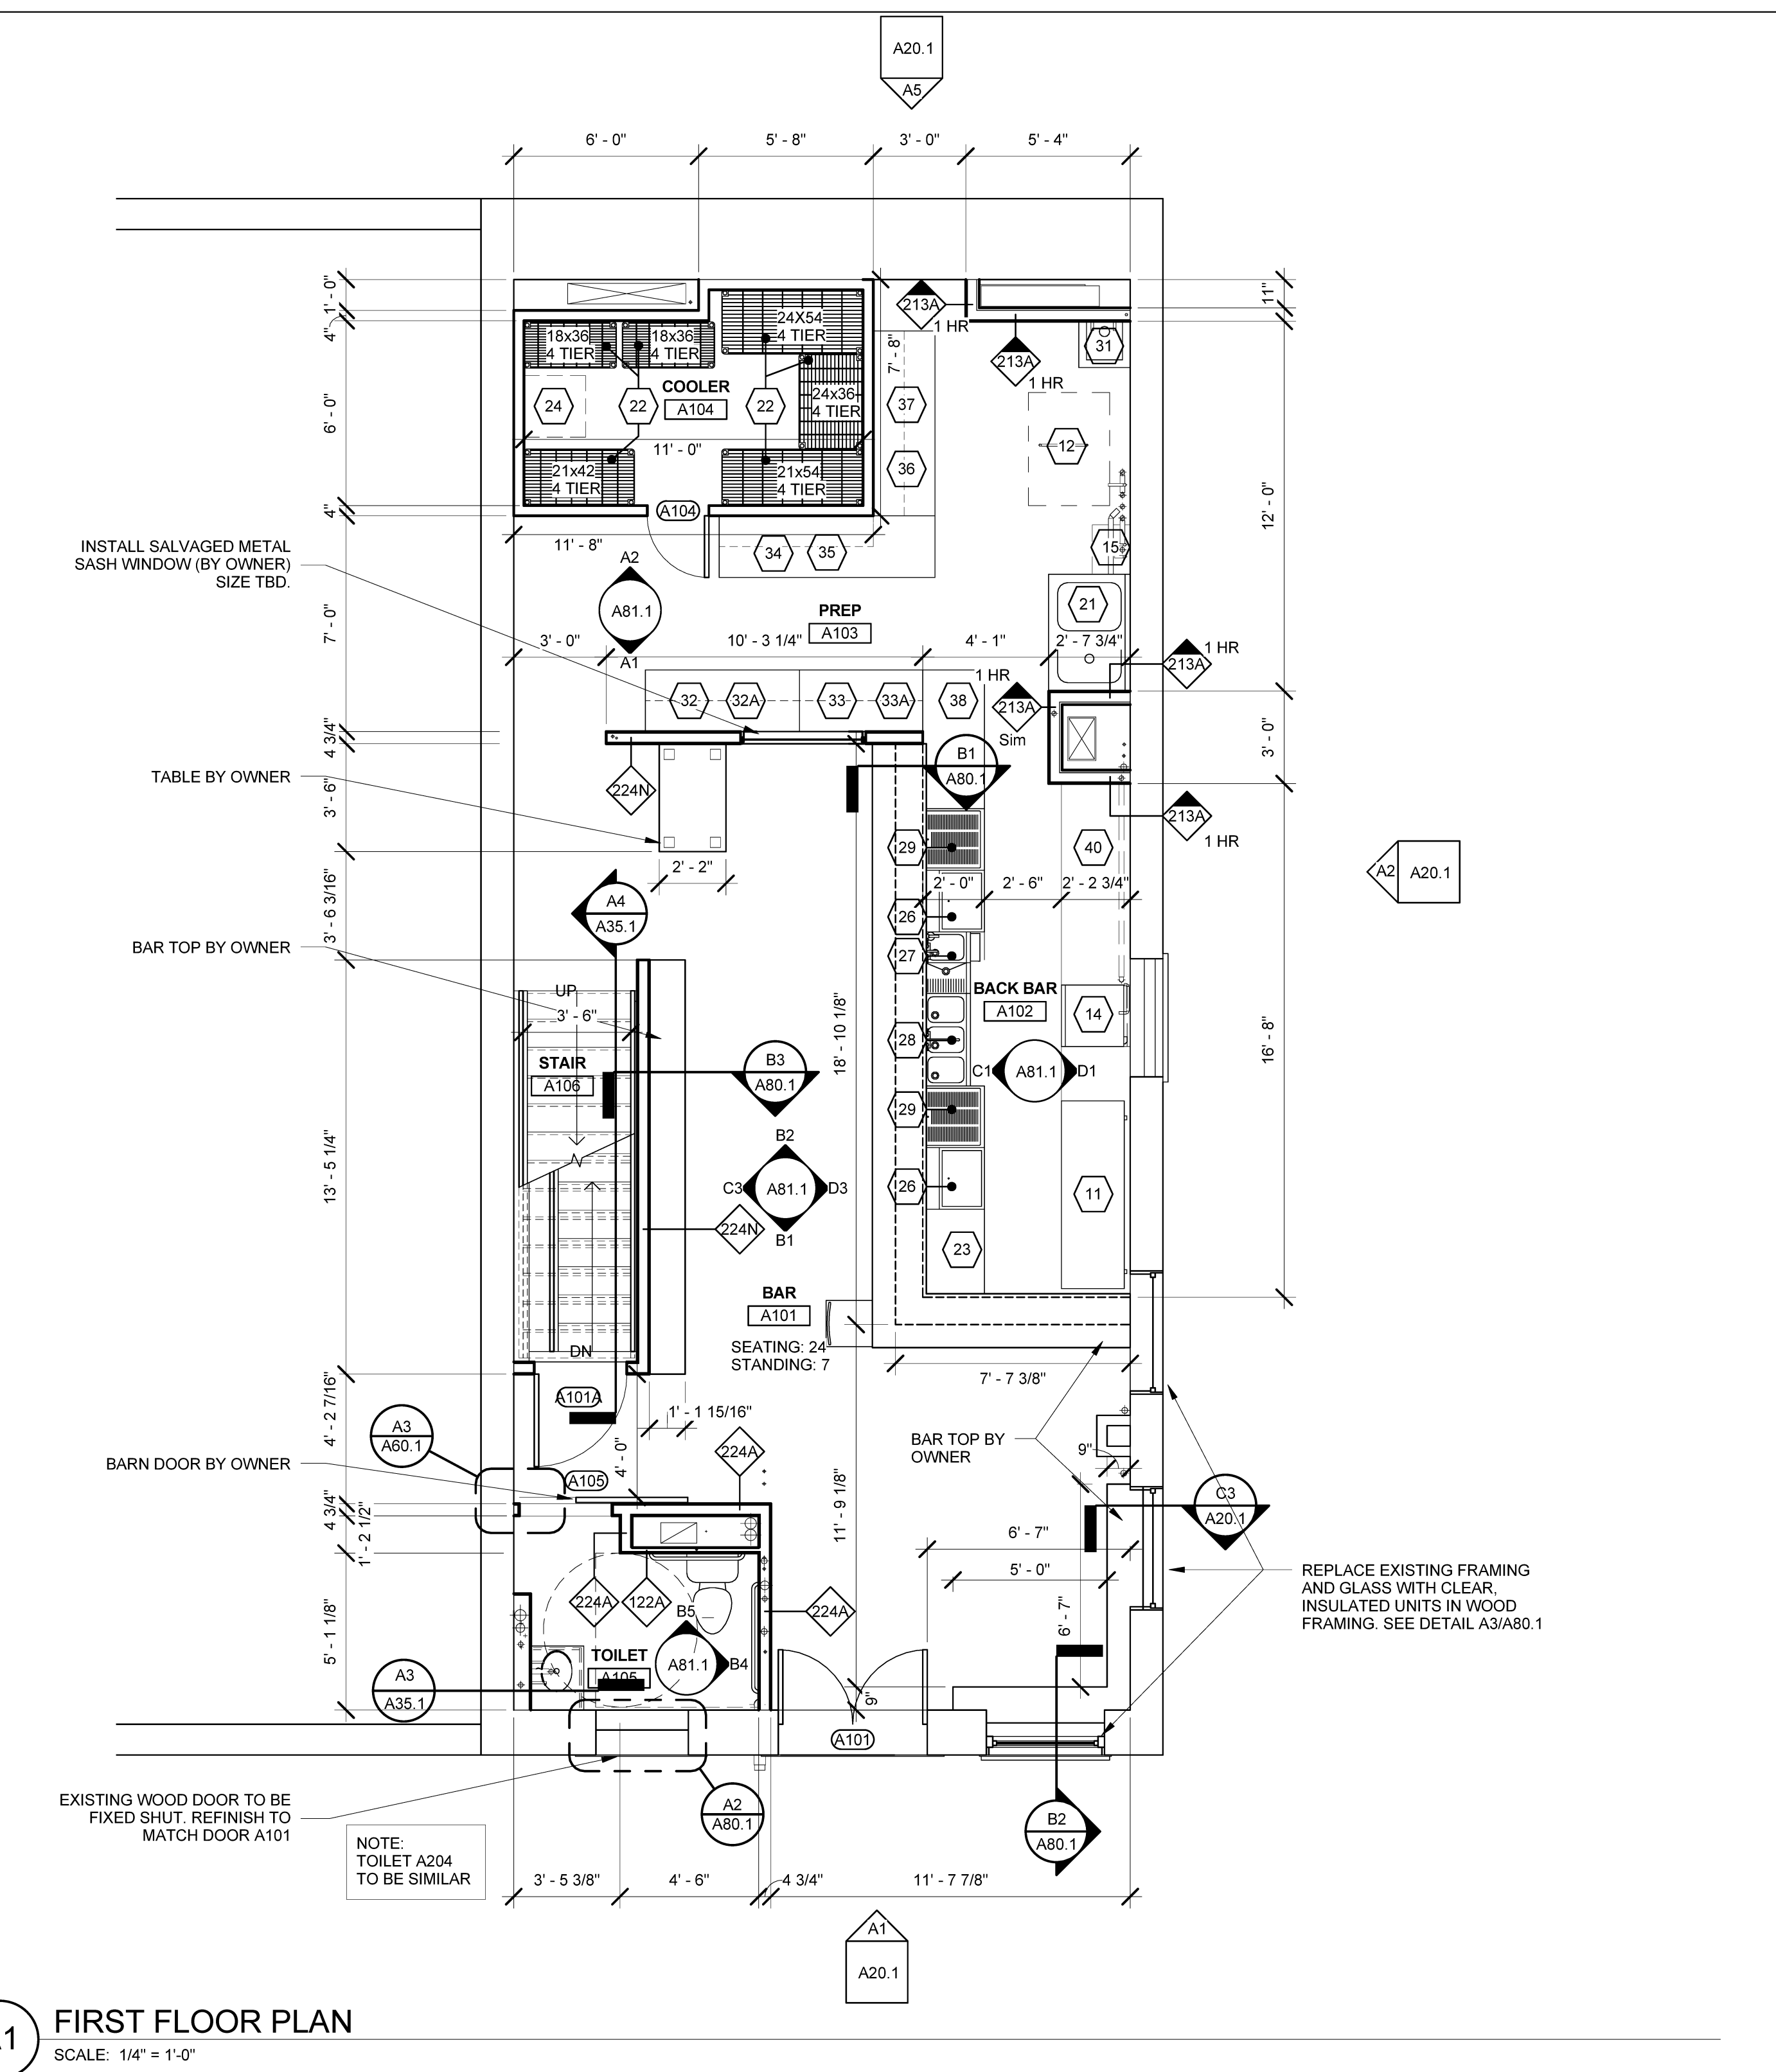

A1 FIRST FLOOR PLAN
SCALE: 1/4" = 1'-0"

A2 SECOND FLOOR PLAN
SCALE: 1/4" = 1'-0"