

HARRIMAN

 
AUBURN PORTLAND MANCHESTER

GOULD RESAURANT

414 FORE STREET
PORTLAND, ME 04101


Harriman Project No. 12752

Key Plan Proj North



Issues and Revisions

Mark	Date	Description
	09-23-13	RE-ISSUED FOR CONSTRUCTION

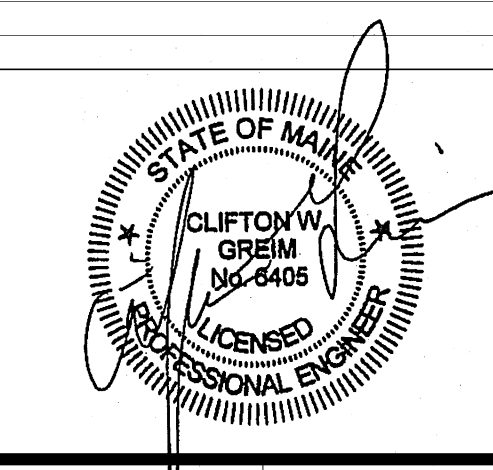


Drawing Scales	
1/4" = 1'-0"	


PA / PE: CG	© 2013 Harriman Associates
Drawn By: ROM	

FIRE PROTECTION PLANS


F10.2

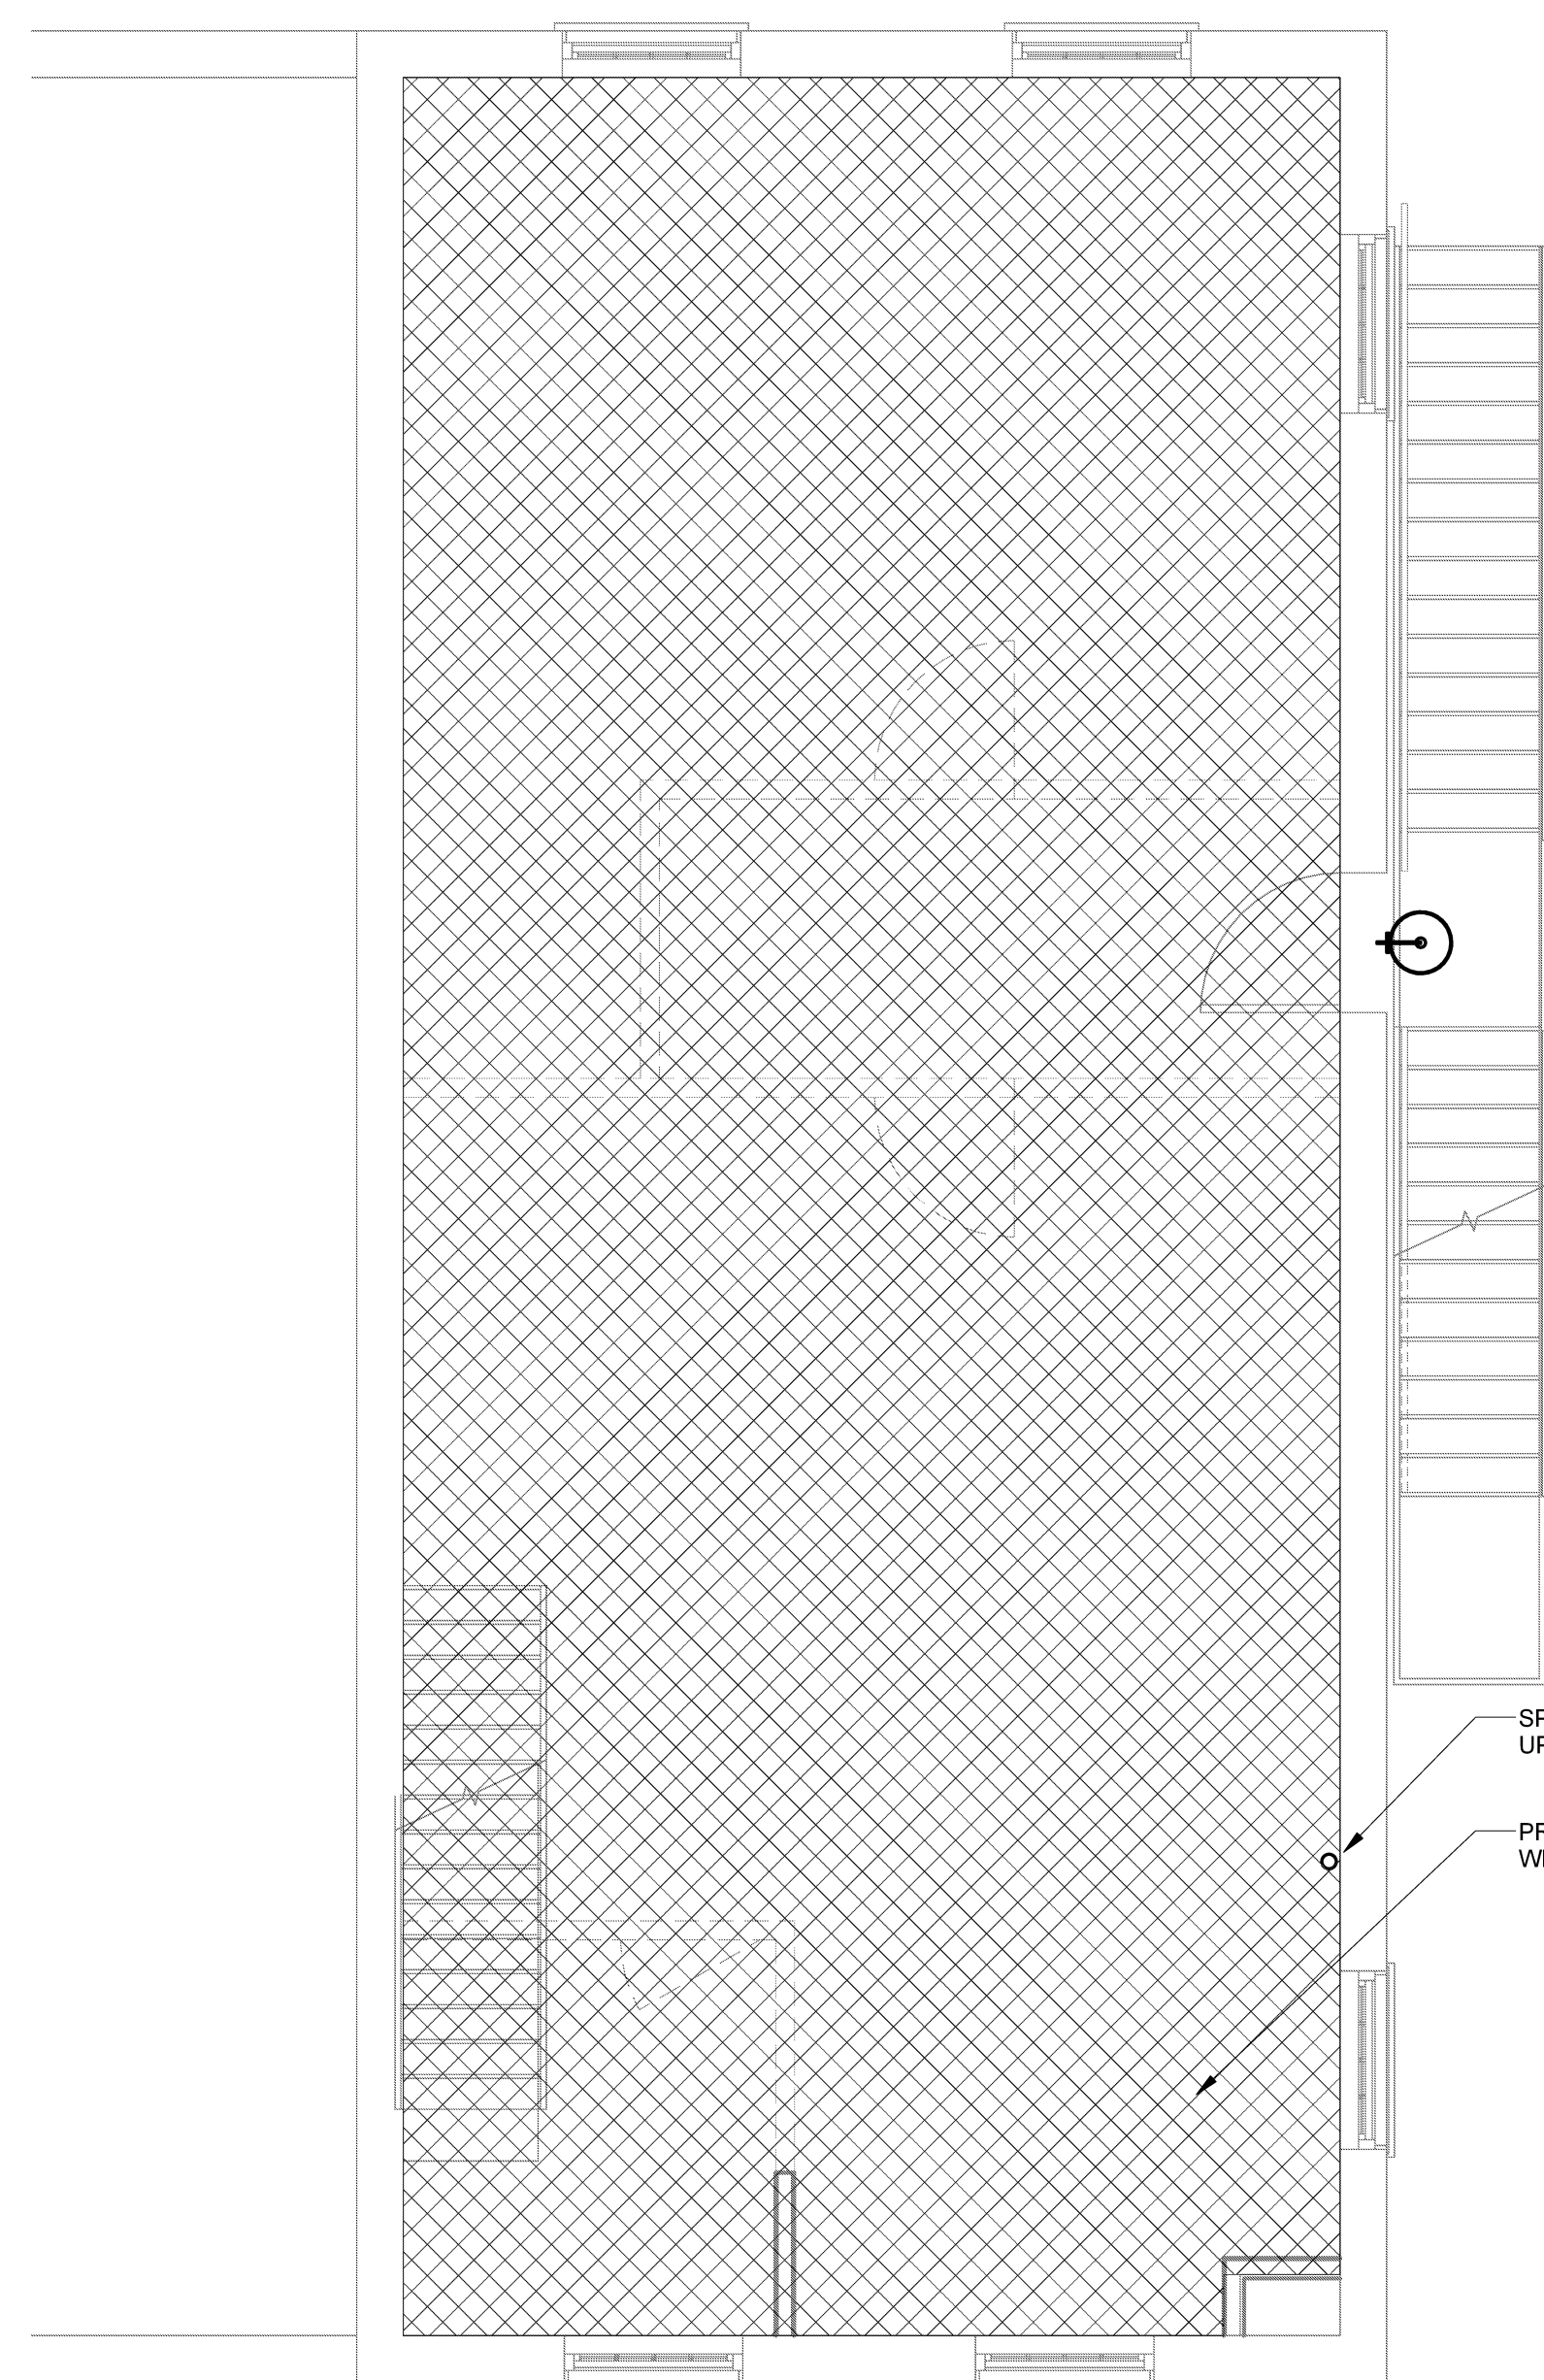

1 THIRD FLOOR FIRE PROTECTION
SCALE: 1/4" = 1'-0"

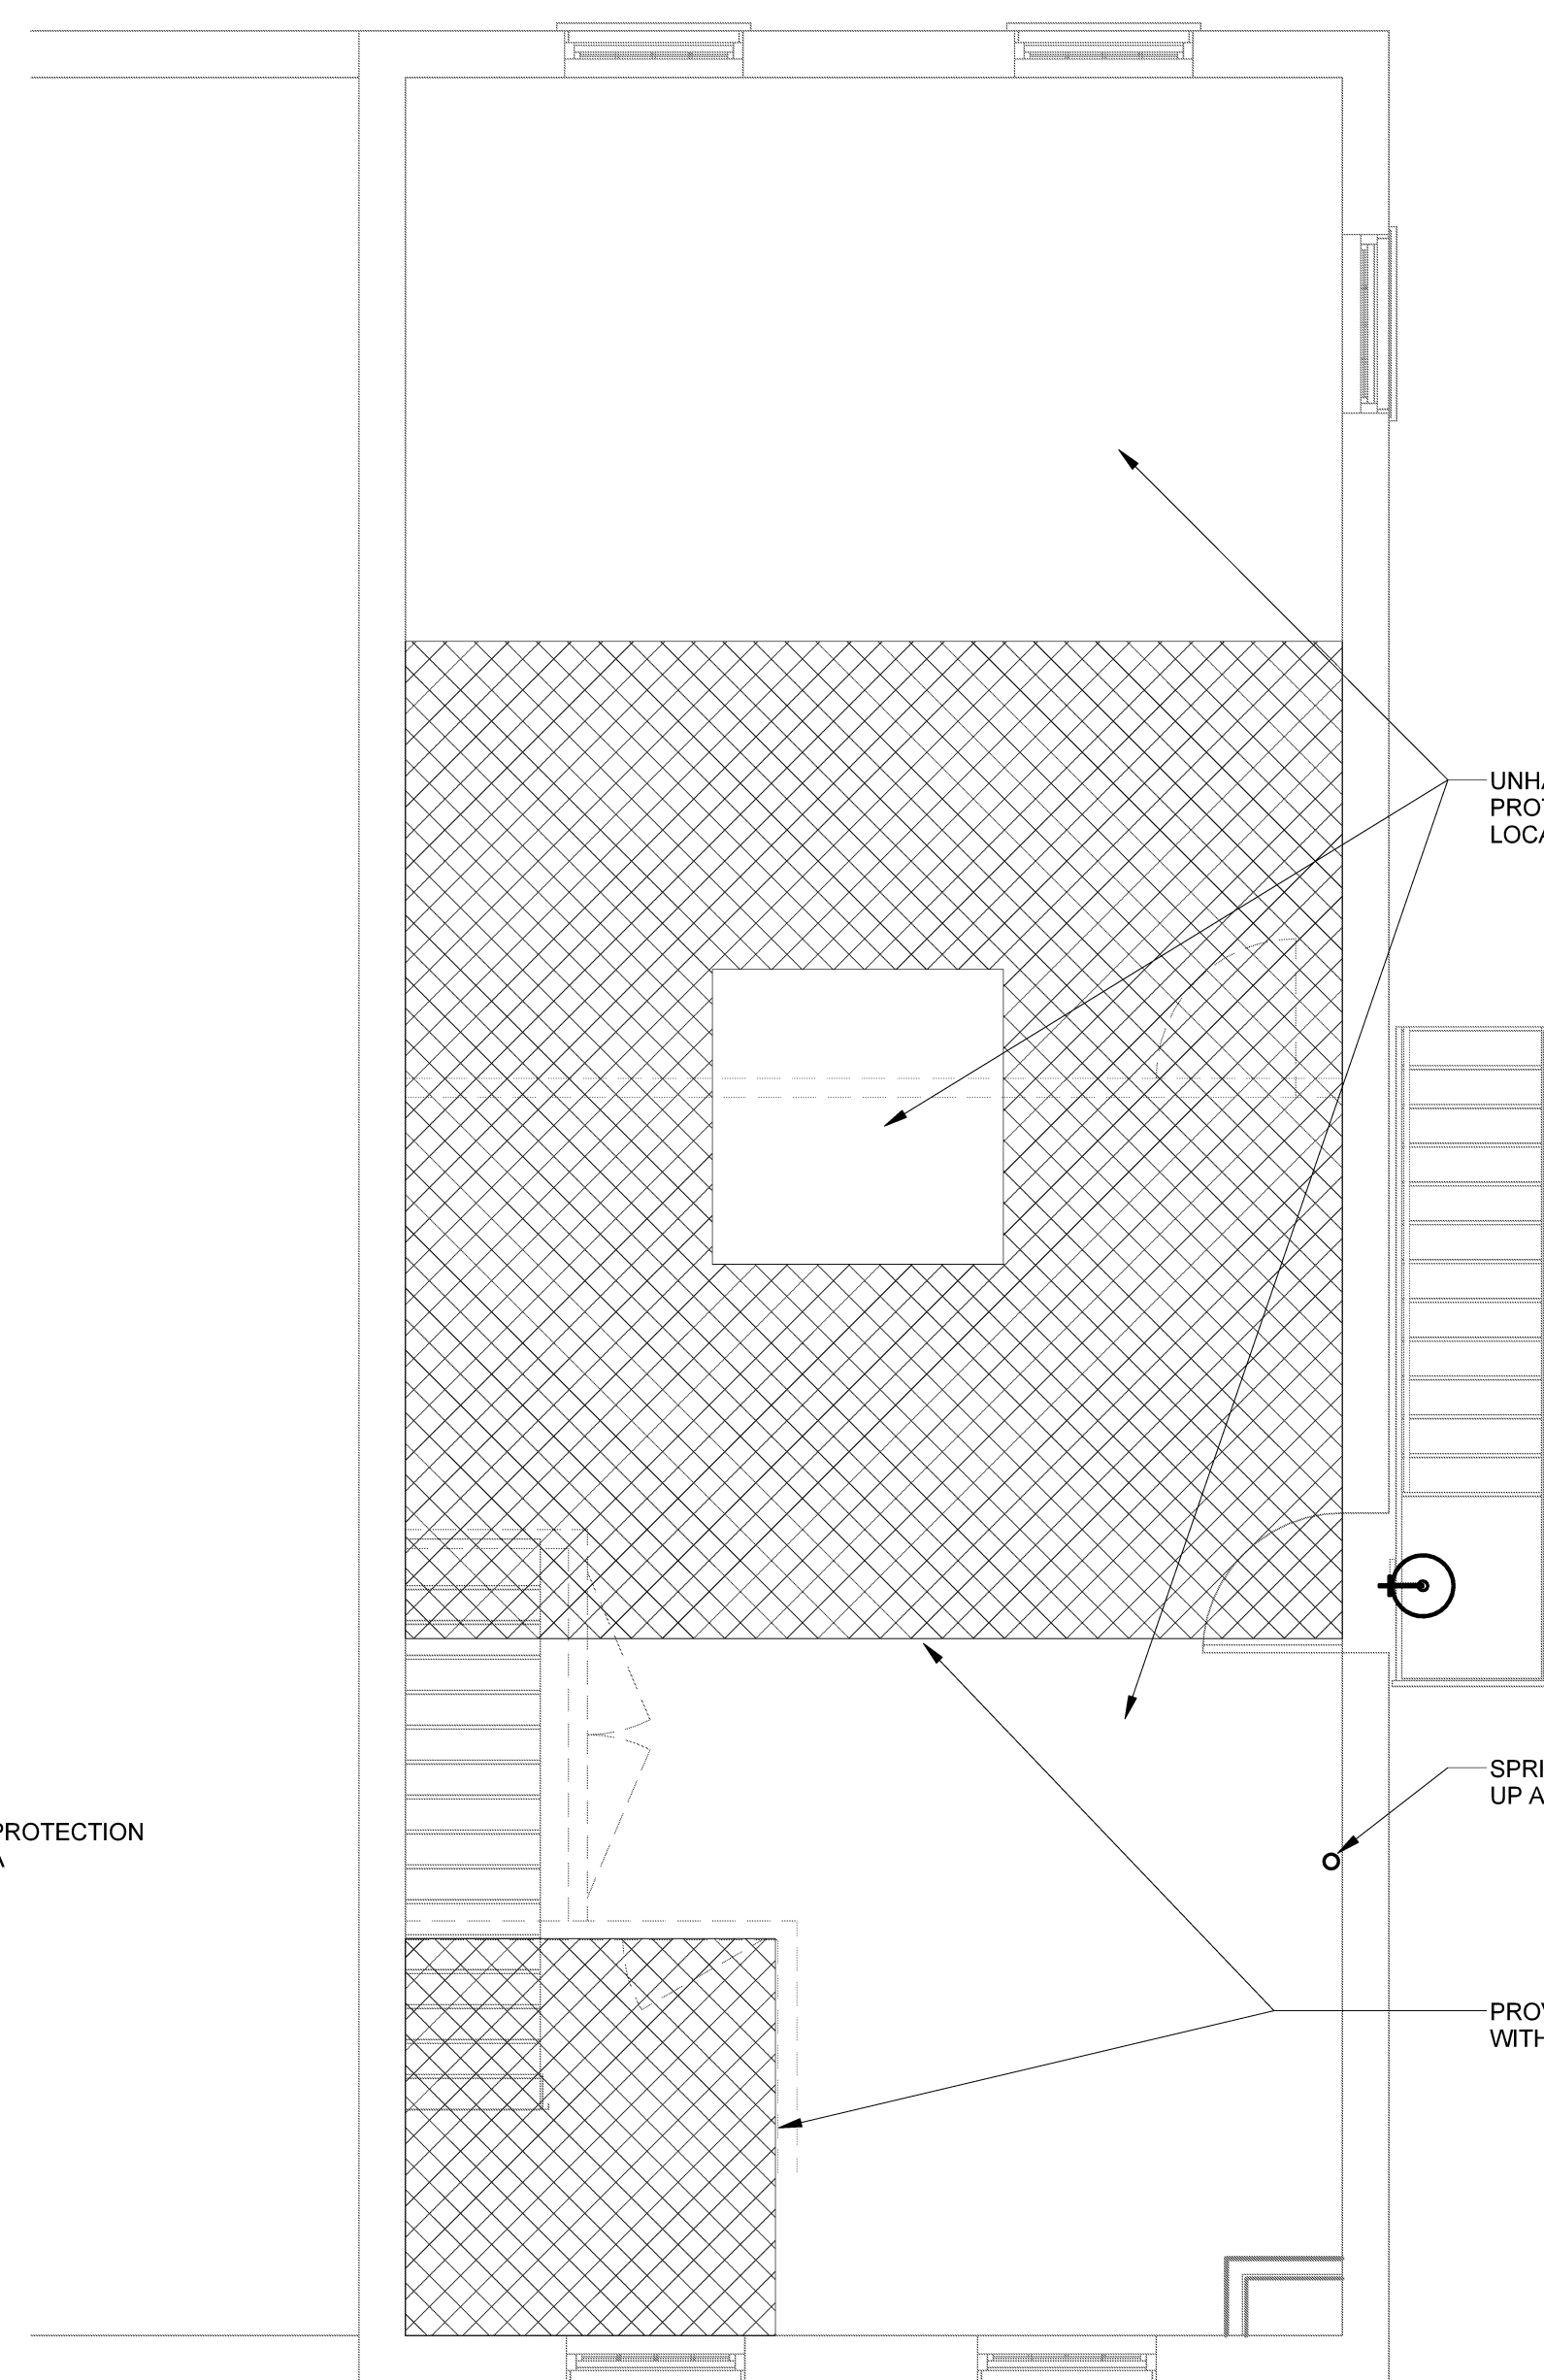

2 FOURTH FLOOR FIRE PROTECTION
SCALE: 1/4" = 1'-0"

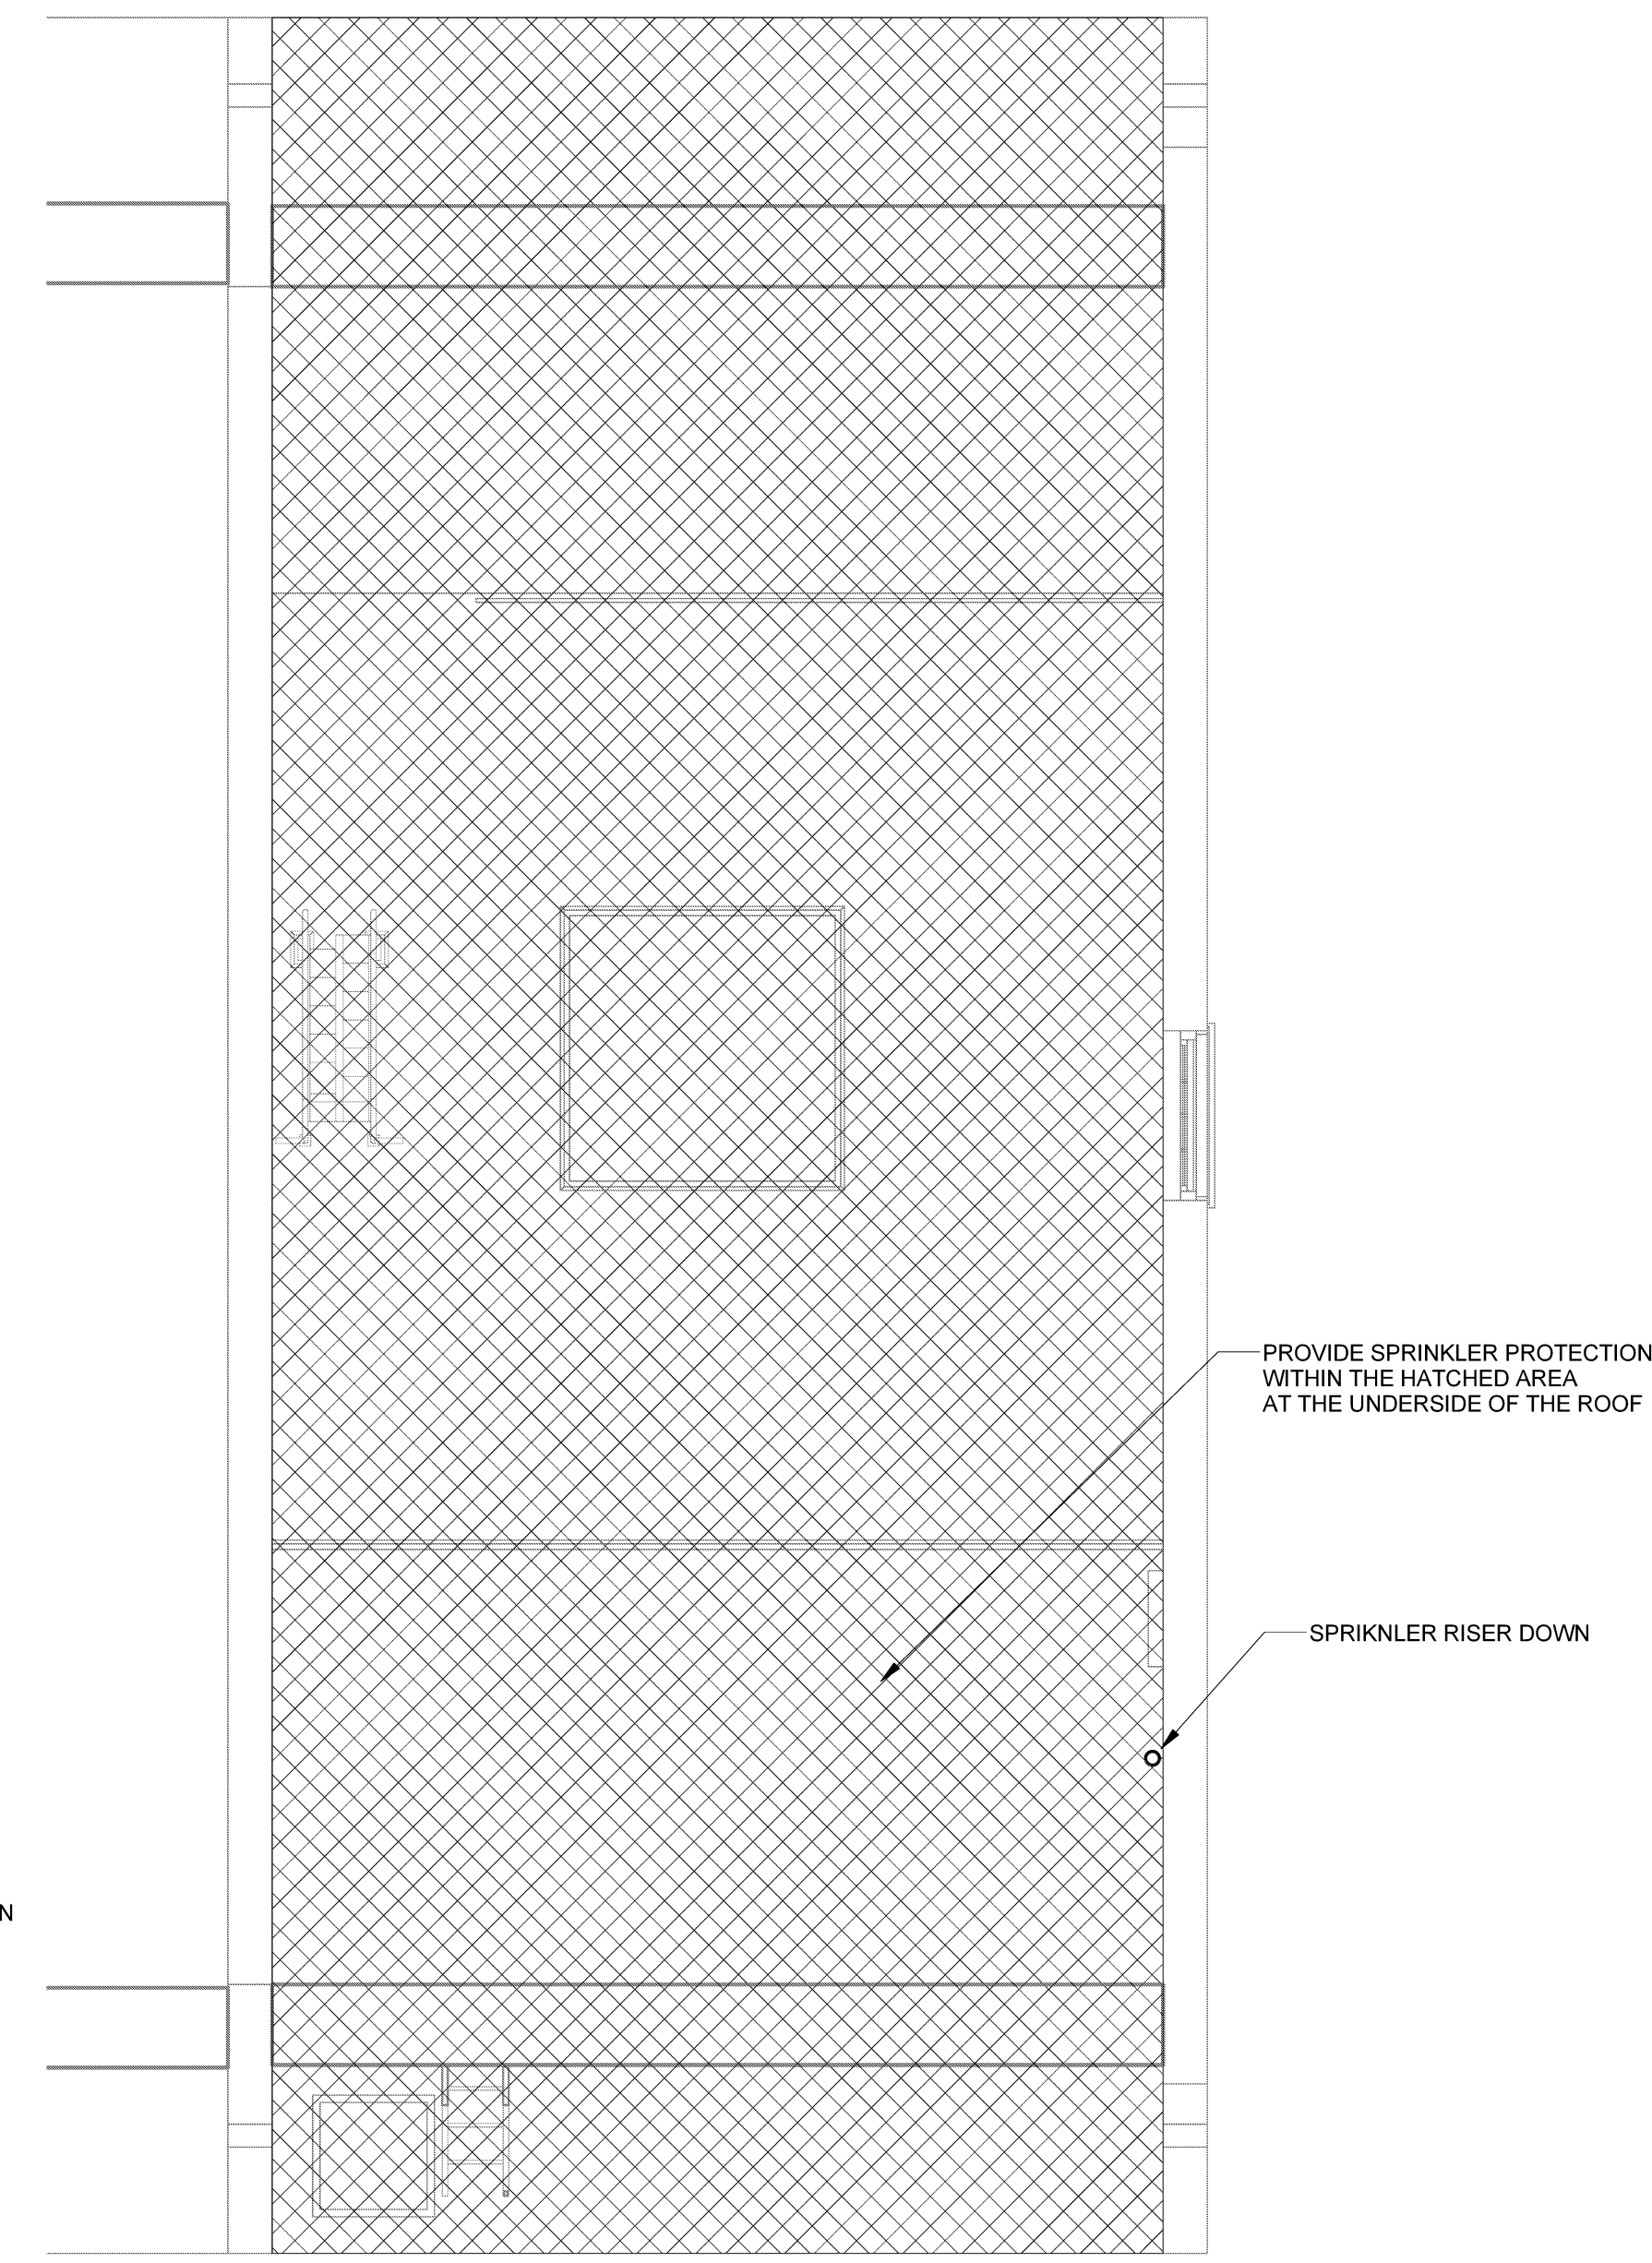

3 FIFTH FLOOR FIRE PROTECTION
SCALE: 1/4" = 1'-0"