

REVISION	DESCRIPTION	DATE
0	ISSUED FOR REVIEW & APPROVAL	11/1/2013

RESERVED FOR CITY STAMP

CUNNINGHAM

Security Systems


10 Princes Point Road, Yarmouth, Maine 04096
Office: 207.846.3350 • Fax: 207.846.6080

**CENTRAL PROVISIONS
414 FORE STREET
PORTLAND, MAINE 04101
SECOND FLOOR FIRE ALARM PLAN**

DRAWN	JPB UNICAD JOB #13638
CHECKED	WAYNE B. HAWES NGEET IV 90496
DATE	10/31/2013
REVISION	0
SCALE	1/4"=1'-0"

FA-4

UNICAD Inc.
Fire Alarm Design & Drafting Services
www.unicad.net
578 W. 40th St.
Portland, ME 04102
Office: 603.865.0410

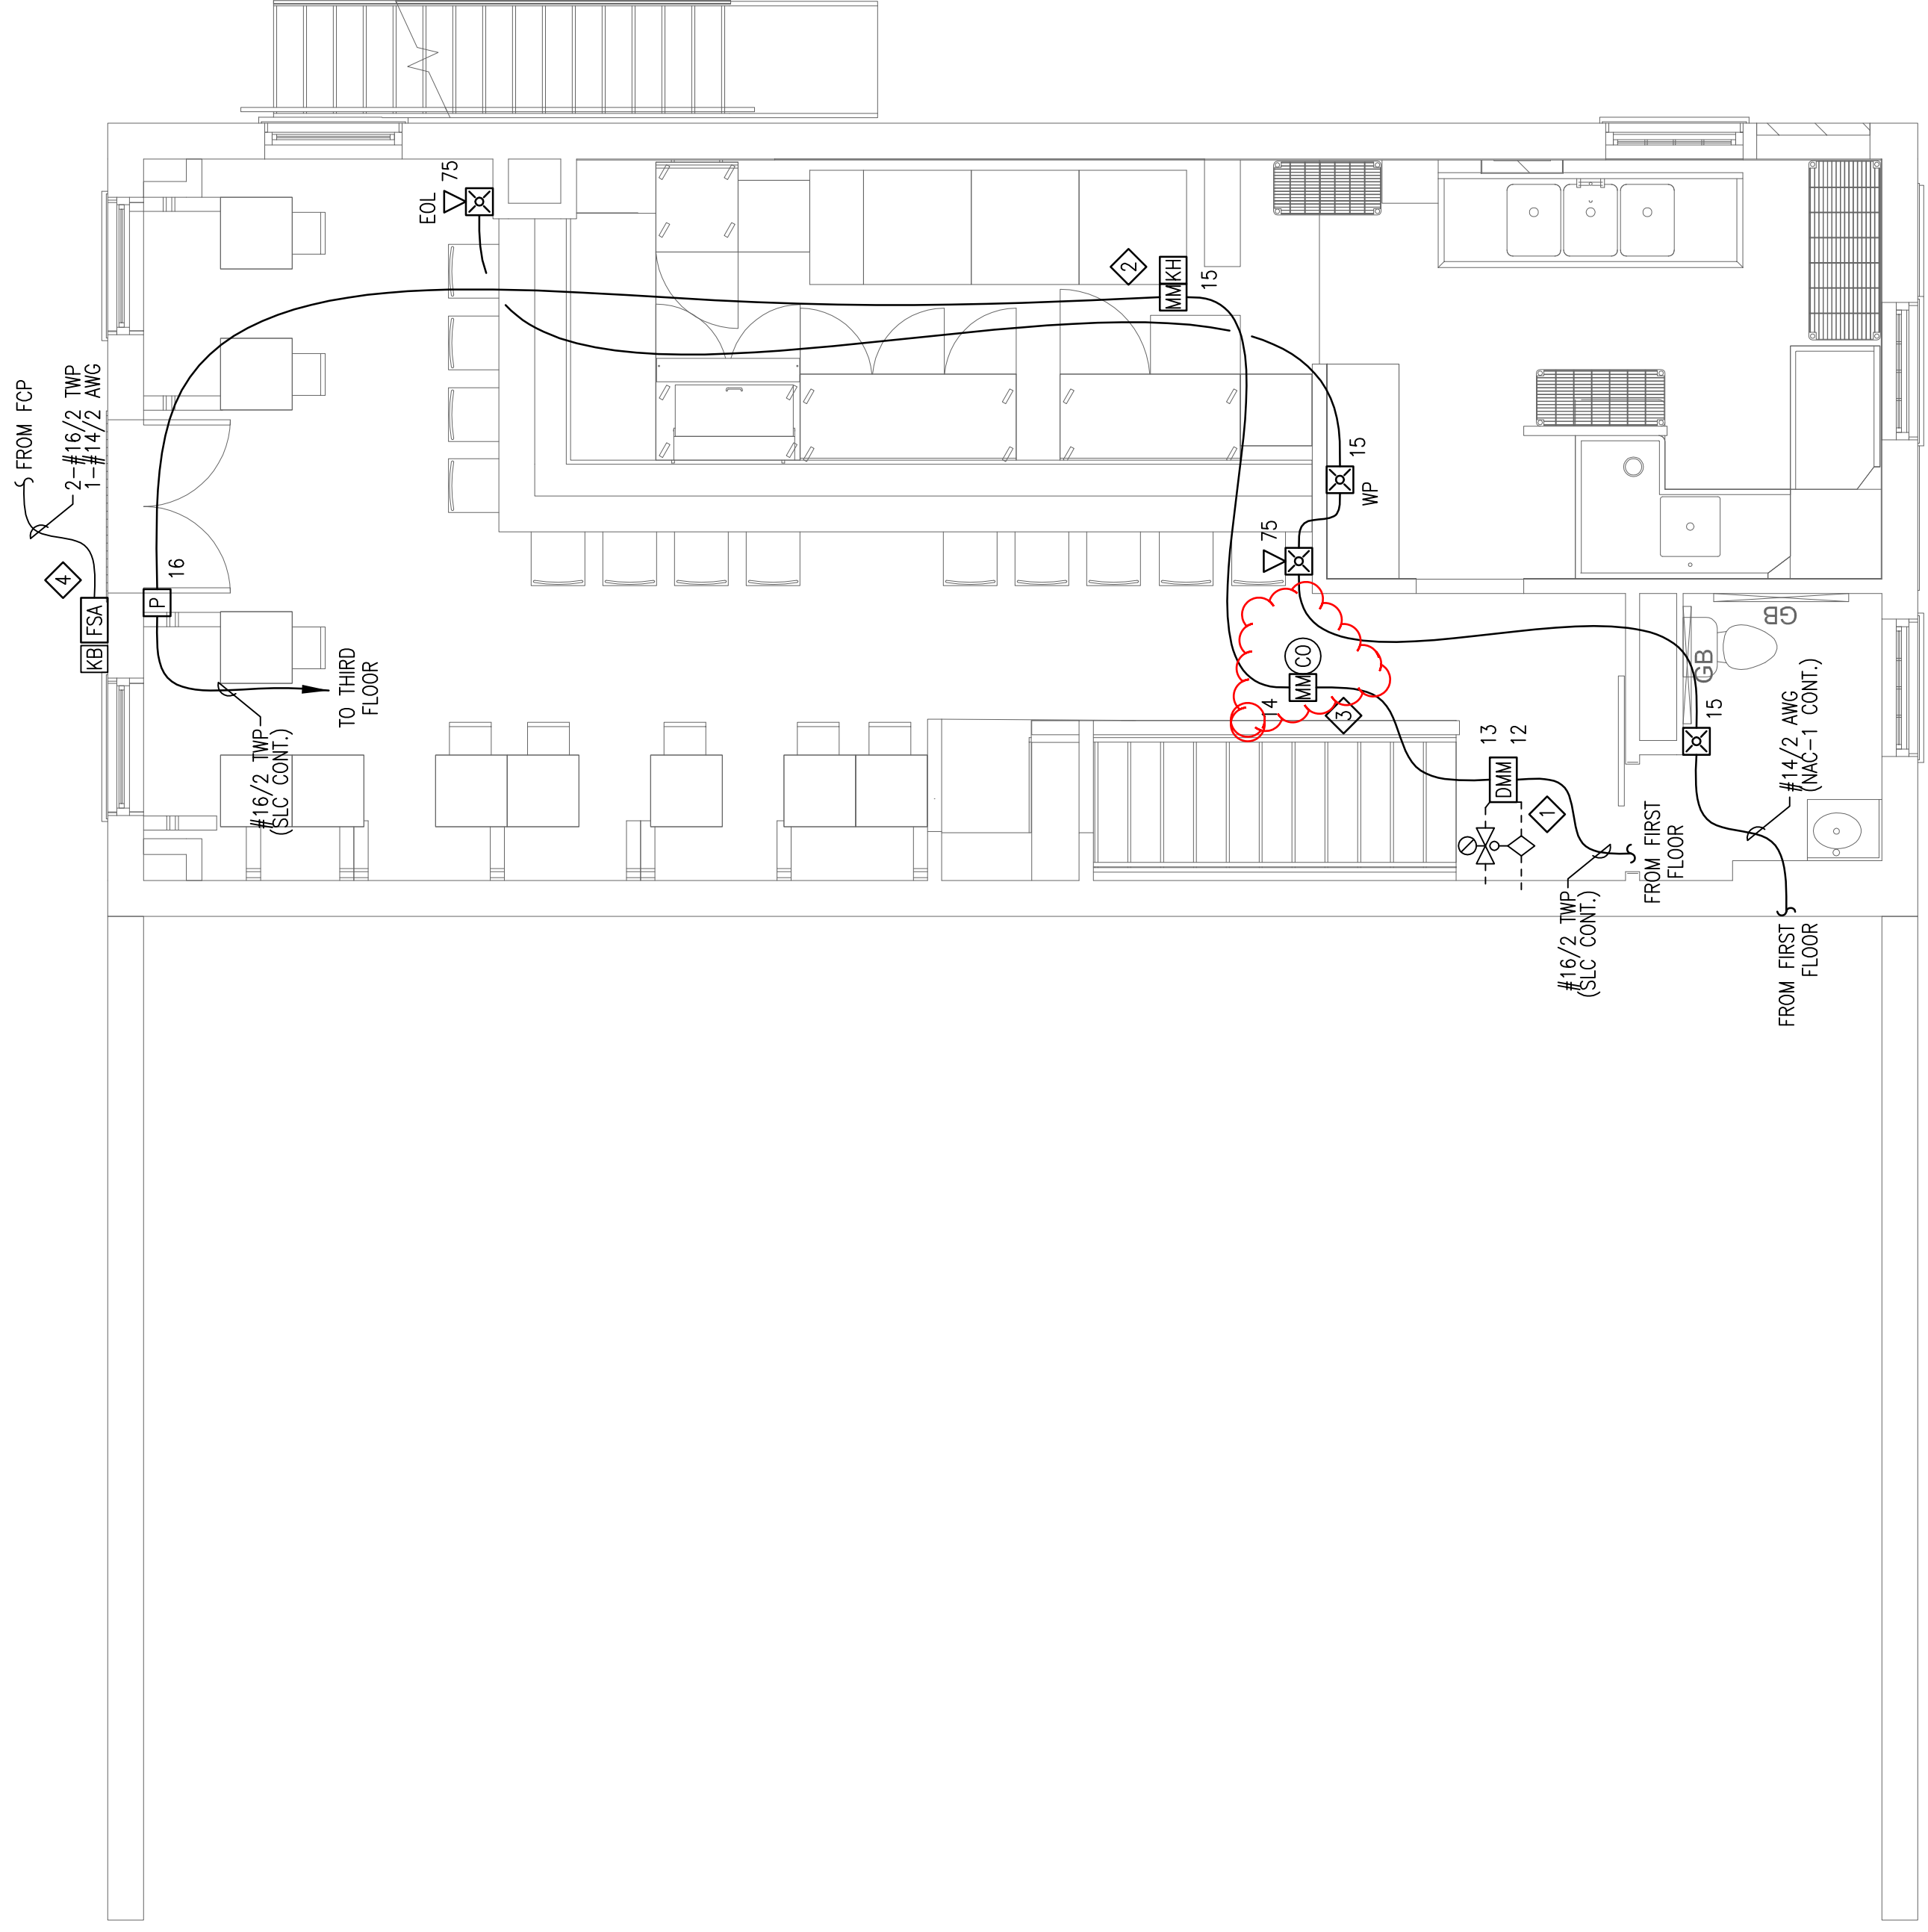

SECOND FLOOR FIRE ALARM PLAN
SCALE: 1/4"=1'-0"

SHEET NOTES:

- ① ADDRESSABLE DUAL MONITOR MODULE(S) PROVIDED TO MONITOR ALL WATER FLOW, PRESSURE SWITCHES, TAMPER SWITCHES AND POST INDICATING VALVES ASSOCIATED WITH THE FIRE SPRINKLER SYSTEM. INSTALLING CONTRACTOR SHALL FIELD VERIFY EXACT MOUNTING, CIRCUITING AND PROGRAMMING REQUIREMENTS. FIELD VERIFY EXACT QUANTITY AND LOCATION(S).
- ② ADDRESSABLE MONITOR MODULE PROVIDED TO MONITOR THE KITCHEN HOOD FIRE SUPPRESSION SYSTEM. INSTALLING CONTRACTOR SHALL FIELD VERIFY EXACT MOUNTING, CIRCUITING AND PROGRAMMING REQUIREMENTS. FIELD VERIFY EXACT QUANTITY AND LOCATION(S).
- ③ ADDRESSABLE MONITOR MODULE PROVIDED TO MONITOR CONVENTIONAL CO DETECTOR. INSTALLING CONTRACTOR SHALL FIELD VERIFY EXACT MOUNTING, CIRCUITING AND PROGRAMMING REQUIREMENTS.
- ④ PROVIDE A WEATHERPROOF ENCLOSURE FOR ANNUNCIATOR (FSA).