

REVISION	DESCRIPTION	DATE
0	ISSUED FOR REVIEW & APPROVAL	11/1/2013

RESERVED FOR CITY STAMP

**CUNNINGHAM**  
Security Systems

10 Princes Point Road, Yarmouth, Maine 04096  
Office: 207.846.3350 • Fax: 207.846.6080


**CENTRAL PROVISIONS**  
414 FORE STREET  
PORTLAND, MAINE 04101  
THRID FLOOR FIRE ALARM PLAN

DRAWN	JPB UNICAD JOB #13638
CHECKED	WAYNE B. HAWES NGEET # 90496
DATE	10/31/2013
REVISION	0
SCALE	1/4"=1'-0"

**FA-5**

**UNICAD** Inc.  
Fire Alarm Design & Drafting Services

100 Main Street  
Portland, ME 04101  
578-1400 (Tel)  
578-1400 (Fax)  
www.unicad.net

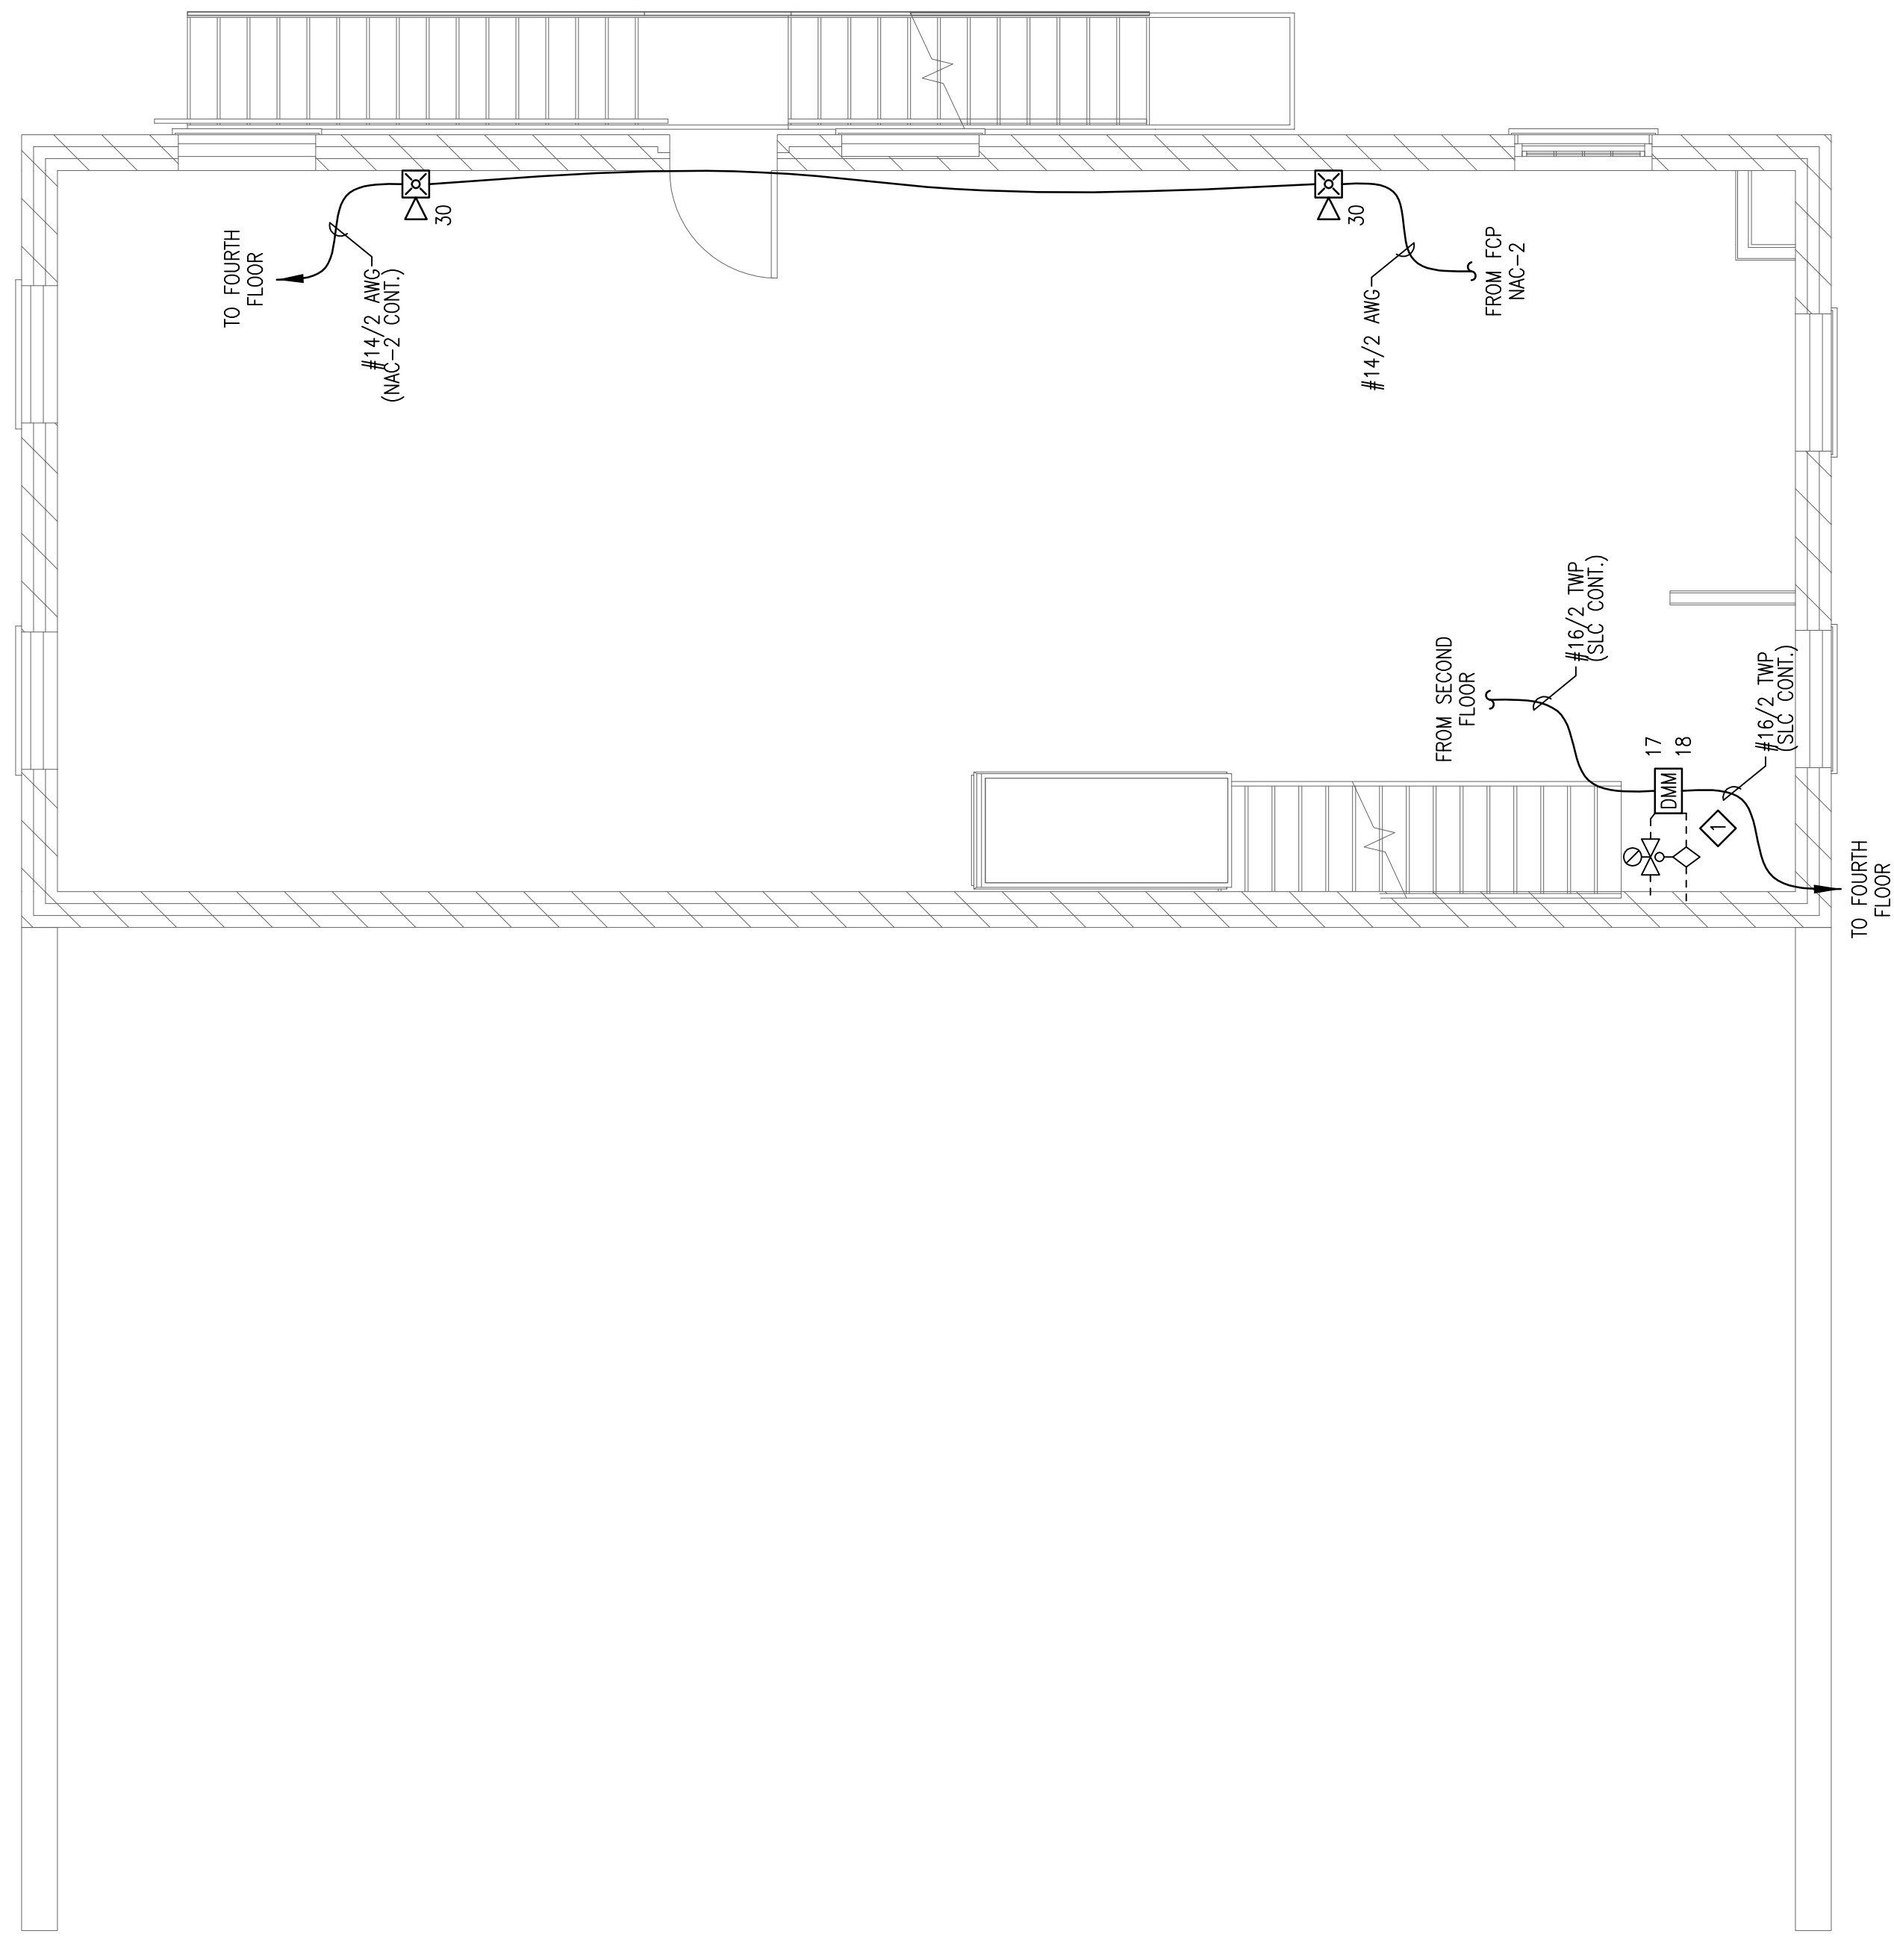

**THIRD FLOOR FIRE ALARM PLAN**  
SCALE: 1/4"=1'-0"

**SHEET NOTES:**

- ◇ ADDRESSABLE DUAL MONITOR MODULE(S) PROVIDED TO MONITOR ALL WATER FLOW, PRESSURE SWITCHES, TAMPER SWITCHES AND POST INDICATING VALVES ASSOCIATED WITH THE FIRE SPRINKLER SYSTEM. INSTALLING CONTRACTOR SHALL FIELD VERIFY EXACT MOUNTING, CIRCUITING AND PROGRAMMING REQUIREMENTS. FIELD VERIFY EXACT QUANTITY AND LOCATION(S).