

REVISION	DESCRIPTION	DATE
0	ISSUED FOR REVIEW & APPROVAL	11/1/2013

RESERVED FOR CITY STAMP


CUNNINGHAM
Security Systems

10 Princes Point Road, Yarmouth, Maine 04096
Office: 207.846.3350 • Fax: 207.846.6080

CENTRAL PROVISIONS
414 FORE STREET
PORTLAND, MAINE 04101
FOURTH FLOOR FIRE ALARM PLAN

DRAWN	JPB	UNICAD JOB #13638
CHECKED	WAYNE B. HAWES	NCET # 90496
DATE	10/31/2013	
REVISION	0	
SCALE	1/4"=1'-0"	

FA-6

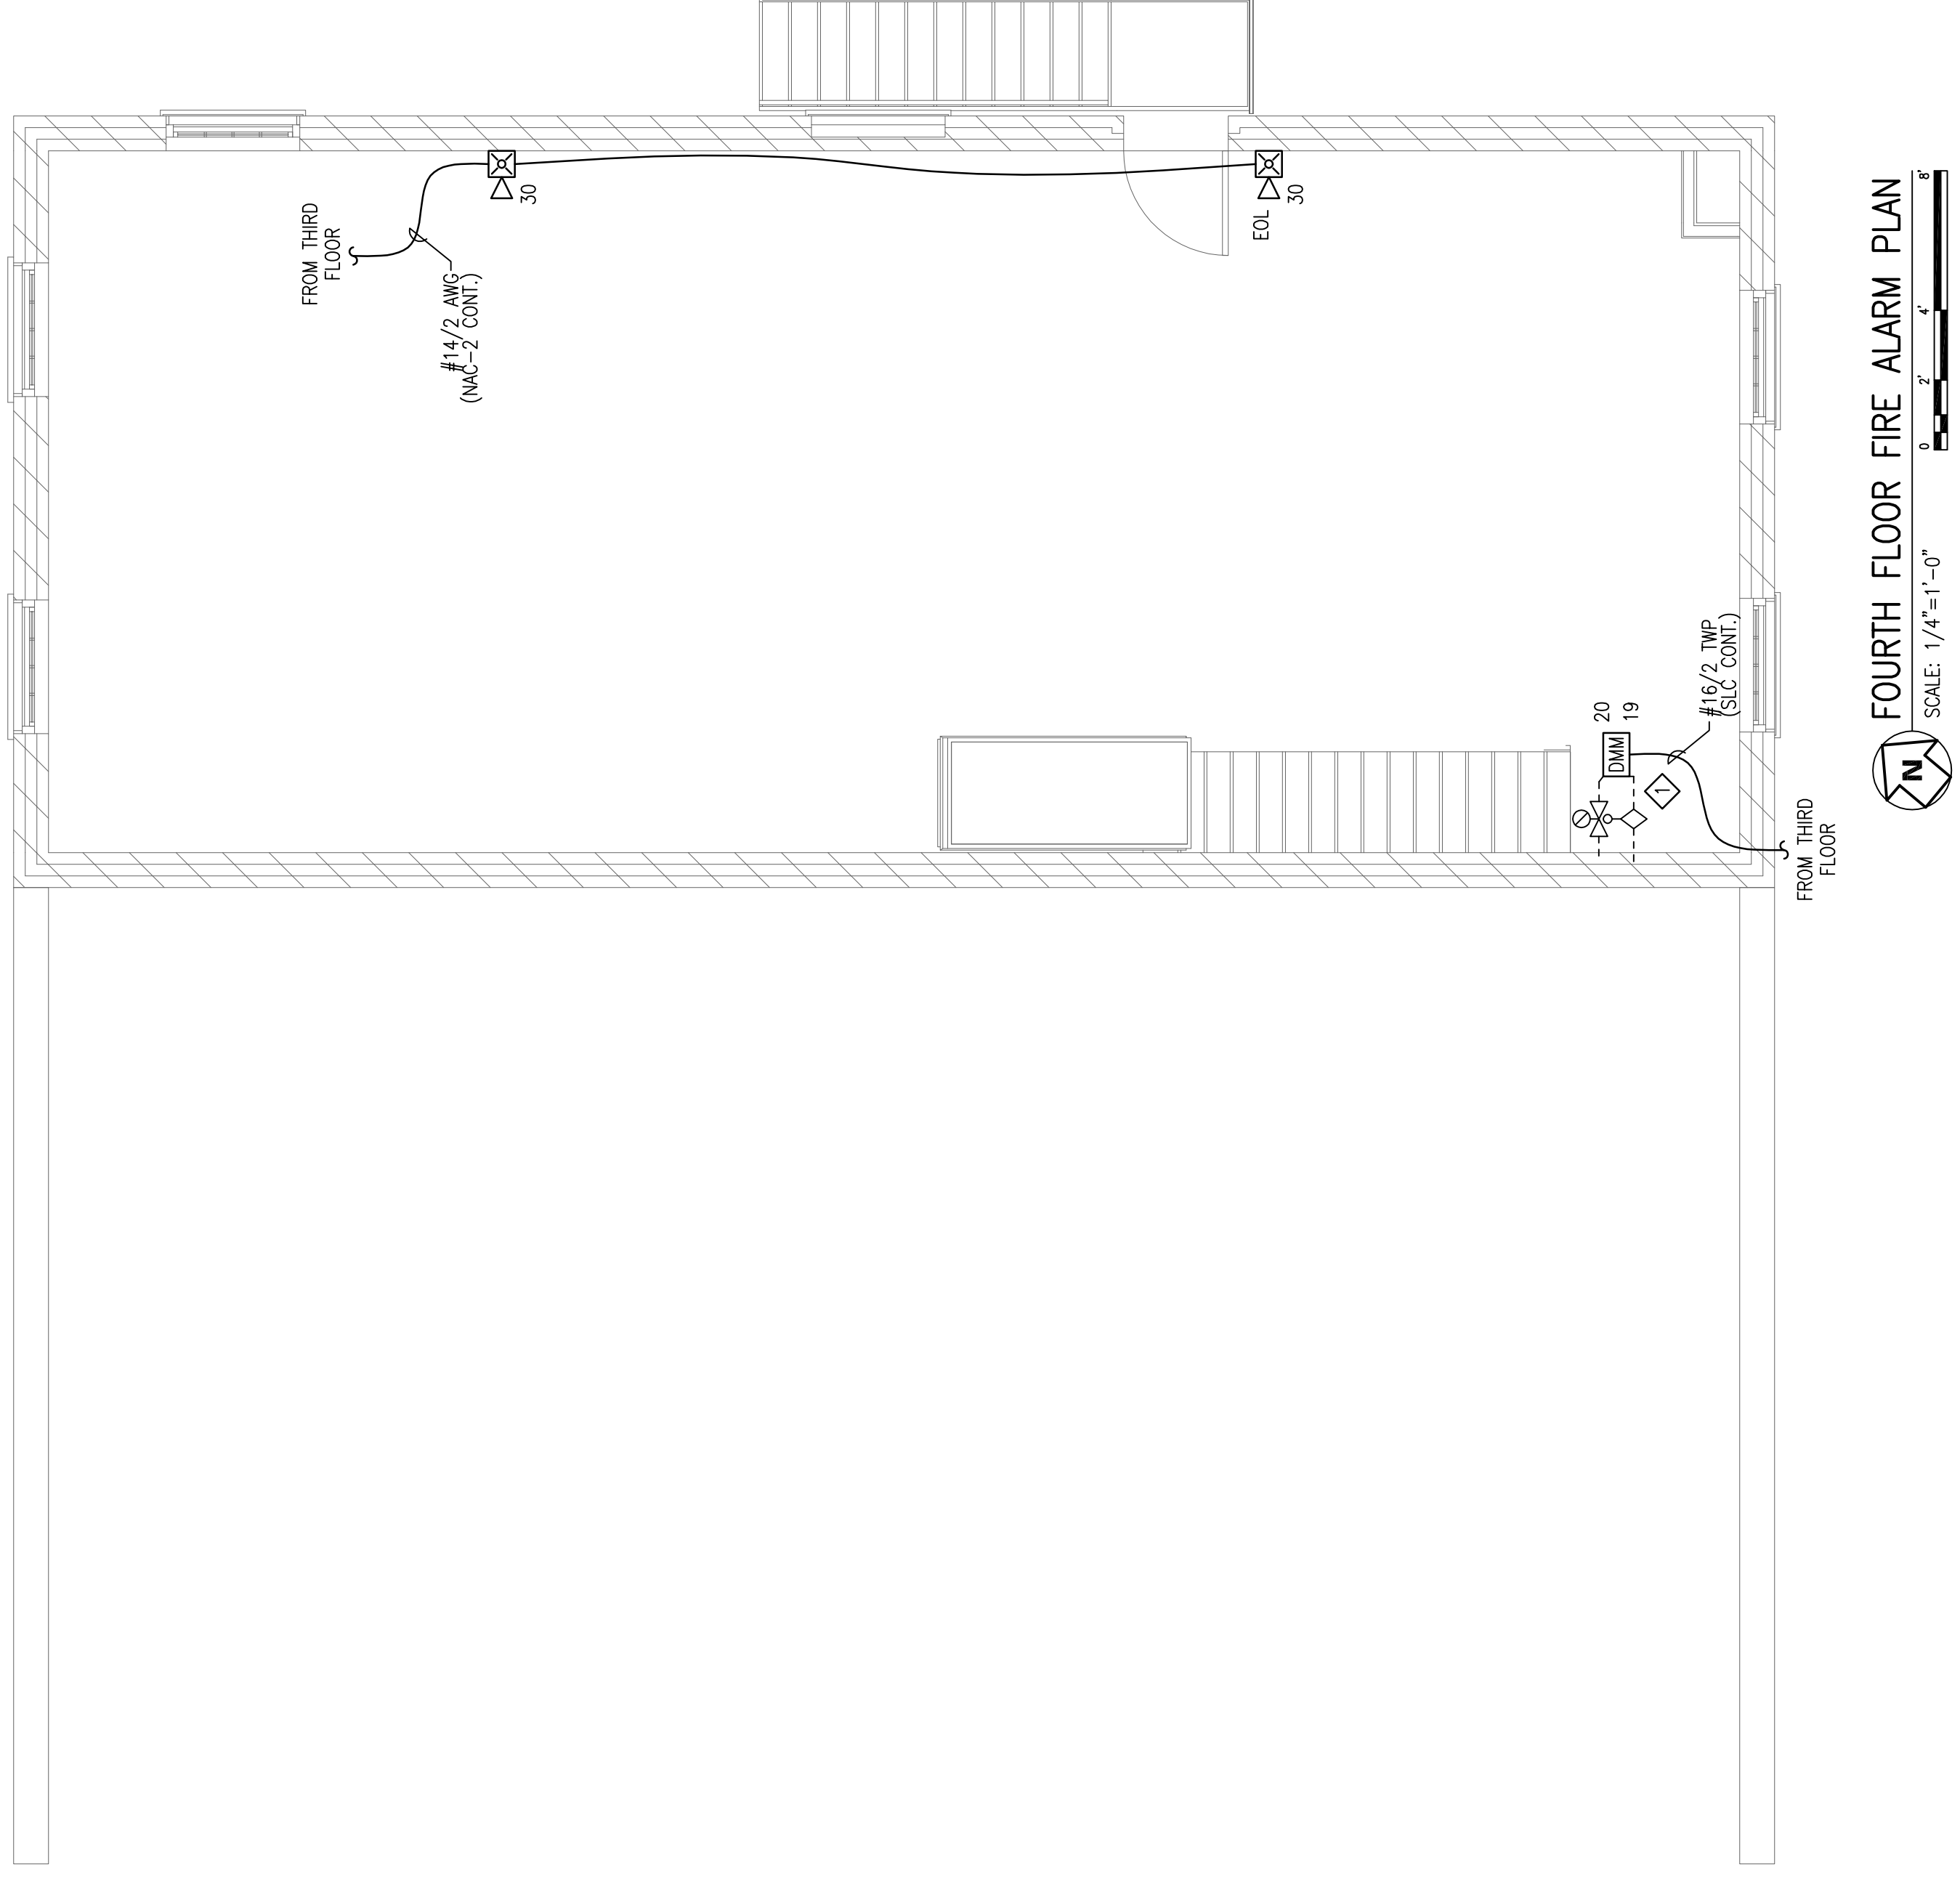

SHEET NOTES:

- ◇ ADDRESSABLE DUAL MONITOR MODULE(S) PROVIDED TO MONITOR ALL WATER FLOW, PRESSURE SWITCHES, TAMPER SWITCHES, AND POST INDICATING VALVES ASSOCIATED WITH THE FIRE SPRINKLER SYSTEM. INSTALLING CONTRACTOR SHALL FIELD VERIFY EXACT MOUNTING, CIRCUITING AND PROGRAMMING REQUIREMENTS. FIELD VERIFY EXACT QUANTITY AND LOCATION(S).

UNICAD Inc.
Fire Alarm Design & Drafting Services

www.unicad.net