



HARRIMAN

 
AUBURN PORTLAND MANCHESTER

GOULD RESAURANT

414 FORE STREET  
PORTLAND, ME 04101


Harriman Project No. 12752

Key Plan Proj North



Issues and Revisions

| Mark | Date     | Description             |
|------|----------|-------------------------|
|      | 05-31-13 | ISSUED FOR CONSTRUCTION |
|      |          |                         |
|      |          |                         |
|      |          |                         |
|      |          |                         |

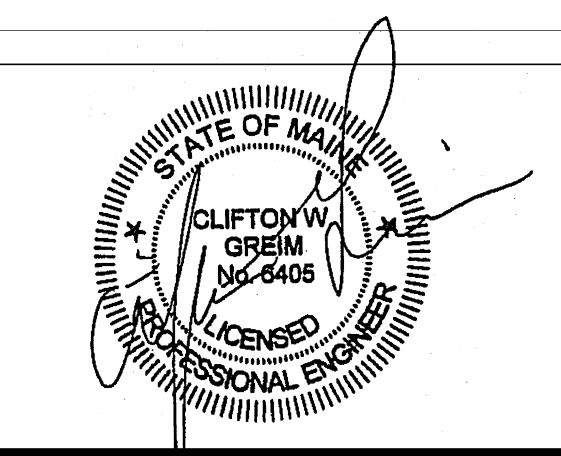


| Drawing Scales | 0 | 2' | 4' | 6' |
|----------------|---|----|----|----|
| 1/4" = 1'-0"   |   |    |    |    |
| 1/4" = 1'-0"   |   |    |    |    |


|               |                               |
|---------------|-------------------------------|
| PA / PE: CG   | © 2013<br>Harriman Associates |
| Drawn By: ROM |                               |

FIRE PROTECTION PLANS


F10.1

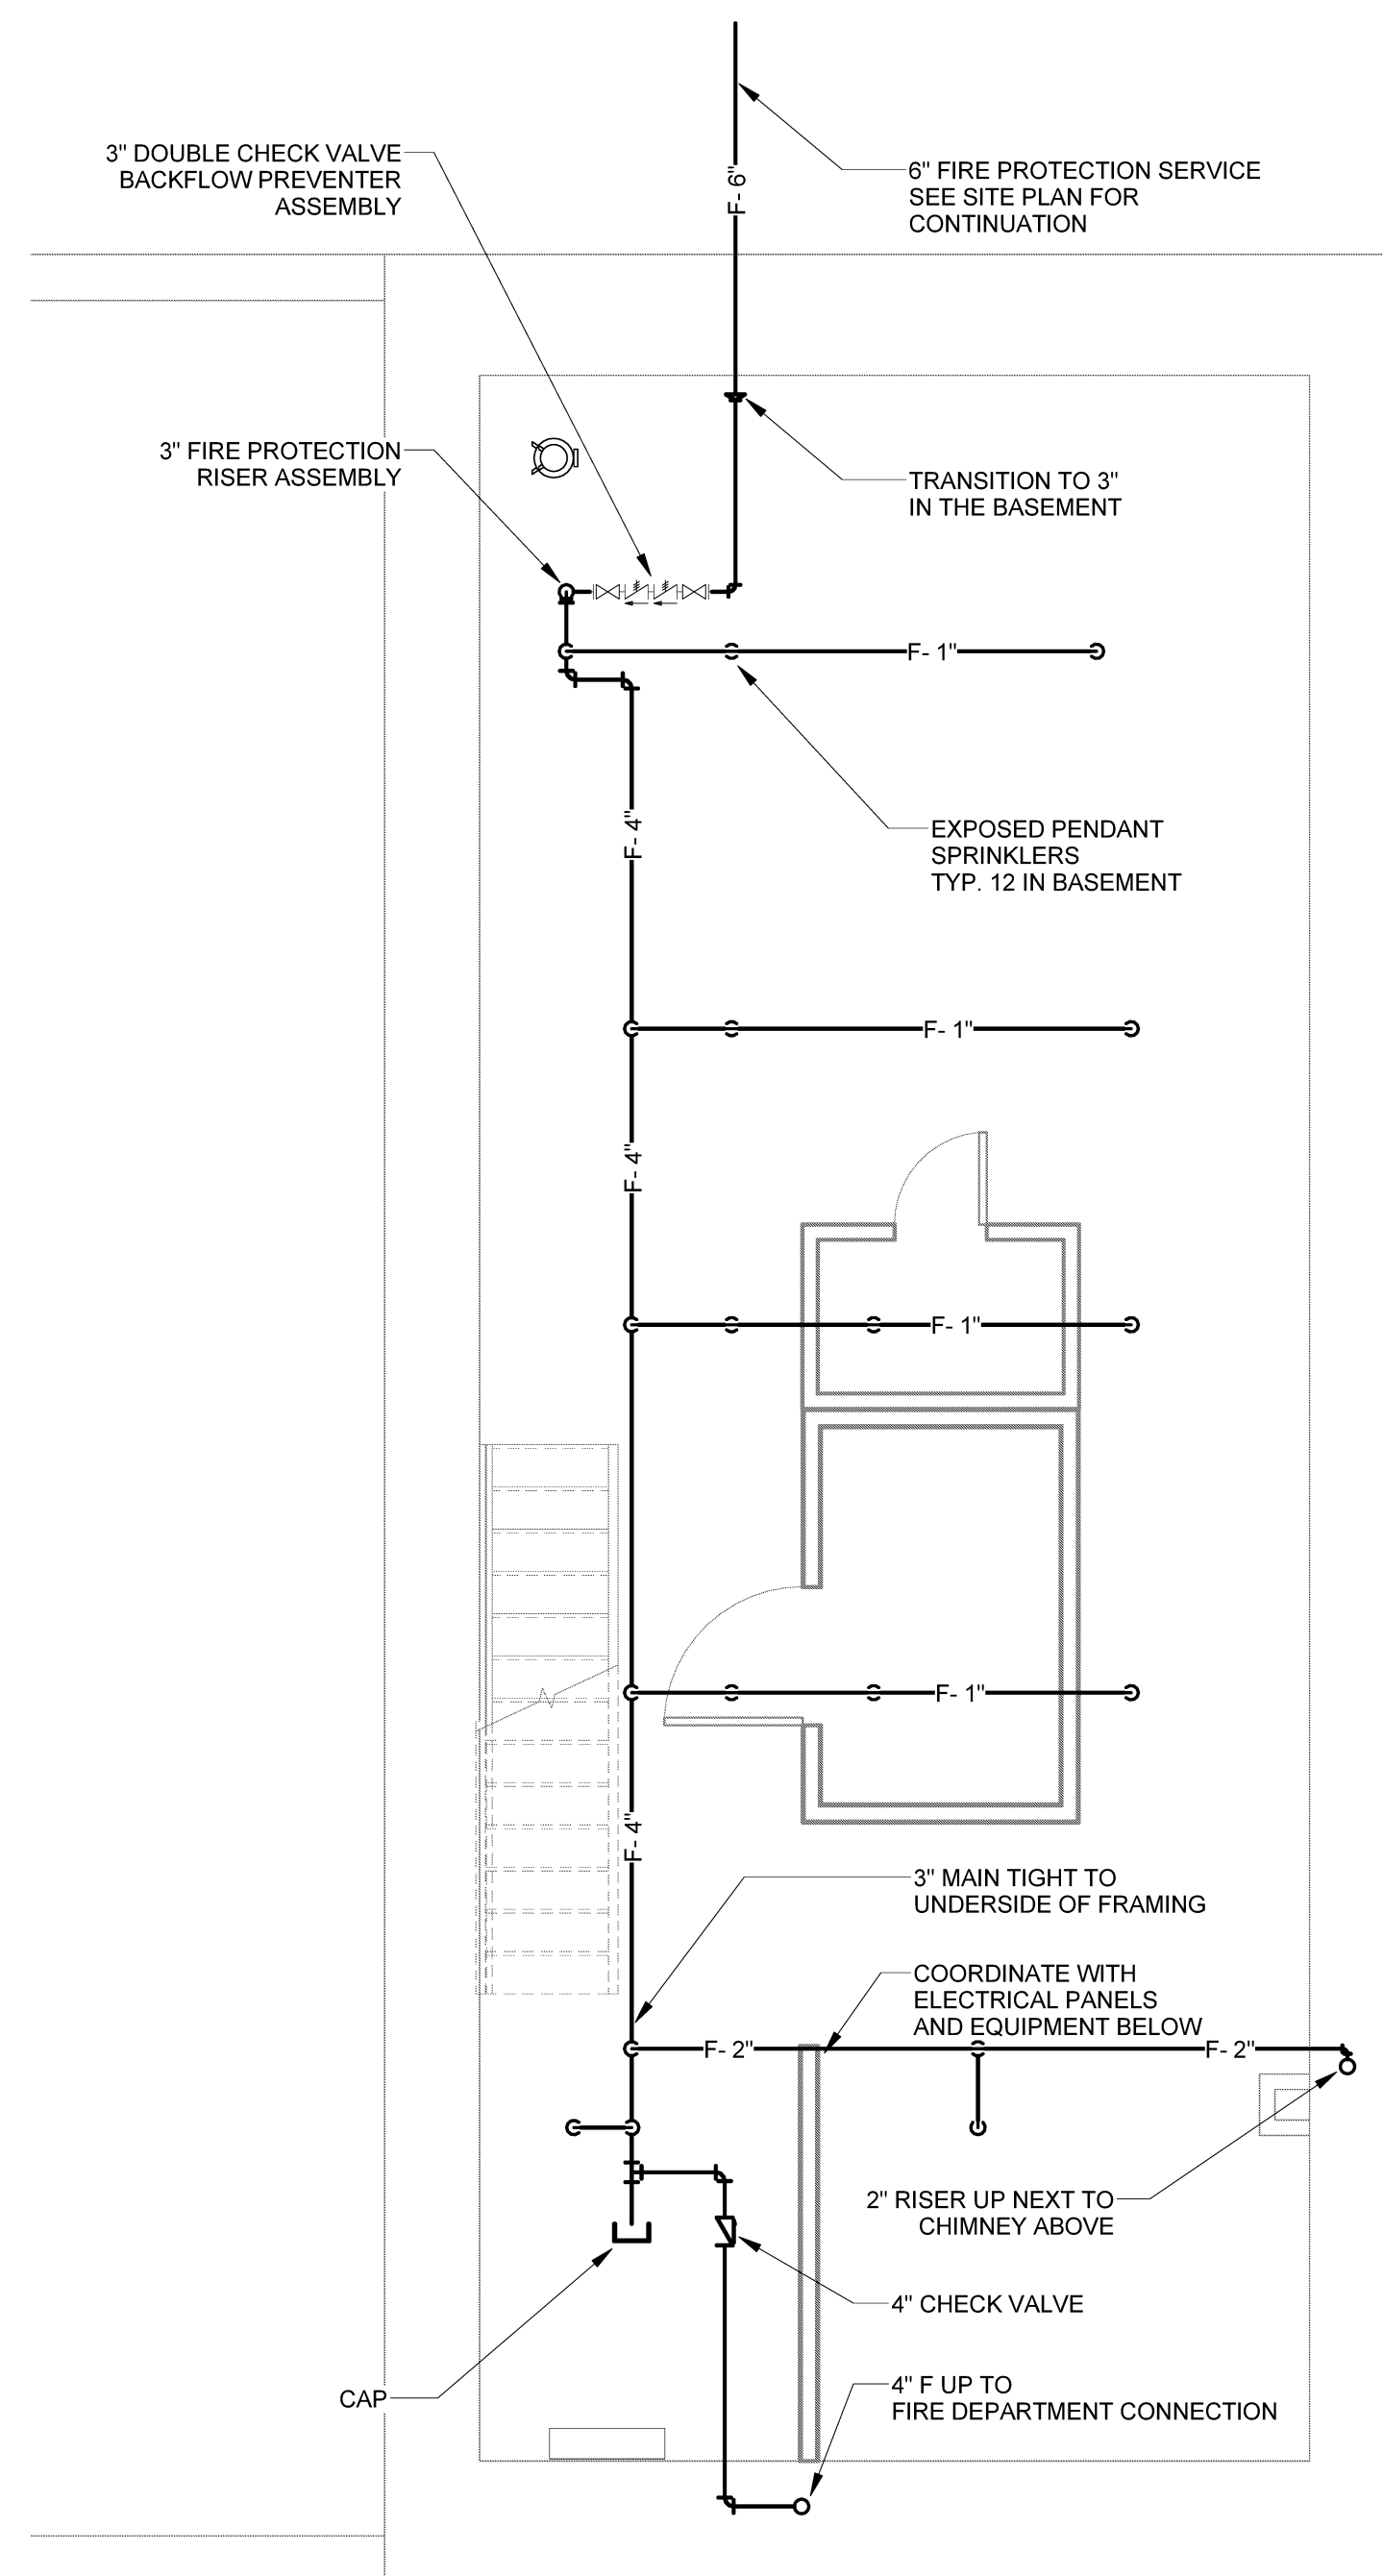

1 BASEMENT FLOOR PLAN FIRE PROTECTION  
SCALE: 1/4" = 1'-0"

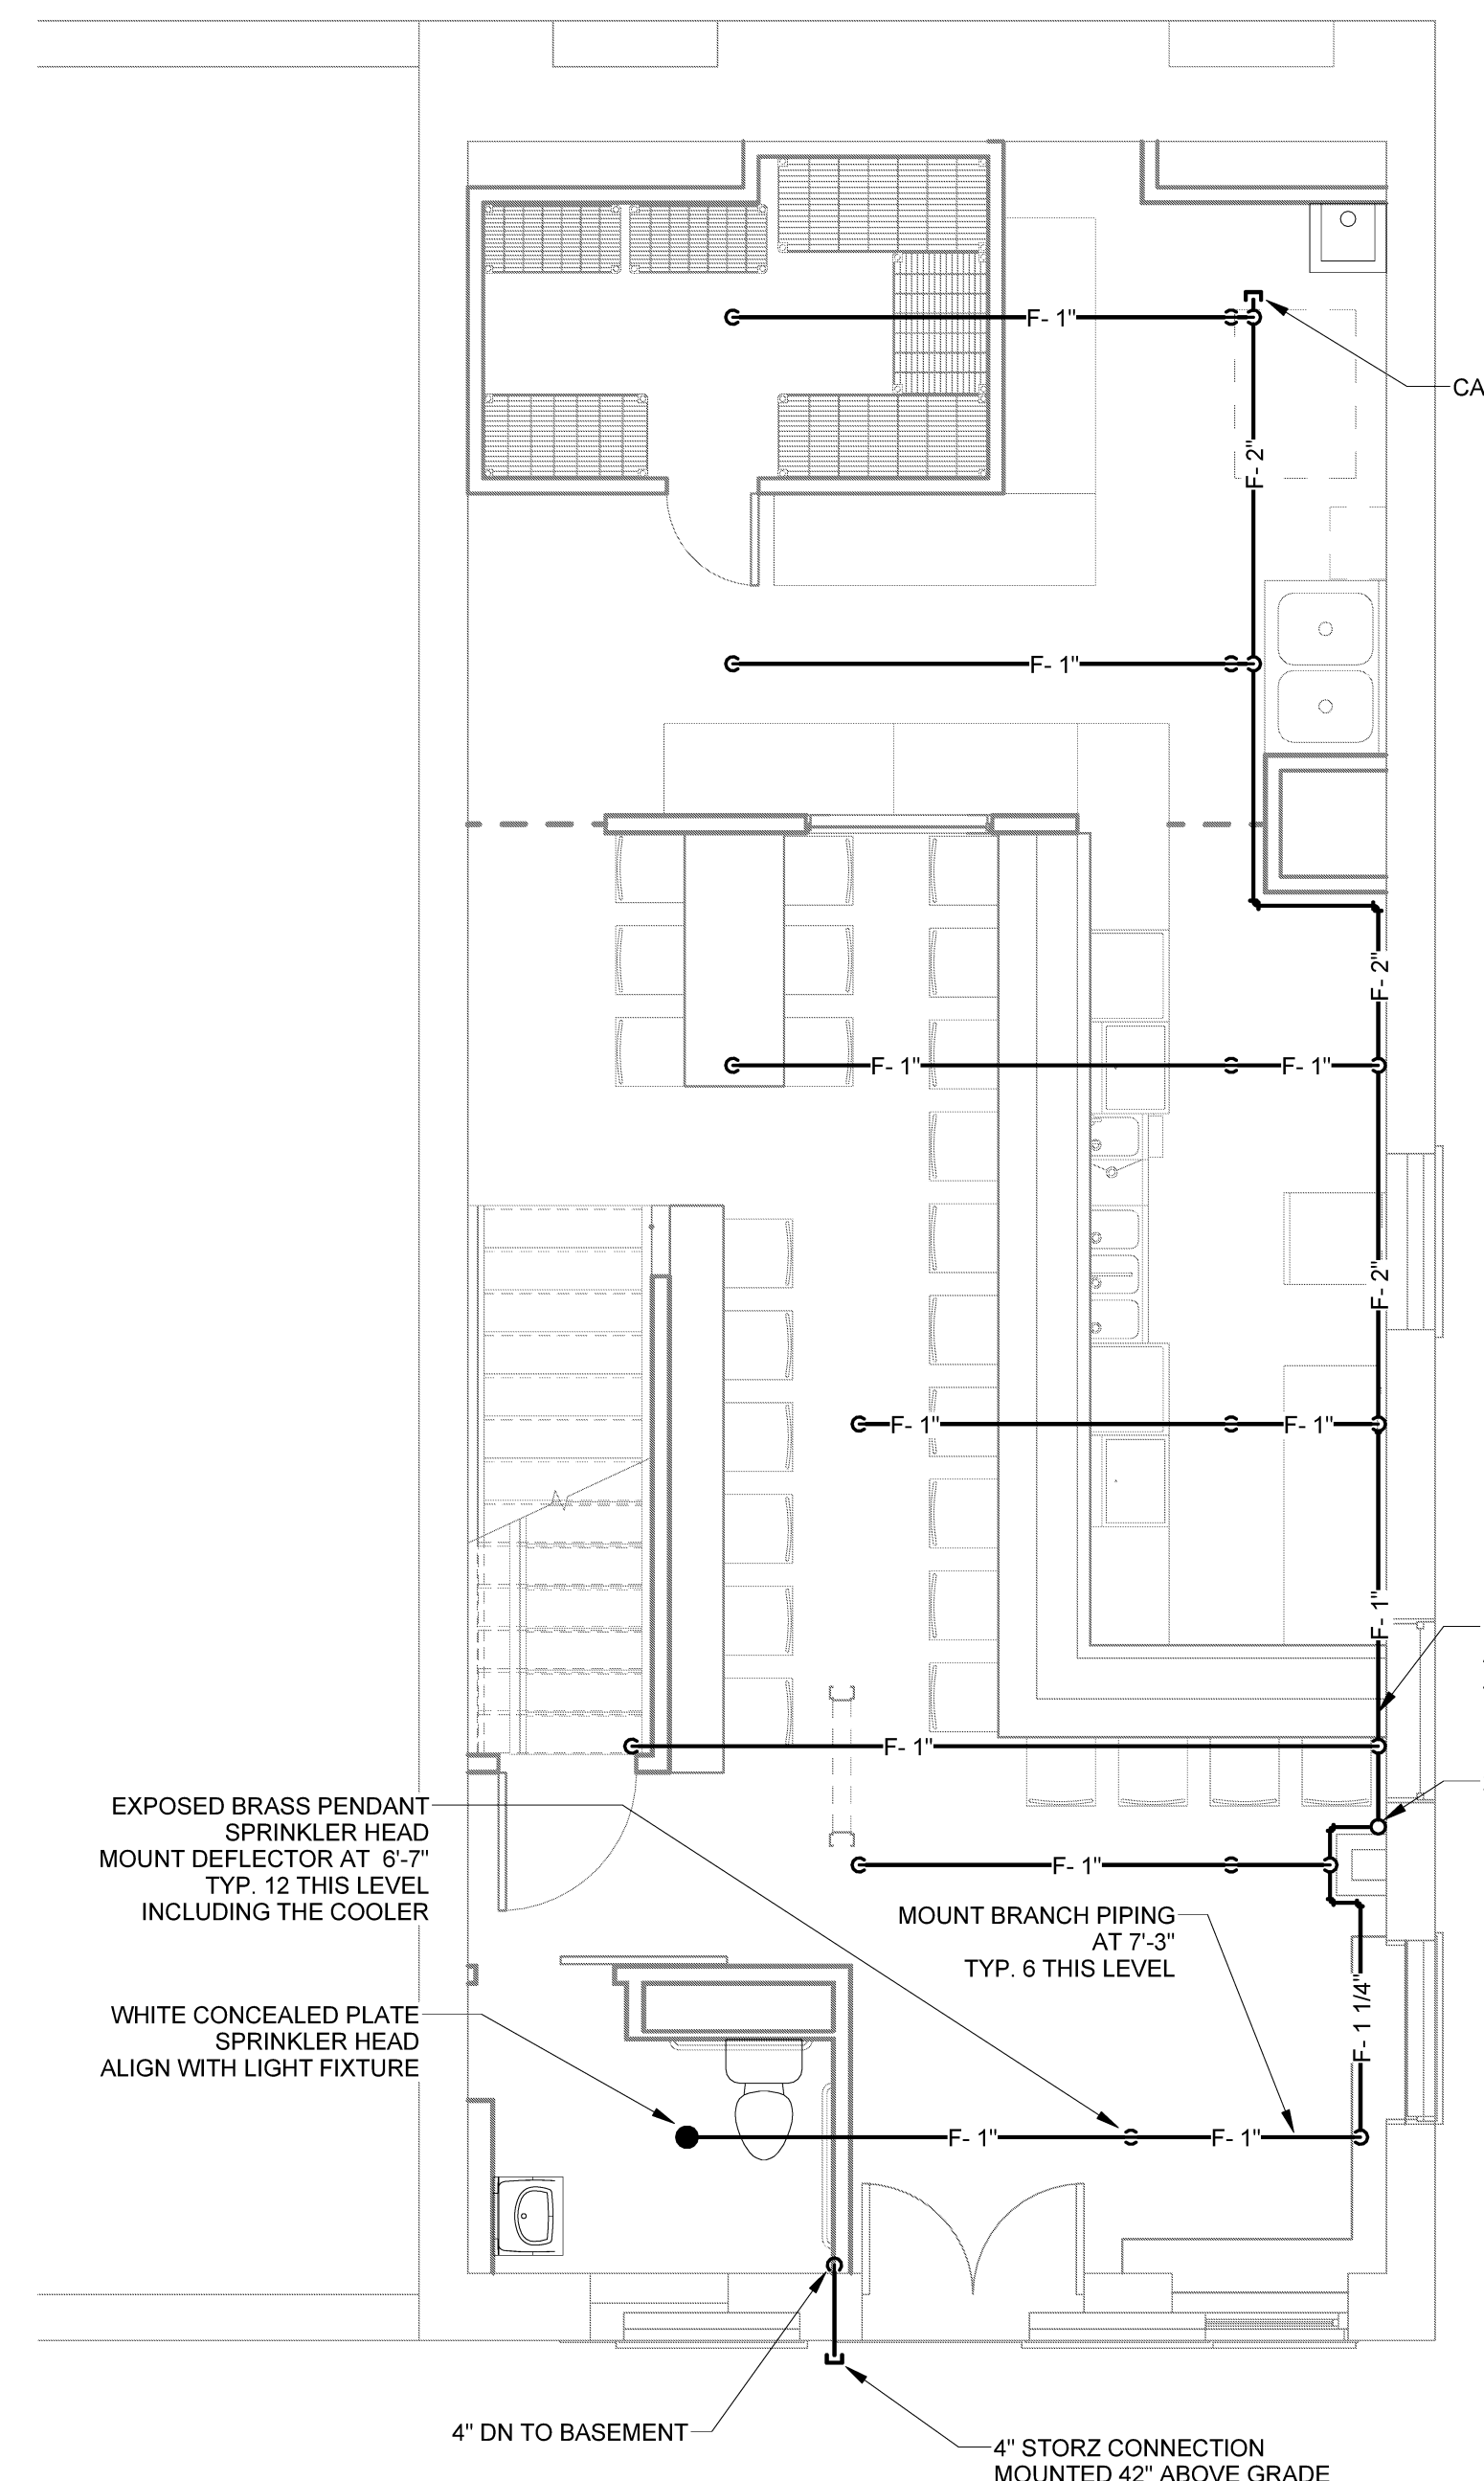

2 FIRST FLOOR PLAN FIRE PROTECTION  
SCALE: 1/4" = 1'-0"

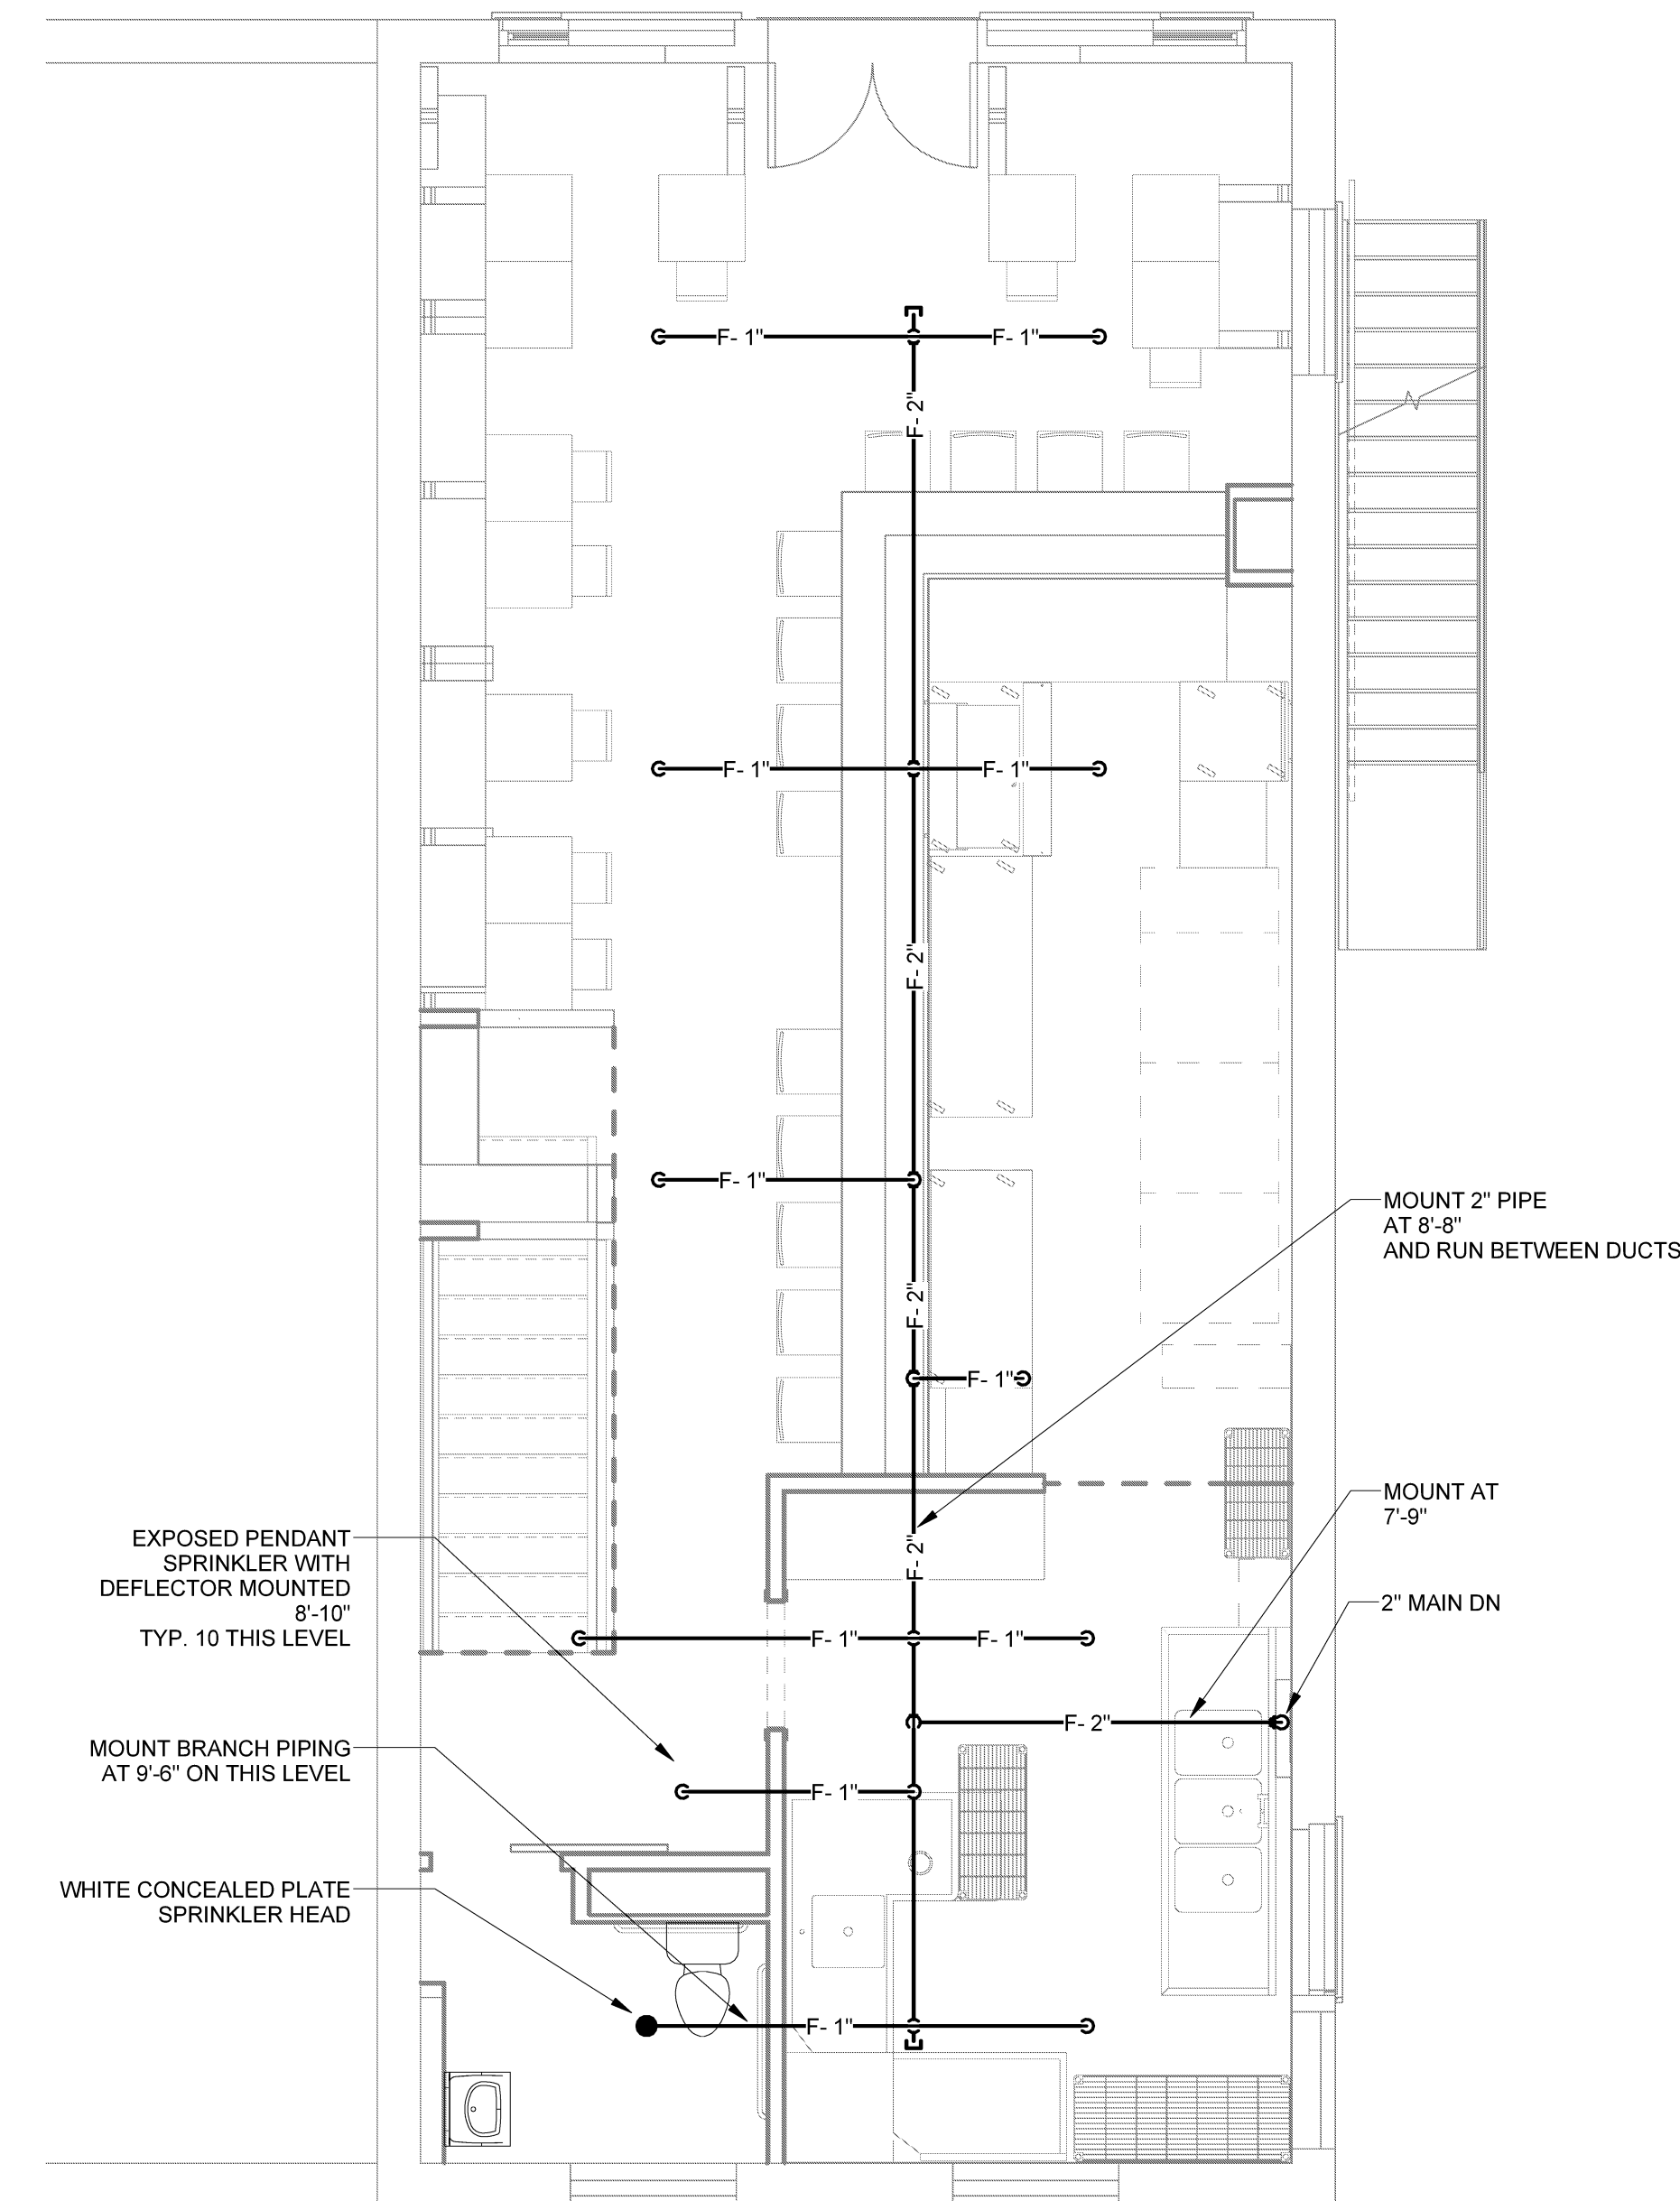

3 SECOND FLOOR PLAN FIRE PROTECTION  
SCALE: 1/4" = 1'-0"