


FORE STREET

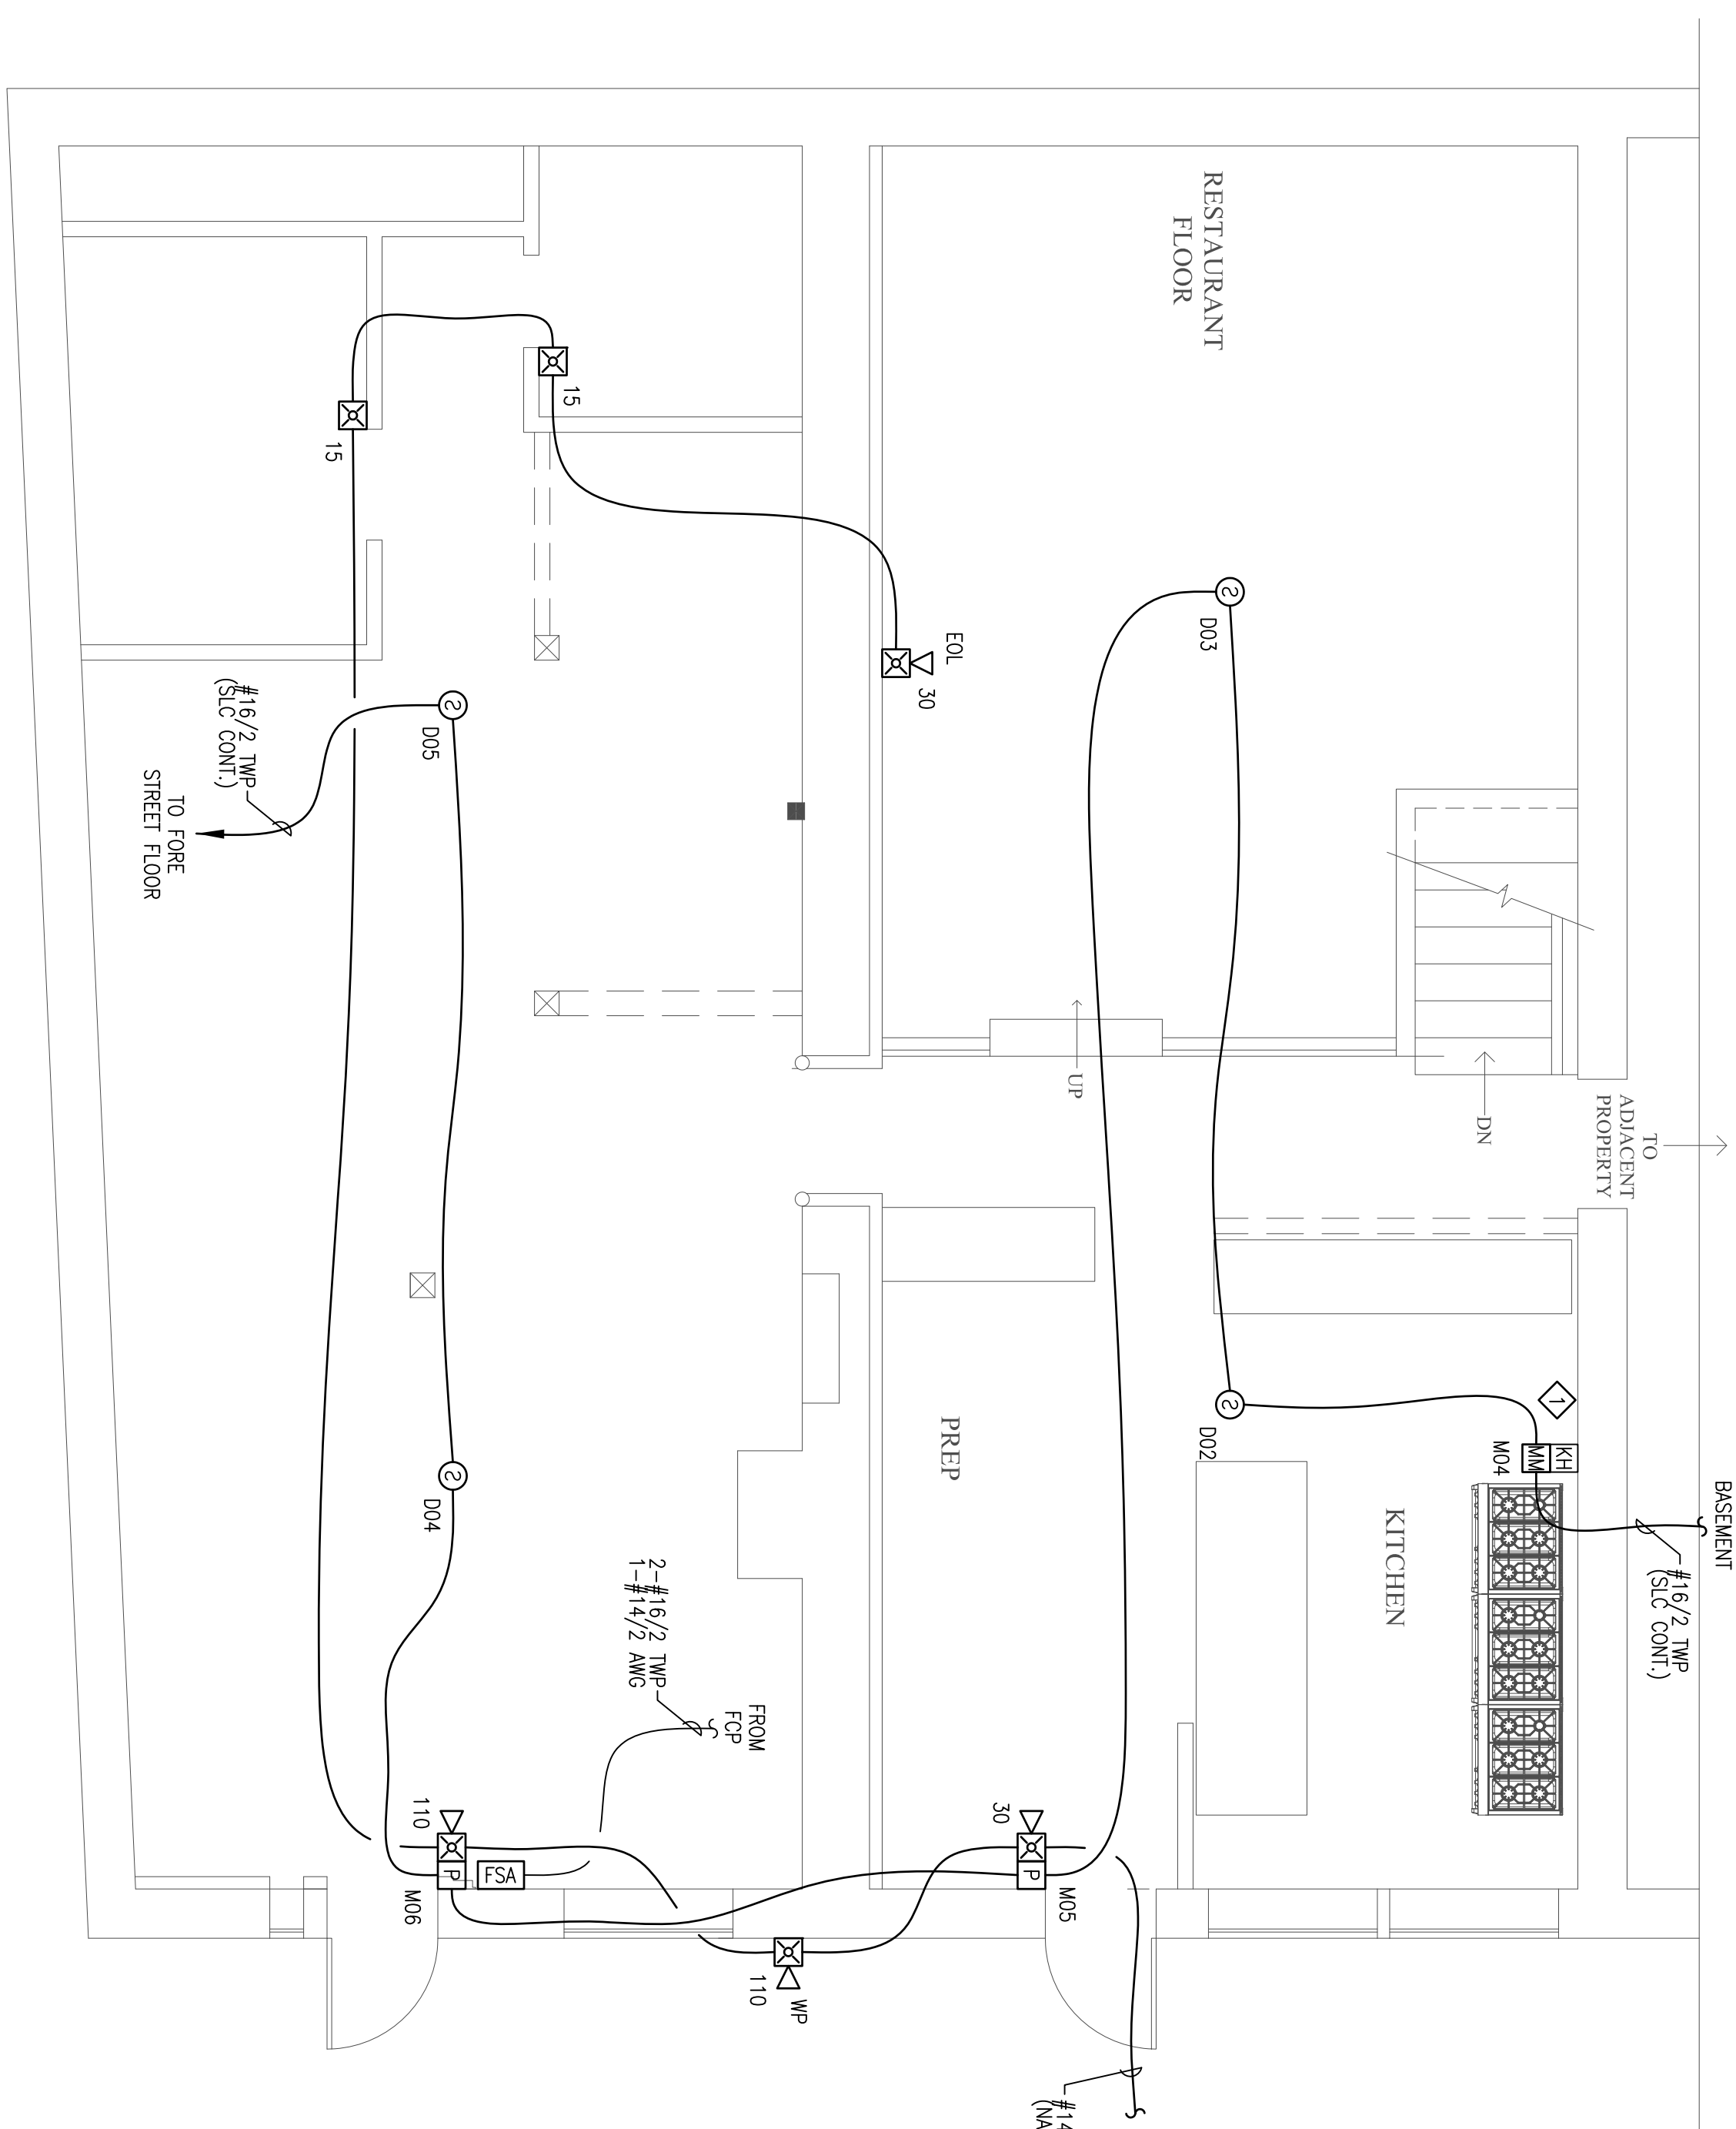

WHARF STREET

WHARF STREET FIRE ALARM PLAN
SCALE: 1/4"=1'-0"

RESERVED FOR CITY STAMP

SHEET NOTES:
 ◆ ADDRESSABLE MONITOR MODULE PROVIDED TO MONITOR THE KITCHEN HOOD FIRE SUPPRESSION SYSTEM. INSTALLING CONTRACTOR SHALL FIELD VERIFY EXACT MOUNTING, CIRCUITING AND PROGRAMMING REQUIREMENTS. FIELD VERIFY EXACT QUANTITY AND LOCATION(S).

REVISION	DESCRIPTION	DATE
0	ISSUED FOR REVIEW & APPROVAL	4/8/2015

CUNNINGHAM
Security Systems
 10 Princes Point Road, Yarmouth, Maine 04096
 Office: 207.846.3350 • Fax: 207.846.6080

424-426 FORE STREET
 PORTLAND, MAINE 04101
WHARF STREET FIRE ALARM PLAN

UNIGAD Inc.
 5700 Broadway
 Suite 400
 Portland, ME 04103
 Office: 207.846.6110
 www.unigad.com
UNIGAD
 Fire Alarm Design & Drafting Services
FA-3

REVISION	DATE	CHECKED	DRAWN
0	4/8/2015	WYNNE B. HANS NCEIT # 90496	JPB UNIGAD JOB #15227