


FORE STREET

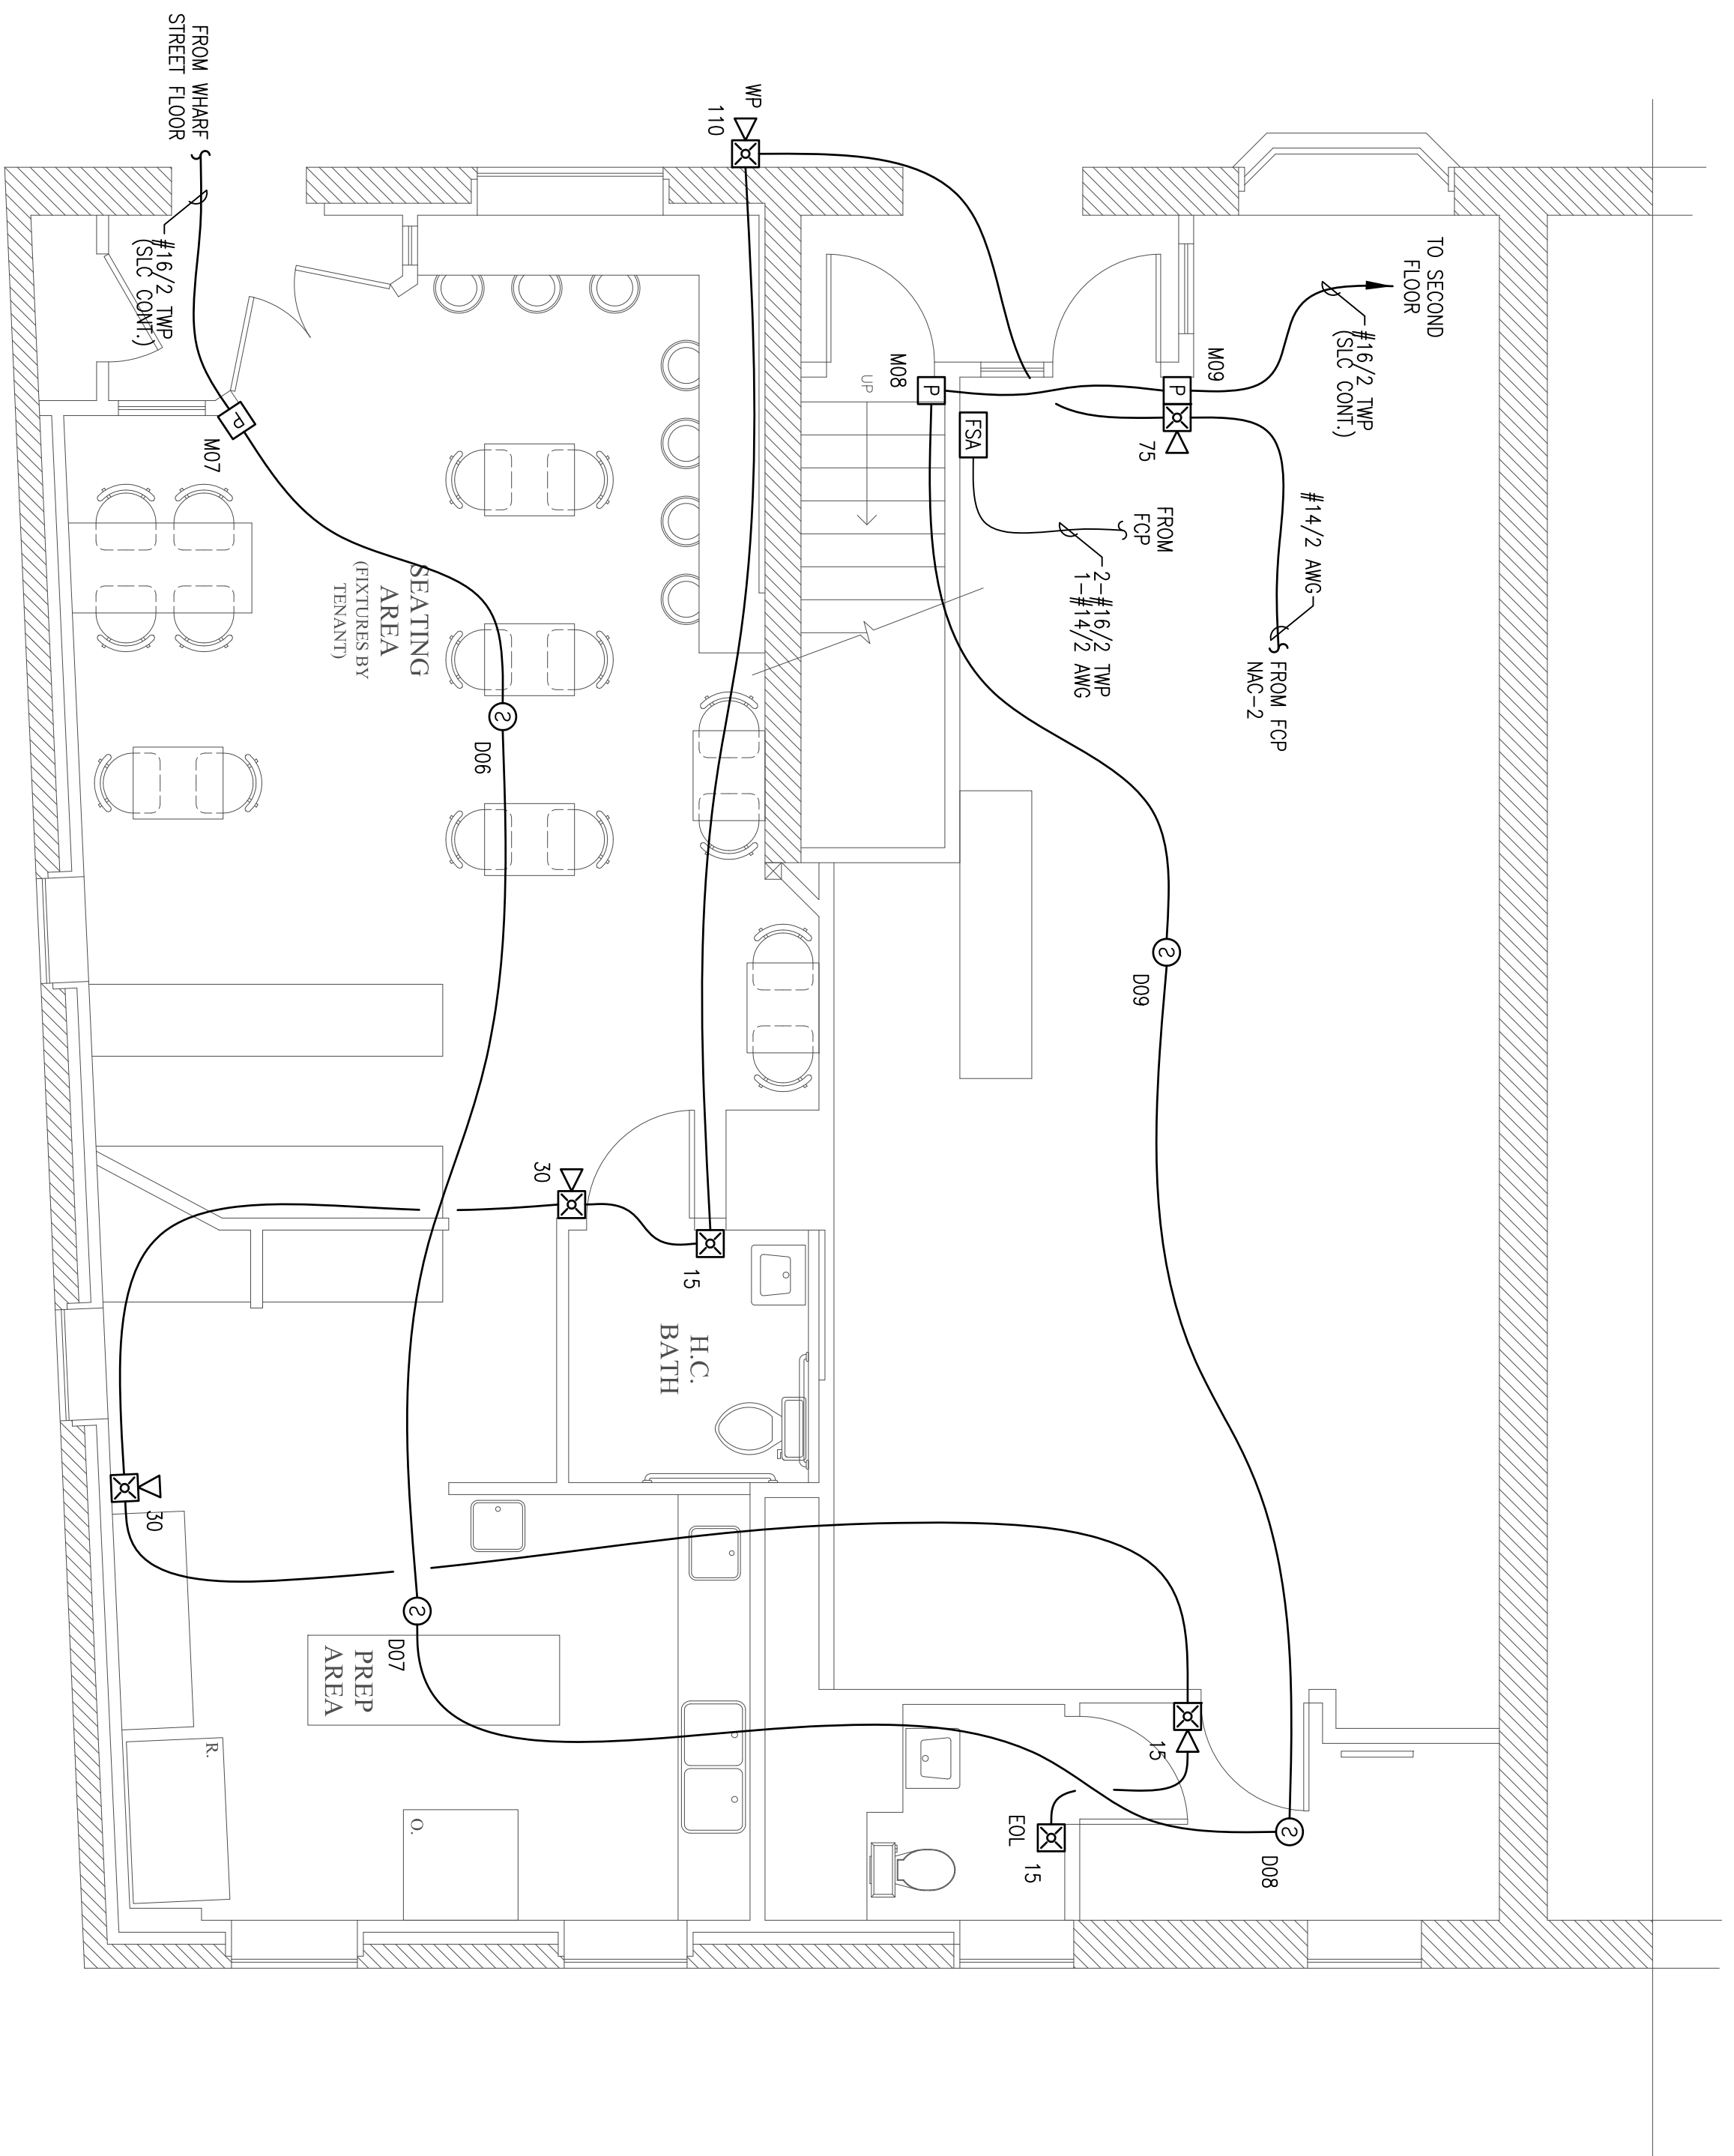

FORE STREET FIRE ALARM PLAN  
SCALE: 1/4"=1'-0"

WHARF STREET

RESERVED FOR CITY STAMP

REVISION	DESCRIPTION	DATE
0	ISSUED FOR REVIEW & APPROVAL	4/8/2015

**CUNNINGHAM**  
Security Systems  
10 Princes Point Road, Yarmouth, Maine 04096  
Office: 207.846.3350 • Fax: 207.846.6080

424-426 FORE STREET  
PORTLAND, MAINE 04101  
FORE STREET FIRE ALARM PLAN

UNIGAD Inc.  
Fire Alarm Design & Drafting Services  
578 W. 40th St.  
Portland, ME 04102  
Office: 207.846.6110  
www.unigad.me

**FA-4**

DRAWN	JPB
UNICAD JOB #15227	
CHECKED	WAYNE B. HAWES
DATE	NCETI IV 90496
DATE	4/8/2015
REVISION	0
SCALE	1/4"=1'-0"