


FORE STREET

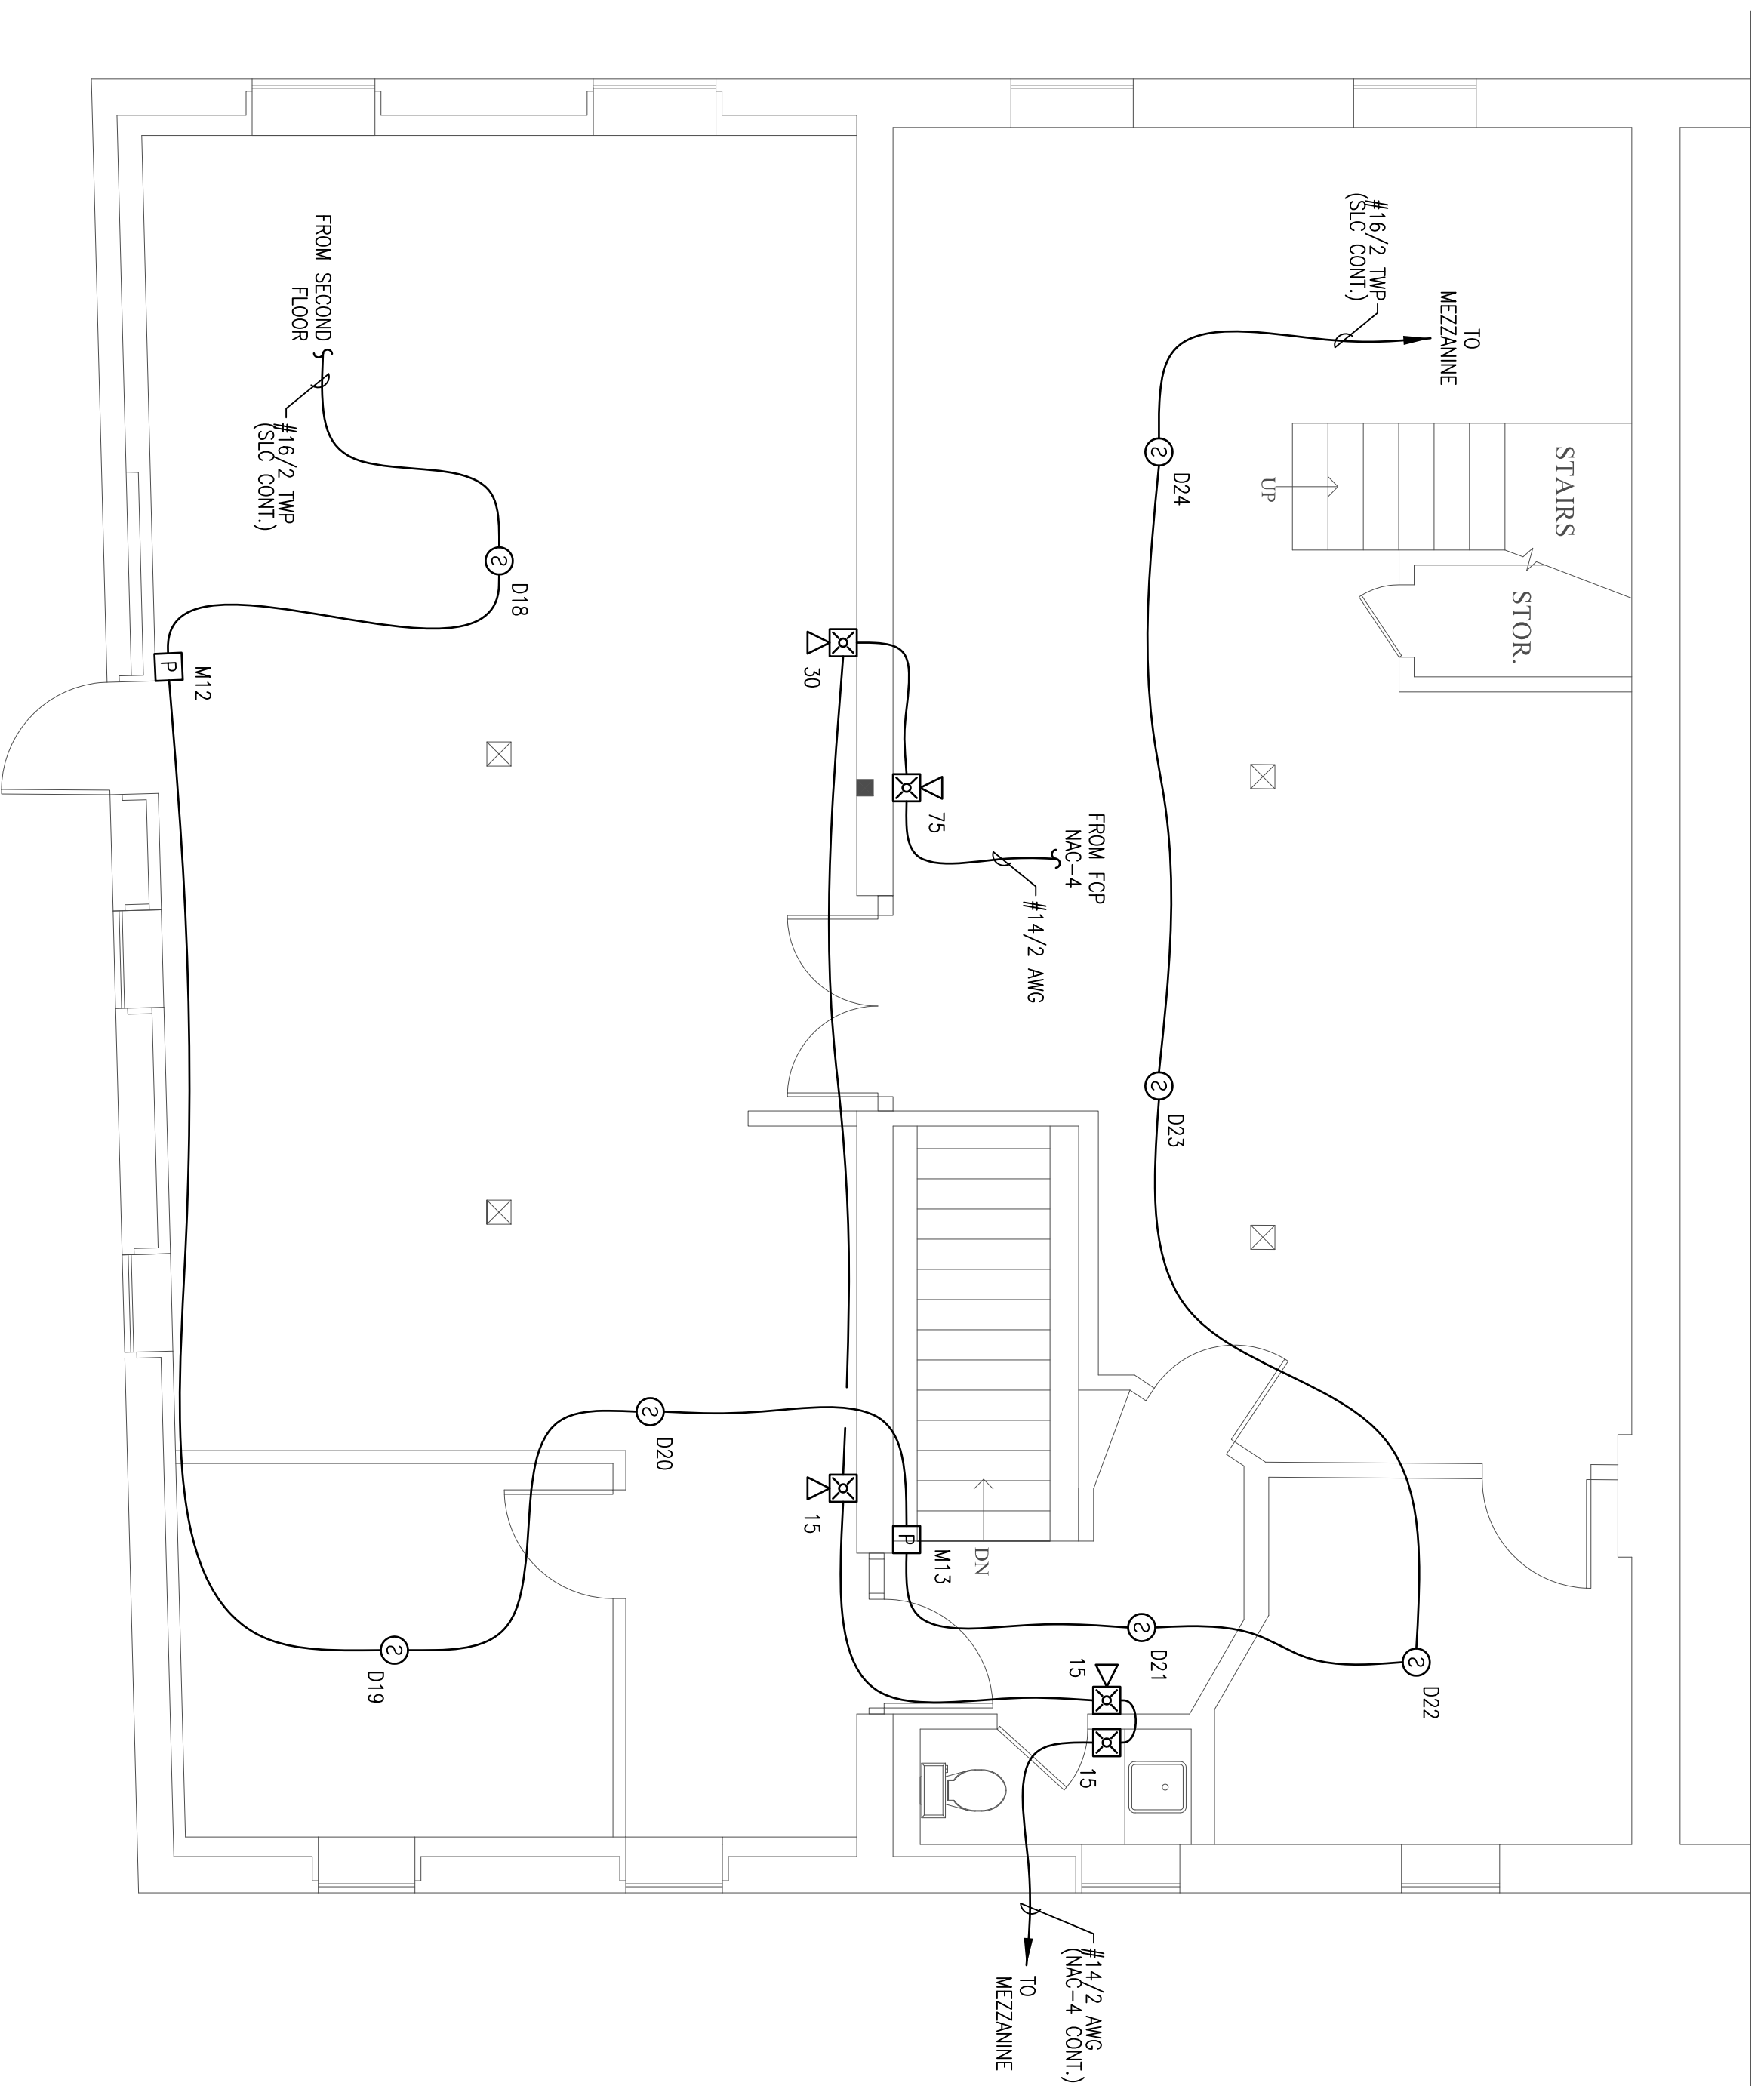

THIRD FLOOR FIRE ALARM PLAN
SCALE: 1/4"=1'-0"

WHARF STREET

RESERVED FOR CITY STAMP

424-426 FORE STREET
PORTLAND, MAINE 04101
THIRD FLOOR FIRE ALARM PLAN

CUNNINGHAM
Security Systems

10 Princes Point Road, Yarmouth, Maine 04096
Office: 207.846.3350 • Fax: 207.846.6080

REVISION	DESCRIPTION	DATE
0	ISSUED FOR REVIEW & APPROVAL	4/8/2015

UNIGAD Inc.
Fire Alarm Design & Drafting Services
578 W. 40th St.
Portland, ME 04102
Office: 207.846.6110
www.unigad.me

FA-6

DRWN	JPB
UNIGAD JOB #15227	
CHECKED	WAYNE B. HAWES
DATE	NCEI IV 90496
DATE	4/8/2015
REVISION	0
SCALE	1/4"=1'-0"