

GENERAL CONTRACTOR

STRUCTURAL ENGINEER


MEP ENGINEER

CLIENT



PROJECT

TIAA
 Interior Office
 Renovation
 4 City Center
 Portland, ME 04106

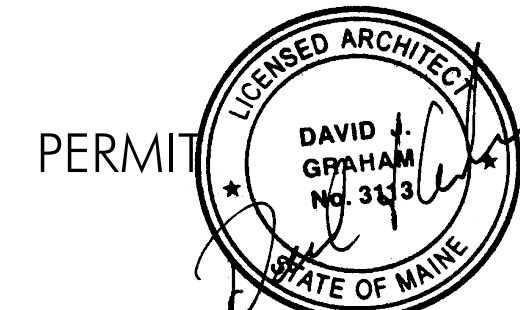

INFORMATION

Path: M./boulos/lia
 Issue Date: 06/08/16
 Drawn By: dijg
 Checked By:
 Revision:
 1.
 2.
 3.
 4.


TITLE

FURNITURE PLAN AND
 POWER AND DATA PLAN


SCALE AS NOTED

© 2016 Graham Architects. All rights reserved. Information, material, and designs in this document are proprietary to and owned by Graham Architects, and may not be disclosed to any third party, reproduced, posted on a global computer information network, or distributed in any way without the written consent from Graham Architects.

DATA DROP / 2 CABLES
 WALL PHONE AT 42" A.F.F. / 1 CABLE
 DATA DROP AT COUNTER HEIGHT / 2 CABLES
 WiFi

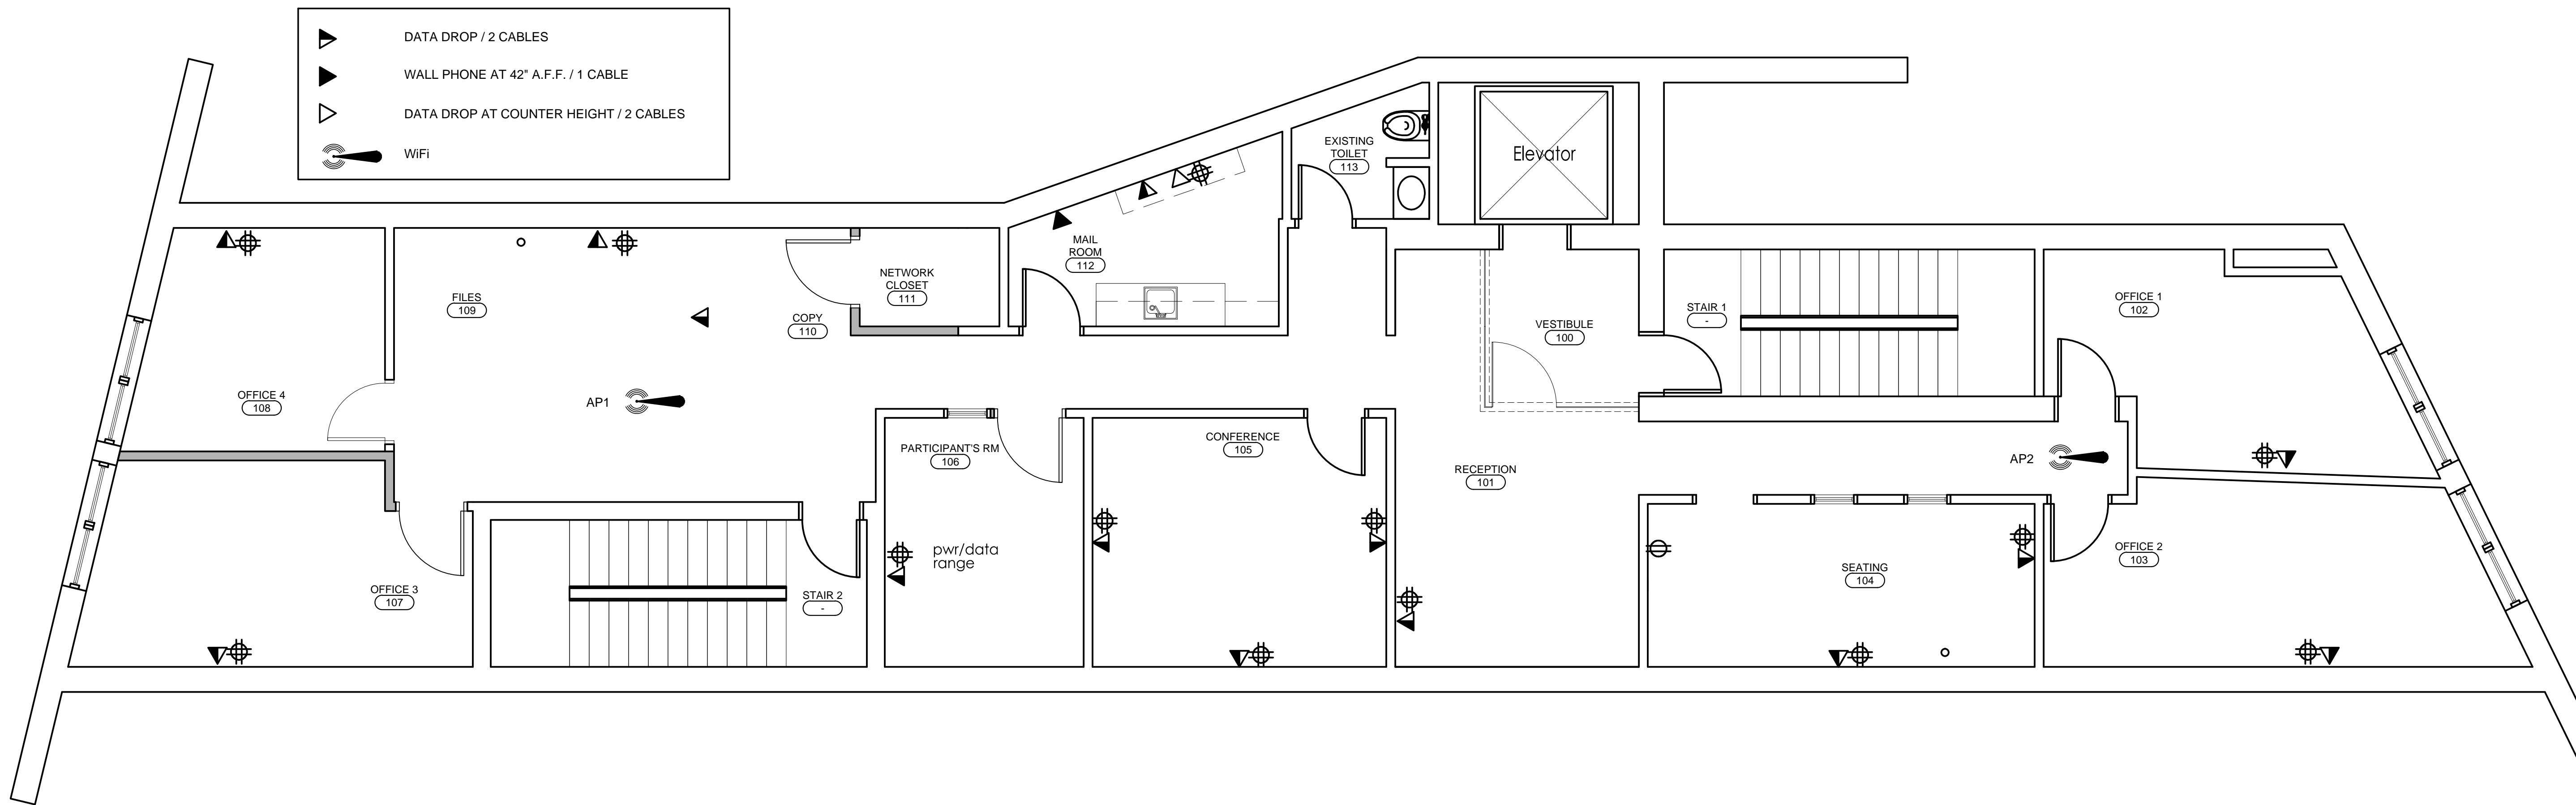

2 1/4"=1'-0" POWER AND DATA PLAN

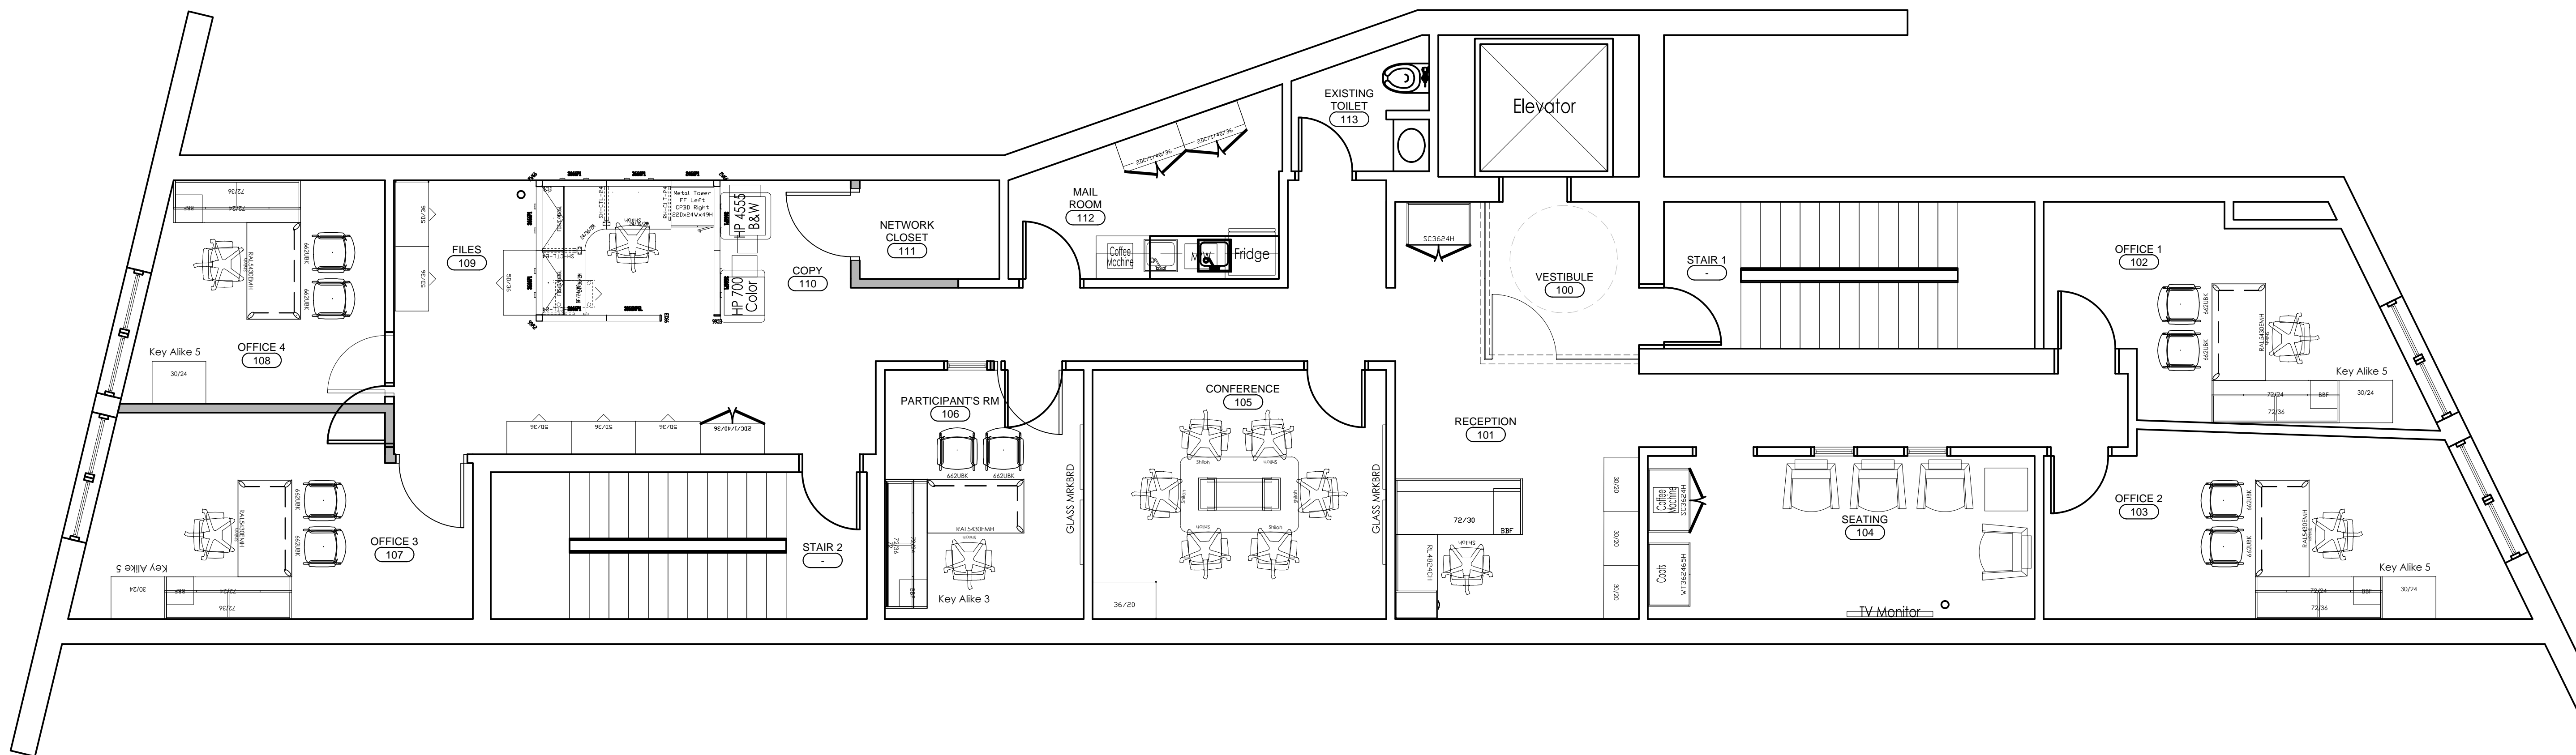

1 1/4"=1'-0" PROPOSED FURNITURE PLAN