


Revisions

**Amigos Mexican
Restaurant &
Bar
Roof Deck &
Patio**

9 Dana Street
Portland, Maine 04101

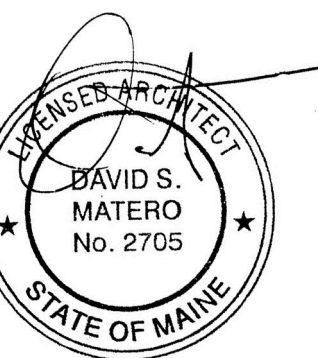


Job Number: 15.000
Date: 12.28.15
Scale: 1/4" = 1'-0"


Drawing Title:
**Proposed
Deck Plan
and Lighting
Plan**

A1.2

Issued for
Permit

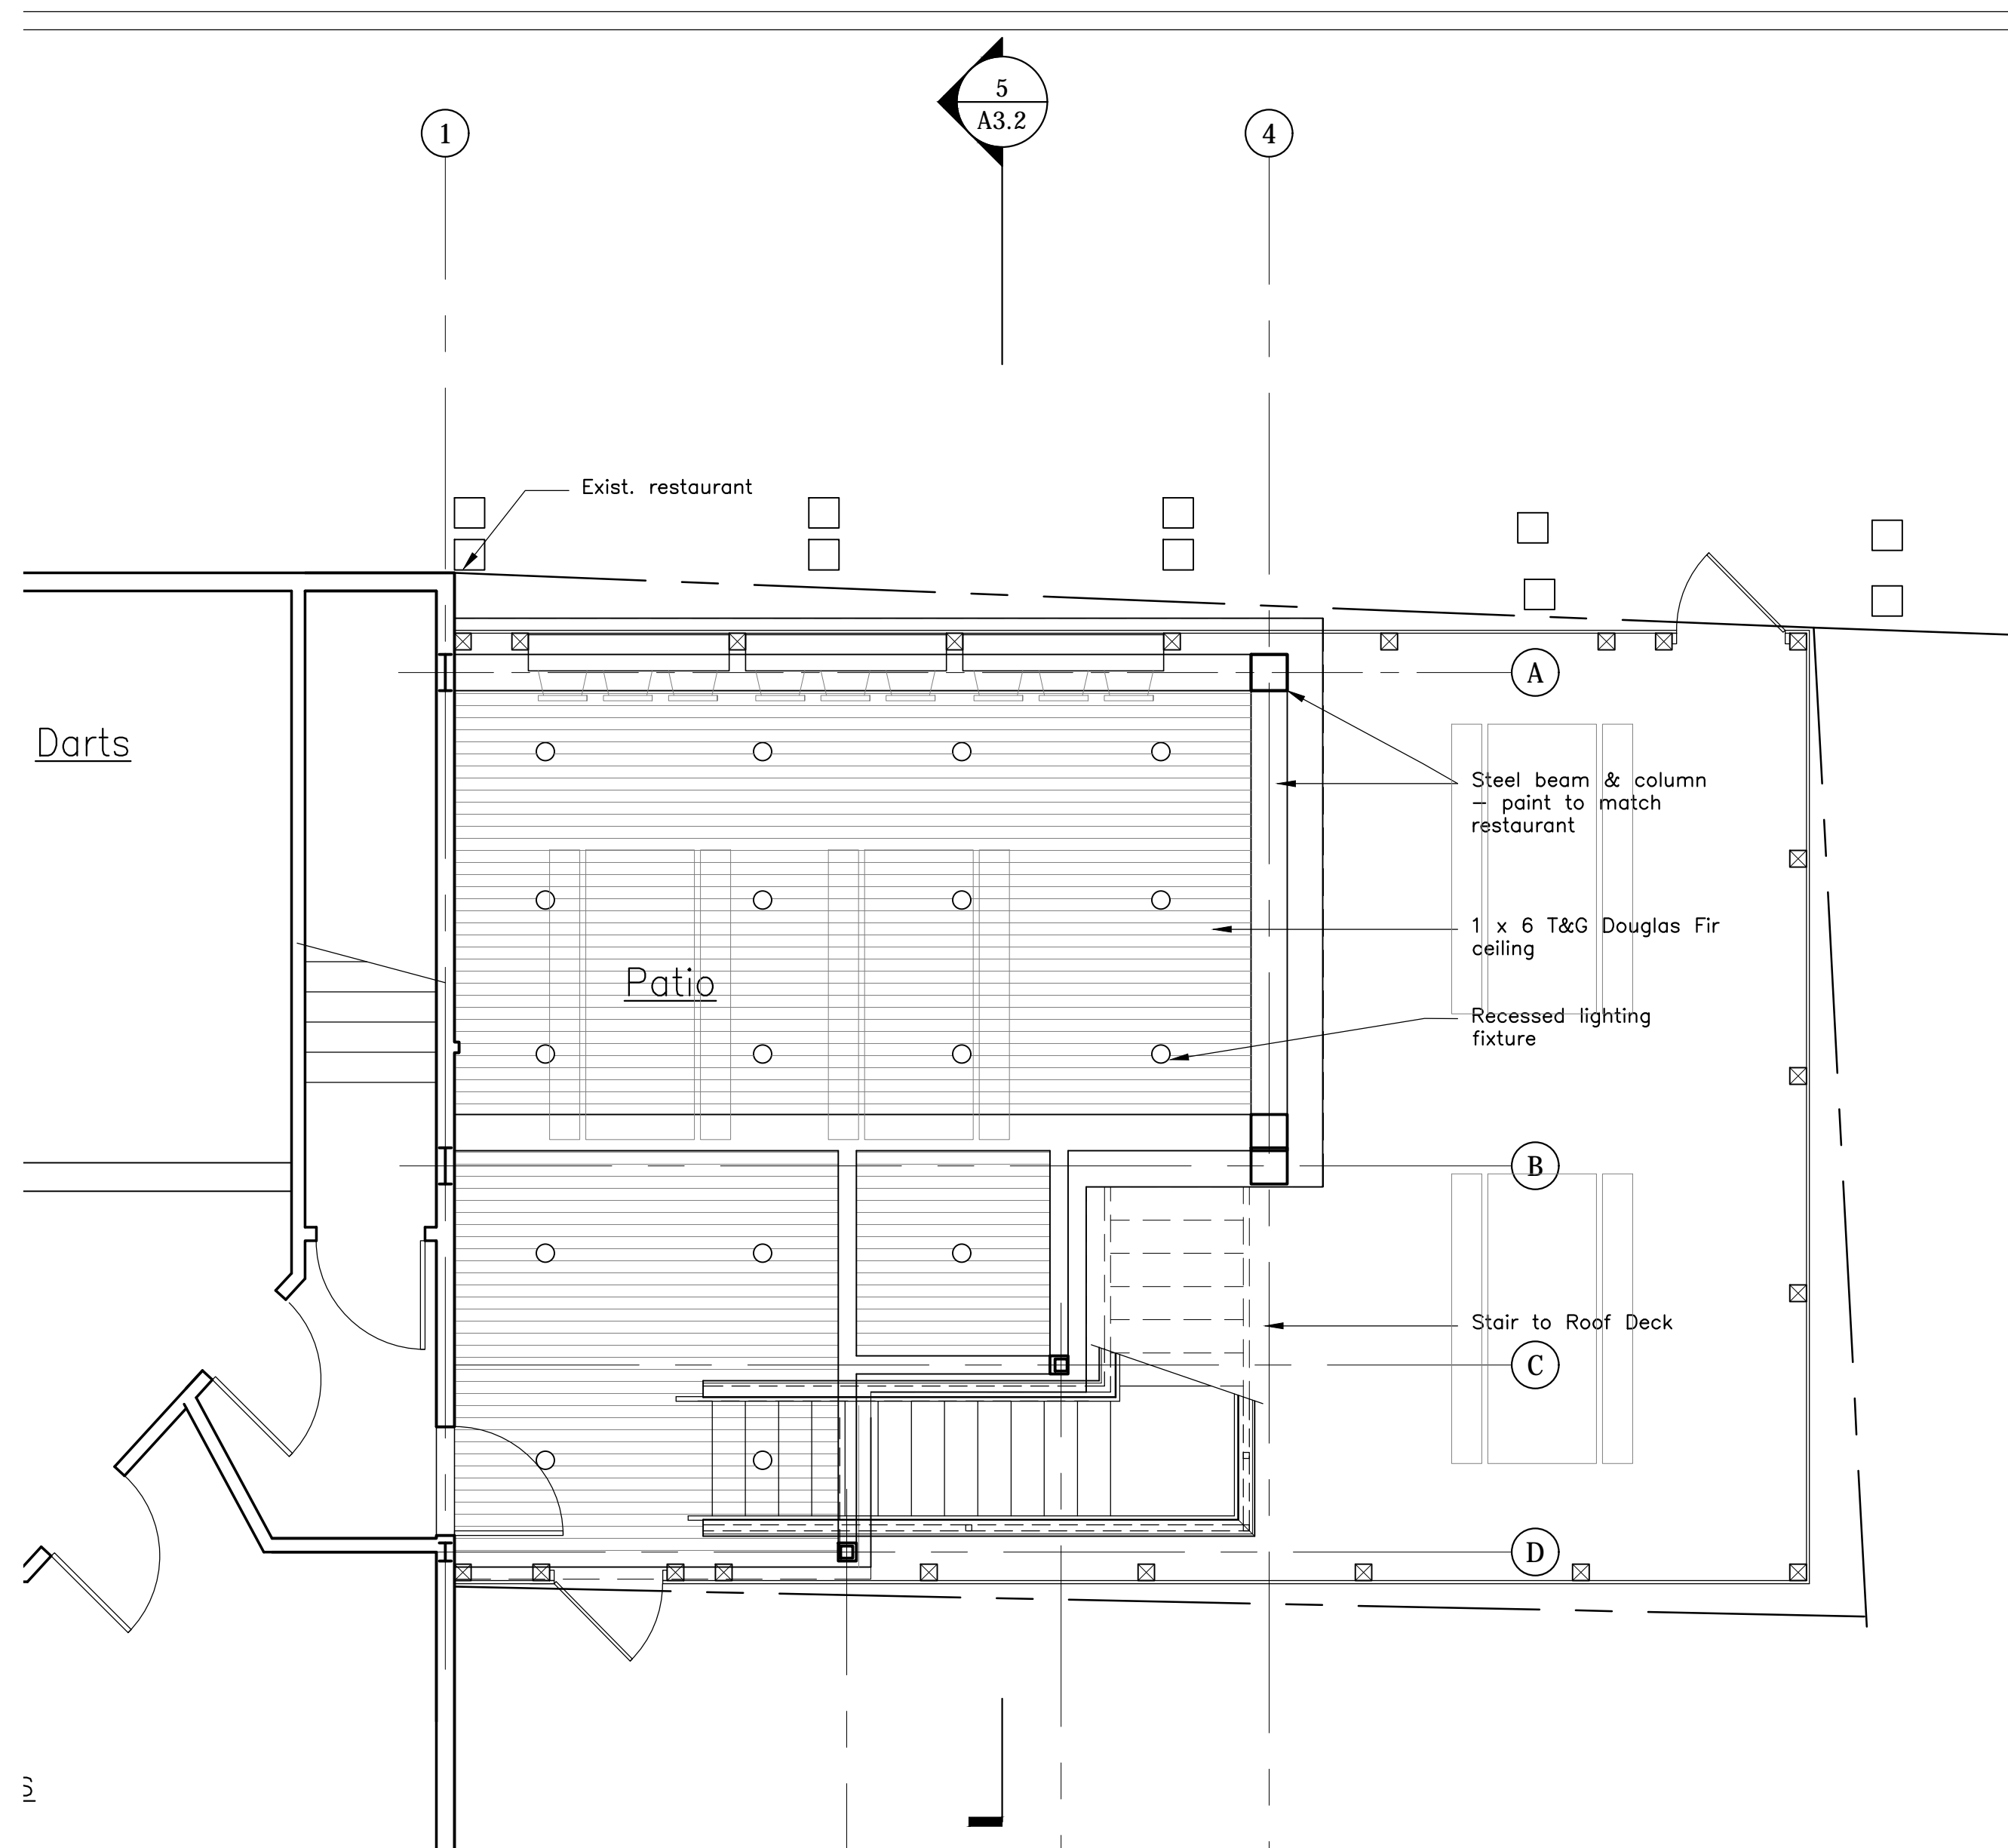

3 First Floor Lighting Plan
Scale: 1/4" = 1'-0"

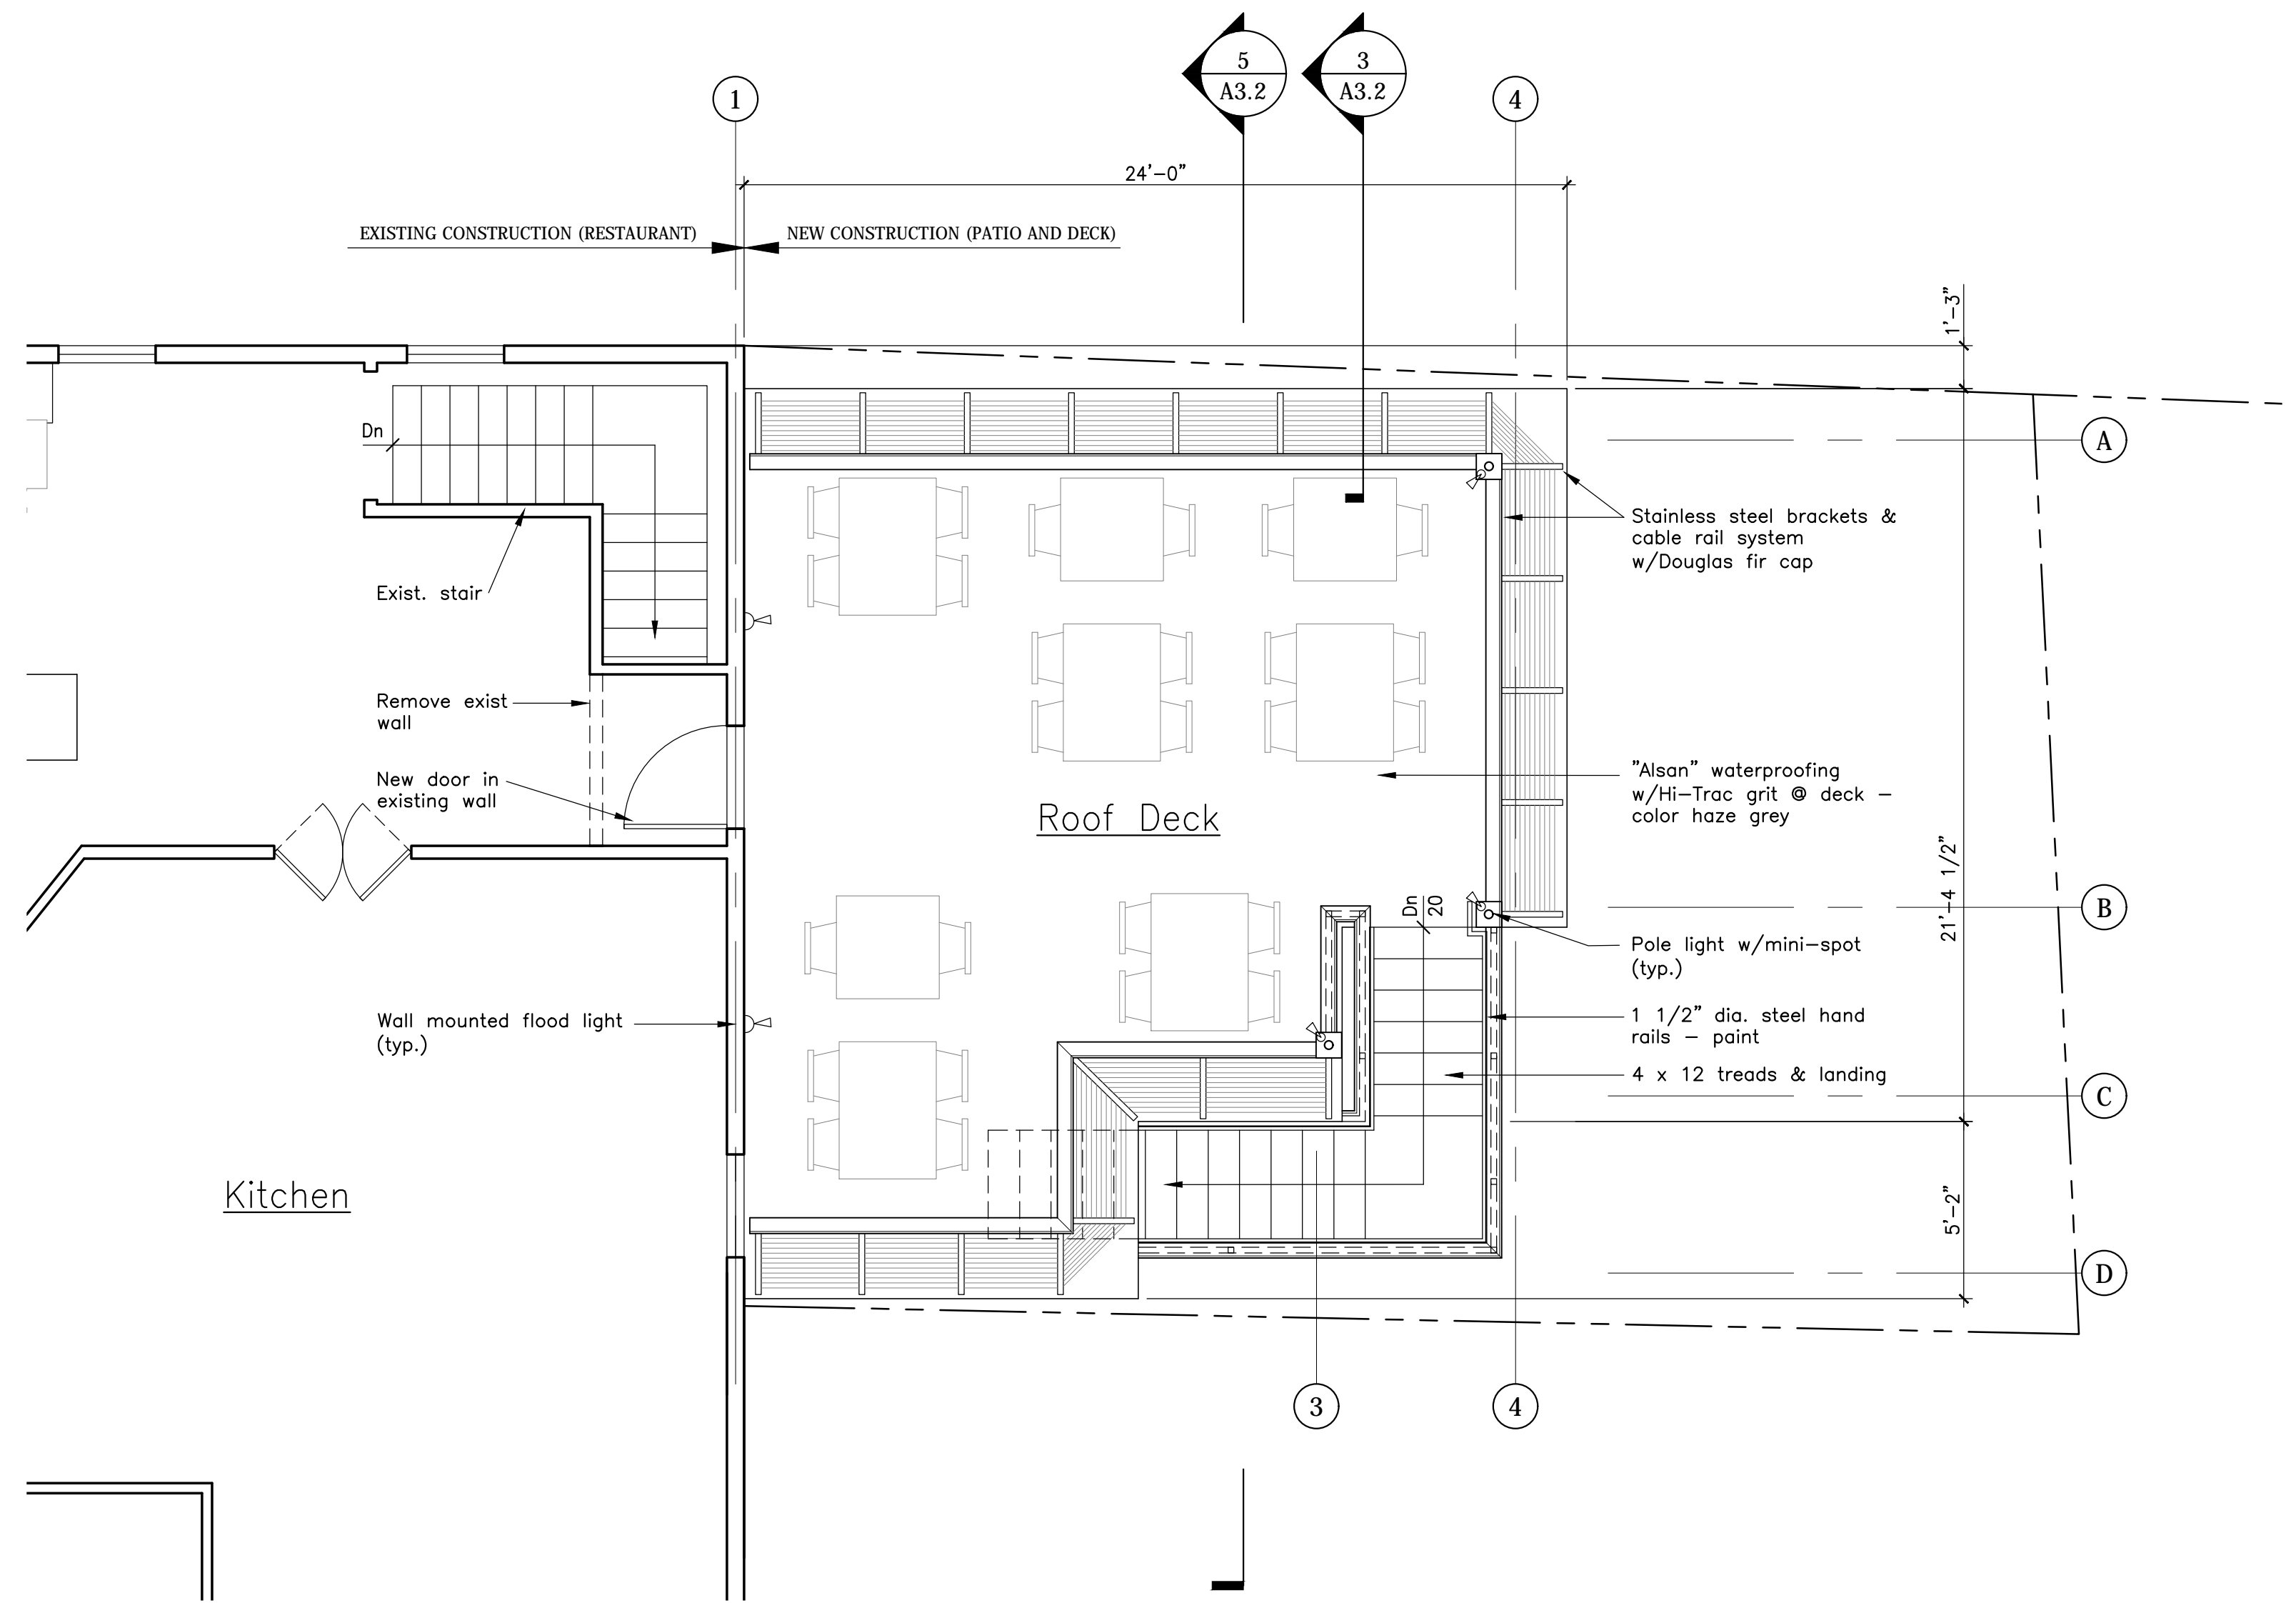

2 Proposed Second Floor Plan
Scale: 1/4" = 1'-0"