


Amigos Mexican Restaurant & Bar
Roof Deck & Patio

7 Dana Street
Portland, Maine 04101

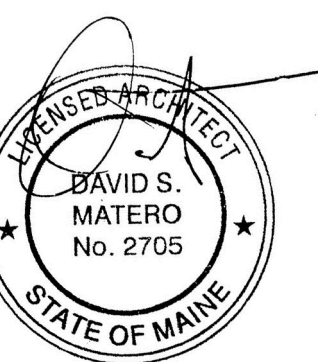


Job Number: 15.000
Date: 07.06.16
Scale: 1/4" = 1'-0"
Drawing Title:

Proposed Deck Plan and Lighting Plan


A1.2

Issued for
Permit

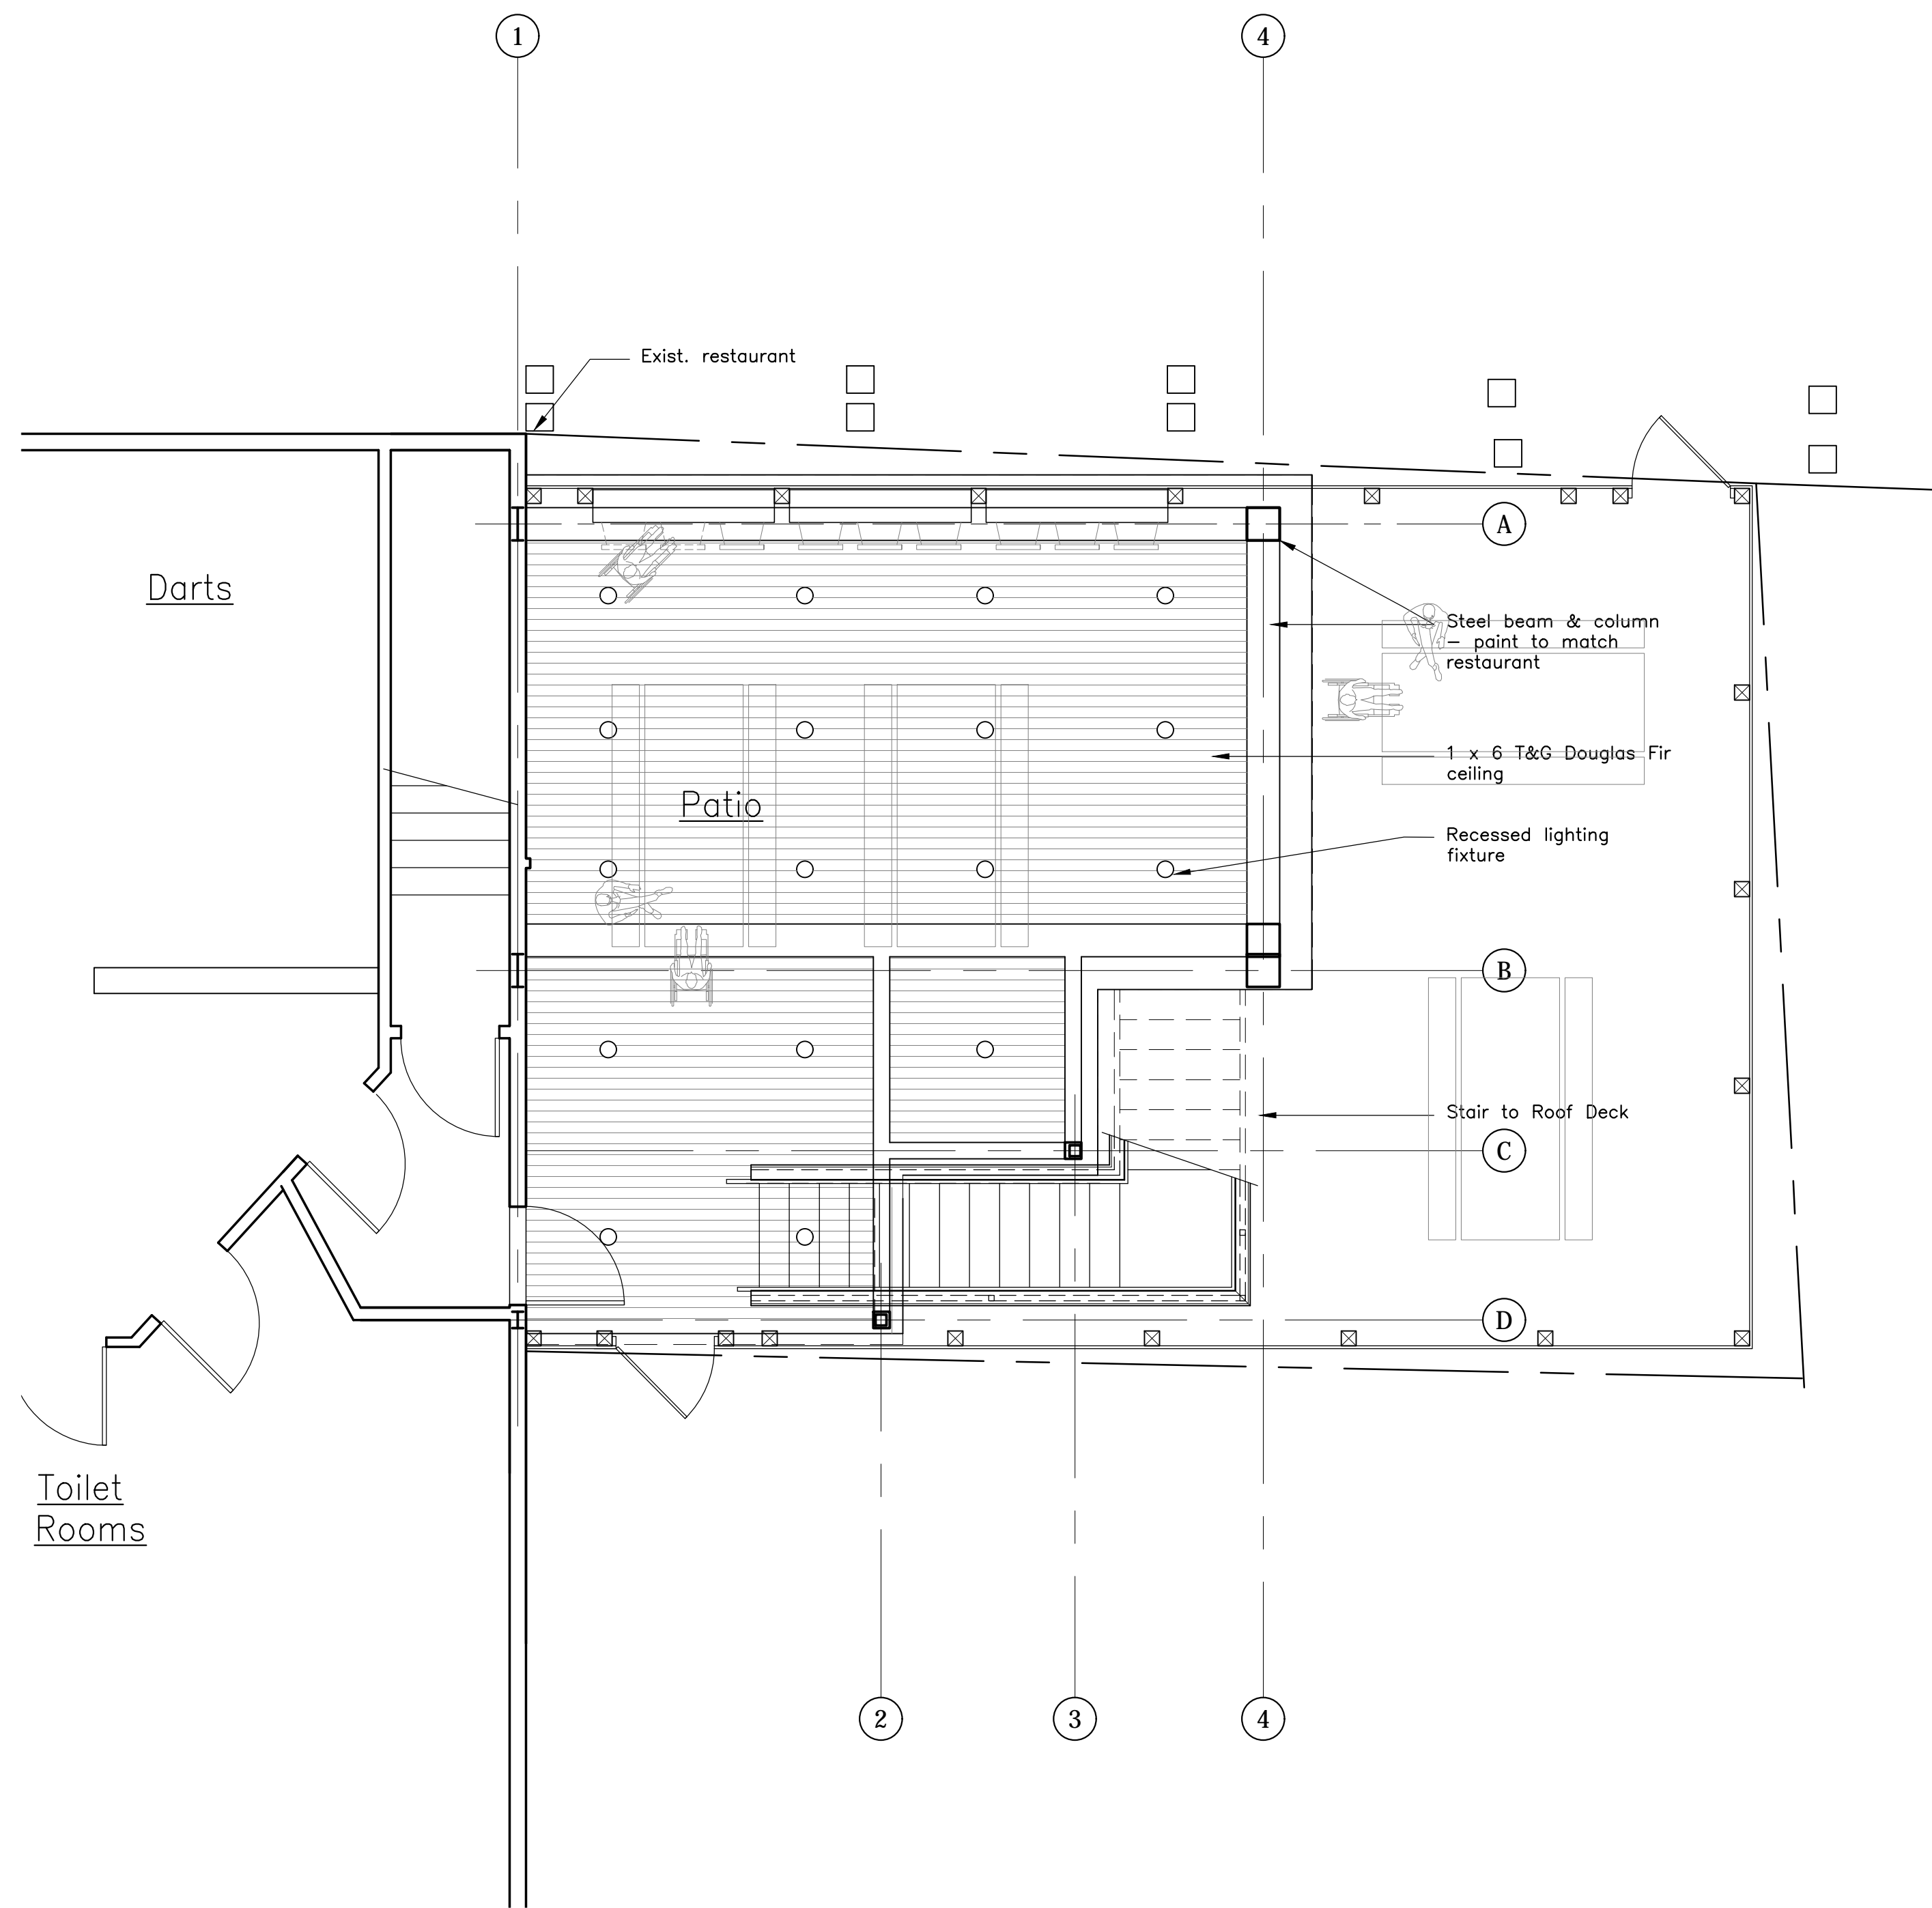

3 First Floor Lighting Plan

Scale: 1/4" = 1'-0"

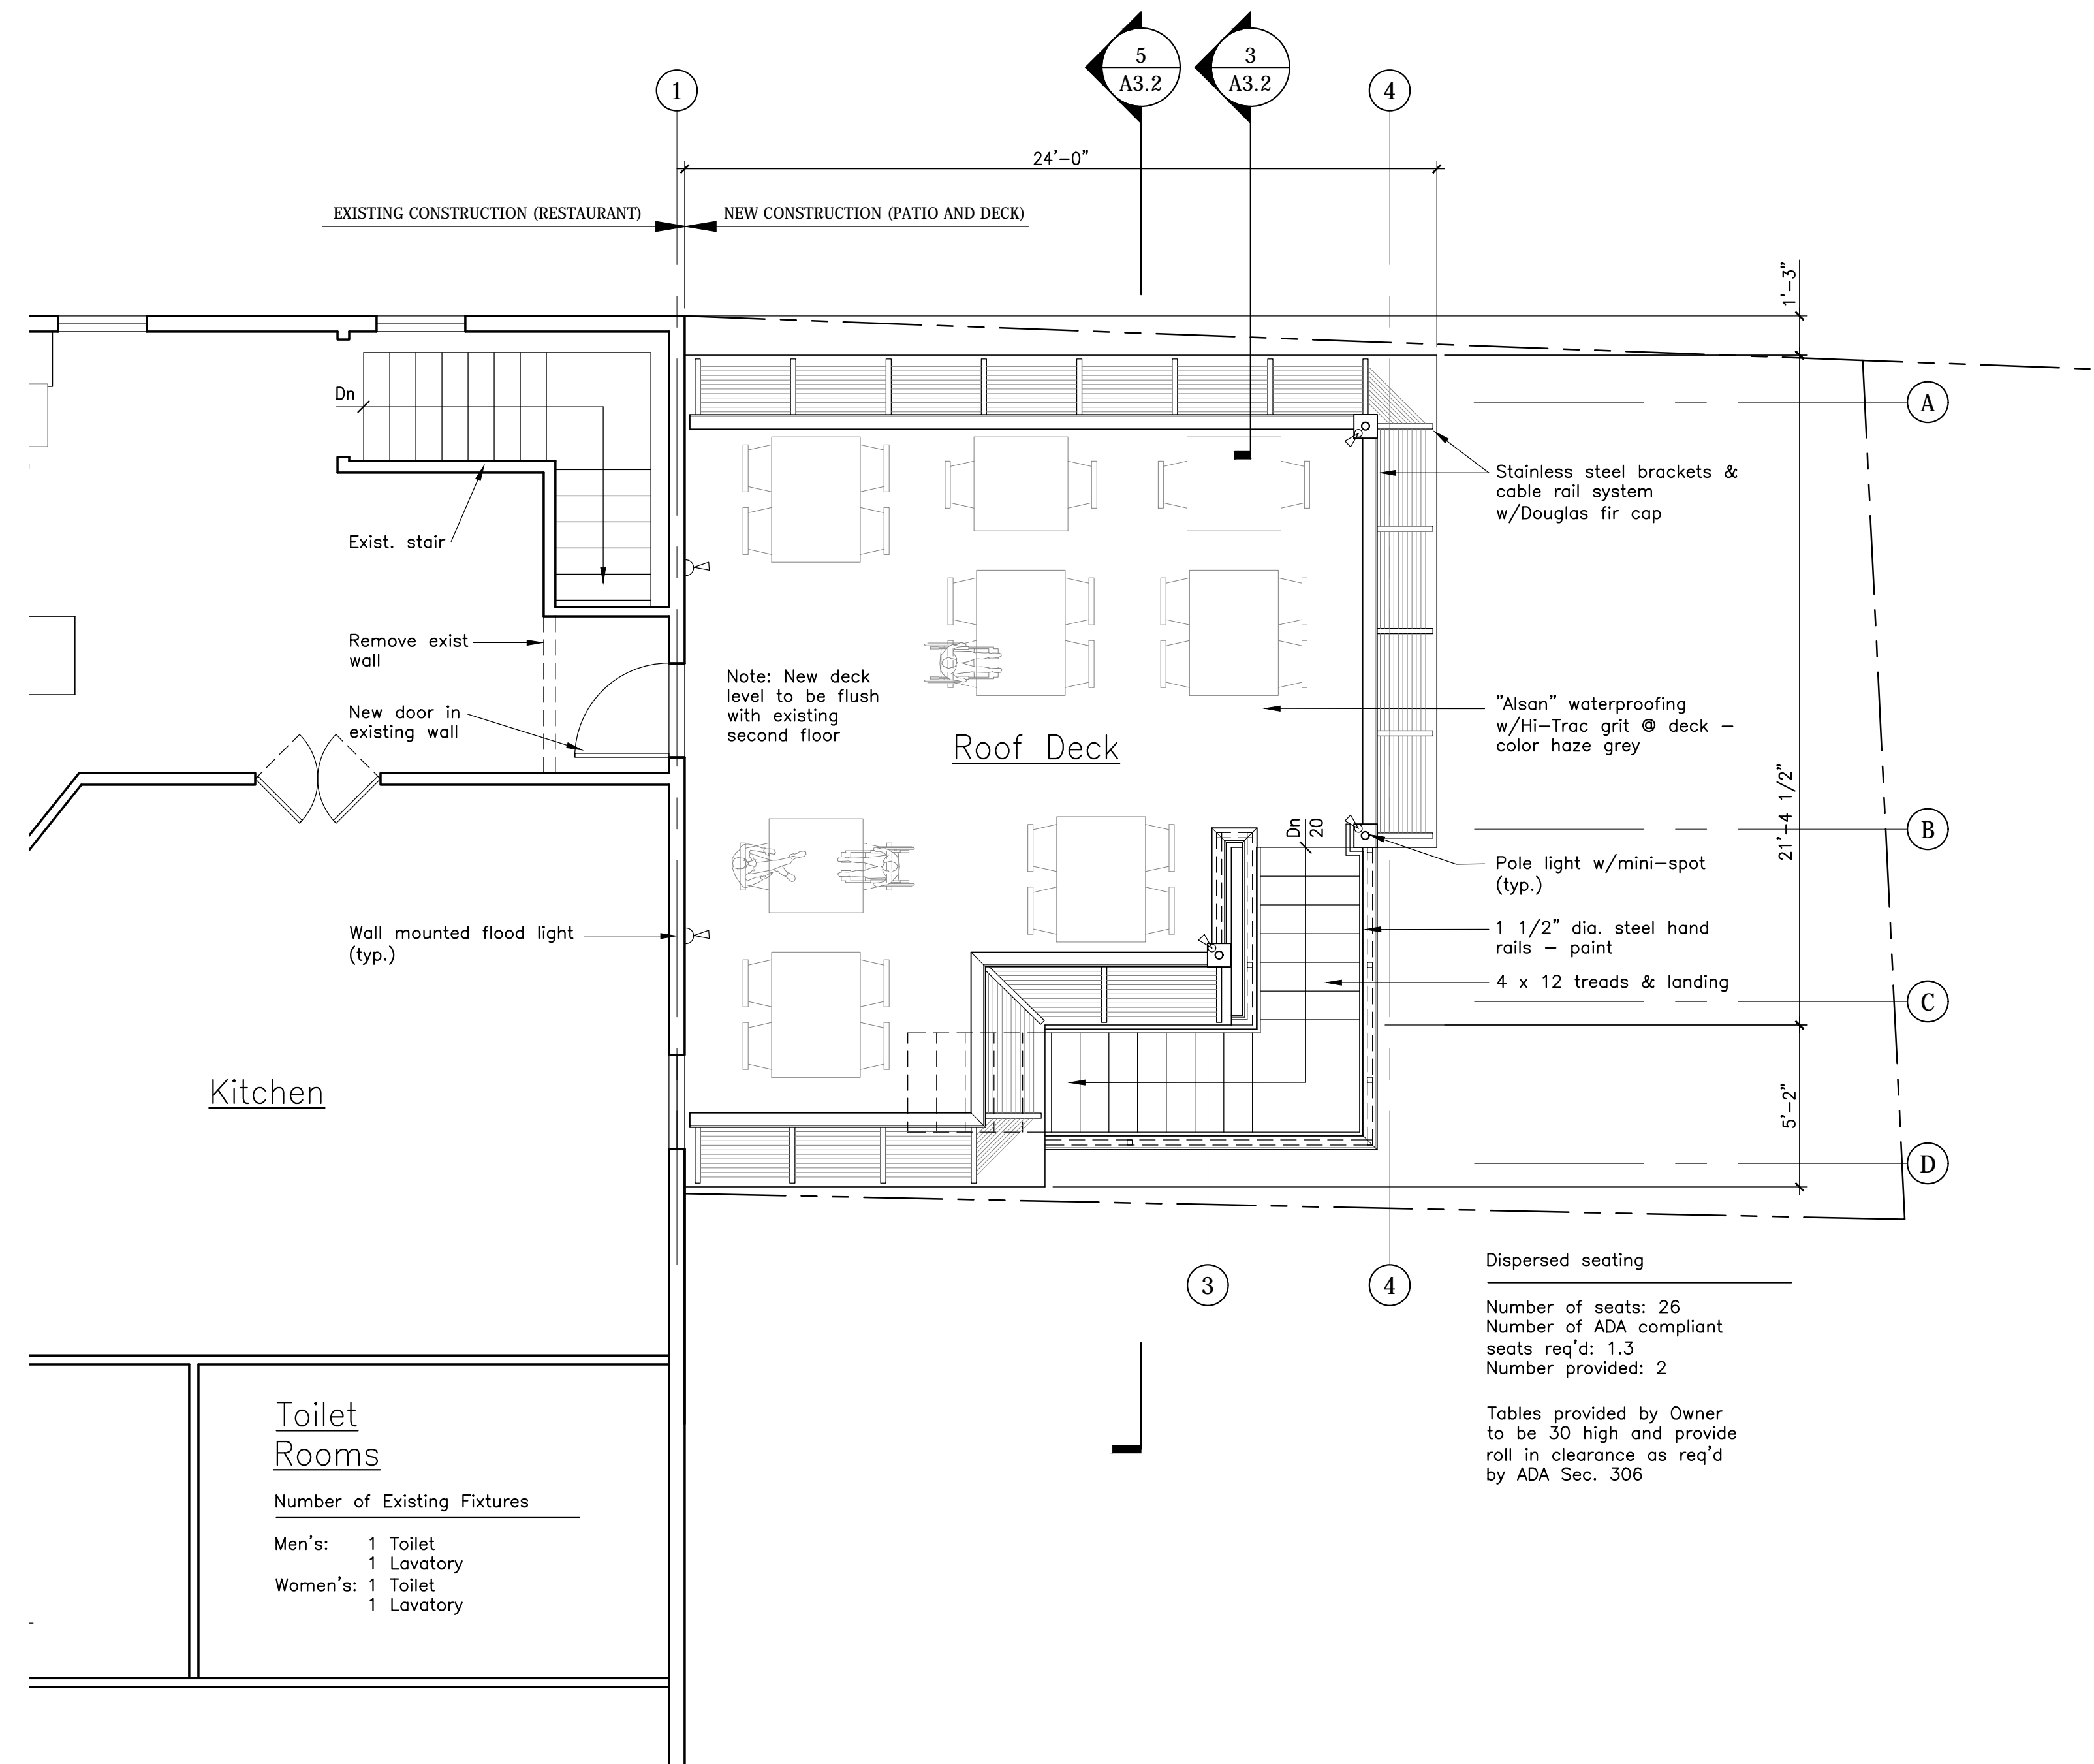

2 Proposed Second Floor Plan

Scale: 1/4" = 1'-0"