

REVISION	0	ISSUED FOR REVIEW & APPROVAL	3/5/2014
DESCRIPTION			
DATE			

RESERVED FOR CITY STAMP

REVISION	0	ISSUED FOR REVIEW & APPROVAL	3/5/2014
DESCRIPTION			
DATE			


CUNNINGHAM
Security Systems
10 Princes Point Road, Yarmouth, Maine 04096
Office: 207.846.3350 • Fax: 207.846.6080

ELEVATION BURGER
205 COMMERCIAL STREET
PORTLAND, MAINE 04101
FIRST FLOOR FIRE ALARM PLAN

DRAWN	JPB	UNICAD JOB #14106
CHECKED	WAYNE B. HAWES	NCET # 90496
DATE	3/4/2014	
REVISION	0	
SCALE	1/8"=1'-0"	

FA-2

UNICAD Inc.
Fire Alarm Design & Drafting Services
www.unicad.net
578 W. 40th St.
Portland, ME 04102
Office: 801.865.0410

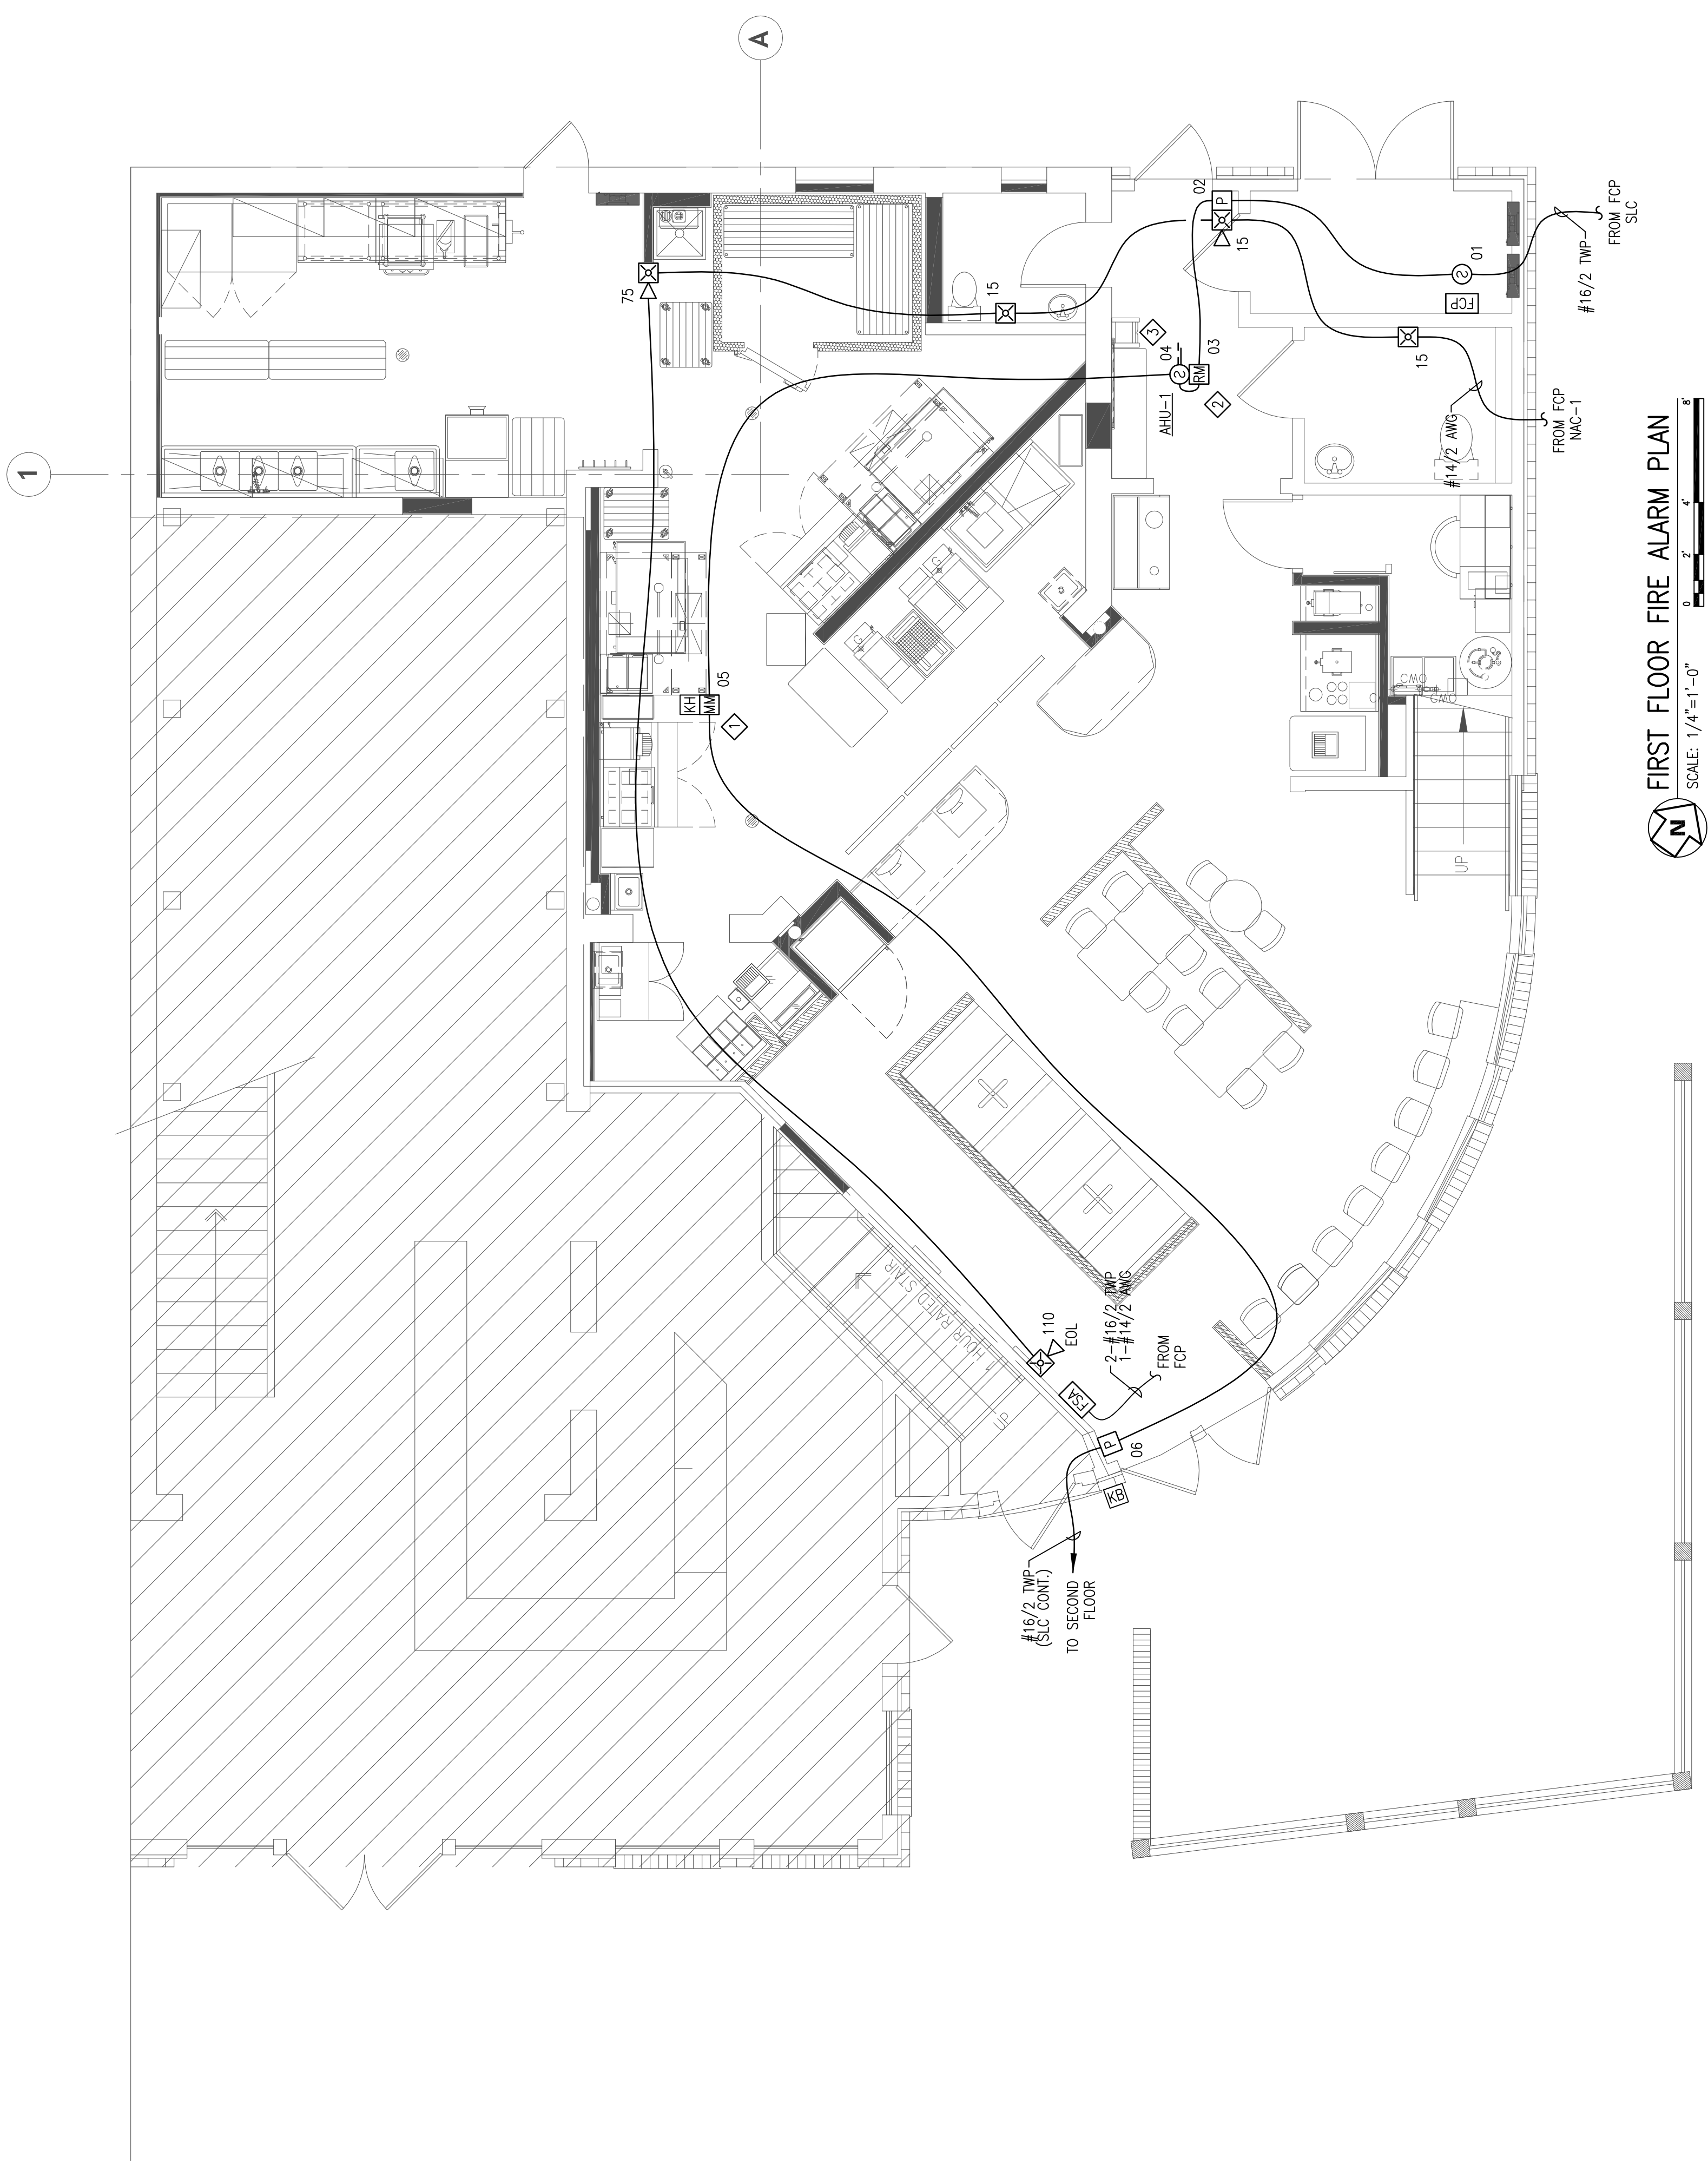

SHEET NOTES:

- ◆ ADDRESSABLE MONITOR MODULE PROVIDED TO MONITOR THE KITCHEN HOOD FIRE SUPPRESSION SYSTEM. INSTALLING CONTRACTOR SHALL FIELD VERIFY EXACT MOUNTING, CIRCUITING AND PROGRAMMING REQUIREMENTS. FIELD VERIFY EXACT QUANTITY AND LOCATION(S).
- ◆ ADDRESSABLE RELAY MODULE(S) PROVIDED FOR FAN SHUT DOWN. TIE TO INDICATED UNIT FAN CONTROLLER. INSTALLING CONTRACTOR SHALL FIELD VERIFY EXACT MOUNTING, CIRCUITING, AND PROGRAMMING REQUIREMENTS. FIELD VERIFY POWER SOURCE. USE MULTI-VOLTAGE CONTROL RELAY(S) IF REQUIRED. FIELD VERIFY EXACT QUANTITY AND LOCATION(S) WITH MECHANICAL DIVISION.
- ◆ DUCT SMOKE DETECTORS PROVIDED FOR THE RETURN AIR PATH AT ALL AIR HANDLING UNITS HAVING A CAPACITY GREATER THAN 2,000 CFM AND FOR THE SUPPLY AIR PATH AT ALL AIR HANDLING UNITS HAVING A CAPACITY GREATER THAN 15,000 CFM. INSTALLING CONTRACTOR SHALL FIELD VERIFY EXACT MOUNTING, CIRCUITING AND PROGRAMMING REQUIREMENTS. PROVIDE FOR SHUT DOWN OF THE ASSOCIATED UNIT FAN(S). FIELD VERIFY UNIT POWER SOURCE. USE MULTI-VOLTAGE CONTROL RELAY(S) IF REQUIRED. FIELD VERIFY EXACT QUANTITY AND LOCATION(S) WITH MECHANICAL DIVISION. PROVIDE REMOTE TEST SWITCH IN A LOCATION ACCEPTABLE TO THE LOCAL AHU WHEN IN-DUCT SMOKE DETECTOR INDICATOR IS NOT VISIBLE TO RESPONDING PERSONNEL.