


Luminaire Schedule (note fixture catalogue numbers are not complete)						
Type	Symbol	Qty	Lum. Lumens LLF	Lum. Watts	Description	
G	⊙	2	3391	0.900	41.7	ARS-18L3K-070-5M-CS
D	⊙	1	998	0.900	13.68	FLC4D-RO-1000L-120-L11-T
W1	⊏	2	1471	0.900	13.9	TRP1-12L15-3K7-4

Calculation Summary					
Label	Avg	Max	Min	Avg/Min	Max/Min
SITE	0.50	4.4	0.0	N.A.	N.A.

- NOTES:
- 1) EXACT MOUNTING DETAILS TO BE DETERMINED AT JOBSITE BY OTHERS.
 - 2) CALCULATIONS DO NOT SHOW THE EFFECT OF SHADOWING CAUSED BY BUILDINGS AND OBJECTS WITHIN THE CALCULATED SPACE OR IN THE SITE AREA.
 - 3) READINGS SHOWN ARE INITIAL HORIZONTAL FOOTCANDLES ON A FLAT SITE WITHOUT REFLECTIONS OR OBSTRUCTIONS UNLESS OTHERWISE INDICATED.
 - 4) THIS CALCULATION IS BASED ON LIMITED INFORMATION SUPPLIED BY OTHERS TO SWANEY LIGHTING ASSOCIATES AND STANDARD ASSUMPTIONS OF THE SPACE AND/OR SITE.
 - 5) CONFORMANCE TO CODES AND OTHER LOCAL REQUIREMENTS AS DETERMINED BY THE AHJ ARE THE RESPONSIBILITY OF THE OWNER AND/OR THE OWNER'S REPRESENTATIVE.
 - 6) THIS LAYOUT DRAWING MUST BE COORDINATED WITH THE SITE LOCATION FOR CORRECT FIXTURE ORIENTATION.
 - 7) DOCUMENTS PRINTED OR PLOTTED FROM ELECTRONIC FILES MAY APPEAR AT OTHER THAN THE DESIRED OR ASSUMED GRAPHIC SCALES. IT IS THE RESPONSIBILITY OF THE RECIPIENT TO VERIFY THAT THE PRINTED OR PLOTTED-TO-SCALE DRAWING IS PRINTED TO SCALE.

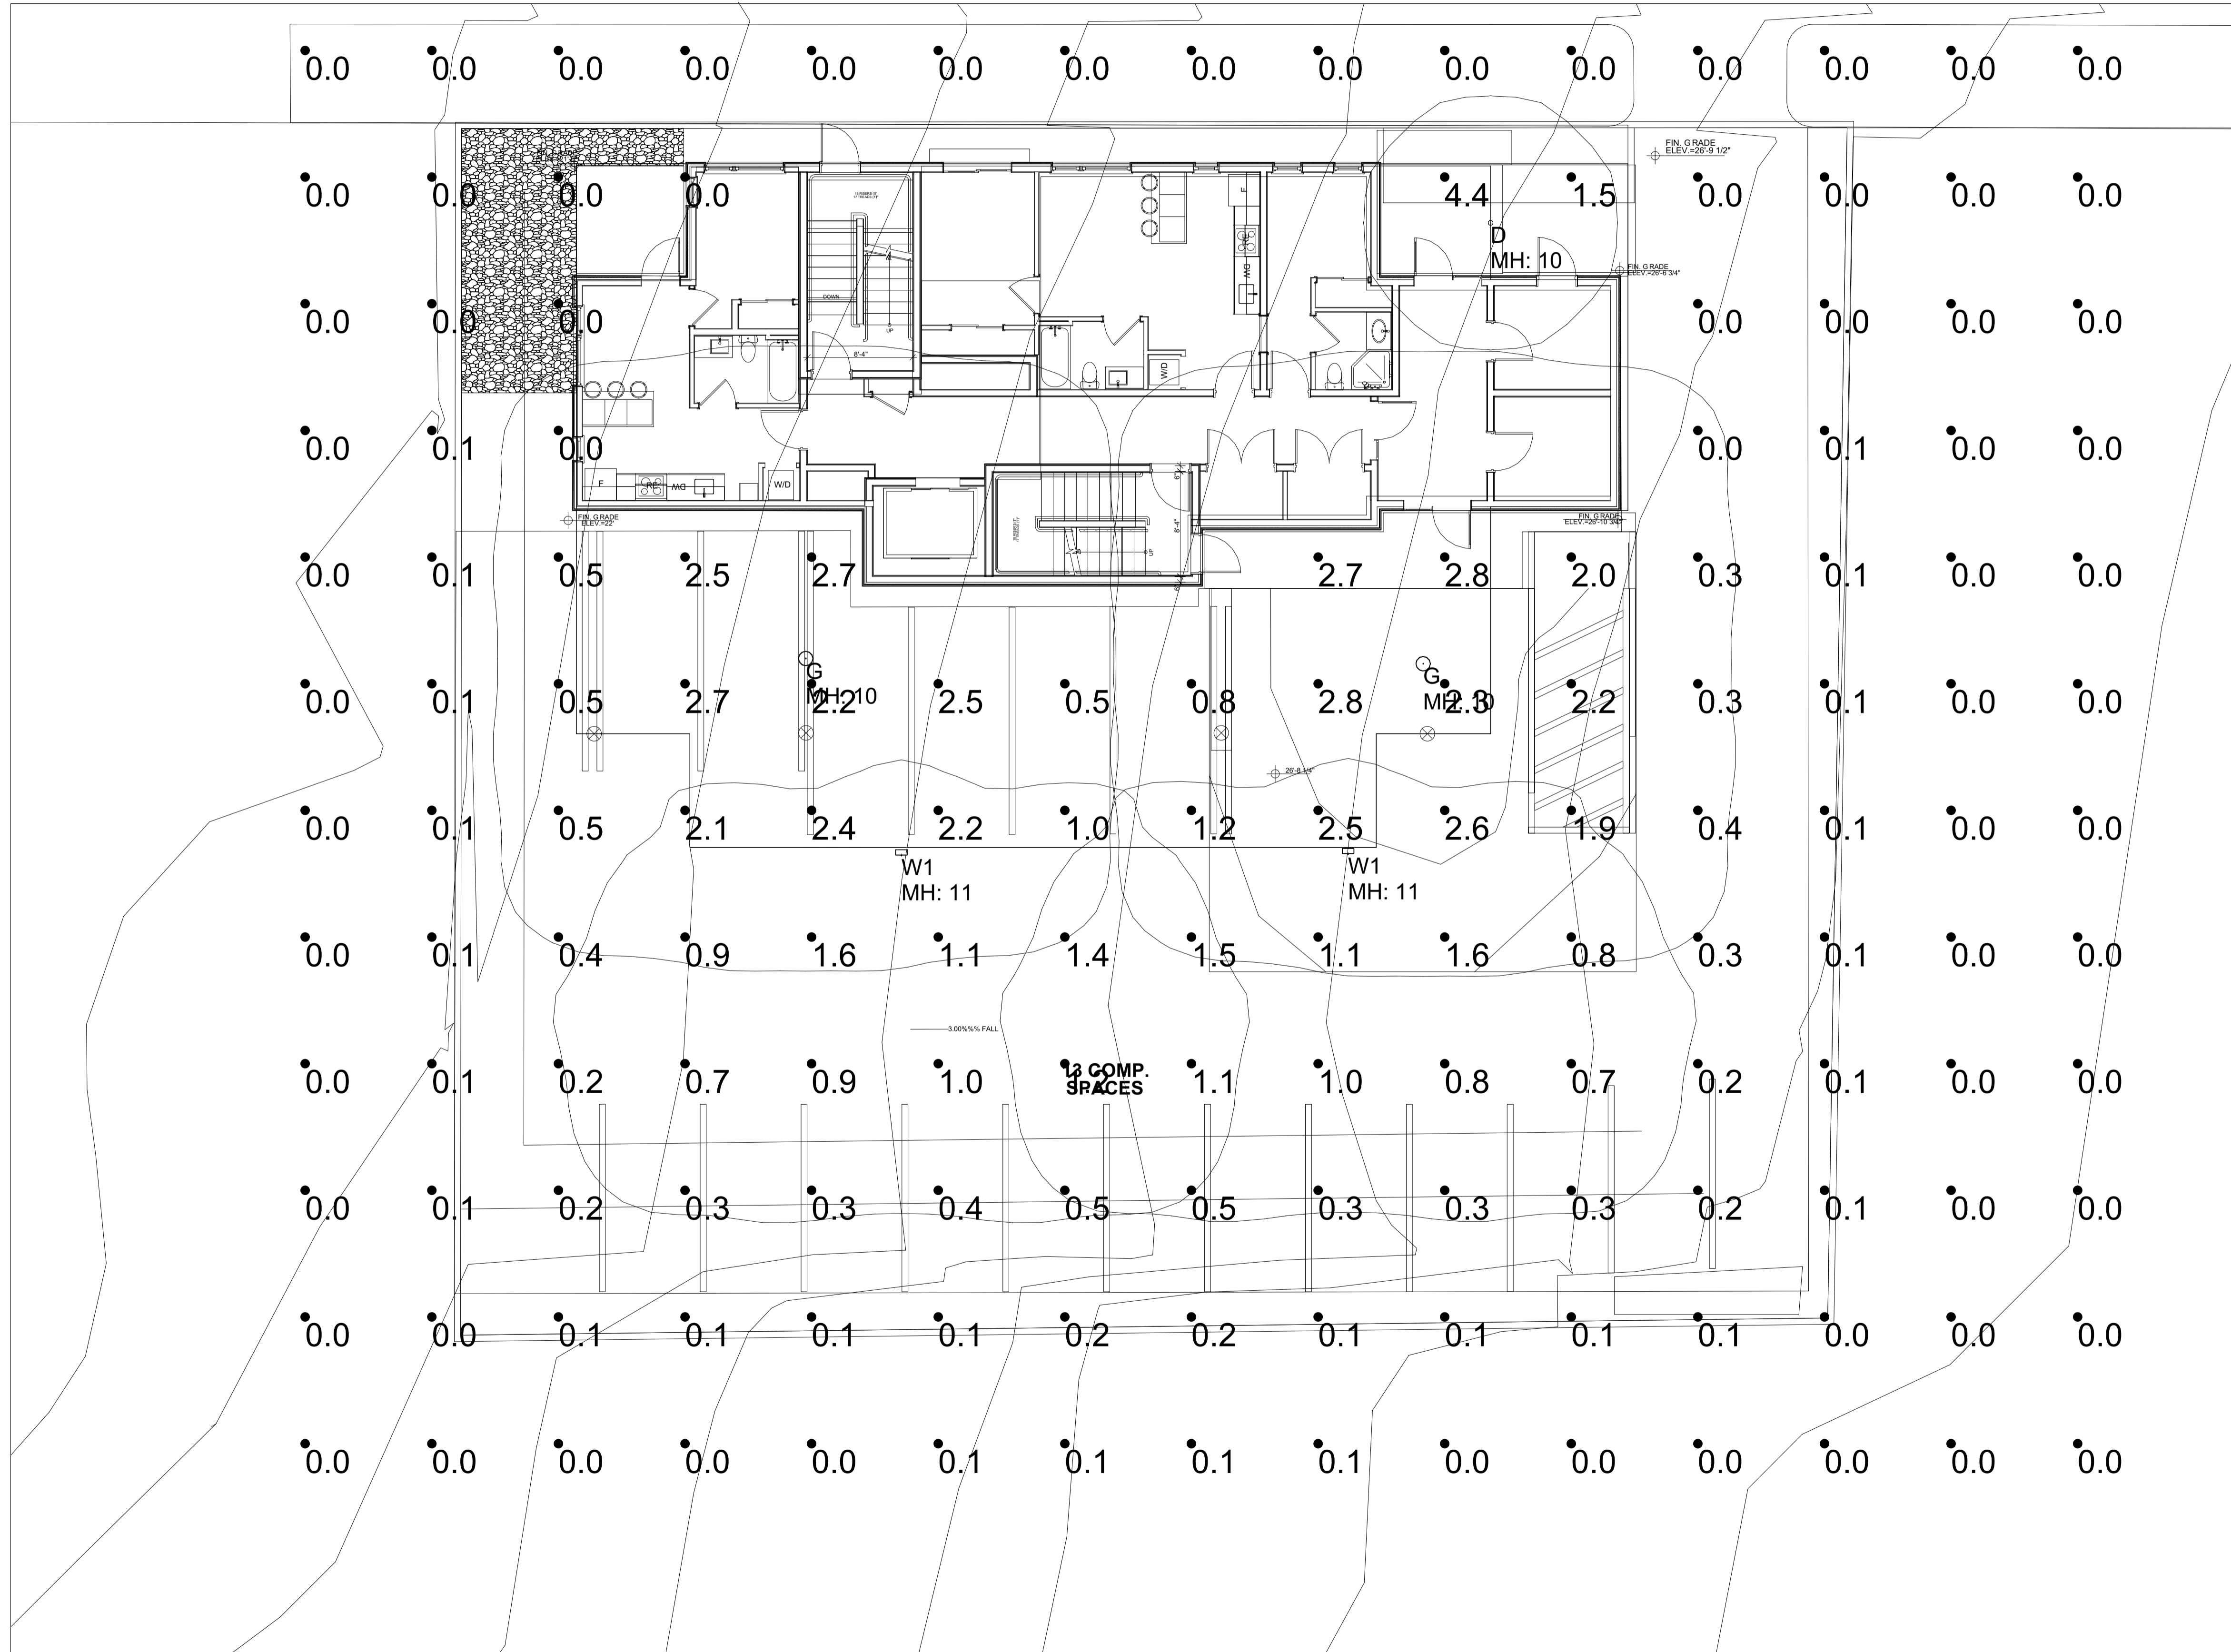

PLAN VIEW



HUBBELL GARAGE LED



HUBBELL WALL PACK

TITLE: PARRIS ST PORTLAND, ME SITE LIGHTING LAYOUT
 GENERATED FOR: KAPLAN THOMPSON ARCHITECTS
 SCALE: NOT TO SCALE
 Date: 3/8/2018
 Page 1 of 1
 GENERATED BY SWANEY LIGHTING, SCARBOROUGH ME - 207-883-7100 - swaneylighting.com

NOTE: THIS DRAWING IS THE EXCLUSIVE PROPERTY OF SWANEY LIGHTING ASSOCIATES. IT IS NOT TO BE REPRODUCED, COPIED, OR TRANSMITTED IN ANY FORM OR BY ANY MEANS, ELECTRONIC OR MECHANICAL, INCLUDING PHOTOCOPYING, RECORDING, OR BY ANY INFORMATION STORAGE AND RETRIEVAL SYSTEM. THIS DRAWING IS TO BE USED FOR THE PROJECT AND SITE SPECIFICALLY IDENTIFIED. ANY OTHER USE OF THIS DRAWING WITHOUT THE WRITTEN PERMISSION OF SWANEY LIGHTING ASSOCIATES IS PROHIBITED. SWANEY LIGHTING ASSOCIATES ASSUMES NO LIABILITY FOR ANY ERRORS OR OMISSIONS IN THIS DRAWING. THE USER OF THIS DRAWING SHALL BE RESPONSIBLE FOR VERIFYING ALL DIMENSIONS AND CONDITIONS AT THE JOB SITE. SWANEY LIGHTING ASSOCIATES IS NOT RESPONSIBLE FOR ANY DAMAGE TO PROPERTY OR PERSONS ARISING FROM THE USE OF THIS DRAWING.



DATE OF APPROVAL: _____
 PLANNER: _____
 PROJECT NO.: 2017-257